


Revisions  
 11/29/2012-UNDERSLAB PIPING FOR  
 CONSTRUCTION - FOR PERMIT  
 12/14/2012 - FOR PERMIT  
 1/14/2013 - PLUMBING REVISIONS.  
 2/6/2013 - 100% FOR REVIEW  
 and Comment

Bay House

Portland, ME

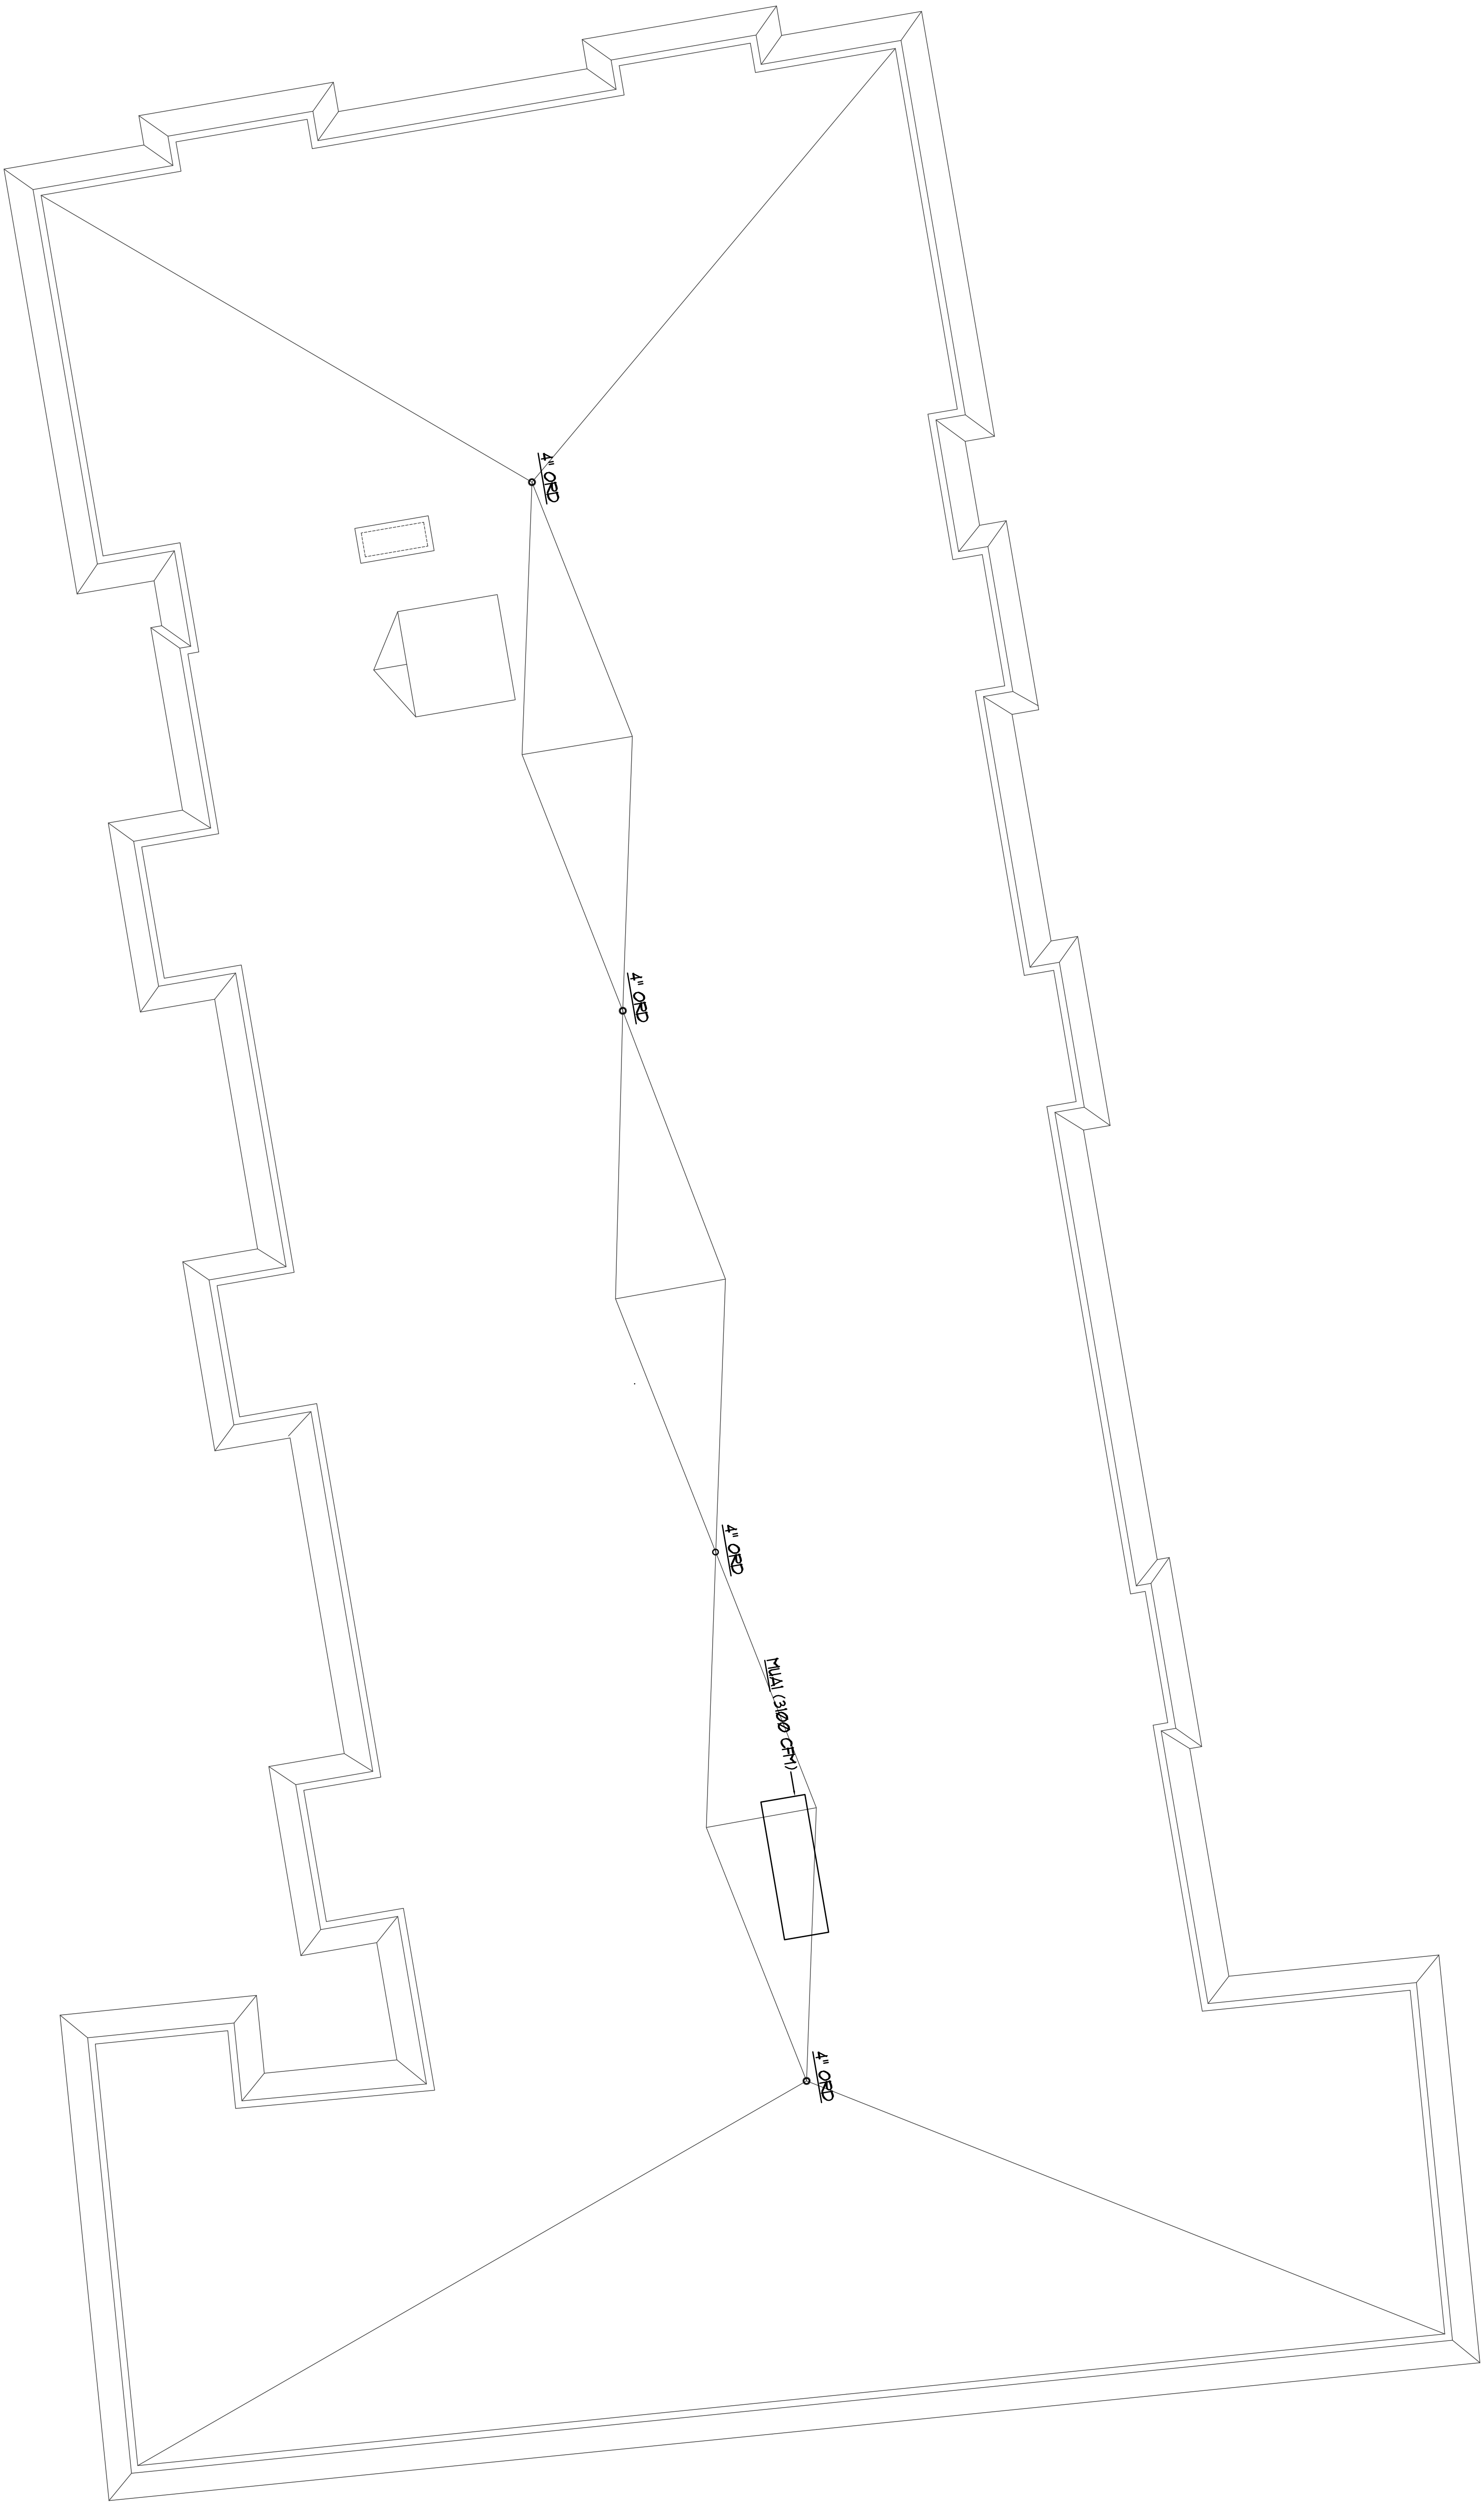

ROOF PLAN  
 BUILDING 2

**Atlantic Comfort  
 Systems, Inc.**  
 Mechanical Contractor • 807-894-4390  
 882 Hill Street, Portland, ME 04105  
 www.atlanticcomfort.com

**BENNETT  
 ENGINEERING**  
 MECHANICAL • ELECTRICAL  
 (207) 865-9475

Job No.: 3346  
 Date: 12/14/12  
 Scale: 1/8" = 1'-0" or A.N.  
 Drawn by: SF Deel  
 Checked by: SF Deel

Drawing Title:  
 Plumbing Roof Plan  
 Building "2"

**P.12**