

Revisions
 1/29/2012-INDERS LAB PIPING FOR
 CONSTRUCTION
 12/14/2012- FOR PERMIT
 1/14/2013- PLUMBING REVISIONS
 2/6/2013- 100% For Review
 and Comment

Bay House
 Portland, ME




**BENNETT
 ENGINEERING**
 MECHANICAL • ELECTRICAL
 (207) 865-9475

Job No.: 3346
 Date: 12/14/12
 Scale: 1/8" = 1'-0" or A.N.
 Drawn by: SF Deel
 Checked by: SF Deel


Drawing Title:
 Unit Plans

P.13

**Atlantic Comfort
 Systems, Inc.**
 Mechanical Contractor • 507-284-4390
 882 Hill Street, Biddeford, ME 04005
 www.atlanticcomfort.com

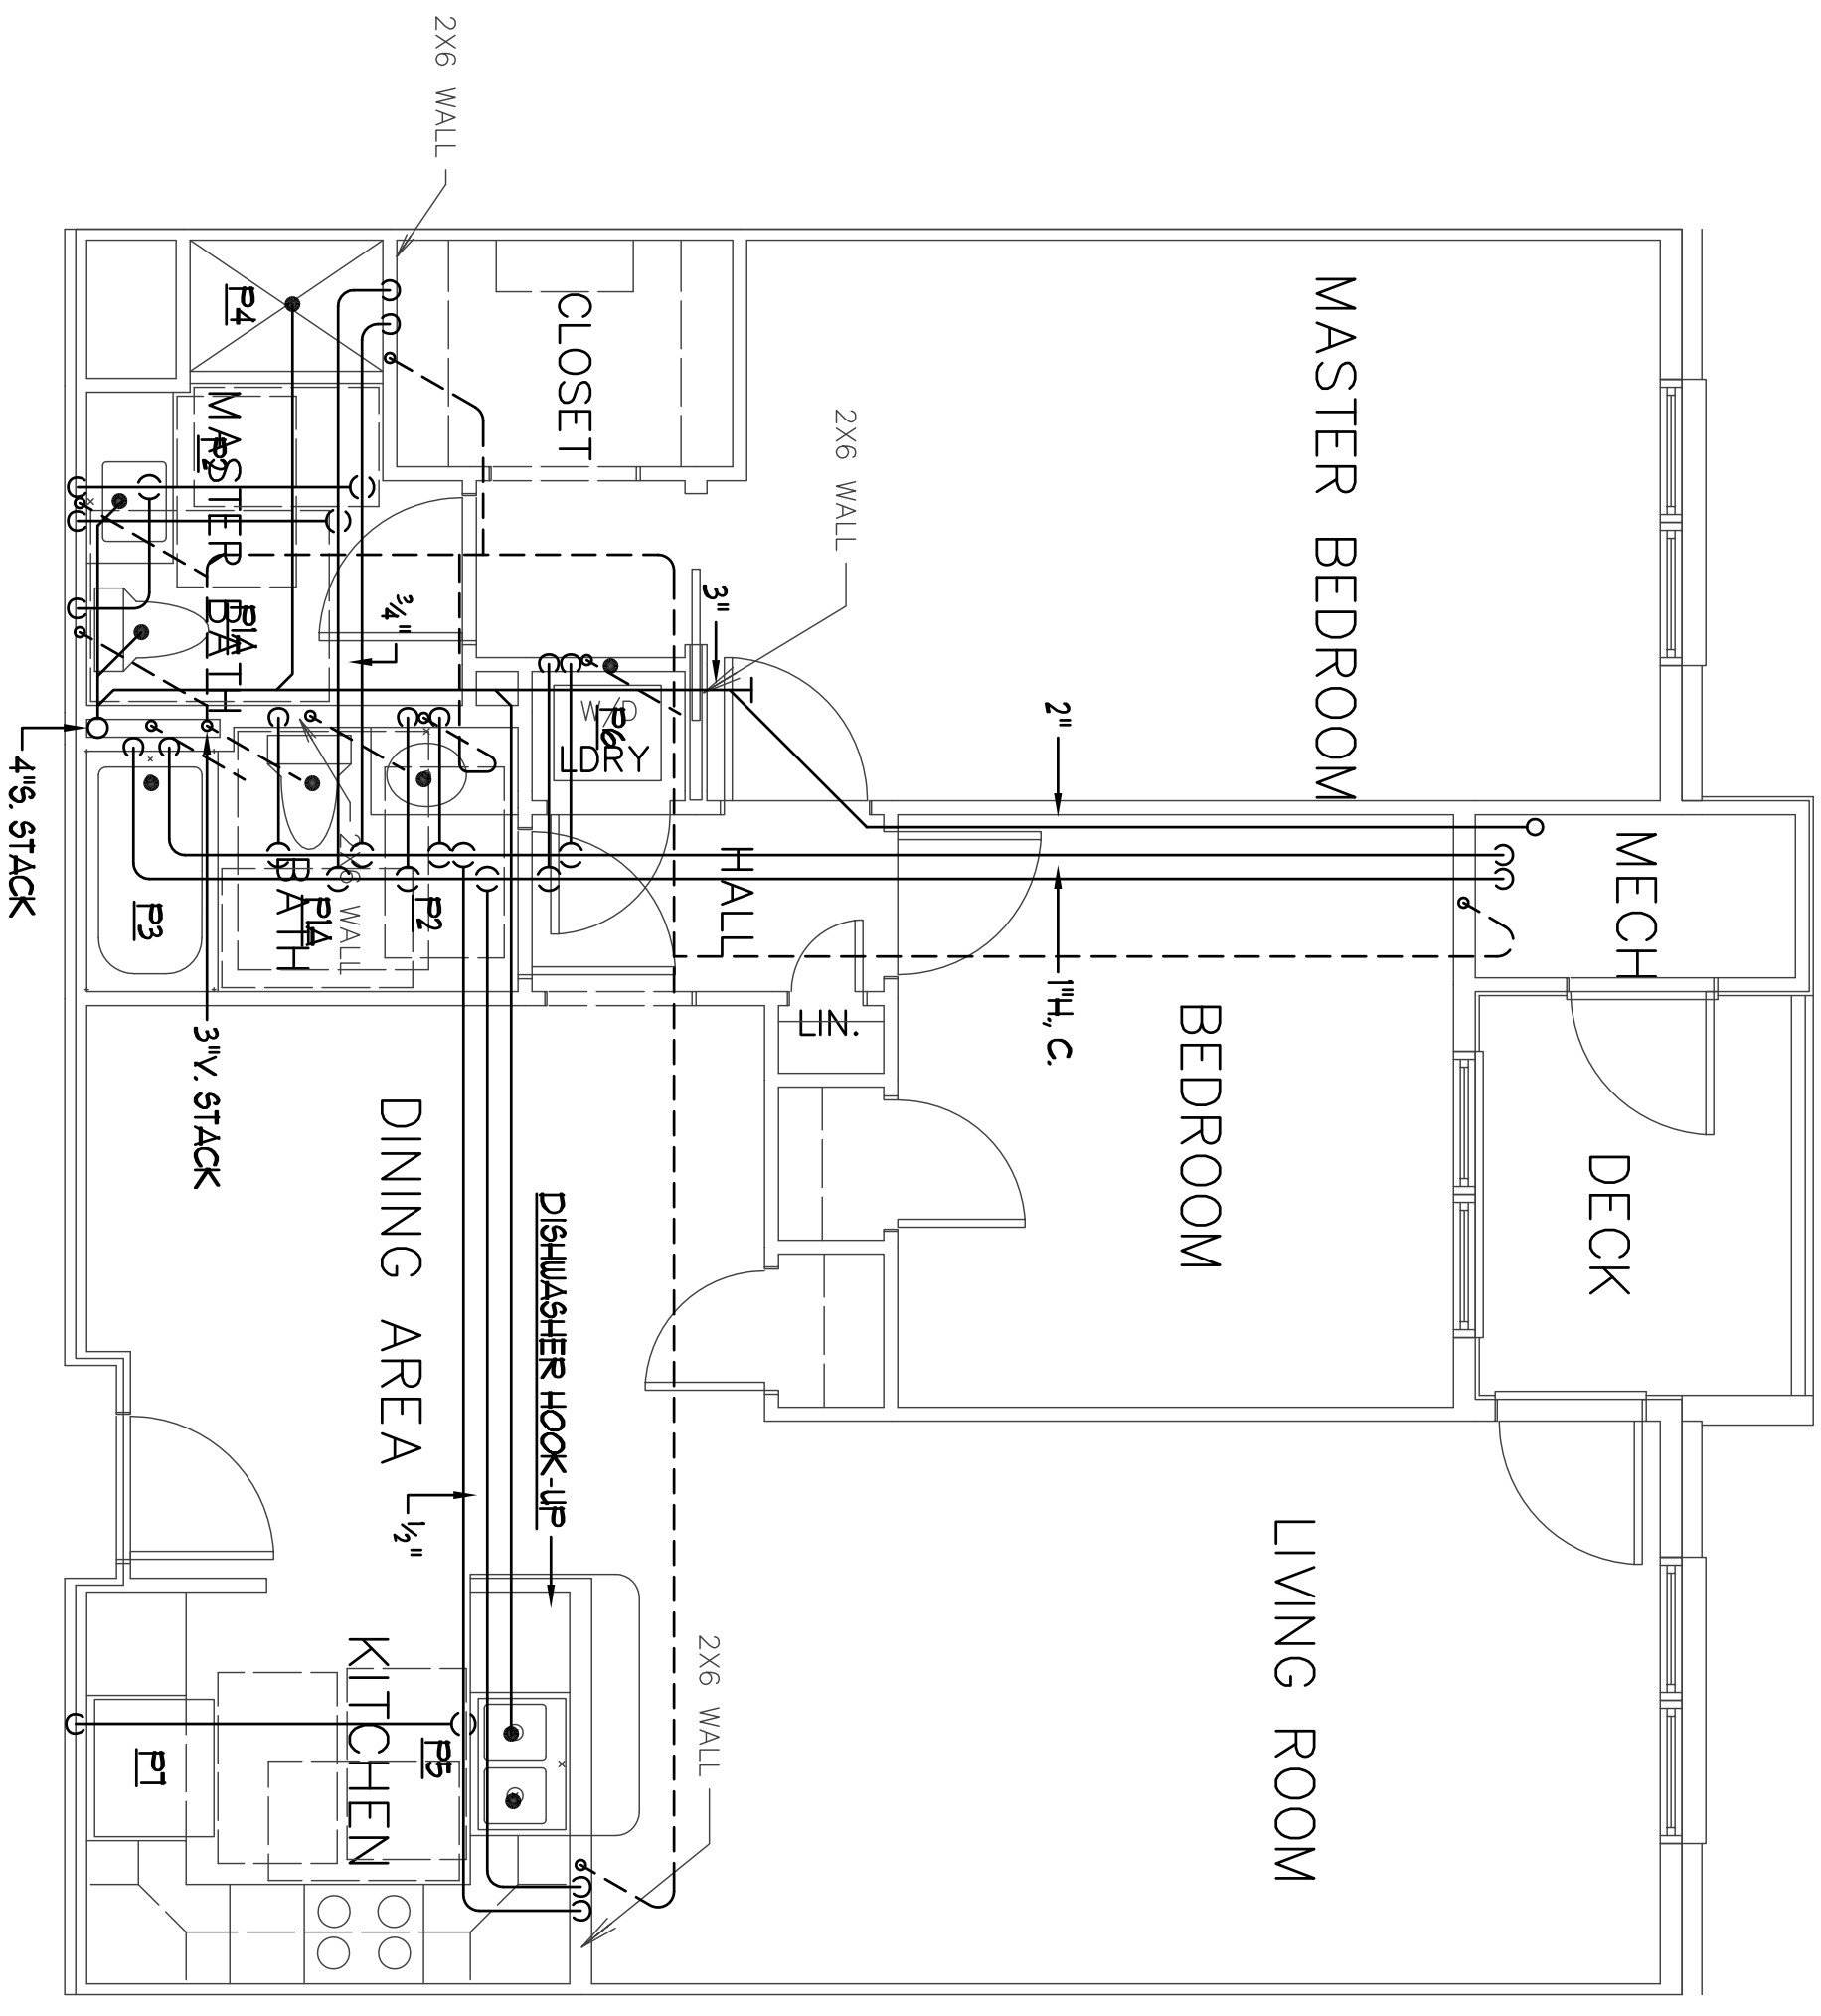

UNIT TYPE A
 SCALE: 1/4" = 1' 0"

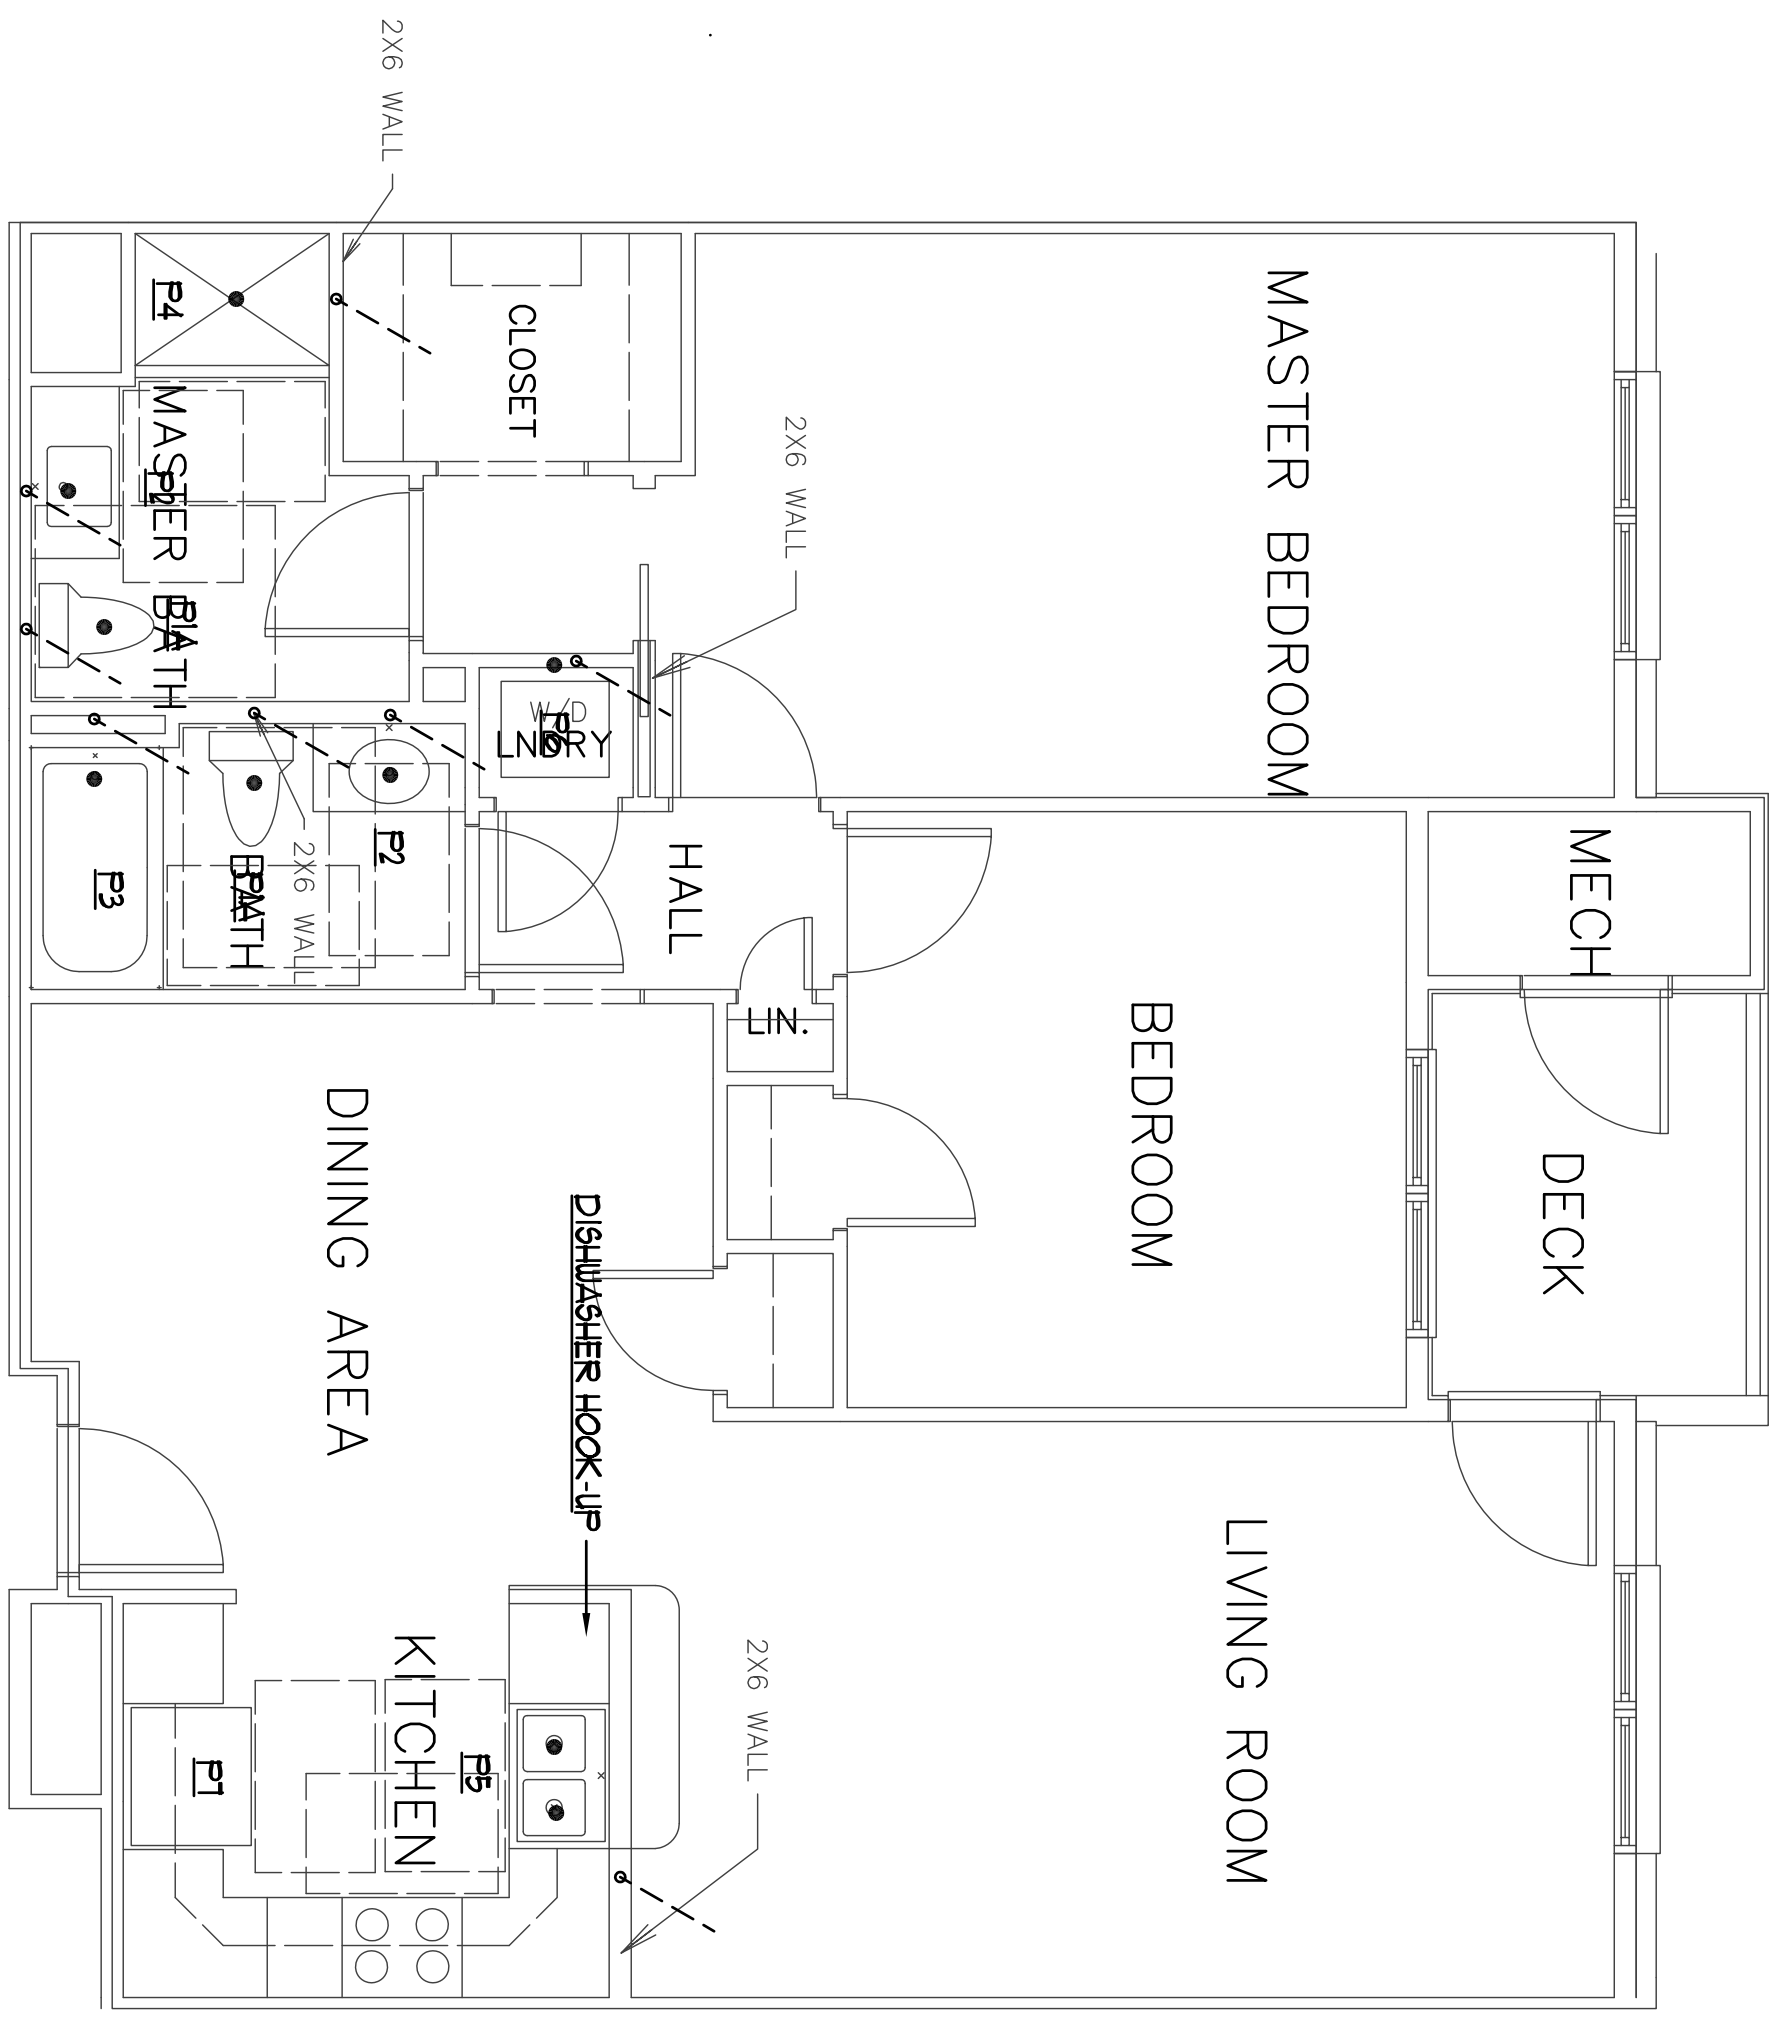

UNIT TYPE A1
 SCALE: 1/4" = 1' 0"

General Note
 1. Unit Type A1 is similar to Unit Type A. See piping layout for Unit Type A for more information.