


Revisions  
 1/29/2012-UNDERSLAB PIPING FOR  
 CONSTRUCTION FOR PERMIT  
 12/14/2012- FOR PERMIT  
 1/14/2013- PLUMBING REVISIONS.  
 2/6/2013- 100% For Review  
 and Comment

Bay House

Portland, ME

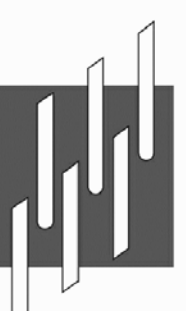


**BENNETT  
 ENGINEERING**  
 MECHANICAL • ELECTRICAL  
 (207) 865-9475

Job No.: 3346  
 Date: 12/14/12  
 Scale: 1/8" = 1'-0" or A.N.  
 Drawn by: SF Deel  
 Checked by: SF Deel

Drawing Title:  
 Plumbing 2nd Floor  
 Plan Building "1"

**P.2**

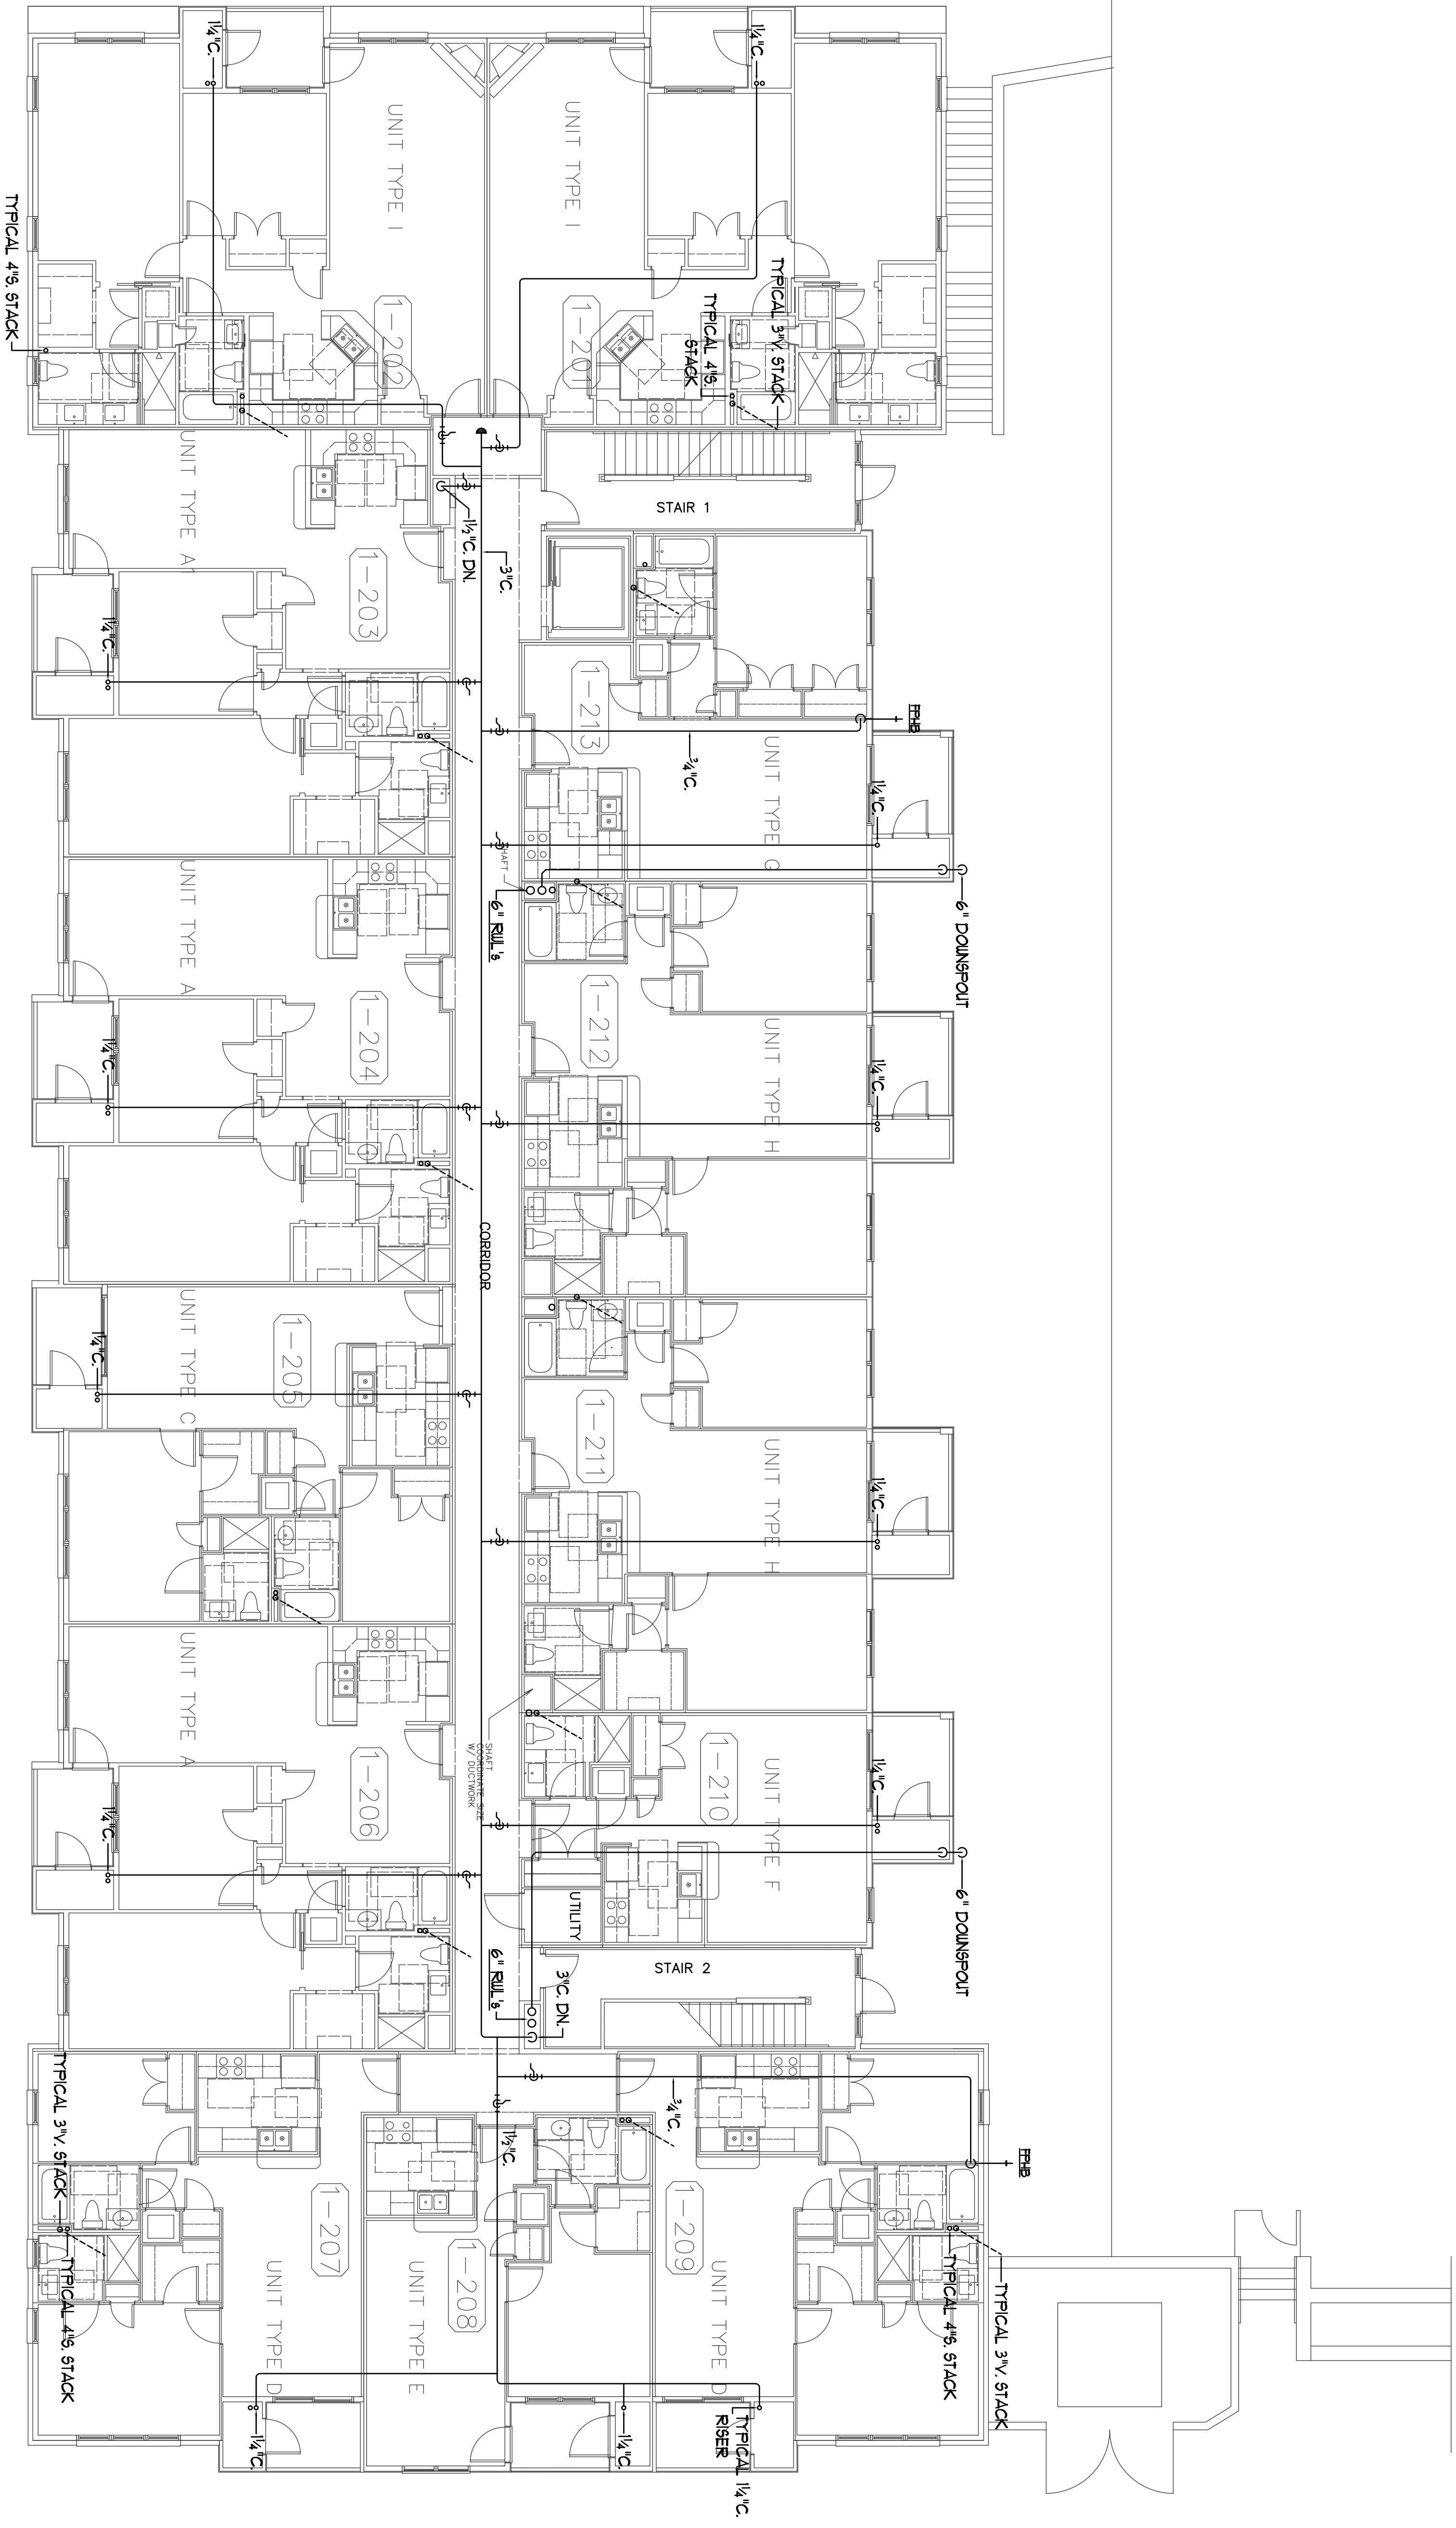

**2nd FLOOR PLAN  
 BUILDING 1**  
 SCALE: 1/8" = 1' 0"

**Atlantic Comfort  
 Systems, Inc.**  
 Mechanical Contractor • 207-894-4390  
 882 Hill Street, Portland, ME 04105  
 www.atlanticcomfort.com