


4th FLOOR PLAN
 BUILDING 1
 SCALE: 1/8" = 1' 0"

Revisions
 1/29/2012-INDERS LAB PIPING FOR
 CONSTRUCTION
 12/14/2012- FOR PERMIT
 1/14/2013- PLUMBING REVISIONS
 2/6/2013- 100% For Review
 and Comment


Bay House
 Portland, ME



**BENNETT
 ENGINEERING**
 MECHANICAL • ELECTRICAL
 (207) 865-9475

Job No.: 3346
 Date: 12/14/12
 Scale: 1/8" = 1'-0" or A.N.
 Drawn by: SF Dnd
 Checked by: SF Dnd

Drawing Title:
 Plumbing Fourth Floor
 Plan Building "1"

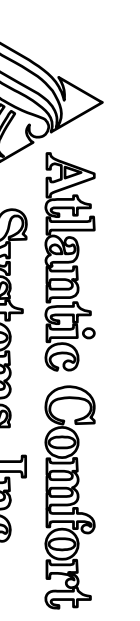

Atlantic Comfort
 Systems, Inc.
 Mechanical Contractor • 207-284-4390
 882 Hill Street, Bridgton, ME 04005
 www.atlanticcomfort.com

P.4