


Revisions  
 11/29/2012-INDERS LAB PIPING FOR  
 CORRECTION- FOR PERMIT  
 12/14/2012- FOR PERMIT  
 1/14/2013- PLUMBING REVISIONS.  
 2/6/2013- 100% For Review  
 and Comment

Bay House  
 Portland, ME

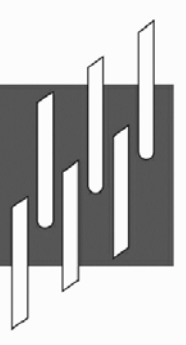


**BENNETT  
 ENGINEERING**  
 MECHANICAL • ELECTRICAL  
 (207) 865-9475

Job No.: 3346  
 Date: 12/4/12  
 Scale: 1/8" = 1'-0" or A.N.  
 Drawn by: SF Deel  
 Checked by: SF Deel

Drawing Title:  
**Plumbing Roof Plan  
 Building "1"**

**P.6**

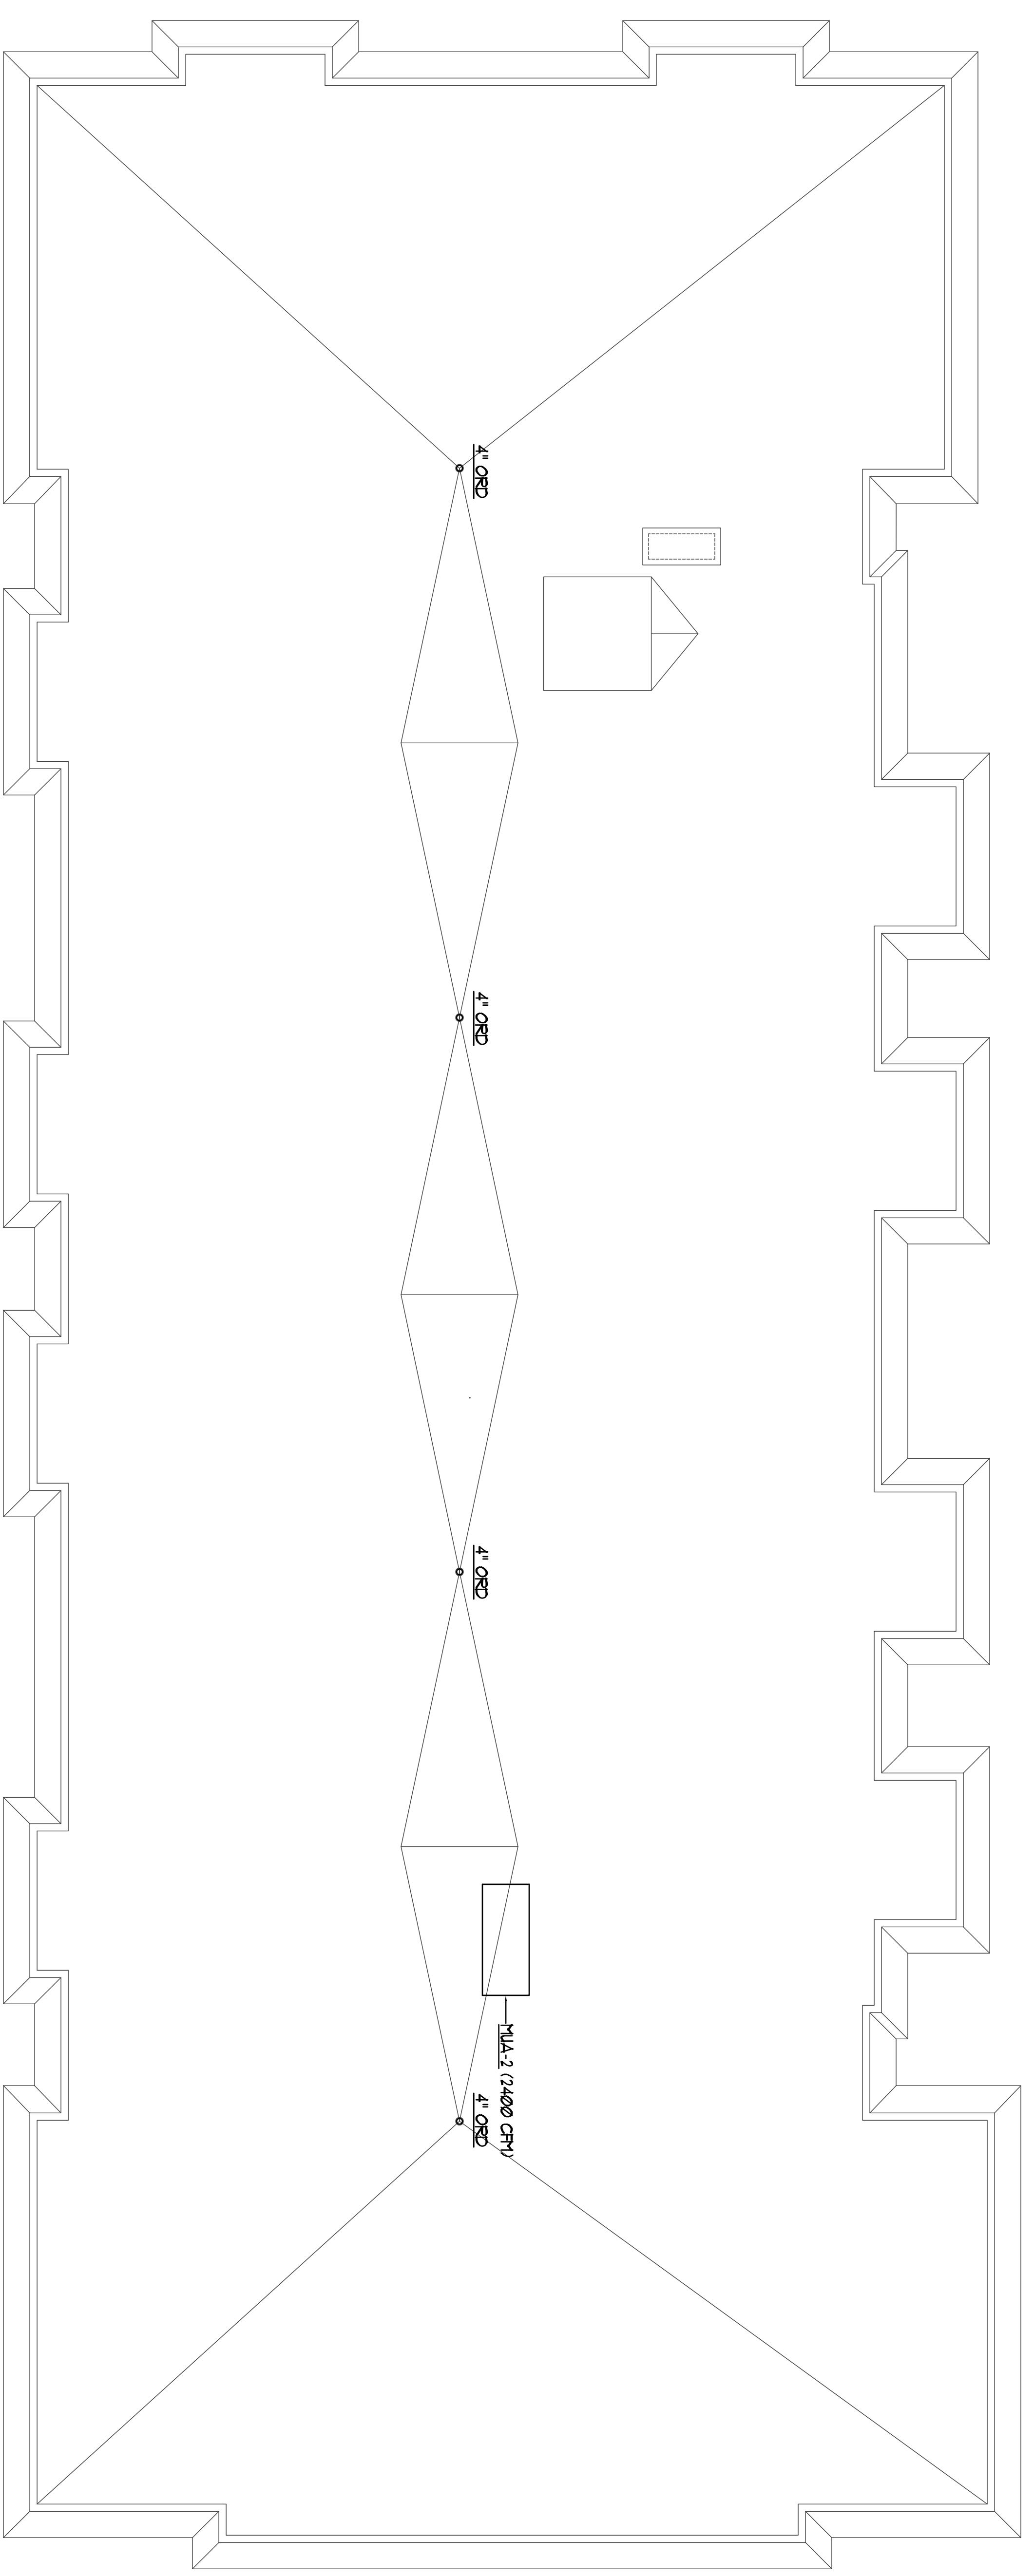

**ROOF PLAN  
 BUILDING 1**  
 SCALE: 1/8" = 1' 0"



**Atlantic Comfort  
 Systems, Inc.**  
 Mechanical Contractor • 807-884-4390  
 882 Hill Street, Biddeford, ME 04005  
 www.atlanticcomfort.com