



3rd FLOOR PLAN  
 BUILDING 2  
 SCALE: 1/8" = 1' 0"

Revisions  
 1/29/2012-INDERS LAB PIPING FOR  
 CONSTRUCTION  
 12/14/2012- FOR PERMIT  
 1/14/2013- PLUMBING REVISIONS.  
 2/6/2013- 100% For Review  
 and Comment

Bay House


Portland, ME



**BENNETT  
 ENGINEERING**  
 MECHANICAL • ELECTRICAL  
 (207) 865-9475

Job No.: 3346  
 Date: 12/14/12  
 Scale: 1/8" = 1'-0" or A.N.  
 Drawn by: SF DvdI  
 Checked by: SF DvdI

Drawing Title:  
 Plumbing Third Floor  
 Plan Building "2"

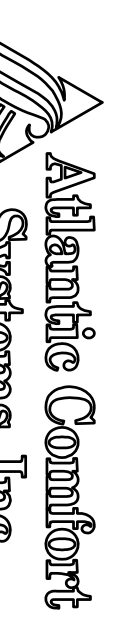

**Atlantic Comfort  
 Systems, Inc.**  
 Mechanical Contractor • 807-894-4390  
 882 Hill Street, Biddeford, ME 04005  
 www.atlanticcomfort.com

**P.9**