




ARCHITECTURE ENGINEERING PLANNING
 SMART
 144 Fore Street, P.O. Box 618
 Portland, Maine 04104
 tel. (207) 772-3846
 fax. (207) 772-1070

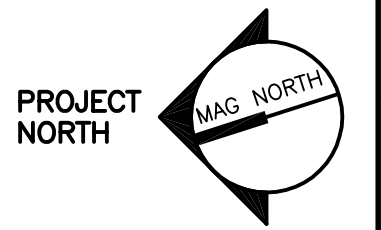

PROJECT TITLE:
THE MILESTONE FOUNDATION
 INDIA STREET, PORTLAND

CURRENT ISSUE STATUS:
ISSUED FOR CONSTRUCTION
4-11-03

REV	DESCRIPTION	DATE
0	ISSUED FOR CONSTRUCTION	4-11-03

GRAPHIC SCALE:
 0" 1"

SCALE: 1/8"=1'-0"
 PROJECT MANAGER: JLH
 JC/DRAWN BY: RJL/LAM
 A/E OF RECORD: DJT
 SMART CAD FILE: EL101-03017
 PROJECT NO: 03017
 DATE: 4-11-03
 SHEET TITLE:

LIGHTING FLOOR PLANS


SHEET No.
EL101

NOTES:

- SEE SHEET E-001 FOR LEGEND AND GENERAL NOTES


KEYED NOTES:

- INSTALL PHOTOCELL AND WIRE TO NEW WALL PACK
- RE-WIRE EXISTING FIXTURES TO NEW BRANCH CIRCUIT & SWITCHES AS INDICATED

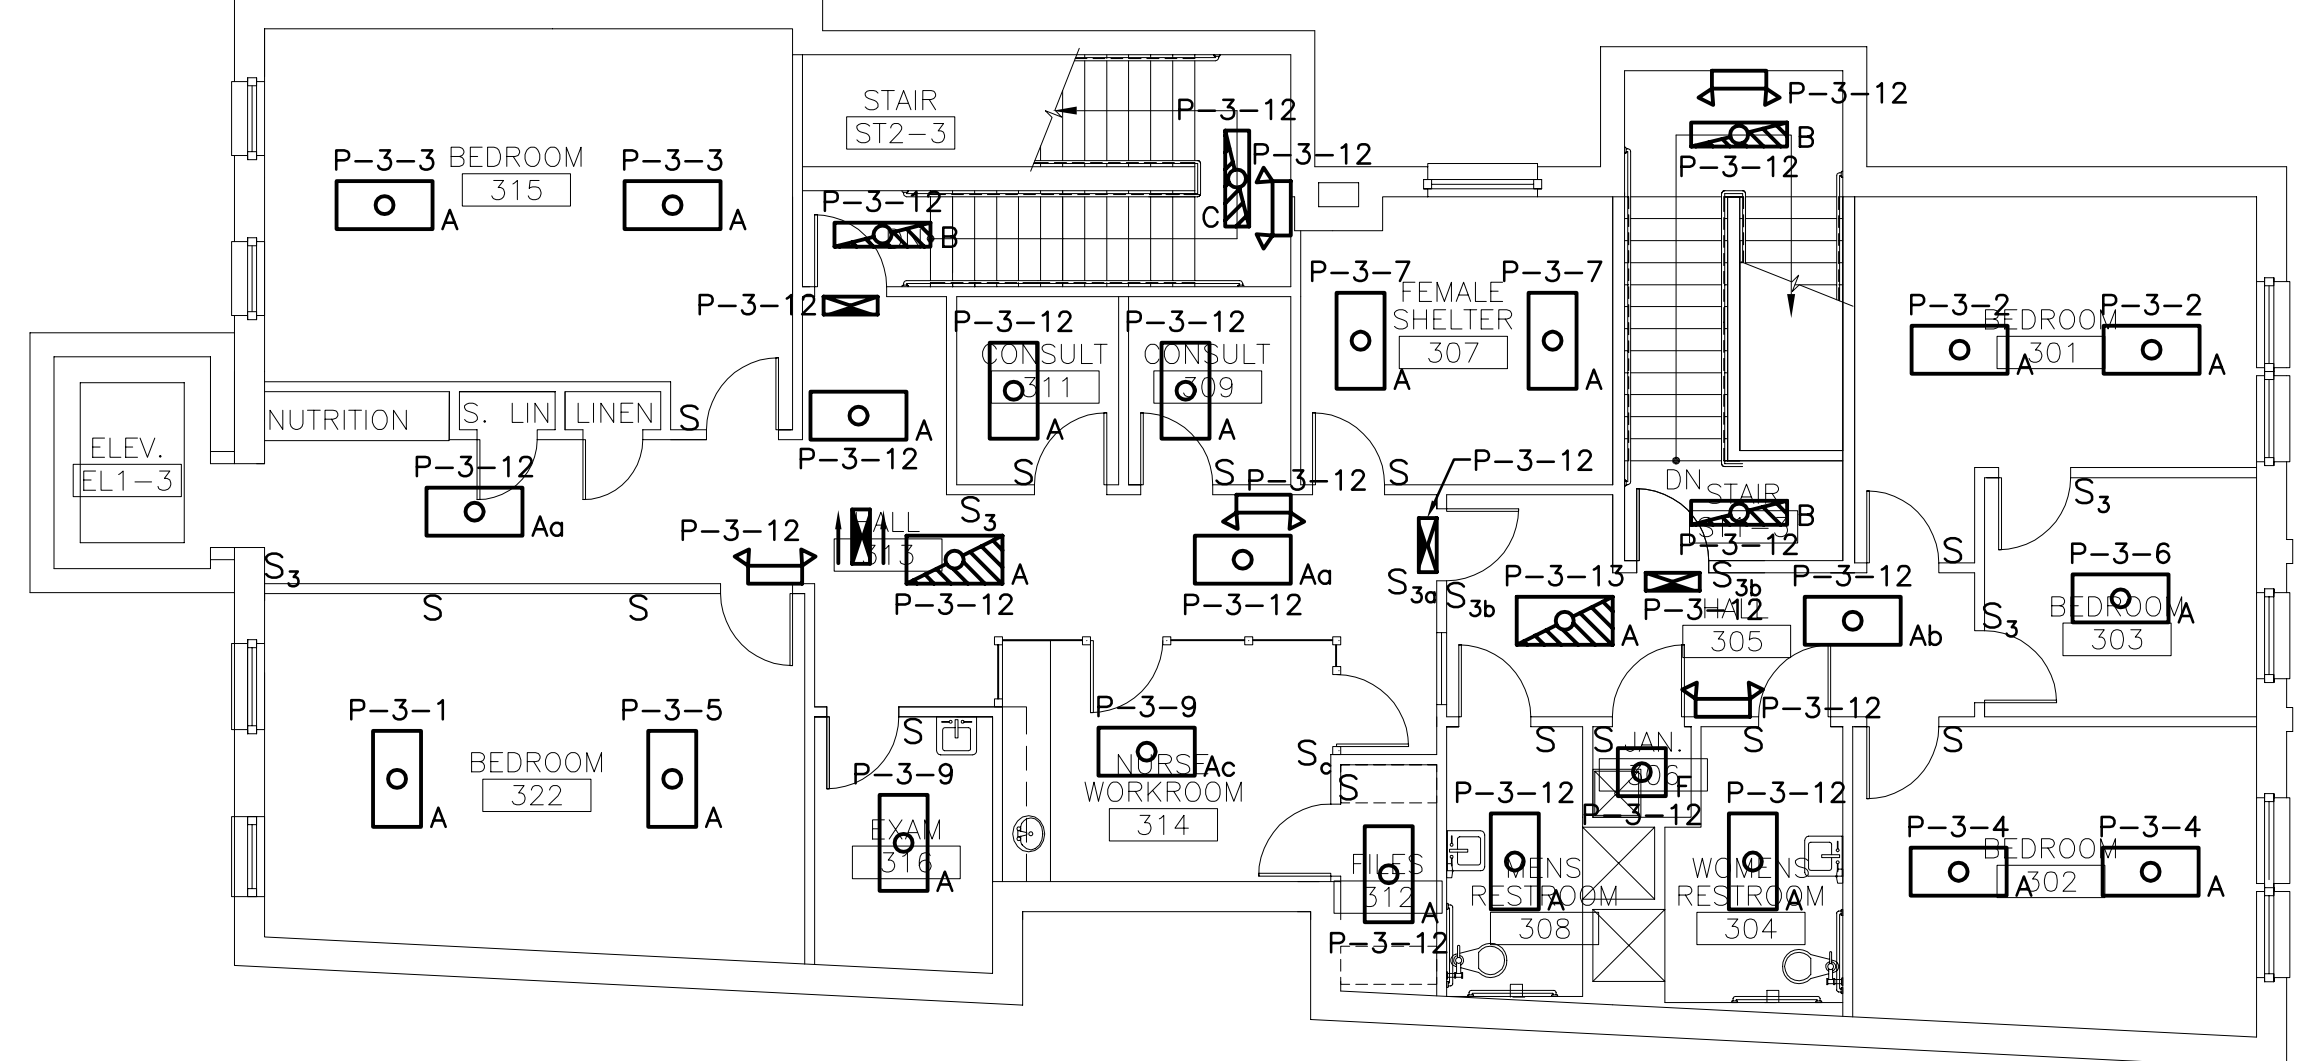


K1 THIRD FLOOR PLAN

1/8"=1'-0"

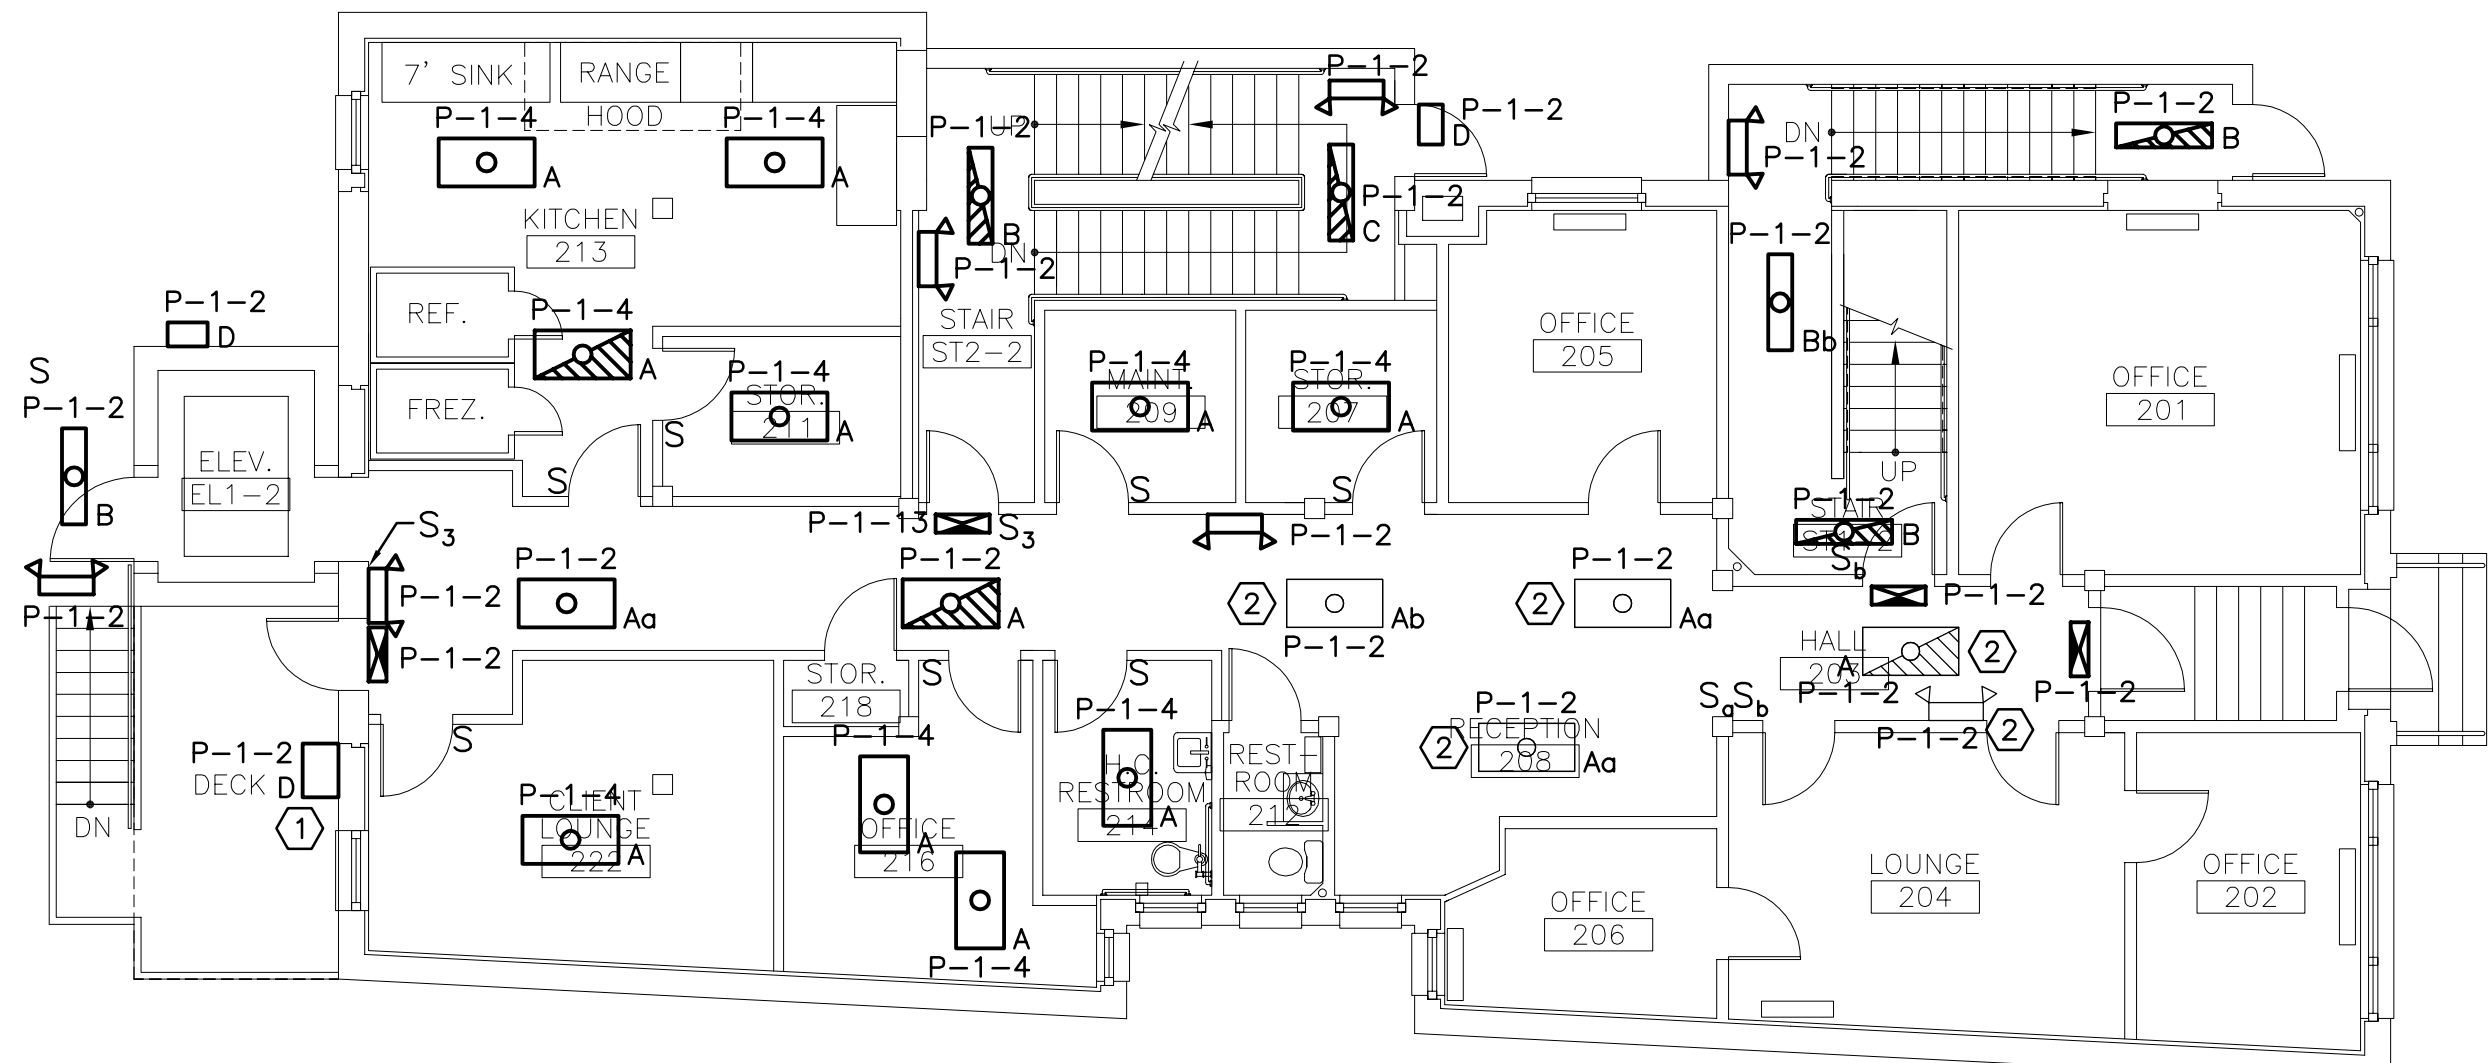

F1 SECOND FLOOR PLAN

1/8"=1'-0"

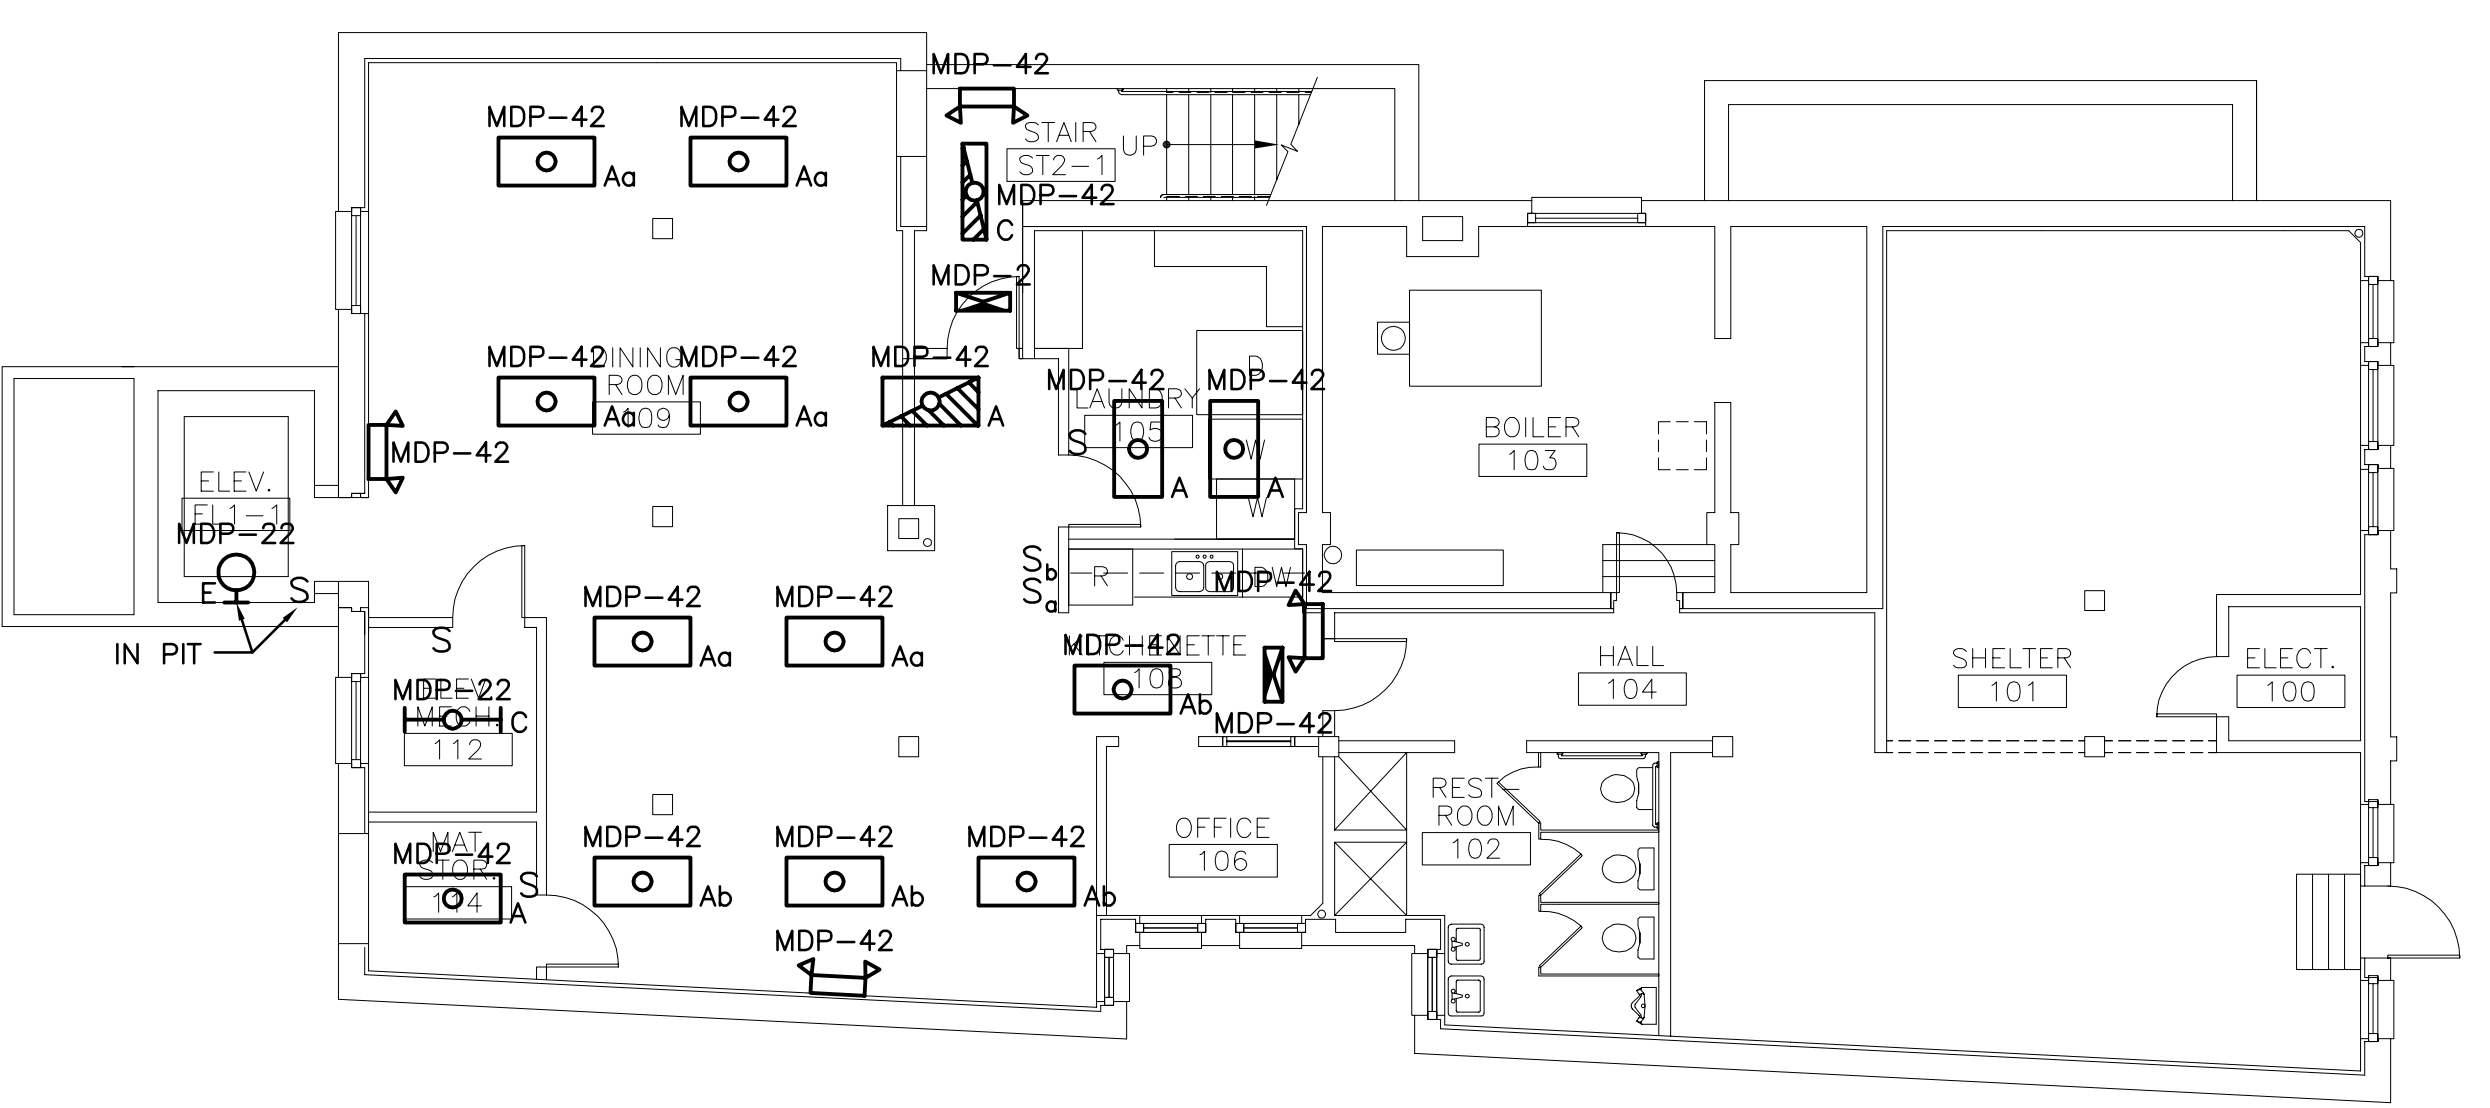

A1 FIRST FLOOR PLAN

1/8"=1'-0"

LIGHT FIXTURE SCHEDULE

TYPE	DESCRIPTION	MFR.	LAMPS	MOUNTING	NOTES
A	2x4 TROFFER SPECIFICATION GRADE, ELECTRONIC BALLAST WITH A12 ACRYLIC LENS	COLUMBIA ST824-332G-FSA12-EBB120	3-F32T8 3500K	RECESSED	
B	4' WRAPAROUND, ELECTRONIC BALLAST	COLUMBIA WC4-232-EBB120	2-F32T8 3500K	CEILING	
C	4' INDUSTRIAL REFLECTOR	COLUMBIA CSR4-232-EBB120	2-F32T8 3500K	CHAIN	
D	EXTERIOR WALL PACK	LUMARK WM SERIES	70W METAL HALIDE	WALL	
E	GUARDED & GLOBED WALL FIXTURE SUITABLE FOR WET LOCATION.	RIGALITE CVPD SERIES	1-75W A1A	WALL	
F	2x2 TROFFER SPECIFICATION GRADE, ELECTRONIC BALLAST WITH A12 ACRYLIC LENS	COLUMBIA ST822-2176-FSA12-EBB120	2-F17T8 3500K	RECESSED	
◀	EMERGENCY LIGHTING UNIT WITH MAINTENANCE FREE BATTERY	PRESCOLITE ELBZ	INTEGRAL W/UNIT	WALL	
◻	EMERGENCY EXIT SIGN W/MAINTENANCE FREE BATTERY	PRESCOLITE PEX SERIES	LED	CEILING	