

Prepared For:



Consulting Engineer:


Architect: **ARCHETYPE** Architects
48 Union Wharf Portland, Maine 04101
(207) 772-6022 Fax (207) 772-4056

Project: **Addition to Ocean Gateway Garage**
167 Fore St.
Portland, Maine

Revisions:

Date: APRIL 12, 2017
Scale: 1/8" = 1'-0"
GROUND FLOOR PLUMBING PLAN

M2.01

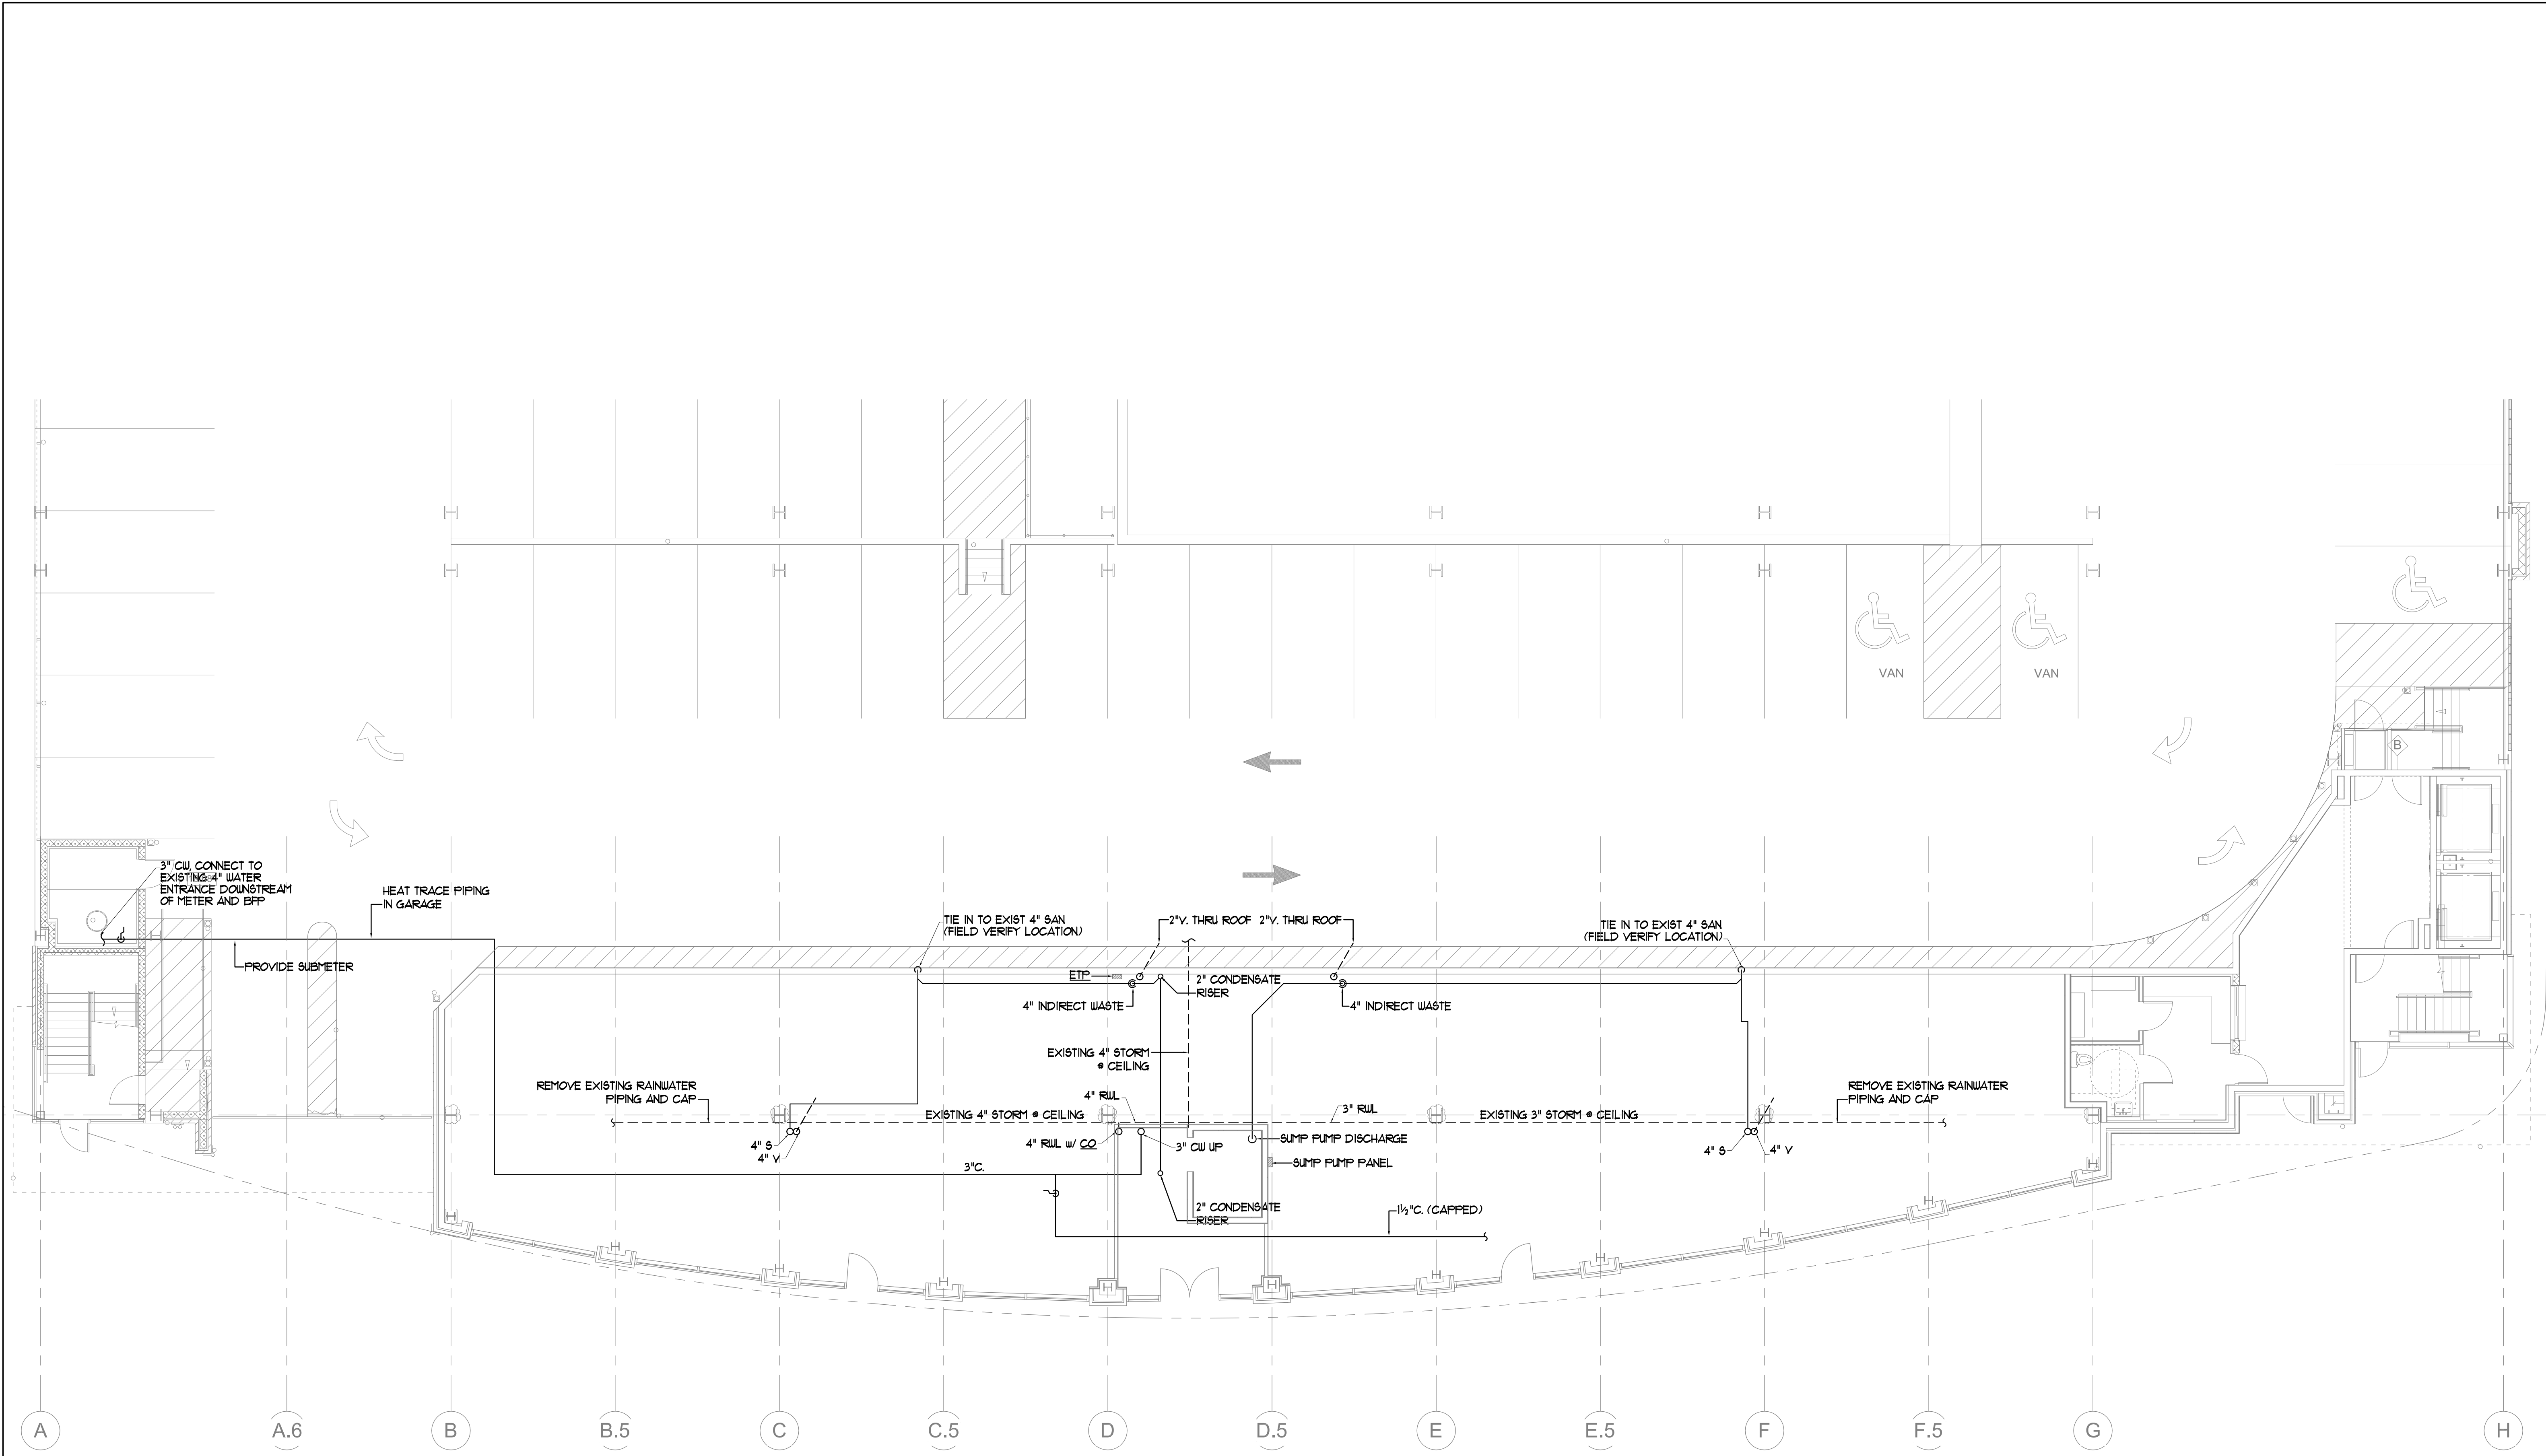

1 | GROUND FLOOR PLUMBING PLAN
SCALE: 1/8"=1'-0"