


Prepared For:



Consulting Engineer:

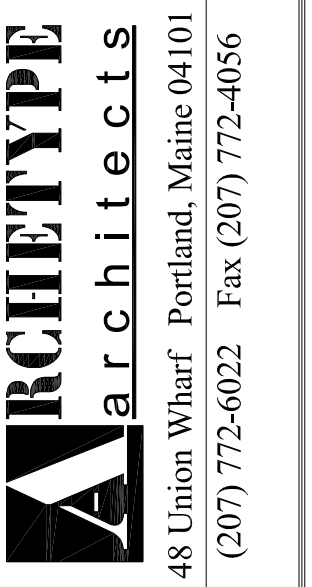

Architect:

**Project:**  
Addition to Ocean Gateway Garage  
167 Fore St.  
Portland, Maine


Revisions:

Date: APRIL 12, 2017

Scale: 1/8" = 1'-0"

FOURTH FLOOR  
PLUMBING PLAN

M2.04

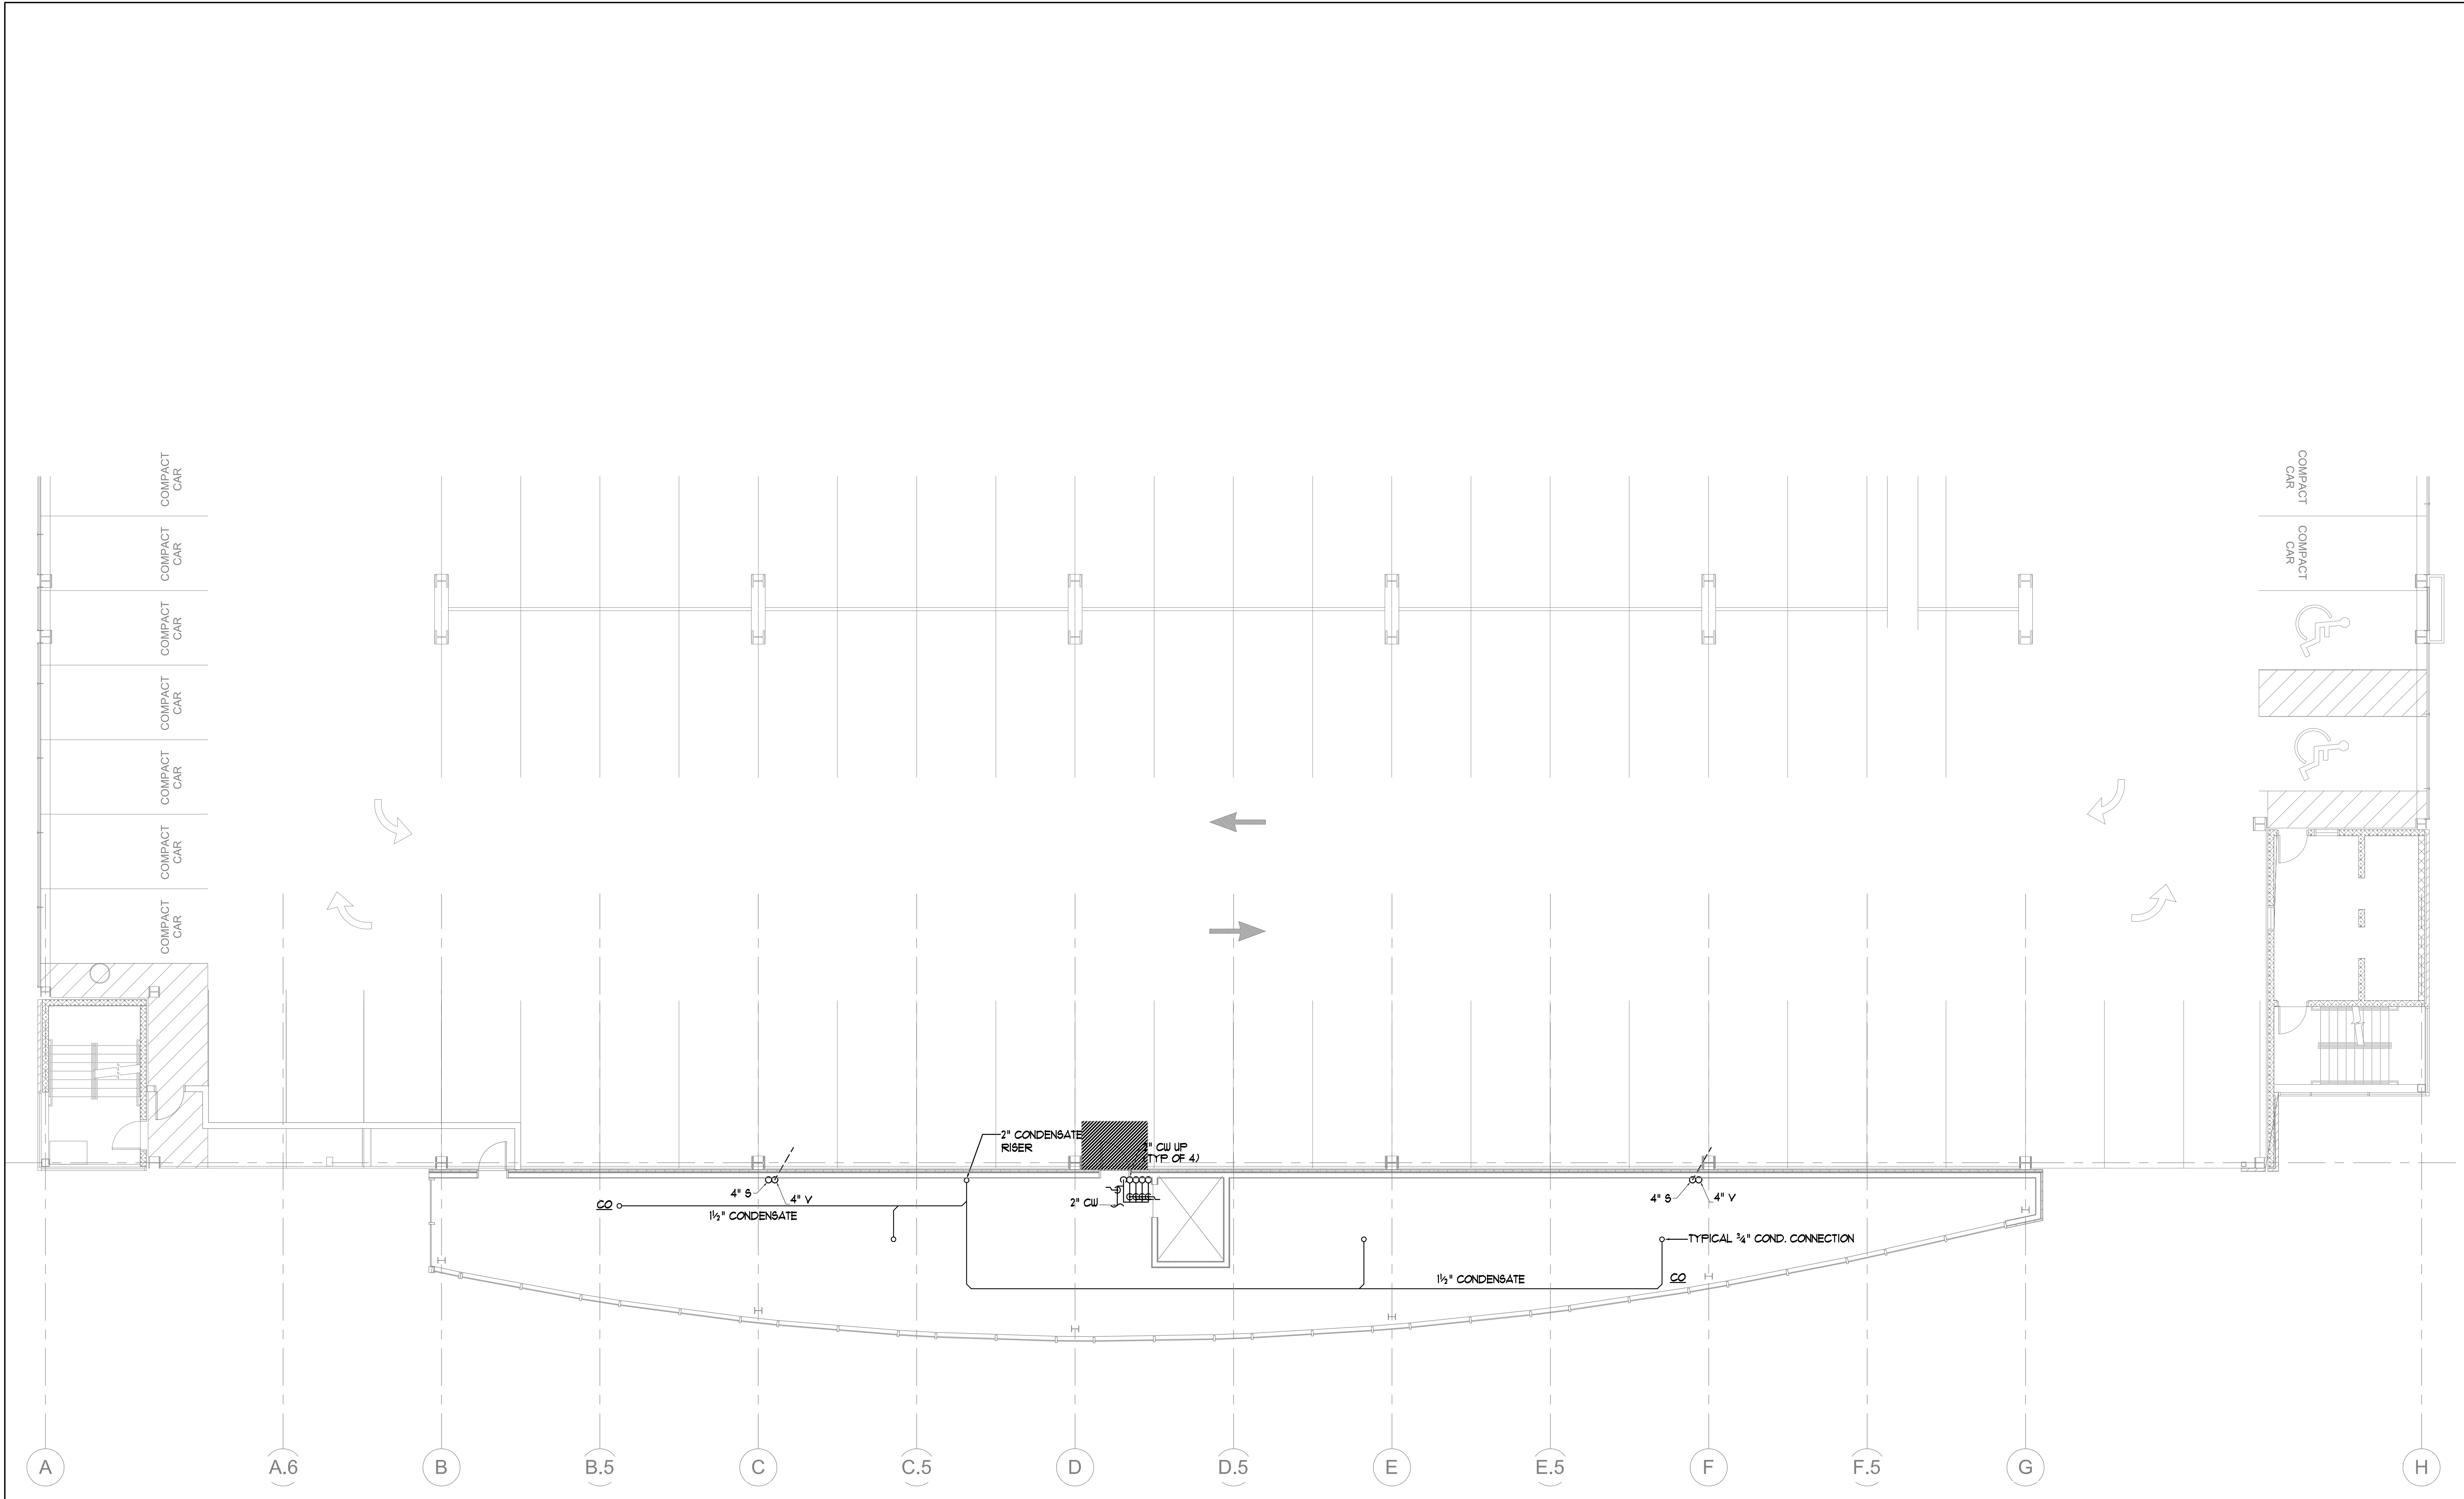

**1** | FOURTH FLOOR PLUMBING PLAN  
SCALE: 1/8"=1'-0"