

Prepared For:



Consulting Engineer:



Project:

Addition to Ocean Gateway Garage

167 Fore St, Portland, Maine

Revisions:

Date:


APRIL 12, 2017

Scale:

1/8" = 1'-0"

FIFTH FLOOR PLUMBING PLAN

M2.05

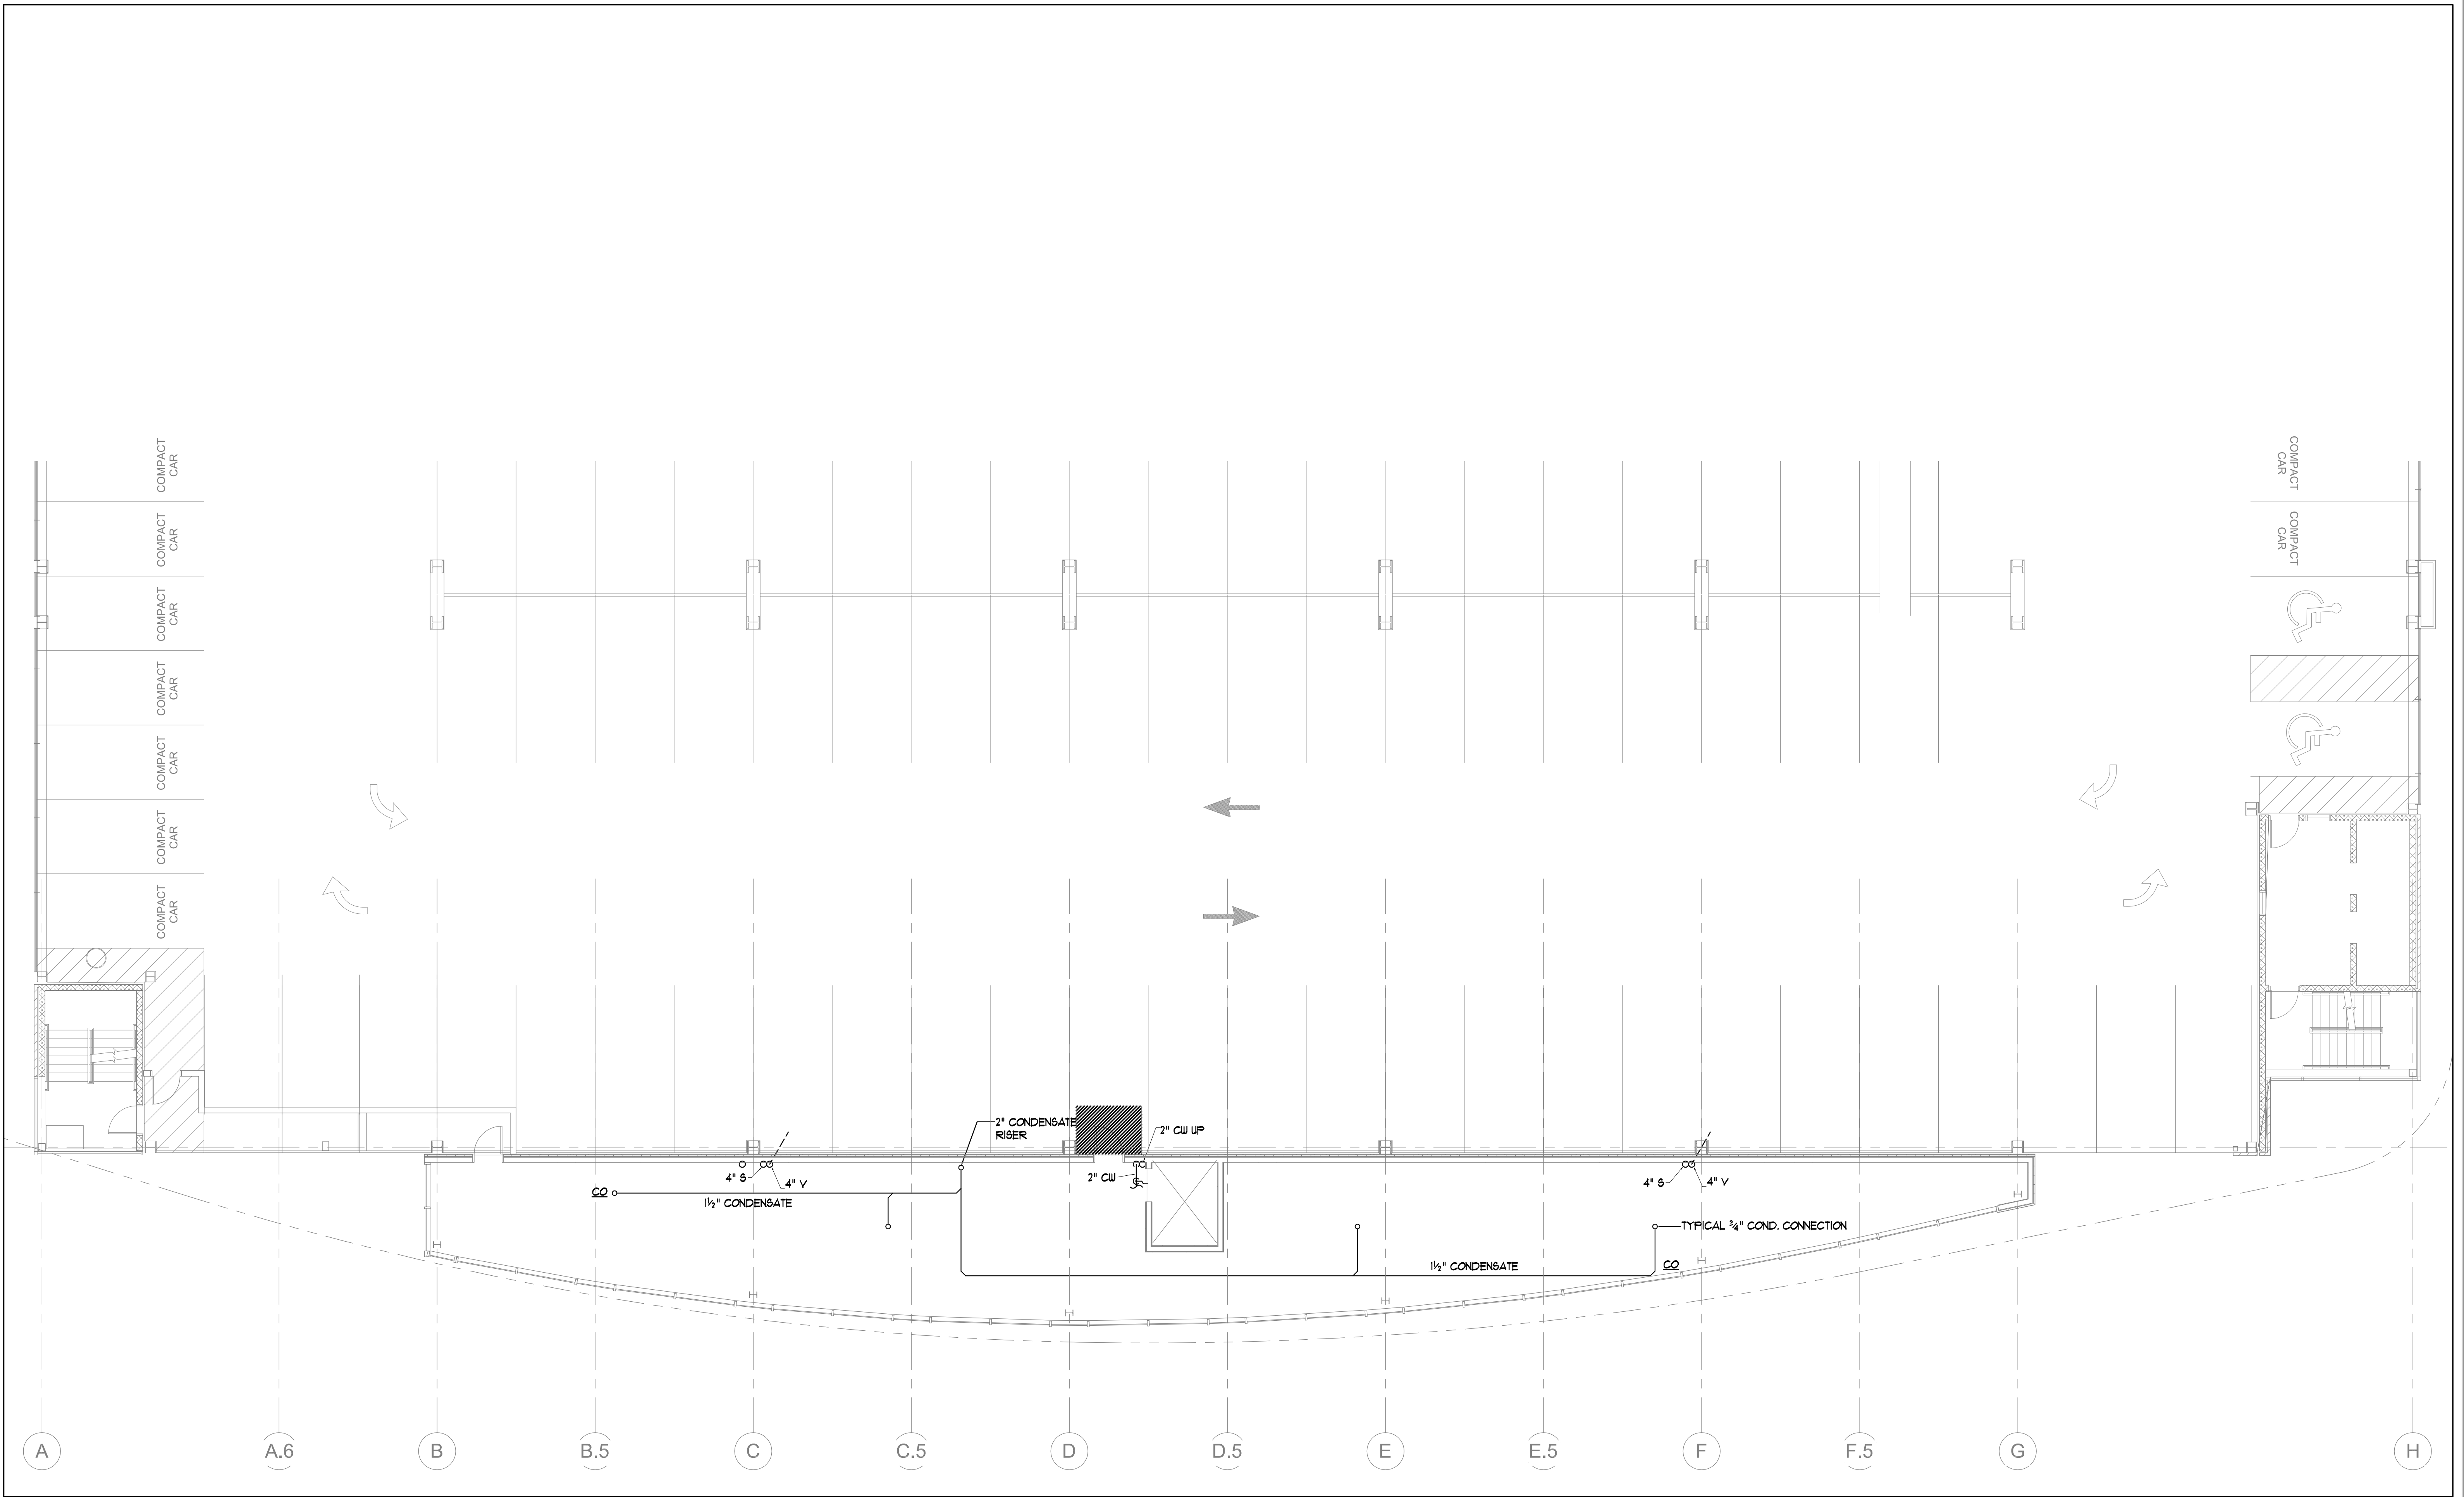

**1** FIFTH FLOOR PLUMBING PLAN  
SCALE: 1/8"=1'-0"