

CONSTRUCTION SET

OWNER
RIVERWALK, LLC
 2 MARKET STREET, SUITE 500
 PORTLAND, ME 04101
 CLIENT


RIVERWALK, LLC
 2 MARKET STREET, SUITE 500
 PORTLAND, ME 04101

PROJECT
OCEAN GATEWAY PARKING GARAGE
 MIDDLE STREET, PORTLAND, MAINE

REVISIONS

| NO. | DATE | DESCRIPTION |
|-----|----------|-------------|
| 1 | 08/19/07 | BULLETP |



DATE FEB 22, 2007
 SCALE
 PROJECT NO. 05-032

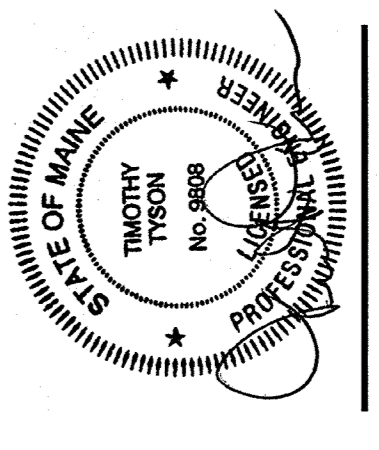

DRAWING TITLE
ELECTRICAL FIRST FLOOR FIRE ALARM PLAN

SHEET NUMBER

- ELECTRICAL NOTES:**
1. REFER TO DRAWING E4.00 FOR LEGEND, SYMBOLS AND GENERAL NOTES.
 2. REFER TO ARCHITECTURAL DRAWINGS FOR ASSOCIATED NOTES, MOUNTING DETAILS, HEIGHTS AND EXACT LOCATIONS OF ALL DEVICES.
 3. FIRE ALARM BRANCH CIRCUITRY SHALL BE INSTALLED IN CONDUIT (RGS).

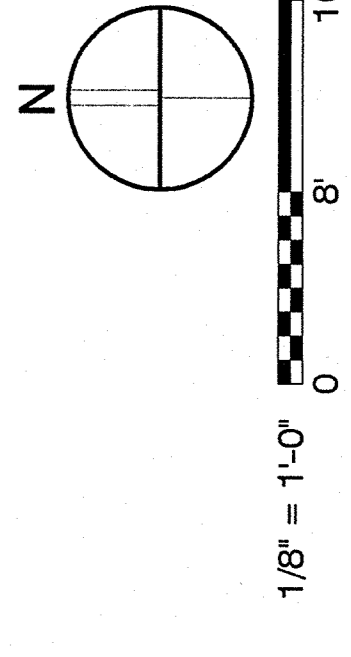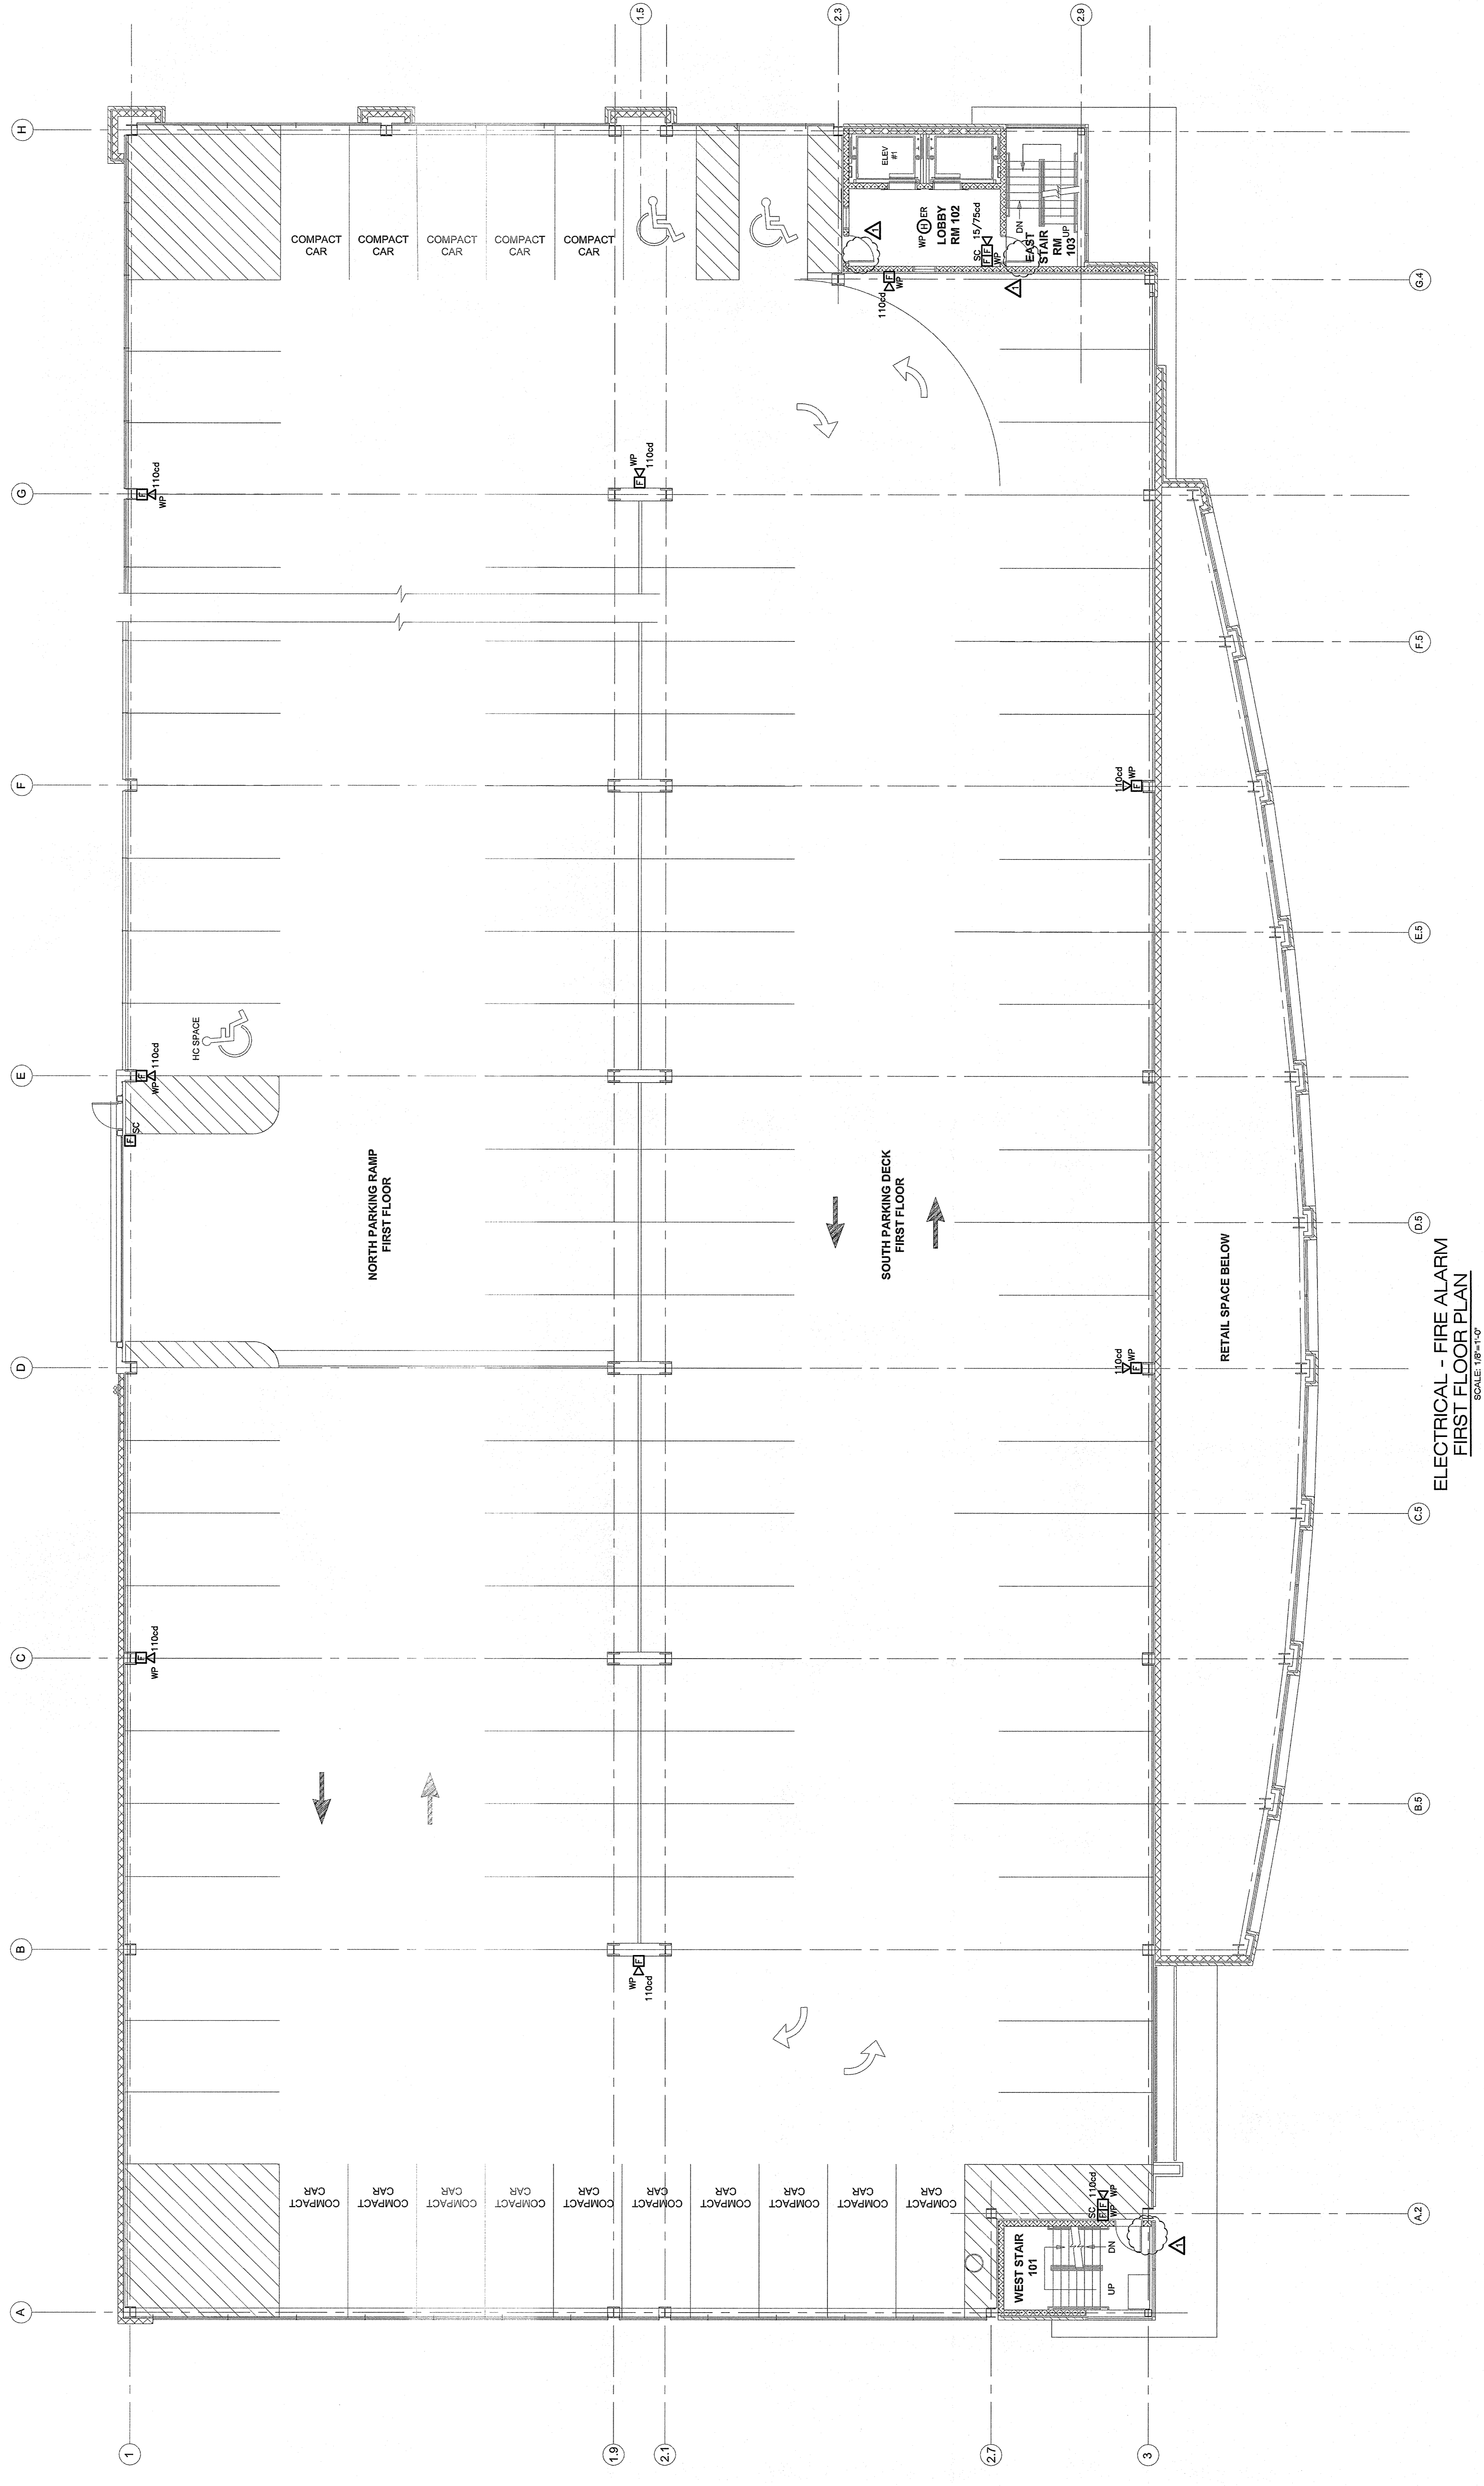

ELECTRICAL - FIRE ALARM FIRST FLOOR PLAN
 SCALE: 1/8"=1'-0"