


- FIRE ALARM NOTES:**
1. REFER TO DRAWING E4.00 FOR LEGEND, SYMBOLS AND GENERAL NOTES.
  2. REFER TO ARCHITECTURAL DRAWINGS FOR ASSOCIATED NOTES, MOUNTING DETAILS, HEIGHTS AND EXACT LOCATIONS OF ALL DEVICES.
  3. FIRE ALARM BRANCH CIRCUITRY SHALL BE INSTALLED IN CONDUIT (RGS).

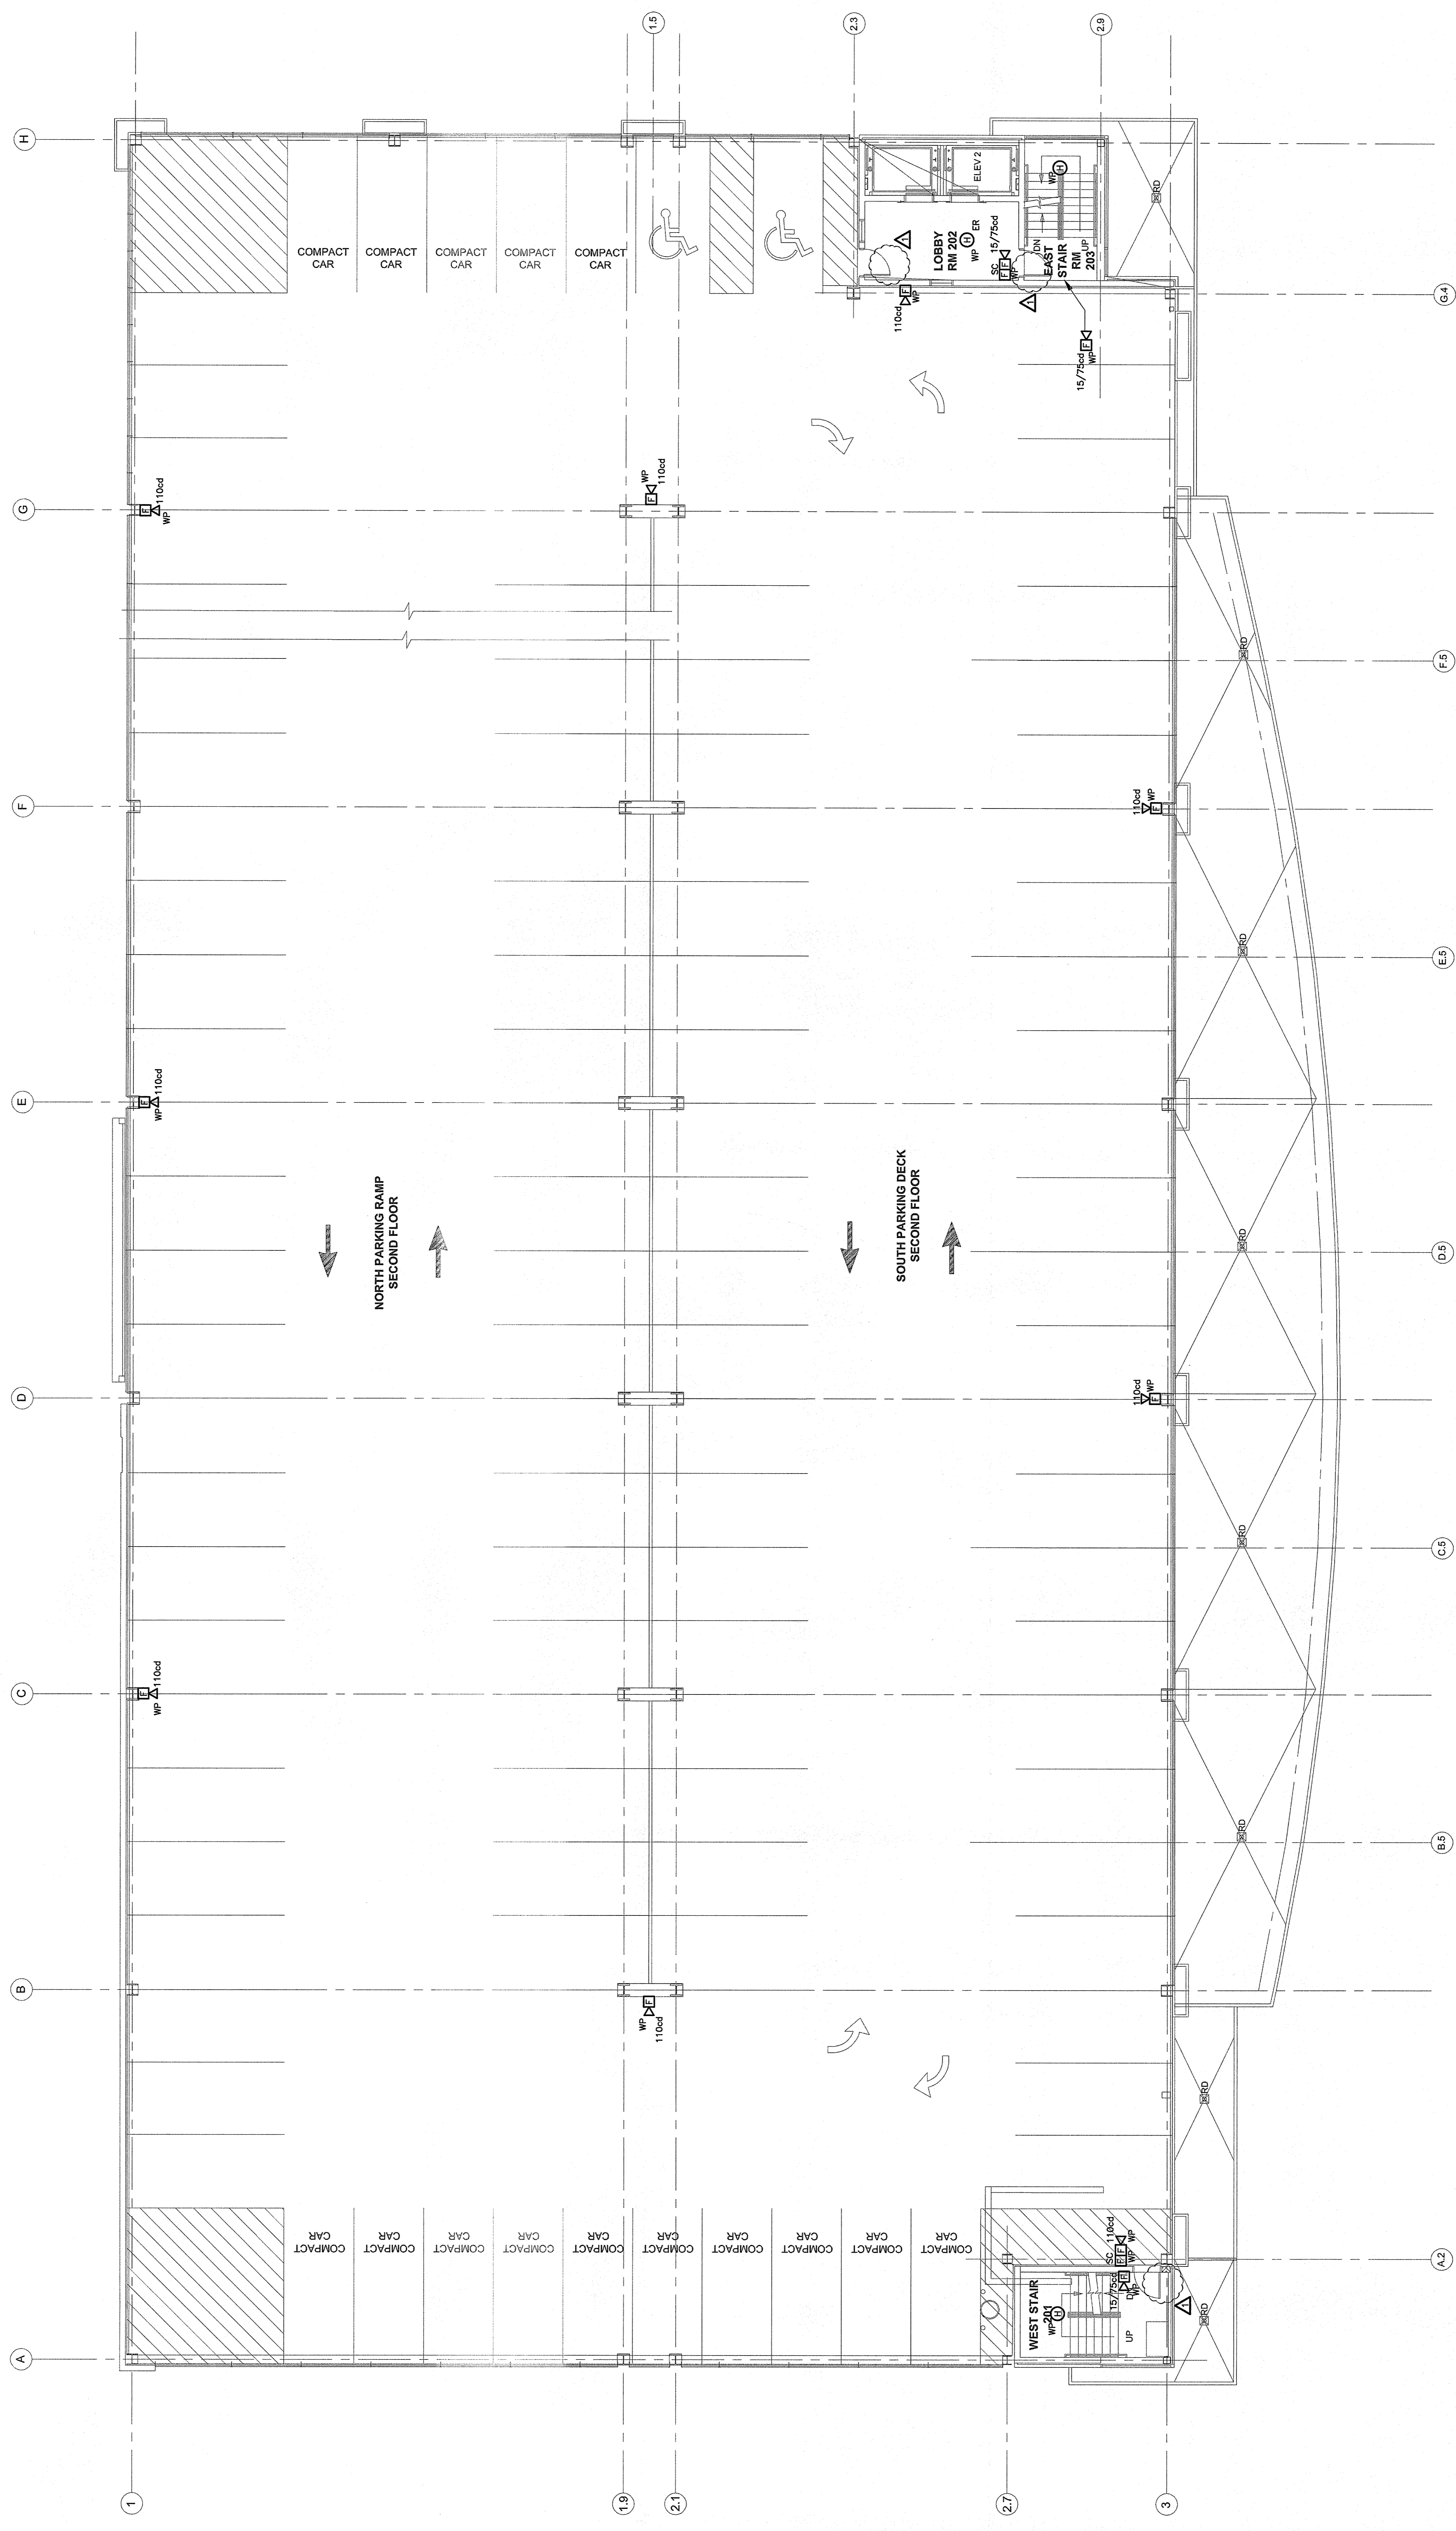

**ELECTRICAL - FIRE ALARM SECOND FLOOR PLAN**  
 SCALE: 1/8"=1'-0"