

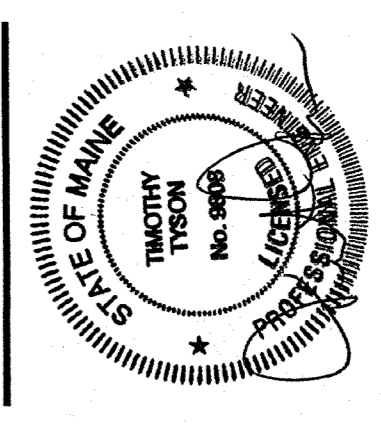


CONSTRUCTION SET
 OWNER
RIVERWALK, LLC
 2 MARKET STREET,
 SUITE 500
 PORTLAND, ME 04101
 CLIENT
RIVERWALK, LLC
 2 MARKET STREET,
 SUITE 500
 PORTLAND, ME 04101
 PROJECT
OCEAN GATEWAY PARKING GARAGE
 MIDDLE STREET
 PORTLAND, MAINE
 REVISIONS
 NO. DATE DESCRIPTION
 1 06/19/07 BULLETIN J
 DATE FEB 22, 2007
 SCALE PROJECT NO. 05-032

DRAWING TITLE
ELECTRICAL THIRD FLOOR FIRE ALARM PLAN
 SHEET NUMBER
E4.03

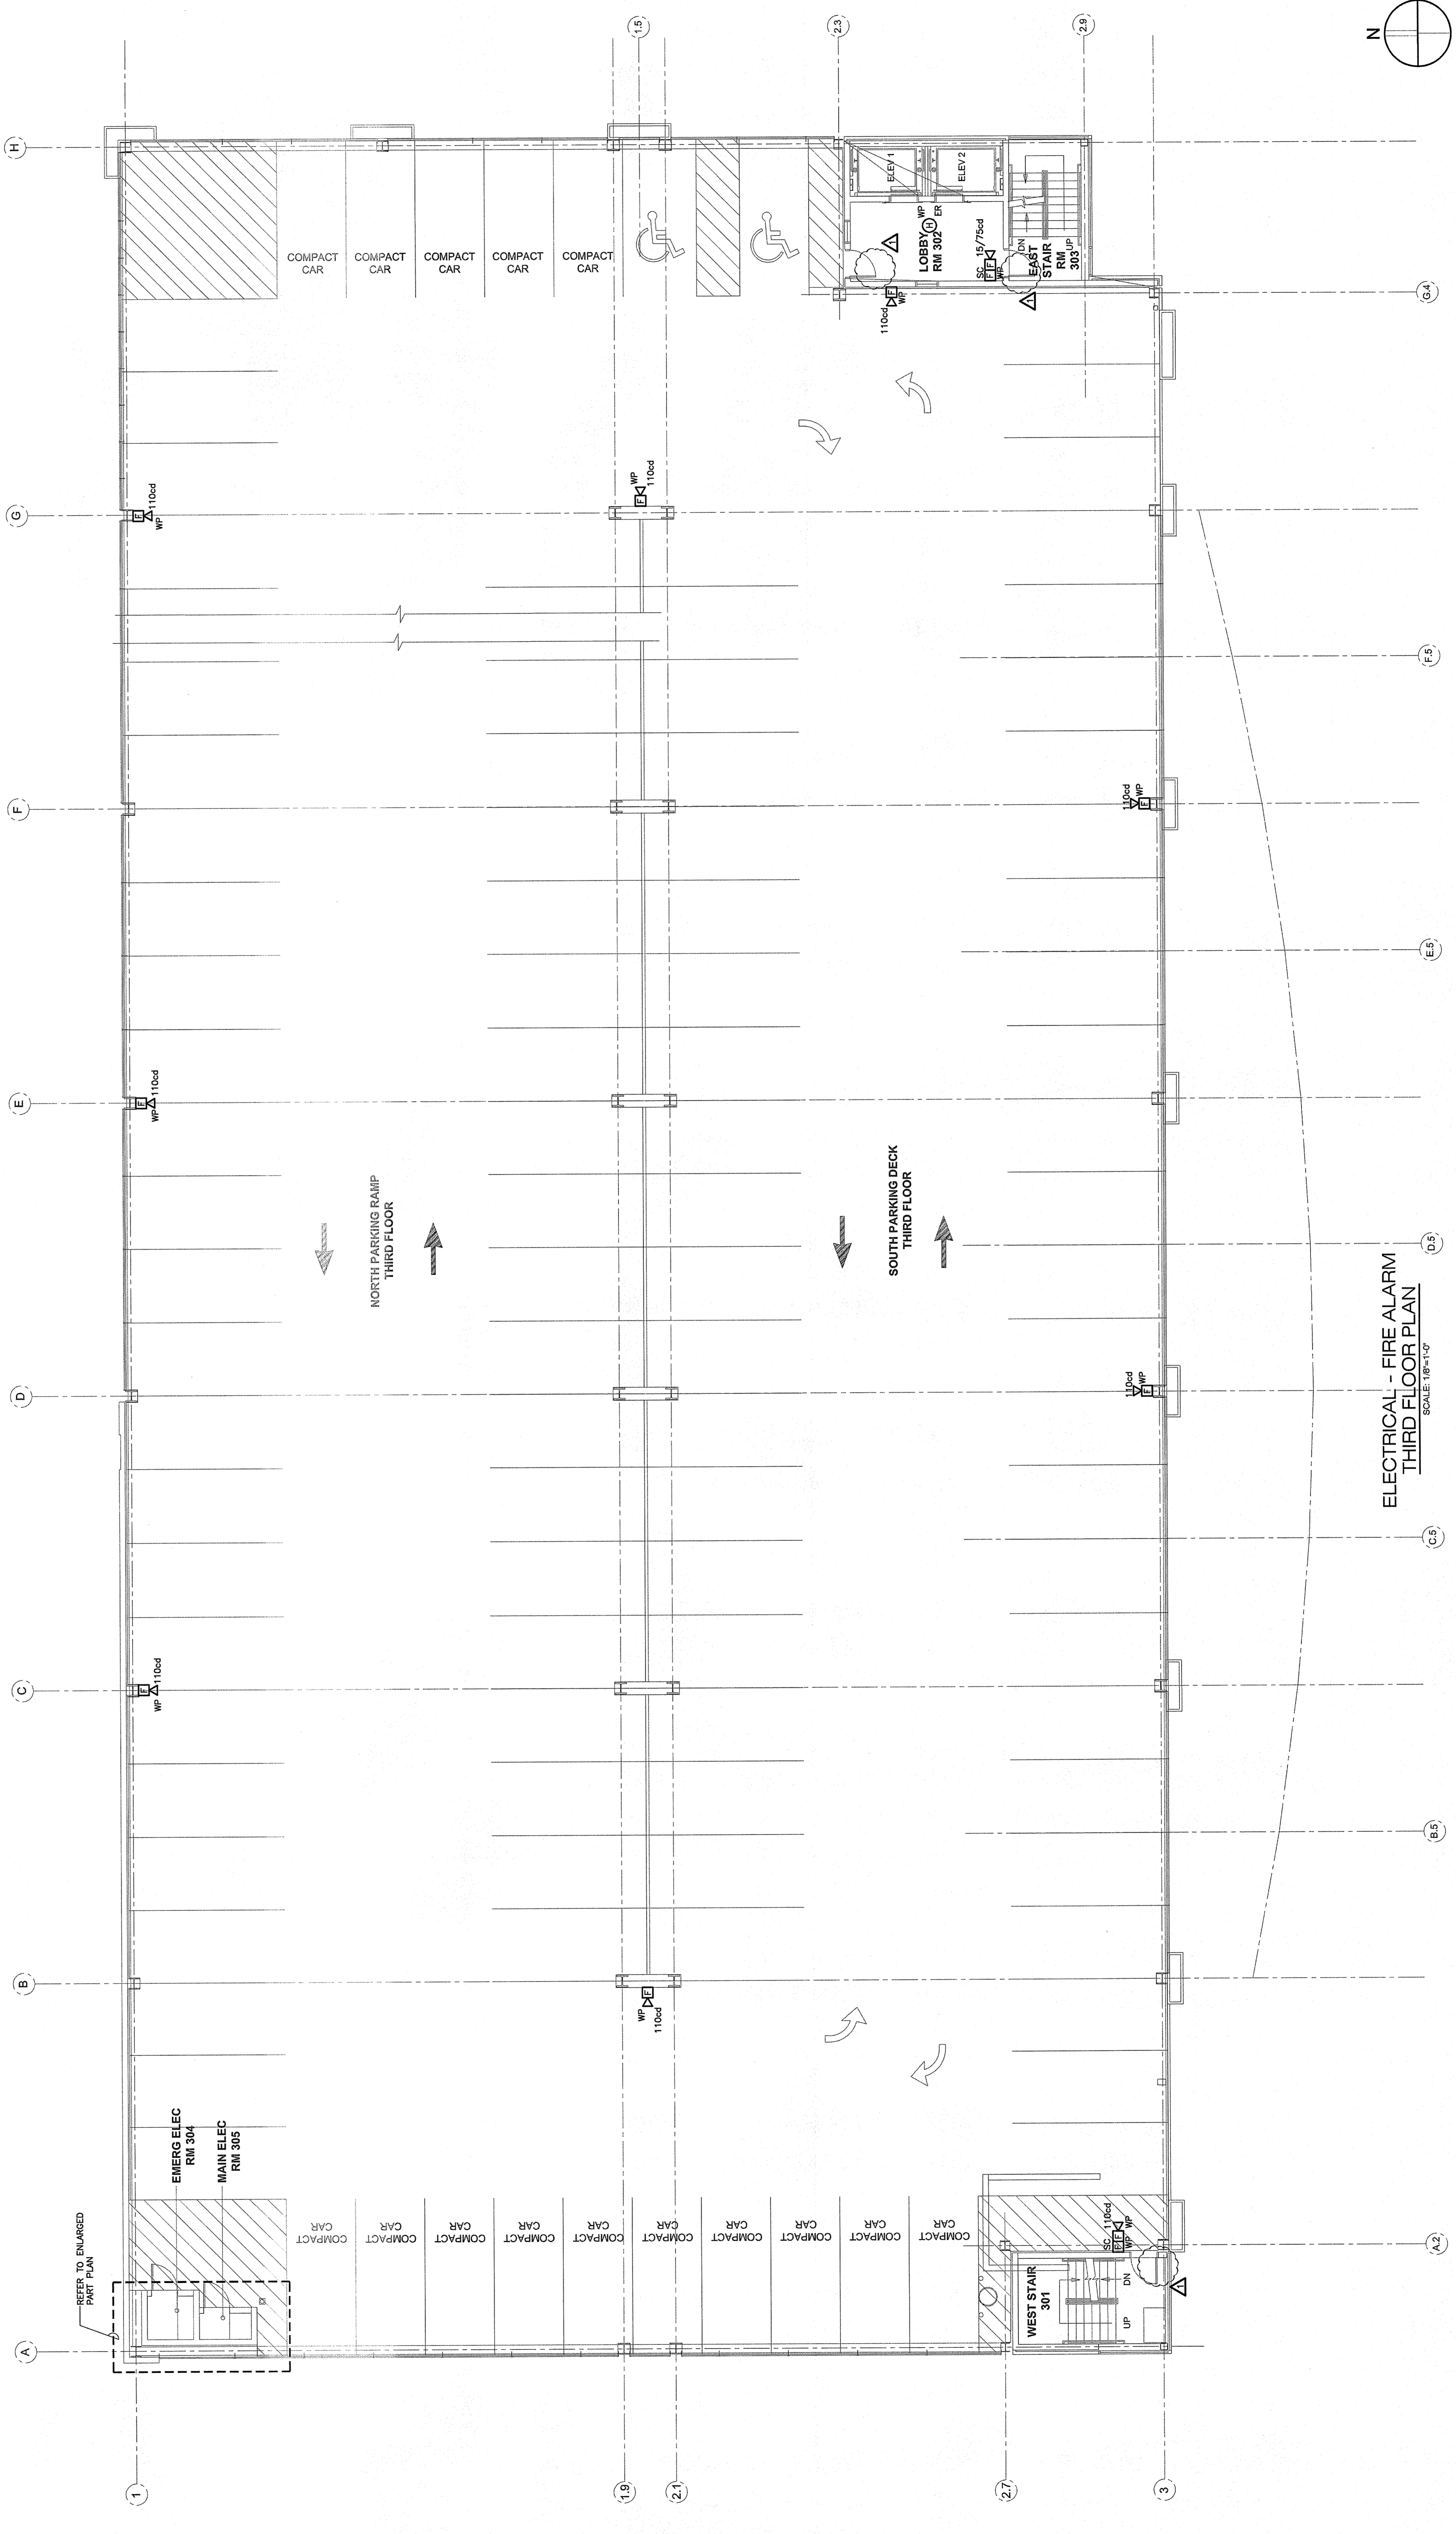

- FIRE ALARM NOTES:**
1. REFER TO DRAWING E4.00 FOR LEGEND, SYMBOLS AND GENERAL NOTES.
 2. REFER TO ARCHITECTURAL DRAWINGS FOR ASSOCIATED NOTES, MOUNTING DETAILS, HEIGHTS AND EXACT LOCATIONS OF ALL DEVICES.
 3. FIRE ALARM BRANCH CIRCUITRY SHALL BE INSTALLED IN CONDUIT (RCS).

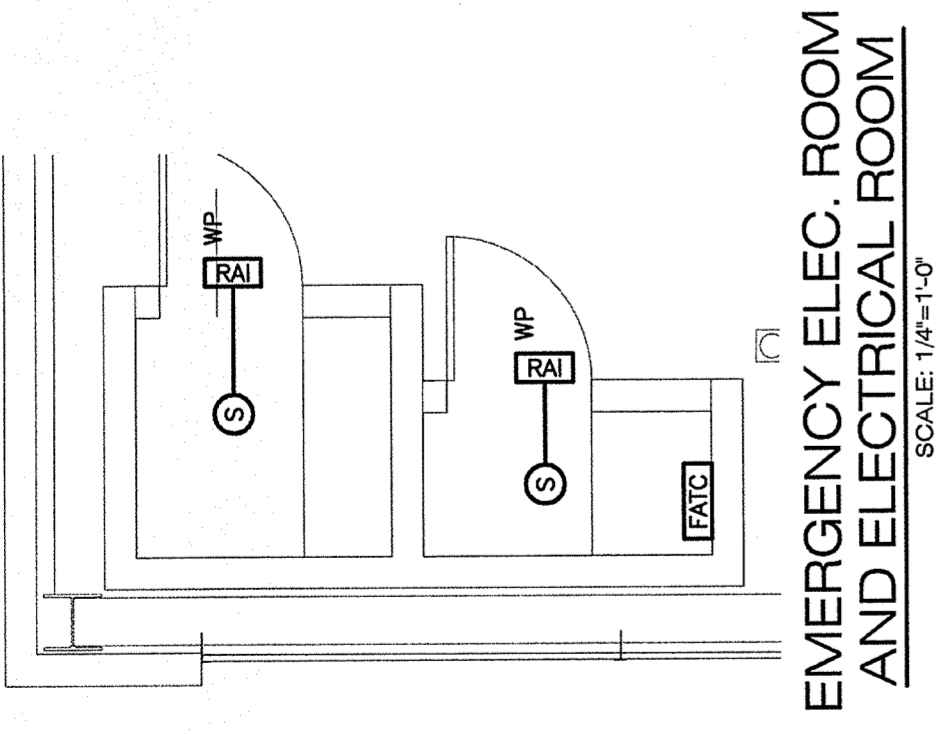

ELECTRICAL - FIRE ALARM THIRD FLOOR PLAN
 SCALE: 1/8"=1'-0"

