


- NOTES:**
- THIS PROJECT INCLUDES THE USE OF A CARTRIDGE FILTER TREATMENT UNIT TO TREAT ROOF STORMWATER RUNOFF PRIOR TO DISCHARGE TO THE SUBSURFACE CHAMBER SYSTEM. THE LOCATION OF THE CARTRIDGE TREATMENT UNIT IS UNKNOWN AT THE TIME OF PERMITTING, AND SHALL BE ADDED TO THE PLANS PRIOR TO CONSTRUCTION.
 - THE EXACT LOCATION OF THE UNITIL GAS MAIN CONNECTION IN MIDDLE STREET IS UNDETERMINED.
 - A 1,000 GALLON GREASE TANK SHALL BE INCLUDED IN THE PROJECT PRICING. THE LOCATION OF THE GREASE TANK HAS NOT YET BEEN DETERMINED.


① APPROXIMATE UNDERGROUND UTILITY LOCATIONS BASED UPON OCEAN GATEWAY PARKING GARAGE PLANS PREPARED BY WOODARD & CURRAN, DATED FEB. 2007.

SANITARY SEWER STRUCTURE APPURTENANCE SCHEDULE			
STRUCTURE I.D.	RIM	INV. IN (SIZE) / FROM	INV. OUT (SIZE) / TO
SMH 1	23.25	16.00 (8") / BLDG. 16.30 (6") / GREASE TRAP	15.90* (8") / EX. SMH
GREASE TRAP	23.50	17.25 (4") / BLDG.	17.00 (6") / SMH 1

* MATCH EXISTING SEWER STUB INVERTS - TEST PIT TO VERIFY PRIOR TO ORDERING STRUCTURE.

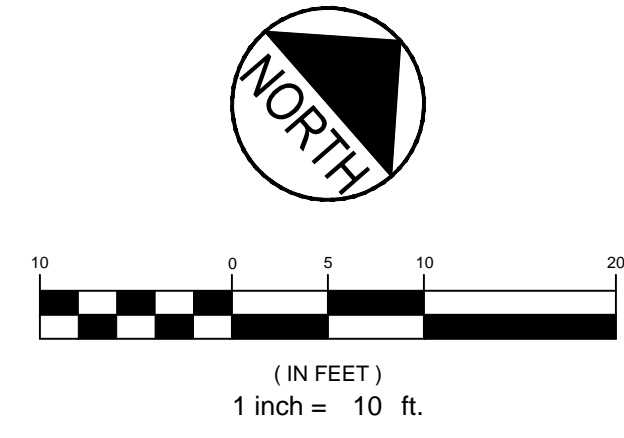

REV	DATE	DESCRIPTION
9	06.03.16	ISSUED FOR CONSTRUCTION
8	05.20.16	90% CD PACKAGE
7	02.15.16	50% CD PACKAGE
6	04.15.15	REVISED PER STAFF COMMENTS & RESUBMITTED TO CITY
5	02.06.15	SUBMITTED FINAL SITE PLAN APPLICATION TO CITY
4	07.22.14	REVISED GAS AND WATER SERVICE LOCATIONS TO AVOID CONFLICT WITH BUILDING STRUCTURE
3	07.08.14	REVISED PER ENGINEERING PEER REVIEW COMMENTS AND RESUBMITTED TO CITY
2	06.12.14	REVISED PER PLANNING REVIEW STAFF COMMENTS AND RESUBMITTED TO CITY
1	05.05.14	SUBMITTED TO CITY
REV	DATE	DESCRIPTION

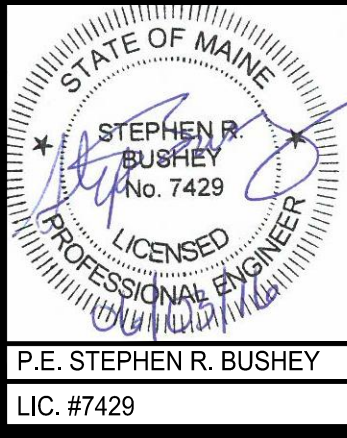

PROJECT
**16 MIDDLE STREET
PORTLAND, MAINE**

SHEET TITLE
UTILITY PLAN

CLIENT
**16 MIDDLE STREET
ASSOCIATES LLC**

FST 100 YEARS
FAY, SPOFFORD & THORNDIKE
ENGINEERS • PLANNERS • SCIENTISTS
778 MAIN ST, SUITE 8, SOUTH PORTLAND, ME 04106

DRAWN: CDD	DATE: MAY 2014
DESIGNED: SRB	SCALE: 1" = 10'
CHECKED: SRB	JOB NO. 195350140
FILE NAME: SP-M150-UTILITY PLAN	
SHEET C-5.0	