



LIGHTING WORK NOTES

- ⊕ FIXTURE SHALL BE MOUNTED HORIZONTALLY.
- ⊙ COORDINATE MOUNTING HEIGHT WITH ARCHITECT PRIOR TO ROUGH-IN.

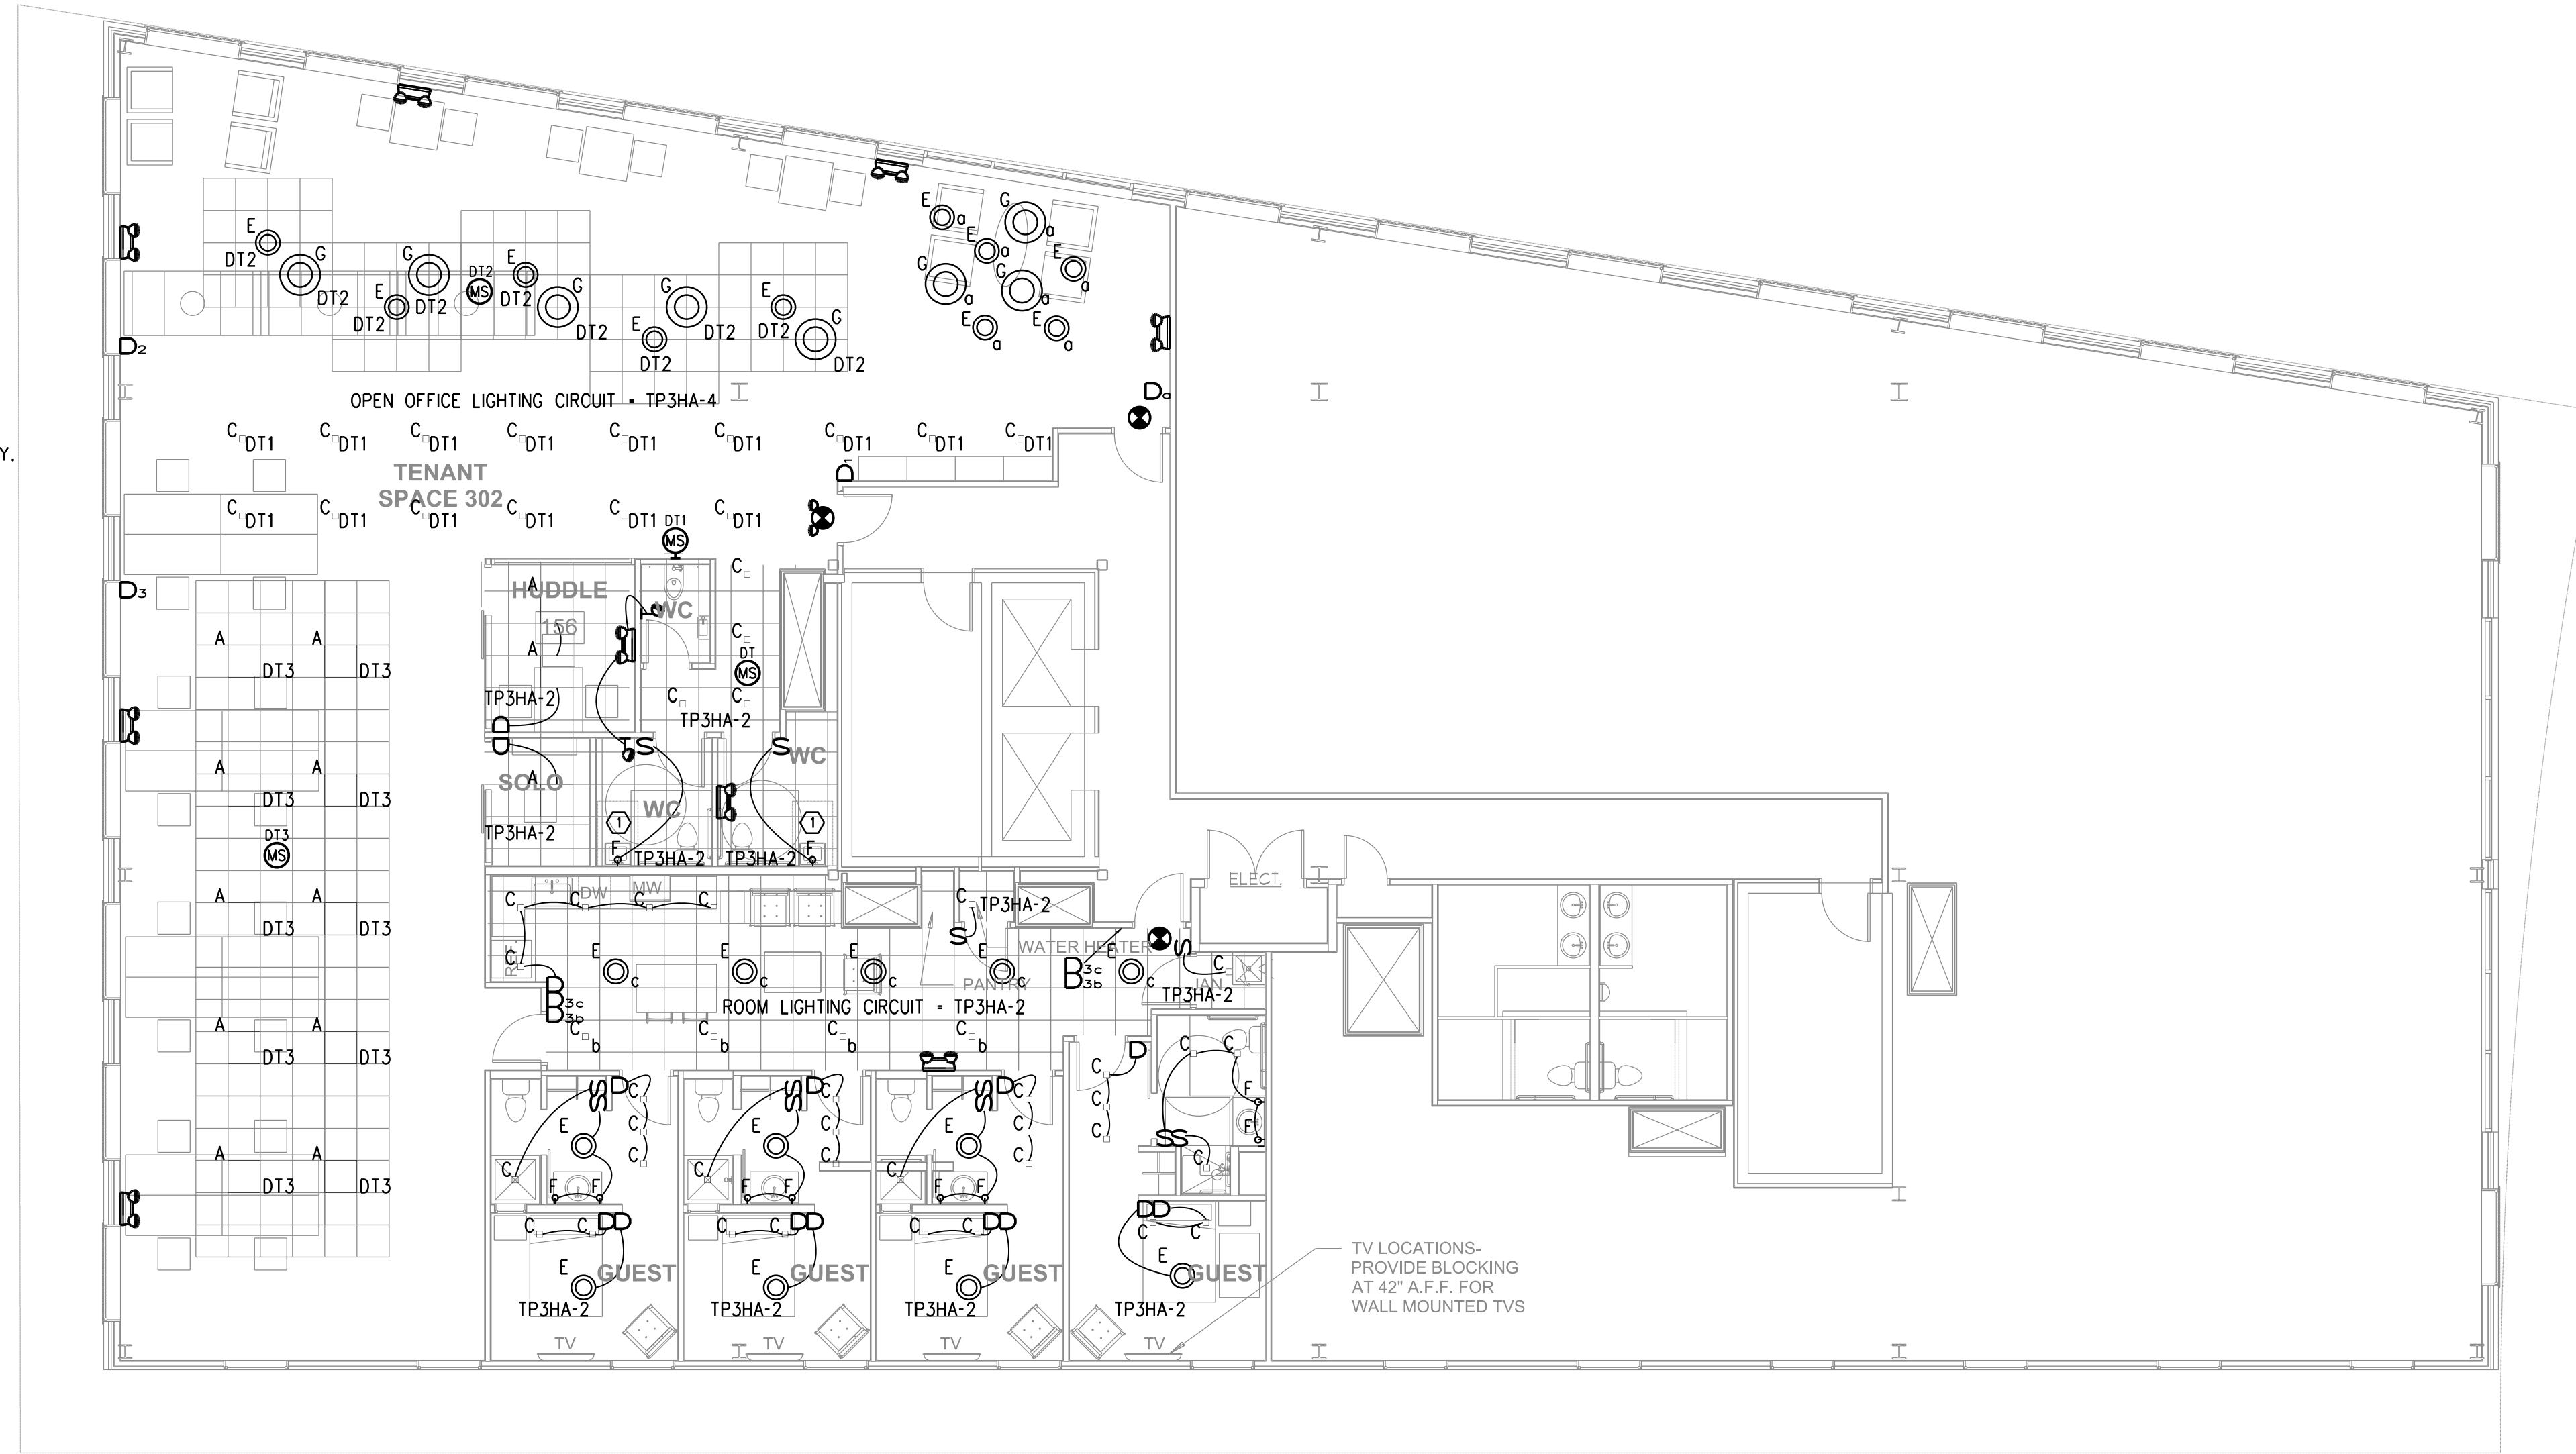


THIRD FLOOR PLAN
SCALE: 1/8" = 1'-0"

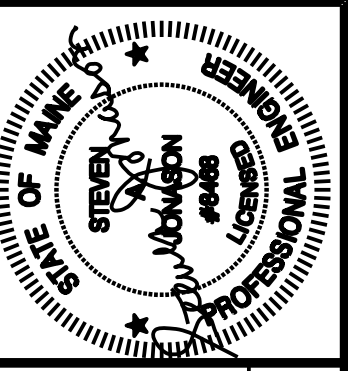

Prepared For: **Archetype**

Union Wharf
Portland, ME 04101

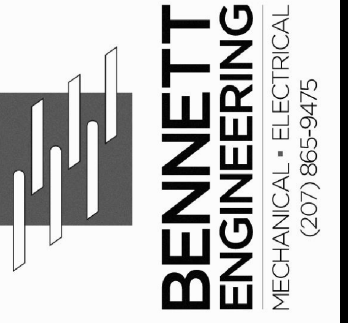

Consultant:



Project: **16 MIDDLE STREET OFFICE BUILDING**
MIDDLE STREET
PORTLAND, MAINE

Revisions:
02/20/2017: CD ISSUE

Date: **20 FEB 2017**
Scale: **1/8" = 1'-0" U.N.O.**
TILSON TECHNOLOGIES:
THIRD FLOOR LIGHTING PLAN

E1.01