



LIGHTING WORK NOTES
 1. FIXTURE SHALL BE MOUNTED HORIZONTALLY.
 2. COORDINATE MOUNTING HEIGHT WITH ARCHITECT PRIOR TO ROUGH-IN.

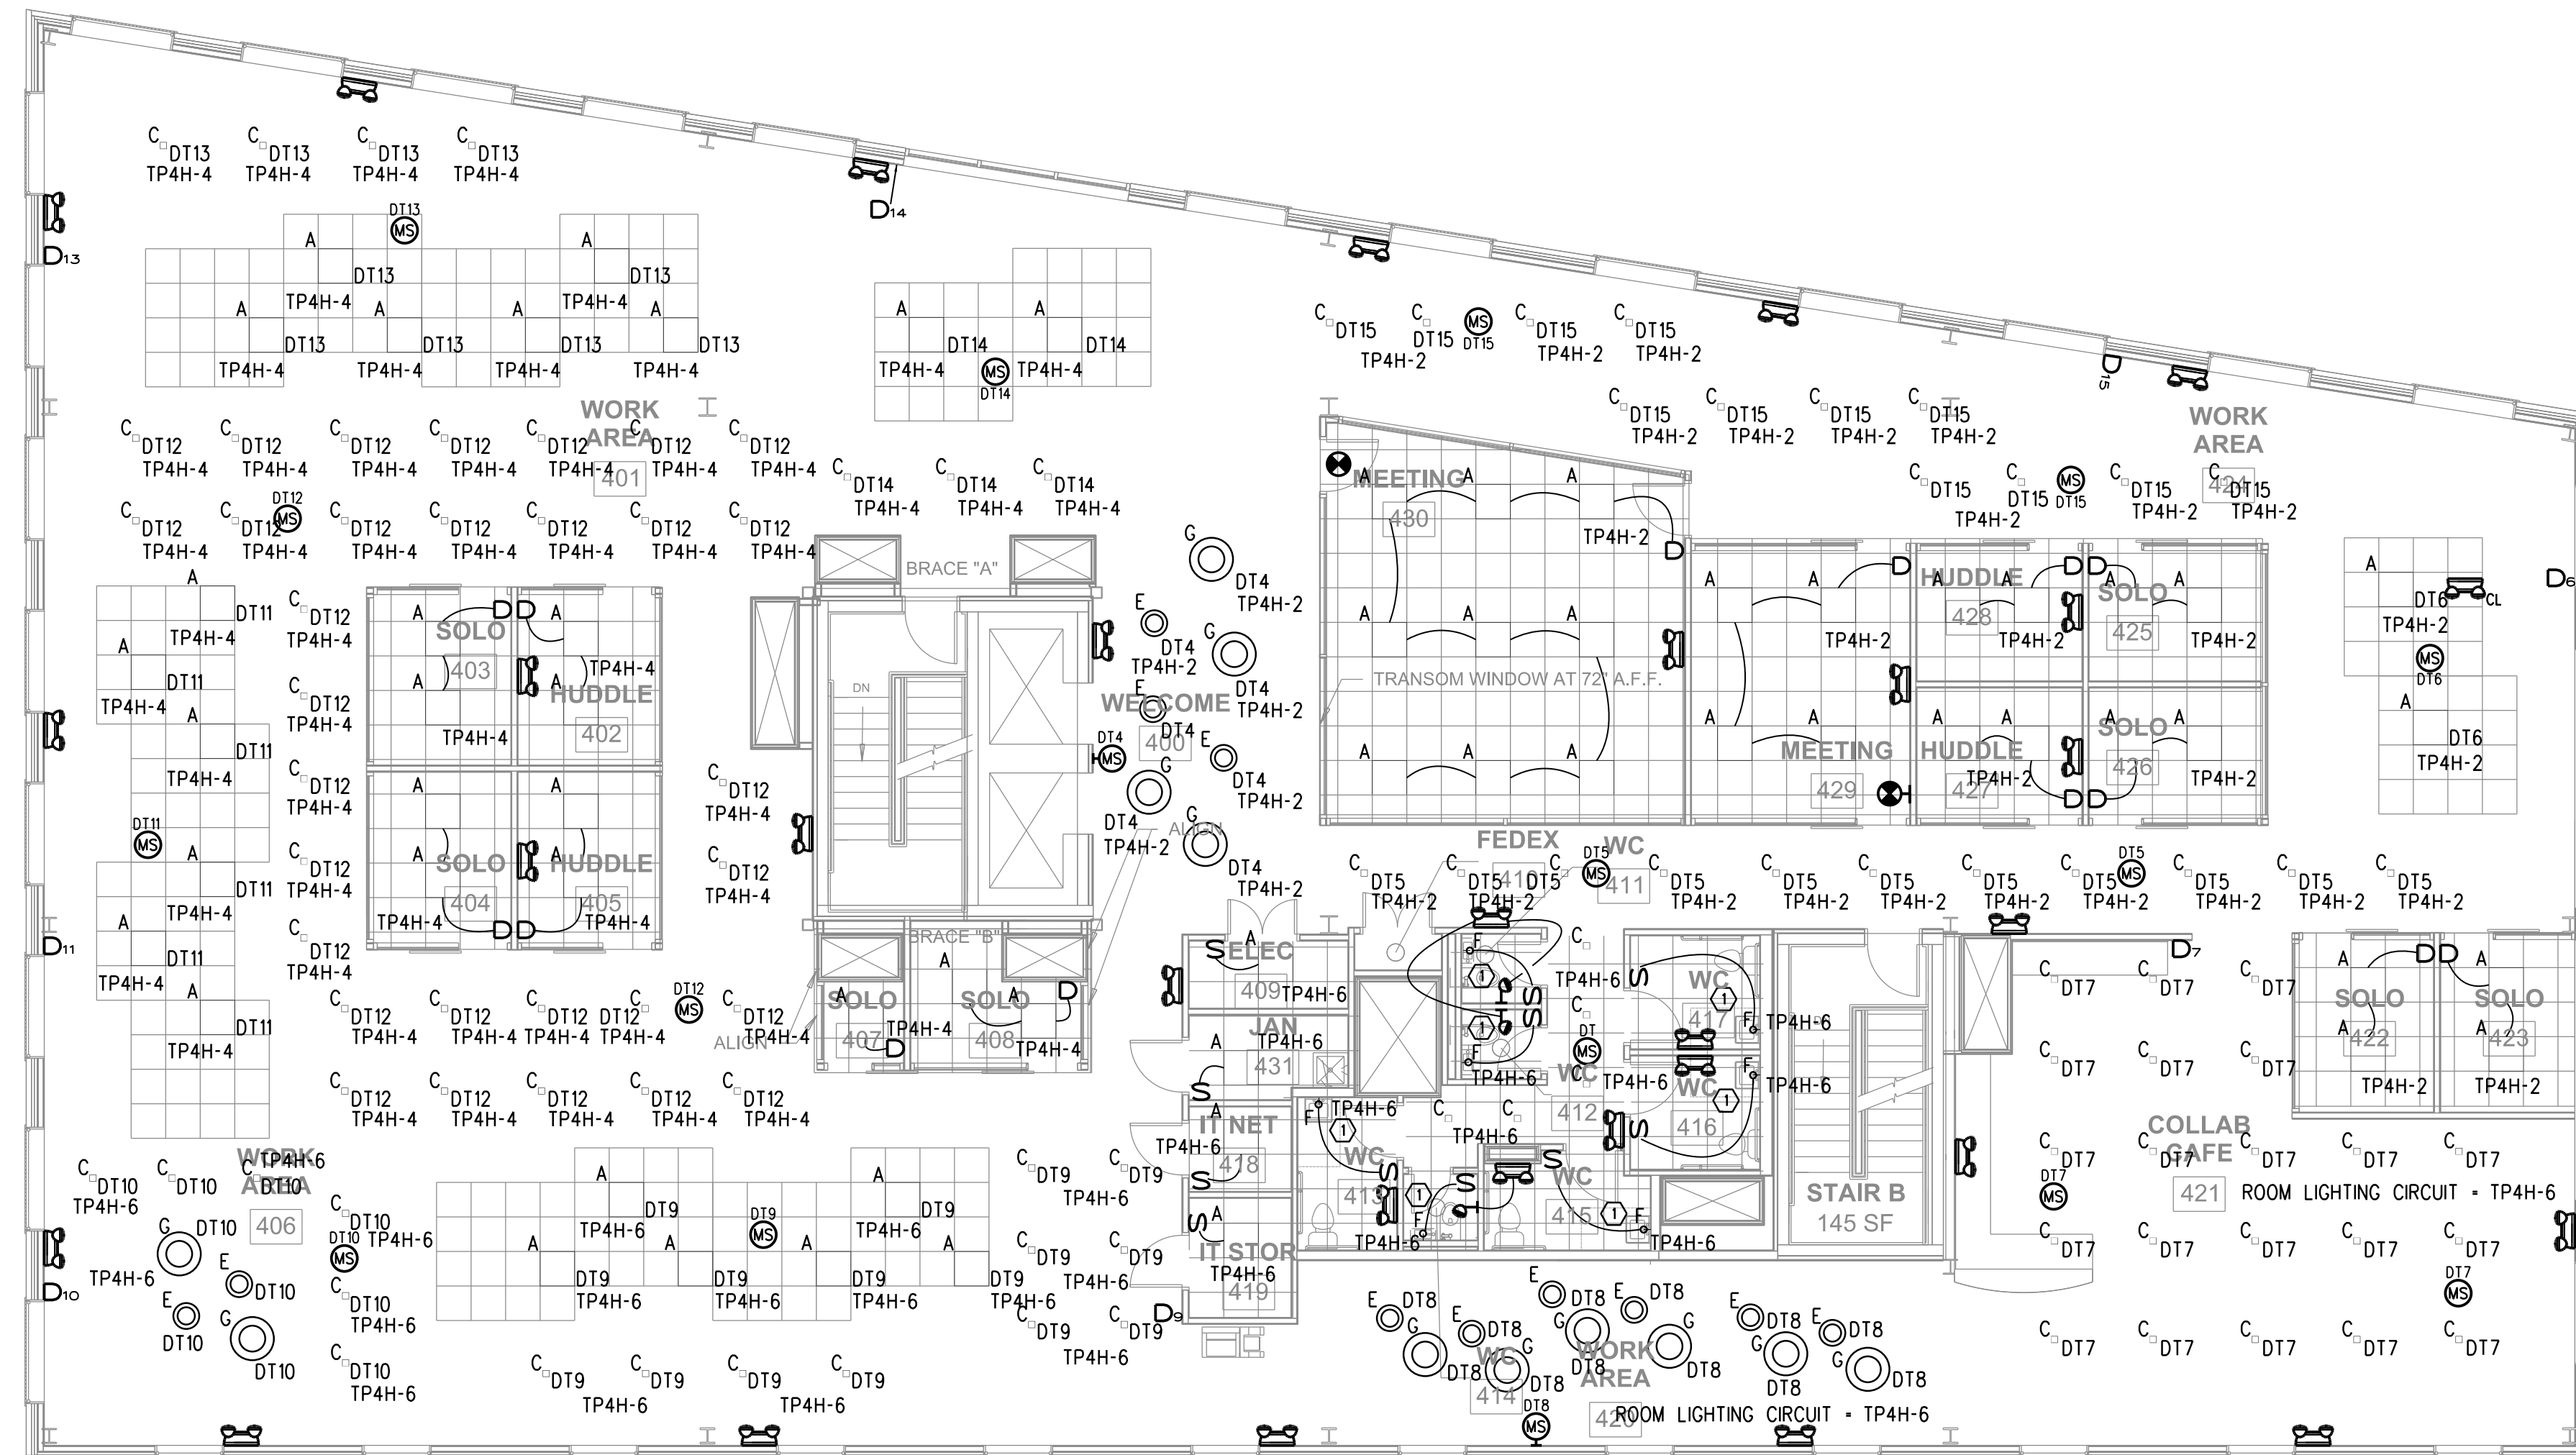


FOURTH FLOOR PLAN
 SCALE: 1/8" = 1'-0"

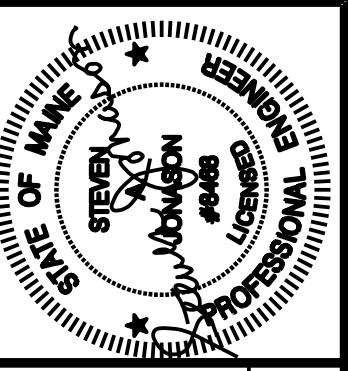

Prepared For: **Archetype**

Union Wharf
 Portland, ME 04101

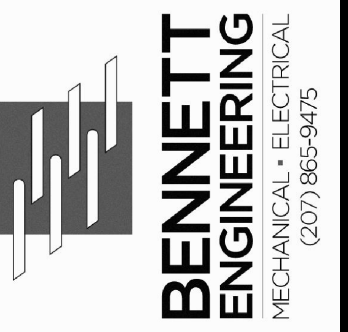

Consultant:



Project: **16 MIDDLE STREET OFFICE BUILDING**

MIDDLE STREET
 PORTLAND, MAINE

Revisions:
 02/20/2017: CD ISSUE

Scale: 1/8" = 1'-0" U.N.O.

Date: 20 FEB 2017

TILSON TECHNOLOGIES:
 FOURTH FLOOR LIGHTING PLAN

E1.02