


Room Summary	
Room Name	Wall Ht.
425	10
426	10
427	10
428	10
429	10
430	10
COLAB	10
CORR	10
CORR 2	8
IT	8
IT NET	8
JAN	8
OPEN OFFICE	10
STOR	8
WORK AREA 424	10

Calculation Summary					
Room Name	Avg	Max	Min	Avg/Min	Max/Min
425_Workplane	32.87	53.5	18.4	1.79	2.91
426_Workplane	33.16	55.3	18.9	1.75	2.93
427_Workplane	33.60	55.3	19.2	1.75	2.88
428_Workplane	33.59	54.7	19.1	1.76	2.86
429_Workplane	62.59	78.3	36.1	1.73	2.17
430_Workplane	72.25	95.1	41.1	1.76	2.31
COLAB_Workplane	18.75	38.3	4.0	4.69	9.58
CORR 2_Floor	12.26	14.4	8.5	1.44	1.69
CORR_Floor	7.70	8.7	4.8	1.60	1.81
IT NET_Floor	35.78	39.6	33.2	1.08	1.19
IT_Floor	32.22	37.0	27.6	1.17	1.34
JAN_Floor	28.27	37.3	17.3	1.63	2.16
OPEN OFFICE_Workplane	82.80	86.0	3.9	8.41	22.05
STOR_Floor	30.29	35.7	22.9	1.32	1.56
WORK AREA 424_Workplane	16.53	60.0	1.9	8.70	31.58

Luminaire Schedule (note fixture catalogue numbers are not complete)					
Tag	Symbol	Lumens	LLF	Lum. Watts	Description
A	□	4764	0.900	40.46	PLD-22-40W-40
C	□	680	0.900	10.39	LBSQ5LEDA6L30K9_WH
E	○	2763	0.900	43.4	32L-R20-C1_C1-35K-R275
G	○	2874	0.900	42.7	32L-R30-C1_C1-35K-R285

- NOTES:
- 1) EXACT MOUNTING DETAILS TO BE DETERMINED AT JOBSITE BY OTHERS.
 - 2) CALCULATIONS MAY SHOW THE EFFECT OF SHADOWING CAUSED BY BUILDINGS AND OBJECTS WITHIN THE CALCULATED SPACE OR IN THE SITE AREA.
 - 3) READINGS SHOWN ARE INITIAL HORIZONTAL FOOTCANDLES TAKEN AS SHOWN IN CALCULATION SUMMARY UNLESS OTHERWISE INDICATED.
 - 4) THIS CALCULATION IS BASED ON LIMITED INFORMATION SUPPLIED BY OTHERS TO SWANEY LIGHTING ASSOCIATES AND STANDARD ASSUMPTIONS OF THE SPACE AND/OR SITE.
 - 5) CONFORMANCE TO CODES AND OTHER LOCAL REQUIREMENTS AS DETERMINED BY THE AHJ ARE THE RESPONSIBILITY OF THE OWNER AND/OR THE OWNER'S REPRESENTATIVE.
 - 6) THIS LAYOUT DRAWING MUST BE COORDINATED WITH THE SITE LOCATION FOR CORRECT FIXTURE ORIENTATION.
 - 7) DOCUMENTS PRINTED OR PLOTTED FROM ELECTRONIC FILES MAY OCCUR AT OTHER THAN THE DESIRED OR ASSUMED GRAPHIC SCALES. IT IS THE RESPONSIBILITY OF THE RECIPIENT TO VERIFY THAT THE PRINTED OR PLOTTED-TO-SCALE DRAWING IS PRINTED TO SCALE.

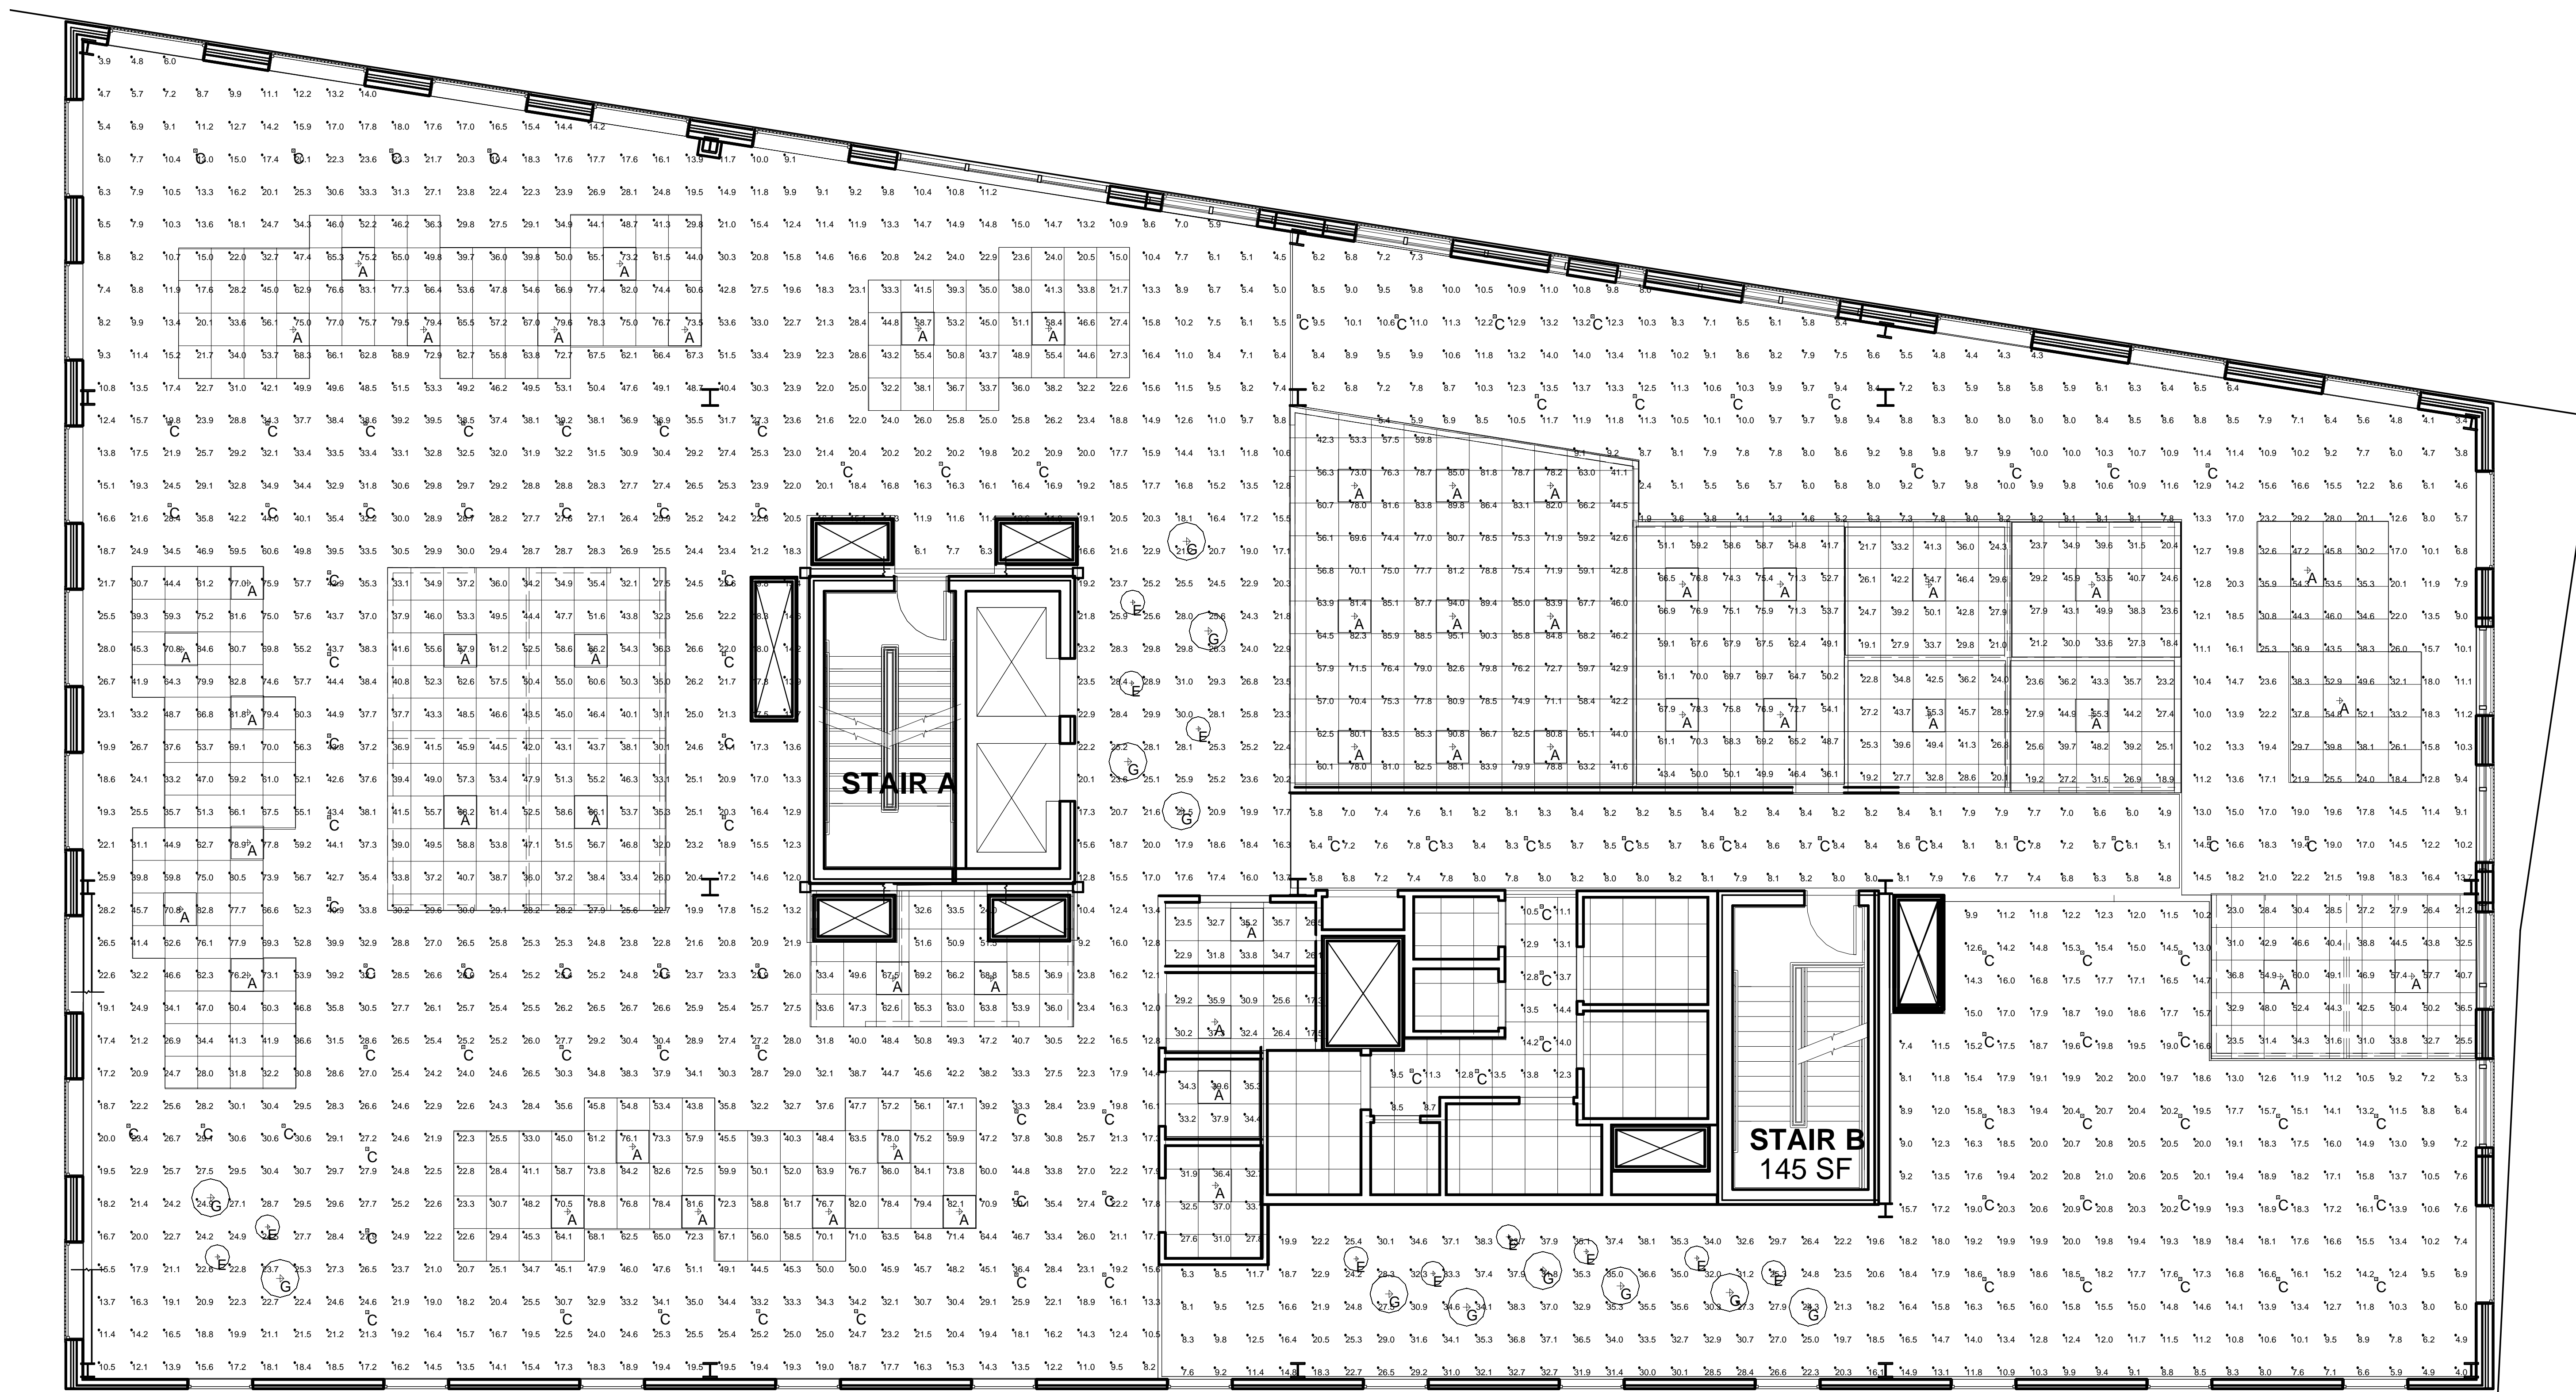

PLAN VIEW

GENERATED FOR: ARCHETYPE
 SCALE: AS SHOWN
 REF. NO.:
 DATE: 2/15/2017
 Page 1 of 1
 GENERATED BY SWANEY LIGHTING, SCARBOROUGH ME - 207-883-7100 - swaneylighting.com
 PRELIM 4th FLR.AGI

3RD AND 4TH FLOOR RENOVATION
16 MIDDLE ST, PORTLAND ME
4TH FLOOR LIGHTING LAYOUT

NOTICE: THIS DRAWING IS THE EXCLUSIVE PROPERTY OF SWANEY LIGHTING ASSOCIATES. IT IS TO BE USED FOR THE PROJECT AND SITE SPECIFICALLY IDENTIFIED. THIS DRAWING IS TO BE USED FOR NO OTHER PURPOSE THAN AS DETAILED HEREIN. ANY REUSE OR MODIFICATION OF THIS DRAWING WITHOUT THE WRITTEN CONSENT OF SWANEY LIGHTING ASSOCIATES IS EXPRESSLY PROHIBITED. SWANEY LIGHTING ASSOCIATES ASSUMES NO LIABILITY FOR THE ACCURACY OF THE INFORMATION PROVIDED HEREIN. THE USER OF THIS DRAWING SHALL BE RESPONSIBLE FOR VERIFYING THE ACCURACY OF THE INFORMATION PROVIDED HEREIN. THE USER OF THIS DRAWING SHALL BE RESPONSIBLE FOR VERIFYING THE ACCURACY OF THE INFORMATION PROVIDED HEREIN. THE USER OF THIS DRAWING SHALL BE RESPONSIBLE FOR VERIFYING THE ACCURACY OF THE INFORMATION PROVIDED HEREIN.