


- NOTES:
 1) EXACT MOUNTING DETAILS TO BE DETERMINED AT JOBSITE BY OTHERS.
 2) CALCULATIONS MAY SHOW THE EFFECT OF SHADOWING CAUSED BY BUILDINGS AND OBJECTS WITHIN THE CALCULATED SPACE OR IN THE SITE AREA.
 3) READINGS SHOWN ARE INITIAL HORIZONTAL FOOTCANDLES TAKEN AS SHOWN IN CALCULATION SUMMARY UNLESS OTHERWISE INDICATED.
 4) THIS CALCULATION IS BASED ON LIMITED INFORMATION SUPPLIED BY OTHERS TO SWANEY LIGHTING ASSOCIATES AND STANDARD ASSUMPTIONS OF THE SPACE AND/OR SITE.
 5) CONFORMANCE TO CODES AND OTHER LOCAL REQUIREMENTS AS DETERMINED BY THE AHJ ARE THE RESPONSIBILITY OF THE OWNER AND/OR THE OWNER'S REPRESENTATIVE.
 6) THIS LAYOUT DRAWING MUST BE COORDINATED WITH THE SITE LOCATION FOR CORRECT FIXTURE ORIENTATION.
 7) DOCUMENTS PRINTED OR PLOTTED FROM ELECTRONIC FILES MAY OCCUR AT OTHER THAN THE DESIRED OR ASSUMED GRAPHIC SCALES. IT IS THE RESPONSIBILITY OF THE RECIPIENT TO VERIFY THAT THE PRINTED OR PLOTTED-TO-SCALE DRAWING IS PRINTED TO SCALE.

| Tag | Symbol | Lumens | LLF | Lum. Watts | Description |
|-----|--------|--------|-------|------------|------------------------|
| A | • | 4764 | 0.900 | 40.46 | PLD-22-40W-40 |
| C | • | 680 | 0.900 | 10.39 | LBSQ5LEDA6L30K9_WH |
| E | ○ | 2763 | 0.900 | 43.4 | 32L-R20-C1_C1-35K-R275 |
| G | ○ | 2874 | 0.900 | 42.7 | 32L-R30-C1_C1-35K-R285 |
| F | • | 376 | 1.000 | 8.586 | SENET 3217_LED_9 |

| Room Summary | |
|--------------|----------|
| Room Name | Wall Ht. |
| CORR 2 | 8 |
| kitchen | 8 |
| tenant space | 10 |
| TYP ENTRY | 8 |
| TYP LAV | 8 |
| TYP SLEEP | 8 |

| Calculation Summary | | | | | |
|----------------------|-------|------|------|---------|---------|
| Room Name | Avg | Max | Min | Avg/Min | Max/Min |
| CORR 2_Floor | 10.11 | 12.6 | 7.3 | 1.38 | 1.73 |
| kitchen_Floor | 21.31 | 27.0 | 12.2 | 1.75 | 2.21 |
| tenant space_Workpla | 31.43 | 92.3 | 4.0 | 7.86 | 23.08 |
| TYP ENTRY_Floor | 18.46 | 23.0 | 11.0 | 1.68 | 2.09 |
| TYP LAV_Floor | 10.40 | 11.5 | 8.9 | 1.17 | 1.29 |
| TYP SLEEP_Workplane | 18.55 | 33.7 | 9.2 | 2.02 | 3.66 |

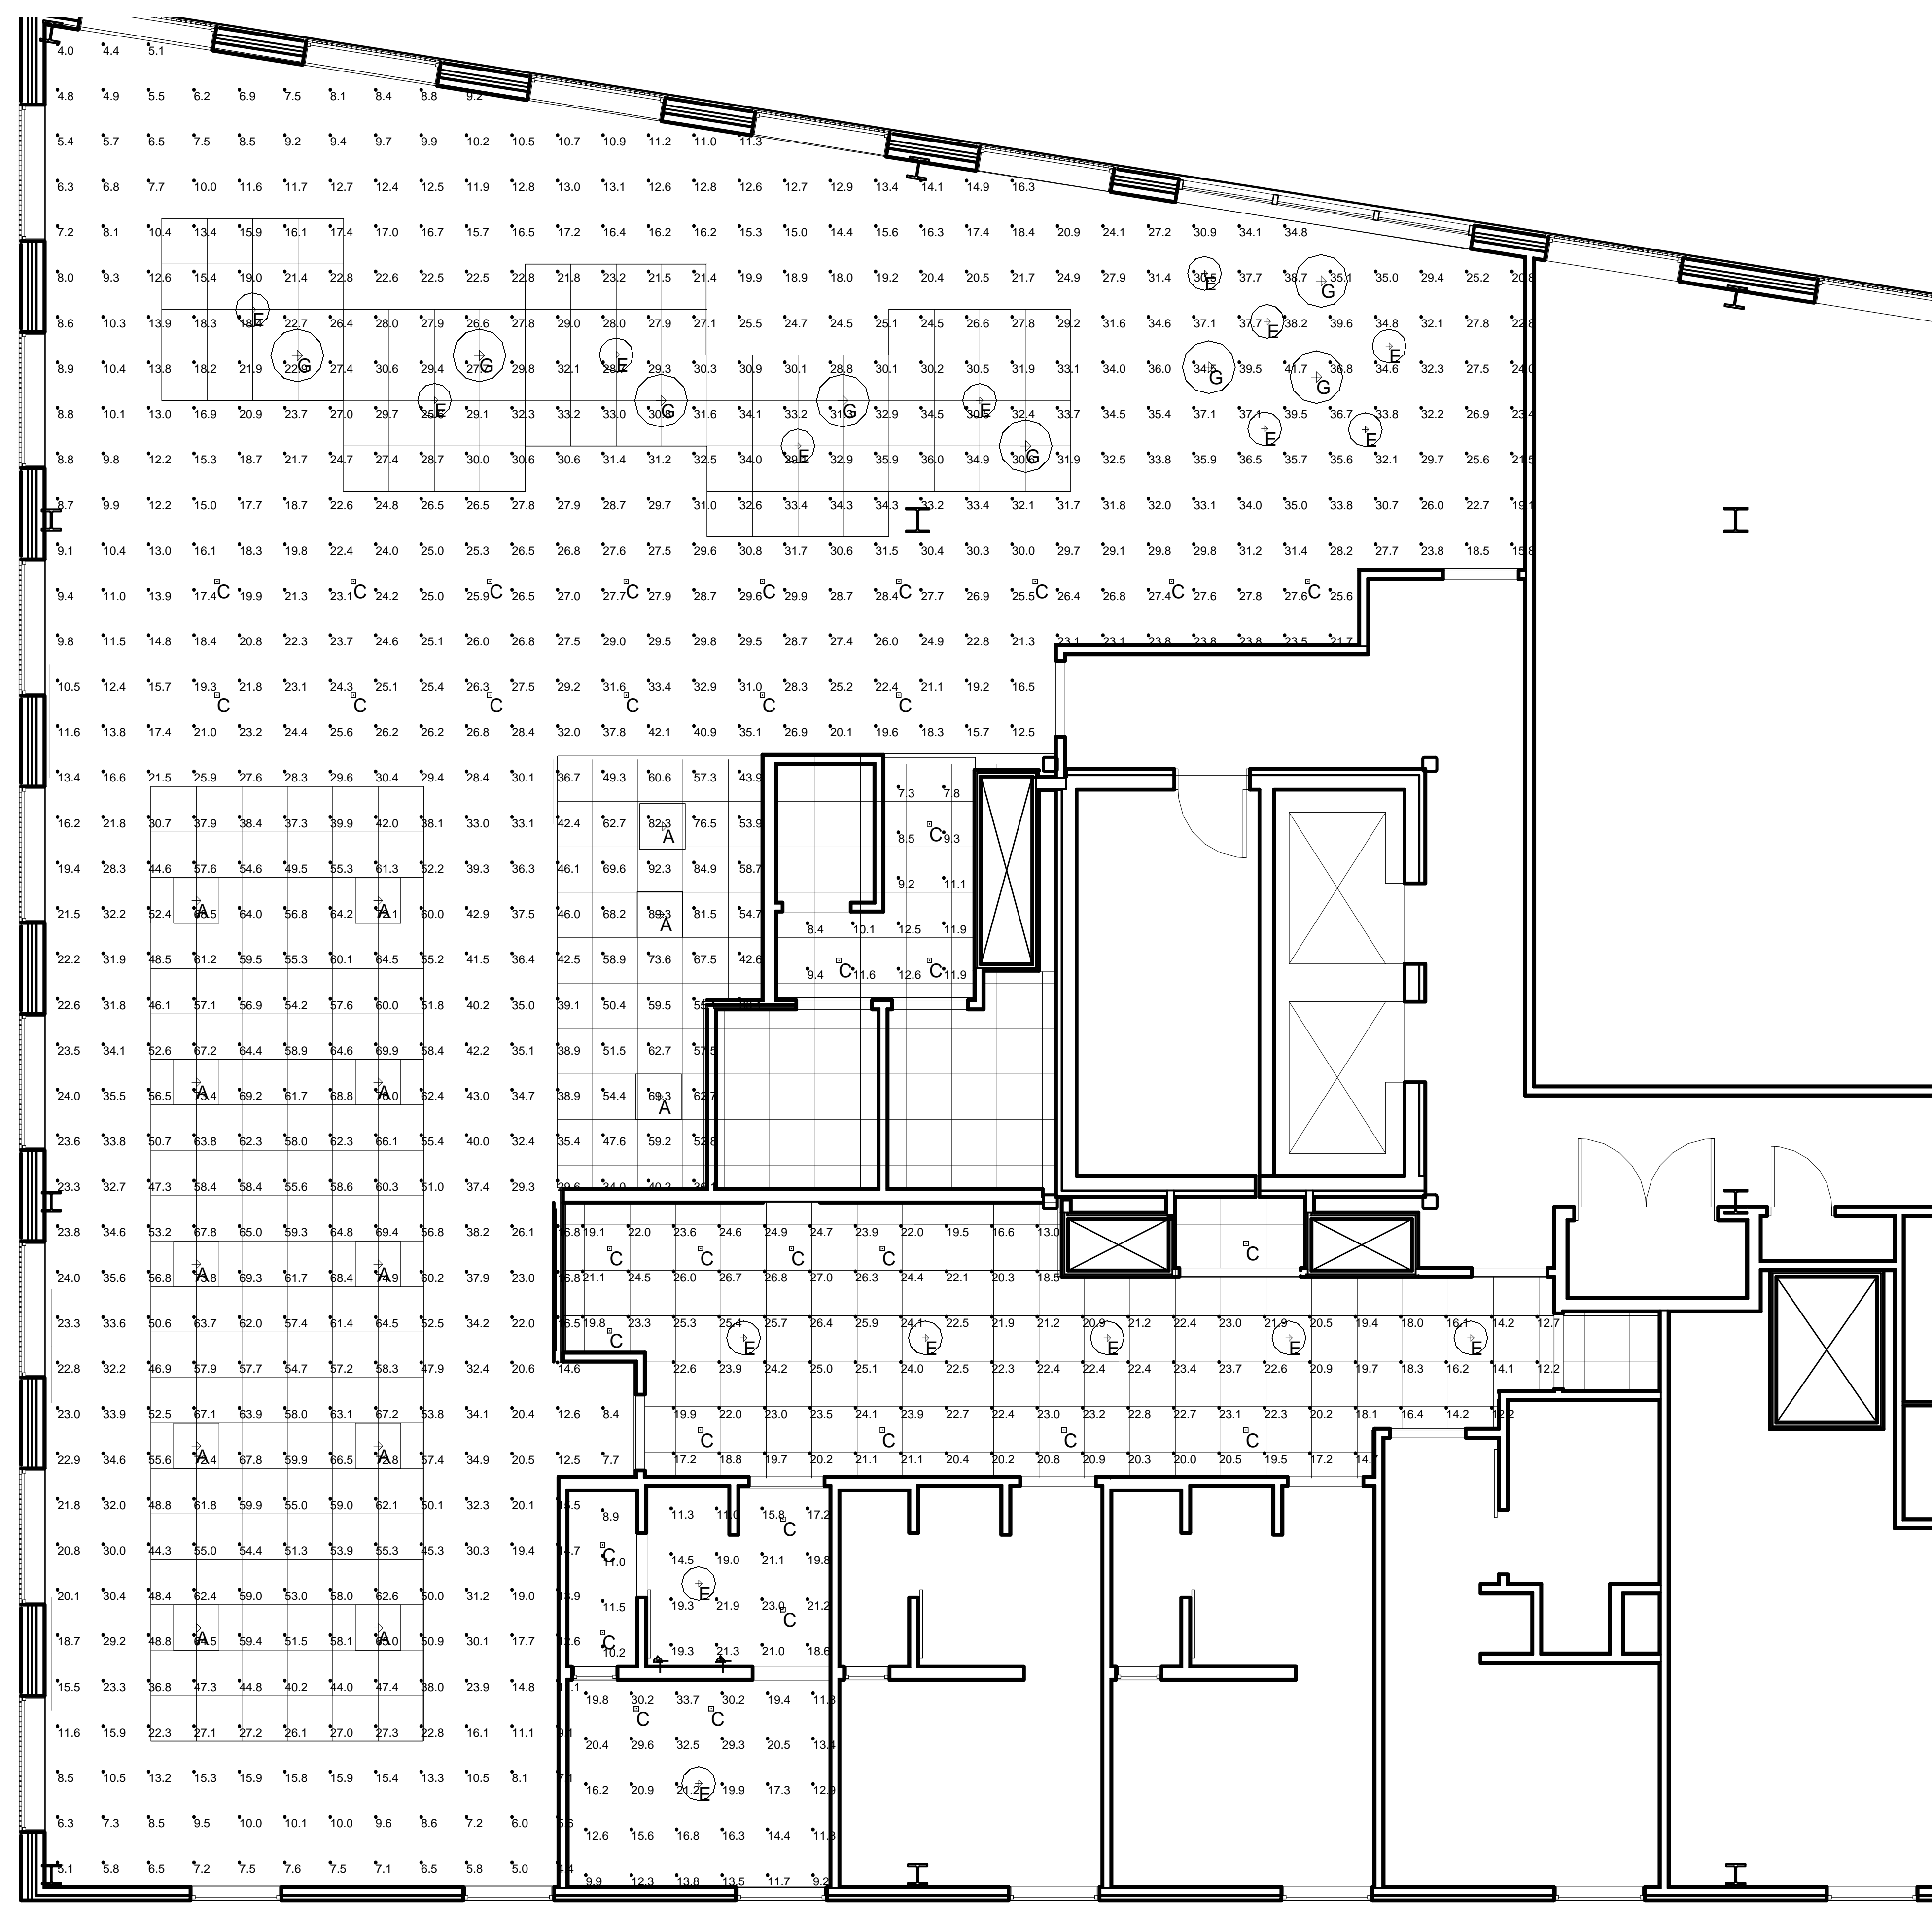

PLAN VIEW

PRELIM 3RD FLR. AGI
 GENERATED BY SWANEY LIGHTING, SCARBOROUGH ME - 207-883-7100 - swaneylighting.com
 Date: 2/15/2017
 Page 1 of 1
 REF. NO.
 SCALE AS SHOWN
 ARCHETYPE
 GENERATED FOR:
 3RD AND 4TH FLOOR RENOVATION
 16 MIDDLE ST, PORTLAND ME
 3RD FLOOR LIGHTING LAYOUT
 TITLE

NOTICE: THIS DRAWING IS THE EXCLUSIVE PROPERTY OF SWANEY LIGHTING ASSOCIATES. INFORMATION CONCERNING THE OPERATION OF UNITS INDICATED, THIS DRAWING IS TO BE CONSIDERED CONFIDENTIAL. THIS DRAWING IS TO BE USED FOR NO PURPOSE OTHER THAN AS DETAILED AS EXPRESSLY AUTHORIZED BY SWANEY LIGHTING ASSOCIATES. NOTICE: THE INTENT OF THIS LIGHTING LAYOUT IS TO SUGGEST THE BEST UTILIZATION FURNISHED BY THE MANUFACTURER. ANY VARIATION IN FUTURE PERFORMANCE FROM OTHER PURPOSES IS NOT AUTHORIZED BY SWANEY LIGHTING ASSOCIATES.