



Prepared For:

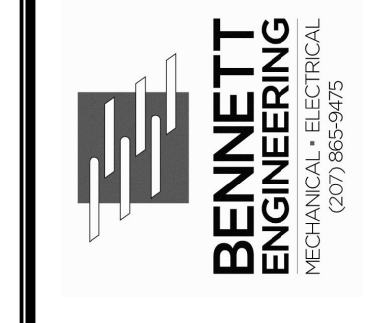

Consultant:

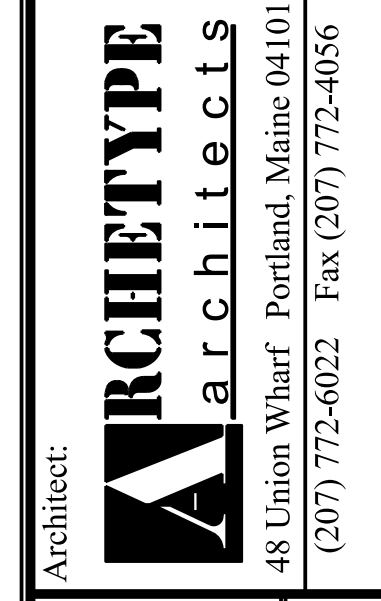

Project:


185 FORE STREET

Revisions: 06-11-15 ADDENDUM #1


Date: 22 May, 2015 Scale: As indicated

FIRST FLOOR POWER PLAN

E2.1

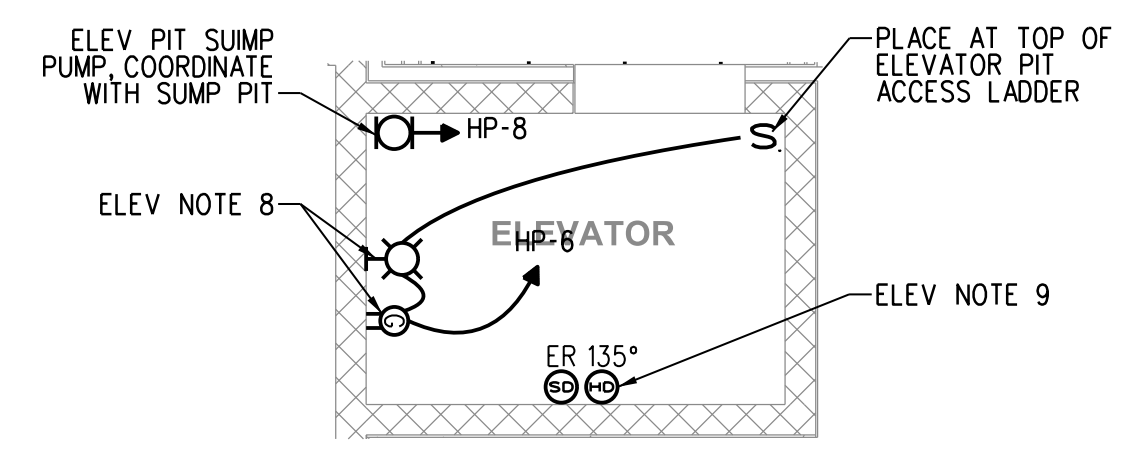

ELEVATOR PIT DETAIL
SCALE: 1/4" = 1'-0"
REFER TO DRAWING E3.0 FOR ELEVATOR NOTES

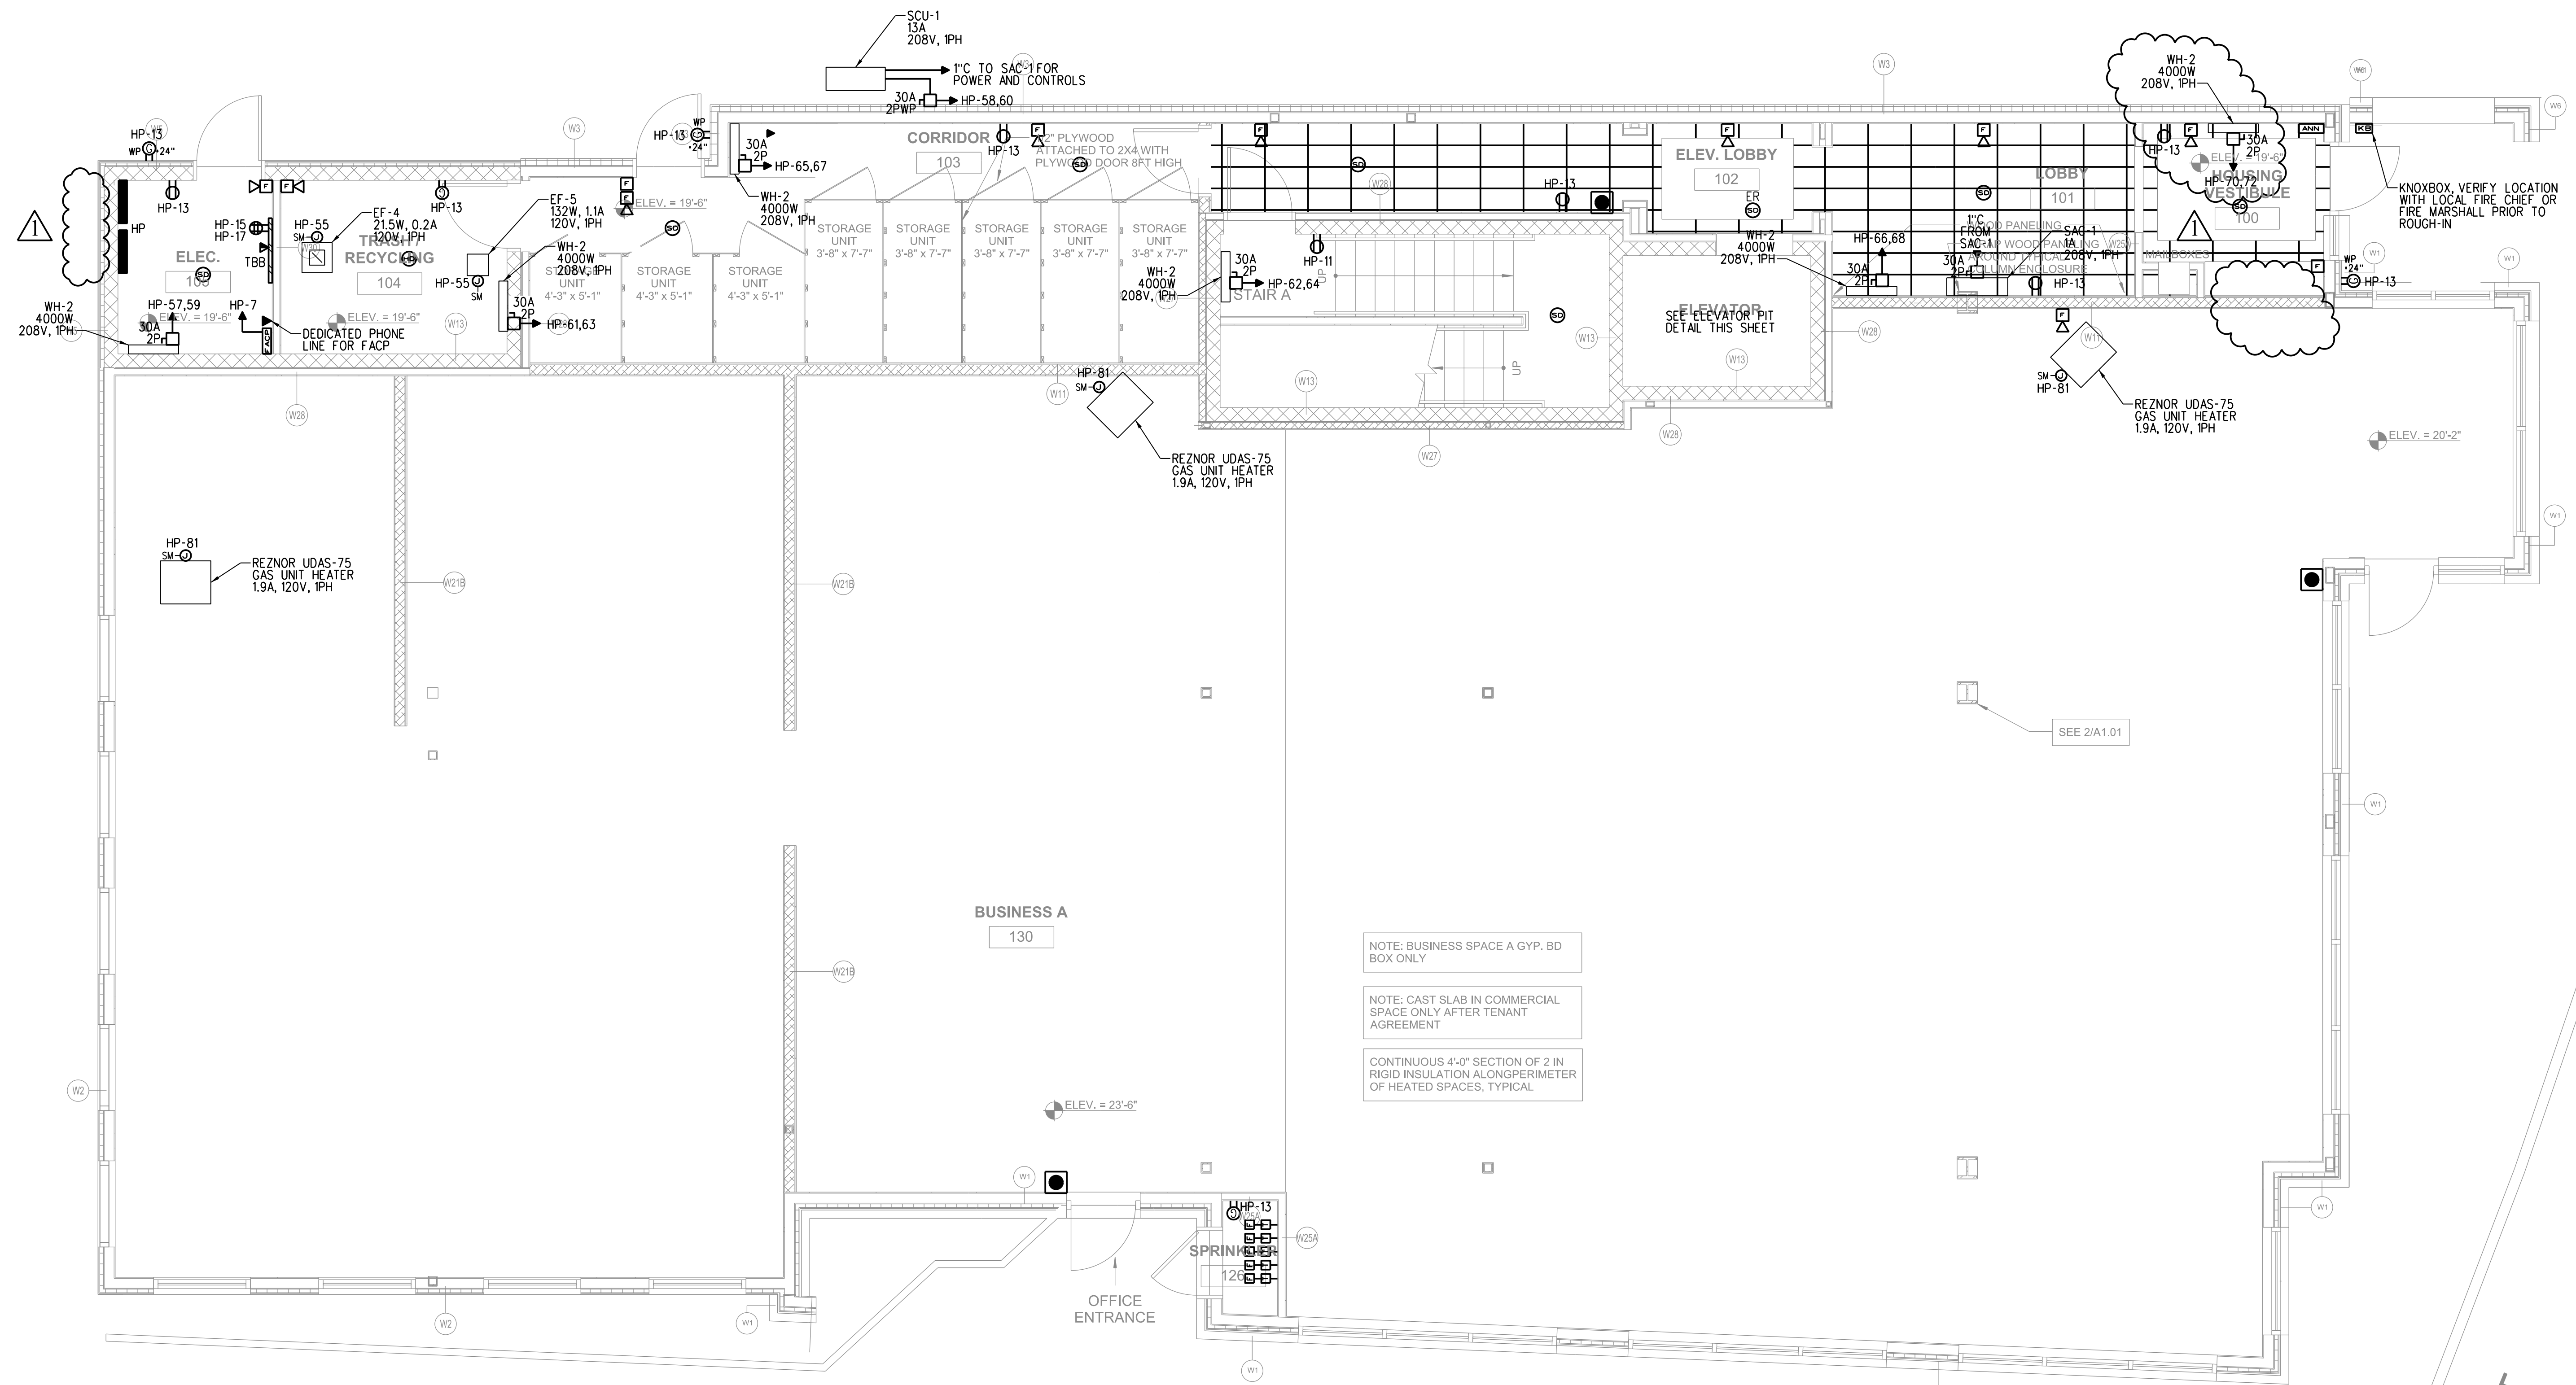

FIRST FLOOR POWER PLAN
SCALE: 1/4" = 1'-0"

INDIA STREET

FORE STREET

POWER KEY NOTES

- ① COORDINATE RECEPTACLE HEIGHT WITH ARCHITECTURAL CASEWORK
- ② COORDINATE LOCATIONS OF CEILING MOUNTED POWER POLE AND TEL/DATA J-BOXES WITH OWNER PRIOR TO ROUGH-IN.