


Prepared For:



Consultant:

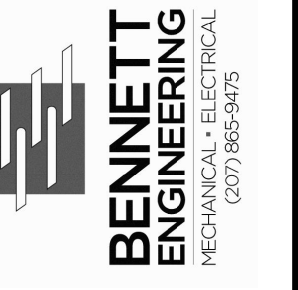

Architect:

185 FORE STREET
Portland, Maine

Project:


06-11-15 ADDENDUM #1

Revisions:

Date: 22 May, 2015
Scale: As indicated

FOURTH FLOOR
POWER PLAN

E2.4

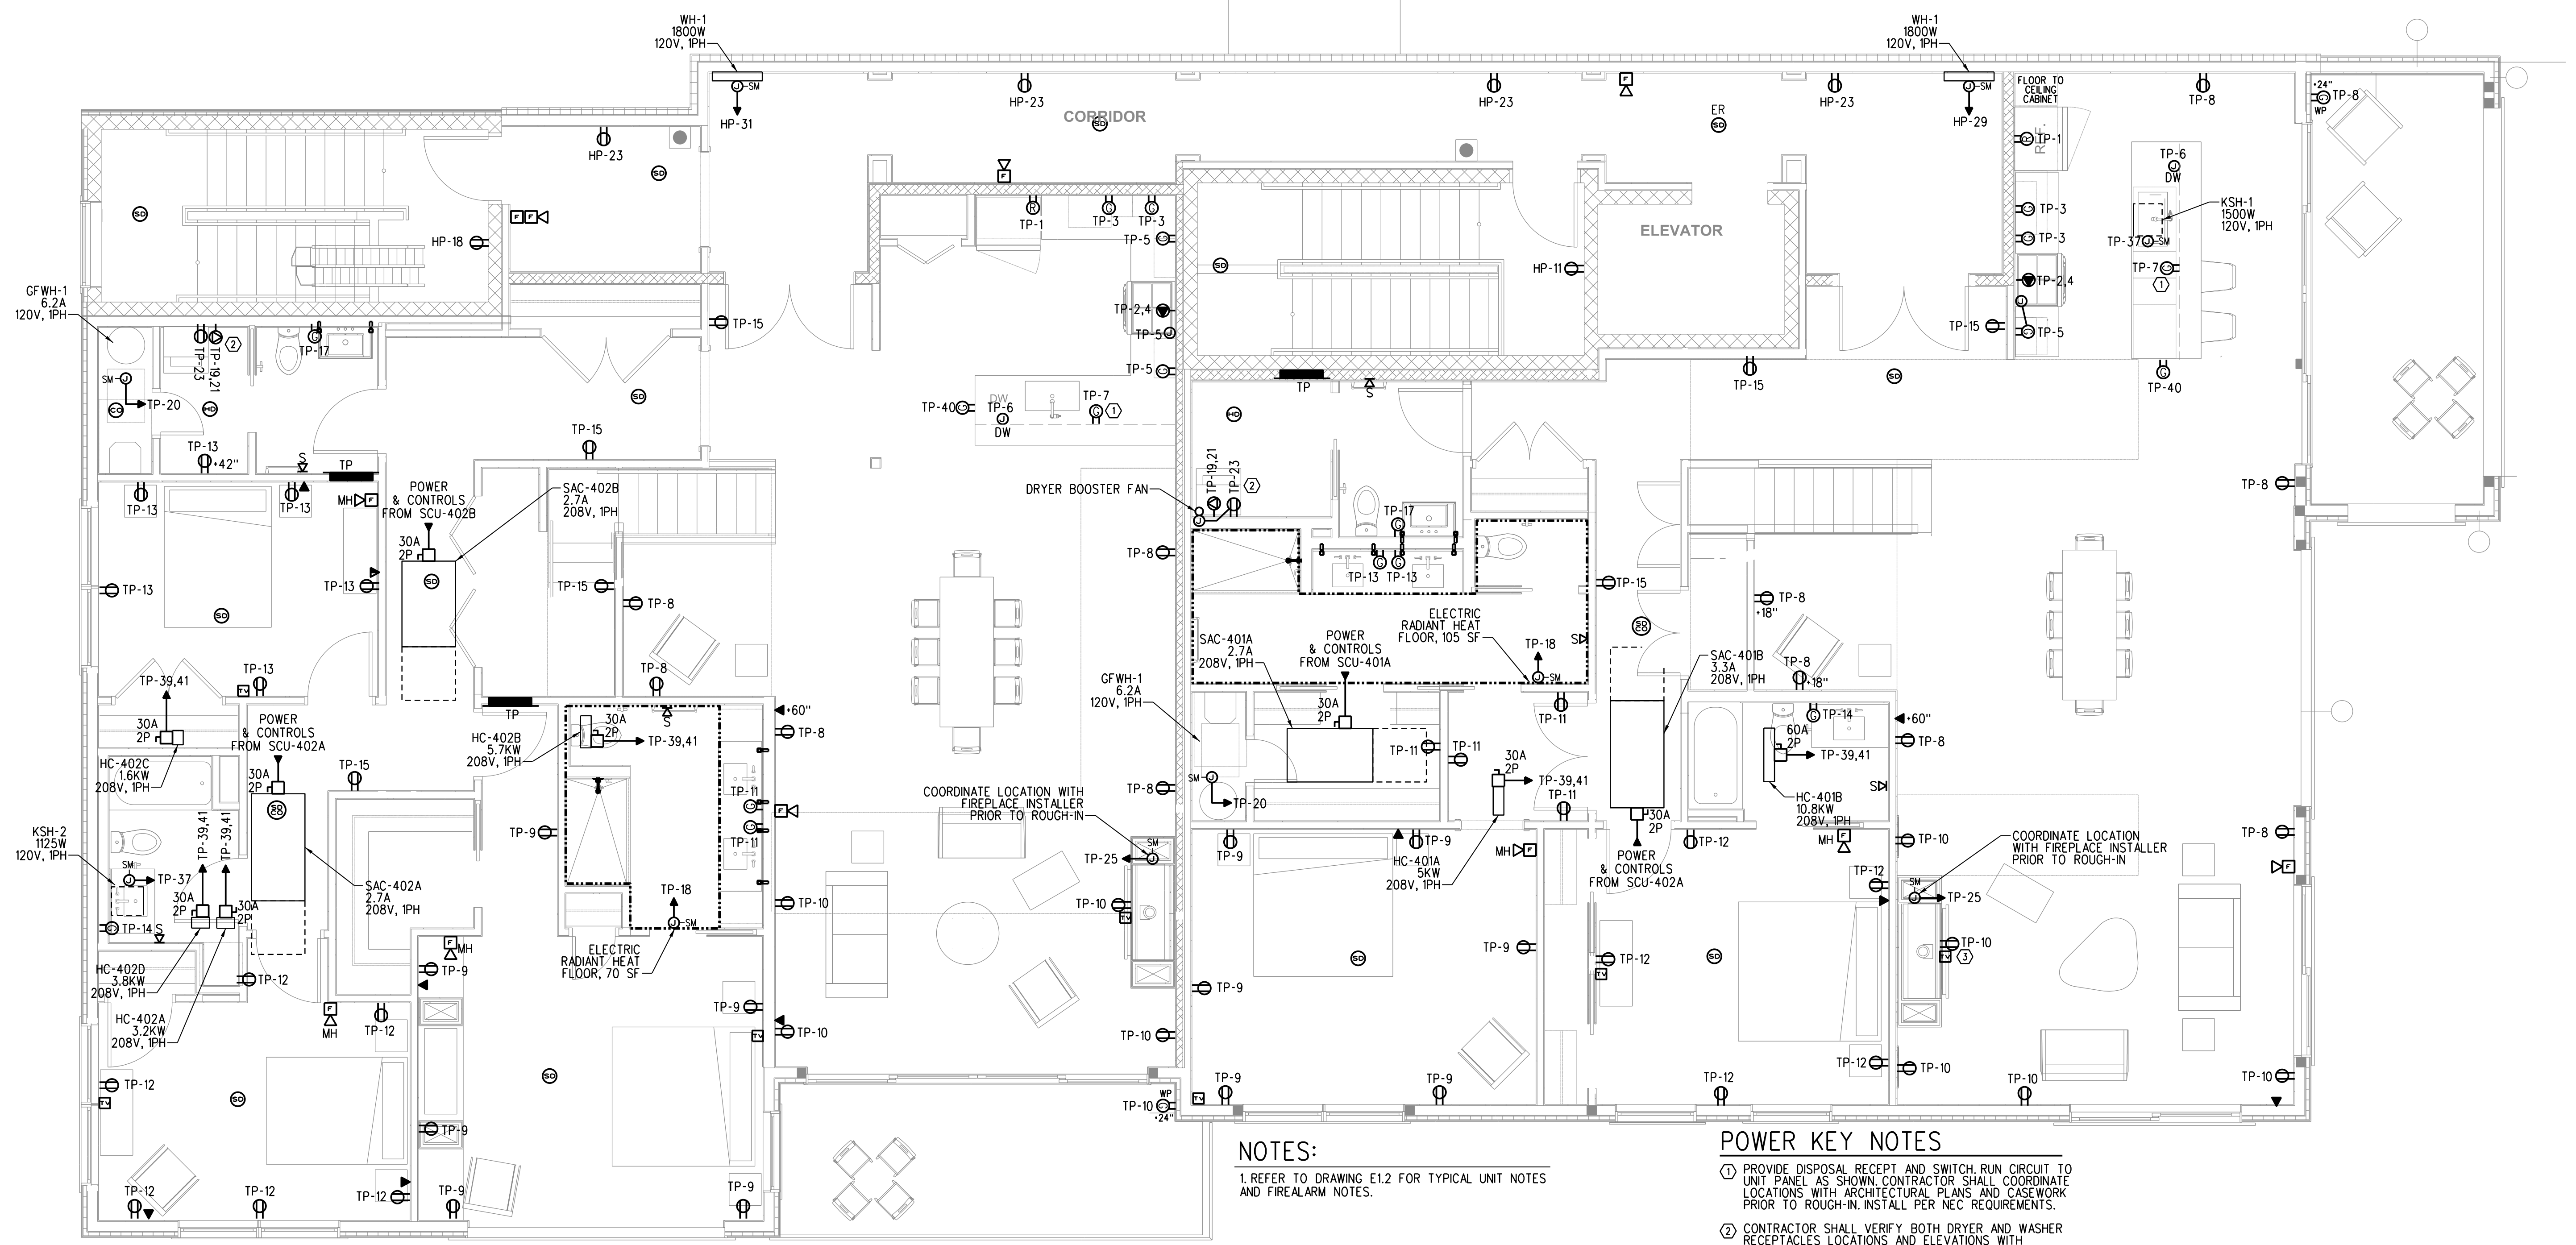

NOTES:
1. REFER TO DRAWING E1.2 FOR TYPICAL UNIT NOTES AND FIREALARM NOTES.

POWER KEY NOTES
① PROVIDE DISPOSAL RECEIPT AND SWITCH. RUN CIRCUIT TO UNIT PANEL AS SHOWN. CONTRACTOR SHALL COORDINATE LOCATIONS WITH ARCHITECTURAL PLANS AND CASEWORK PRIOR TO ROUGH-IN. INSTALL PER NEC REQUIREMENTS.
② CONTRACTOR SHALL VERIFY BOTH DRYER AND WASHER RECEPTACLES LOCATIONS AND ELEVATIONS WITH EQUIPMENT PRIOR TO ROUGH-IN.
③ CONTRACTOR SHALL VERIFY TV AND POWER RECEPTACLES ELEVATION WITH ARCHITECT PRIOR TO ROUGH-IN.

FOURTH FLOOR POWER PLAN
SCALE: 1/4" = 1'-0"