


Prepared For:



Consultant:

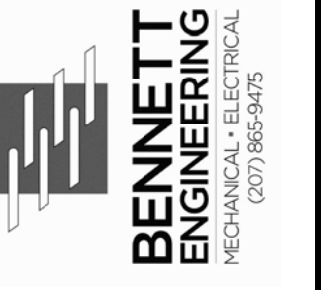

Architect:

185 FORE STREET
Portland, Maine


Project:

06-11-15 ADDENDUM #1

Revisions:

Date: 22 May, 2015
Scale: As indicated
FOURTH FLOOR
MECHANICAL PLAN

M1.04

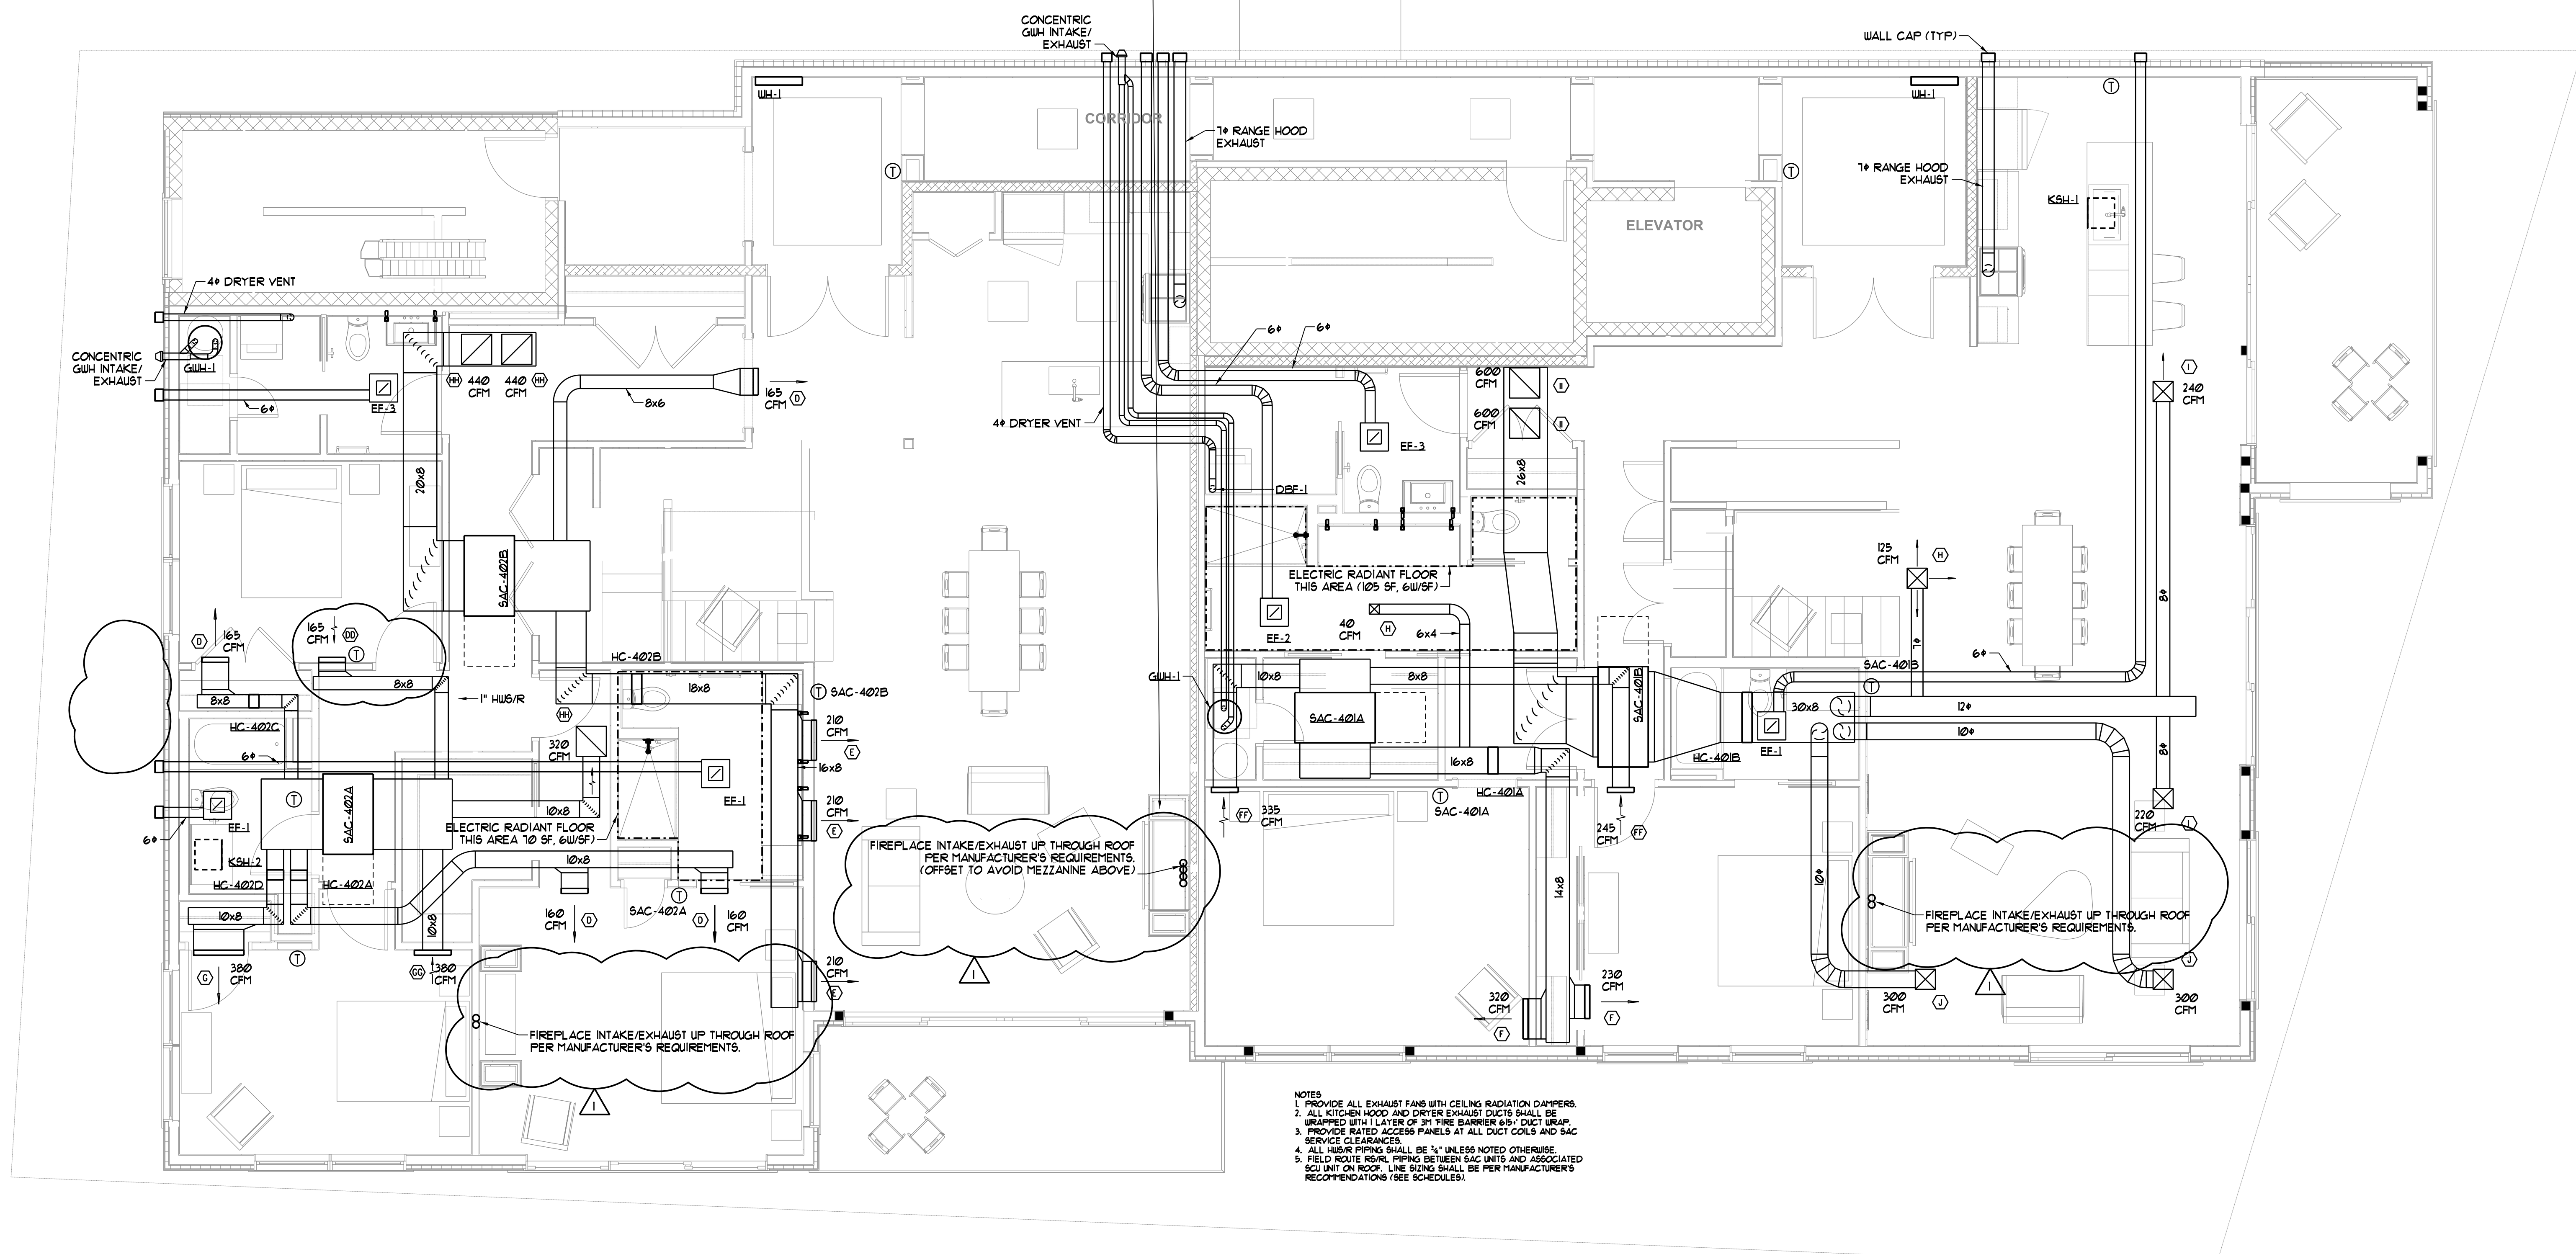

FOURTH FLOOR MECHANICAL PLAN
SCALE - 1/4" = 1'-0"