


MEZZANINE FLOOR PLAN
SCALE: 1/8" = 1'-0"
FLOOR AREA = 880 SF
FF ELEV. 72.83'


SPRINKLER HEAD INFORMATION, THIS FLOOR ONLY

QTY	SIZE	ORIFICE	K-FACTOR	DESCRIPTION	MODEL	TEMP	ESCUTCHEON	SYMBOL
10	1/2"	7/16"	4.9	VIKING RES. WHITE CONCEALED PEND	VK457	155	RECESSED	☉

TOTAL HEADS=10

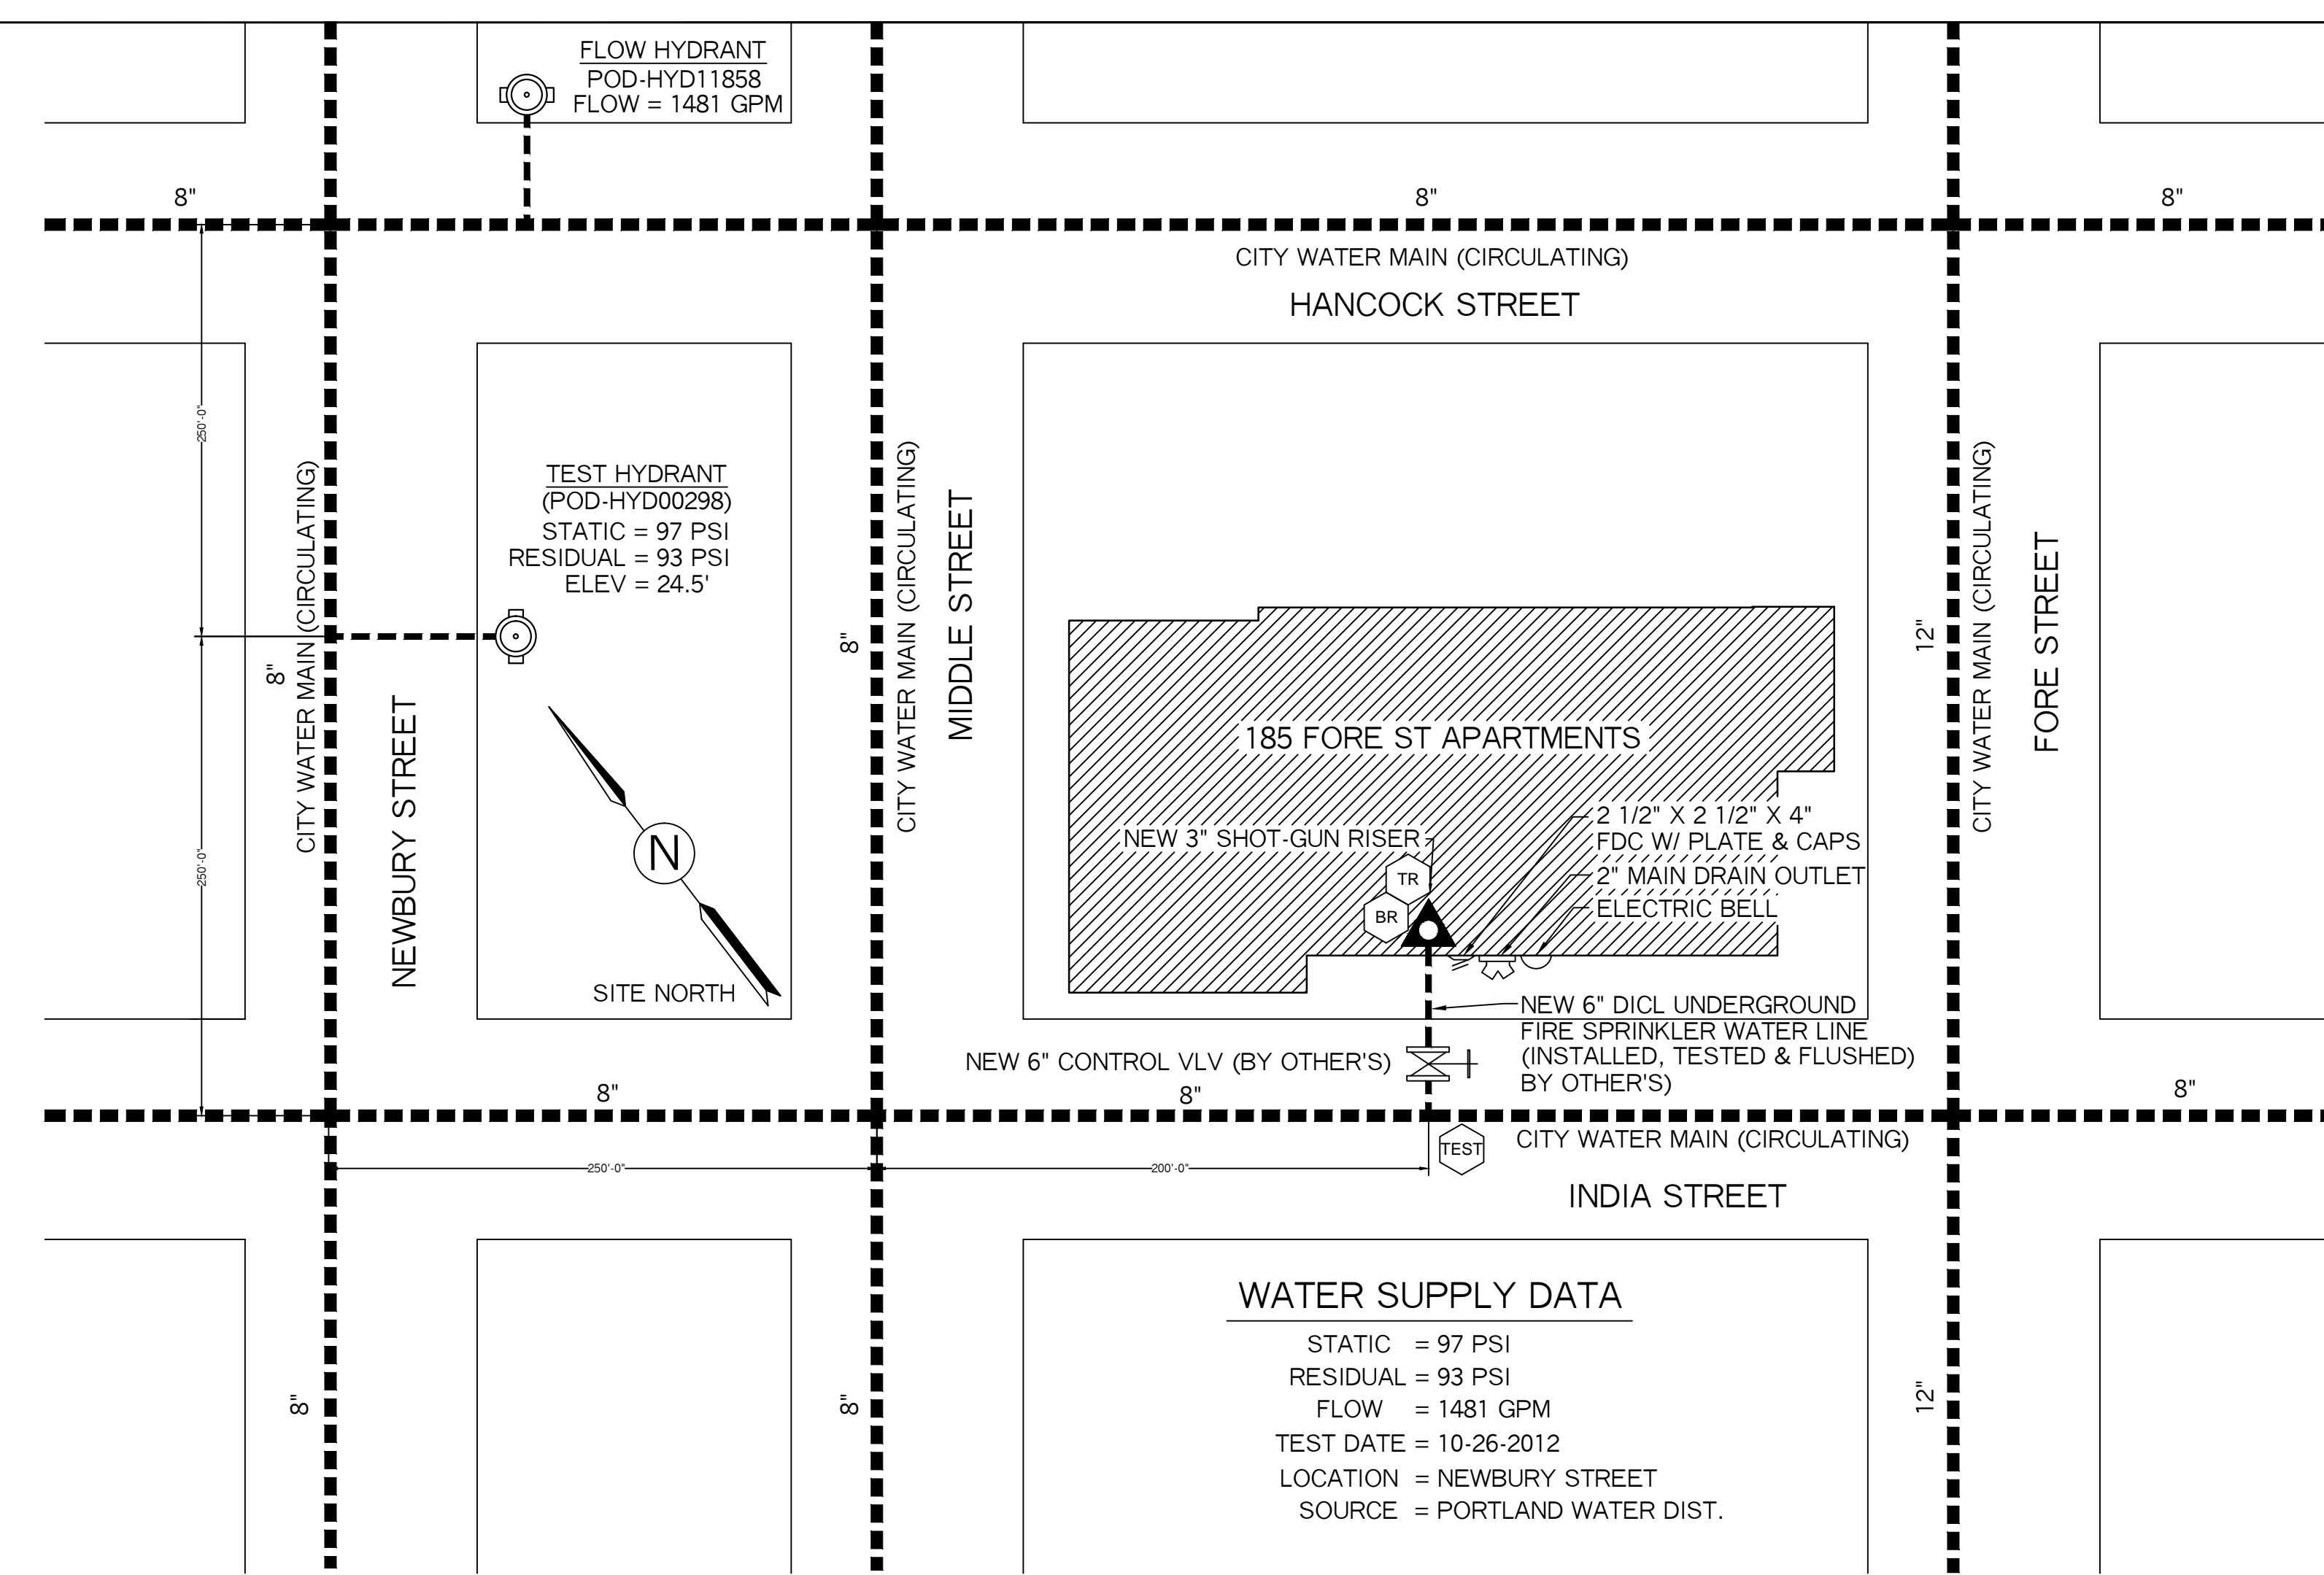


PLOT / SITE PLAN
N.T.S.

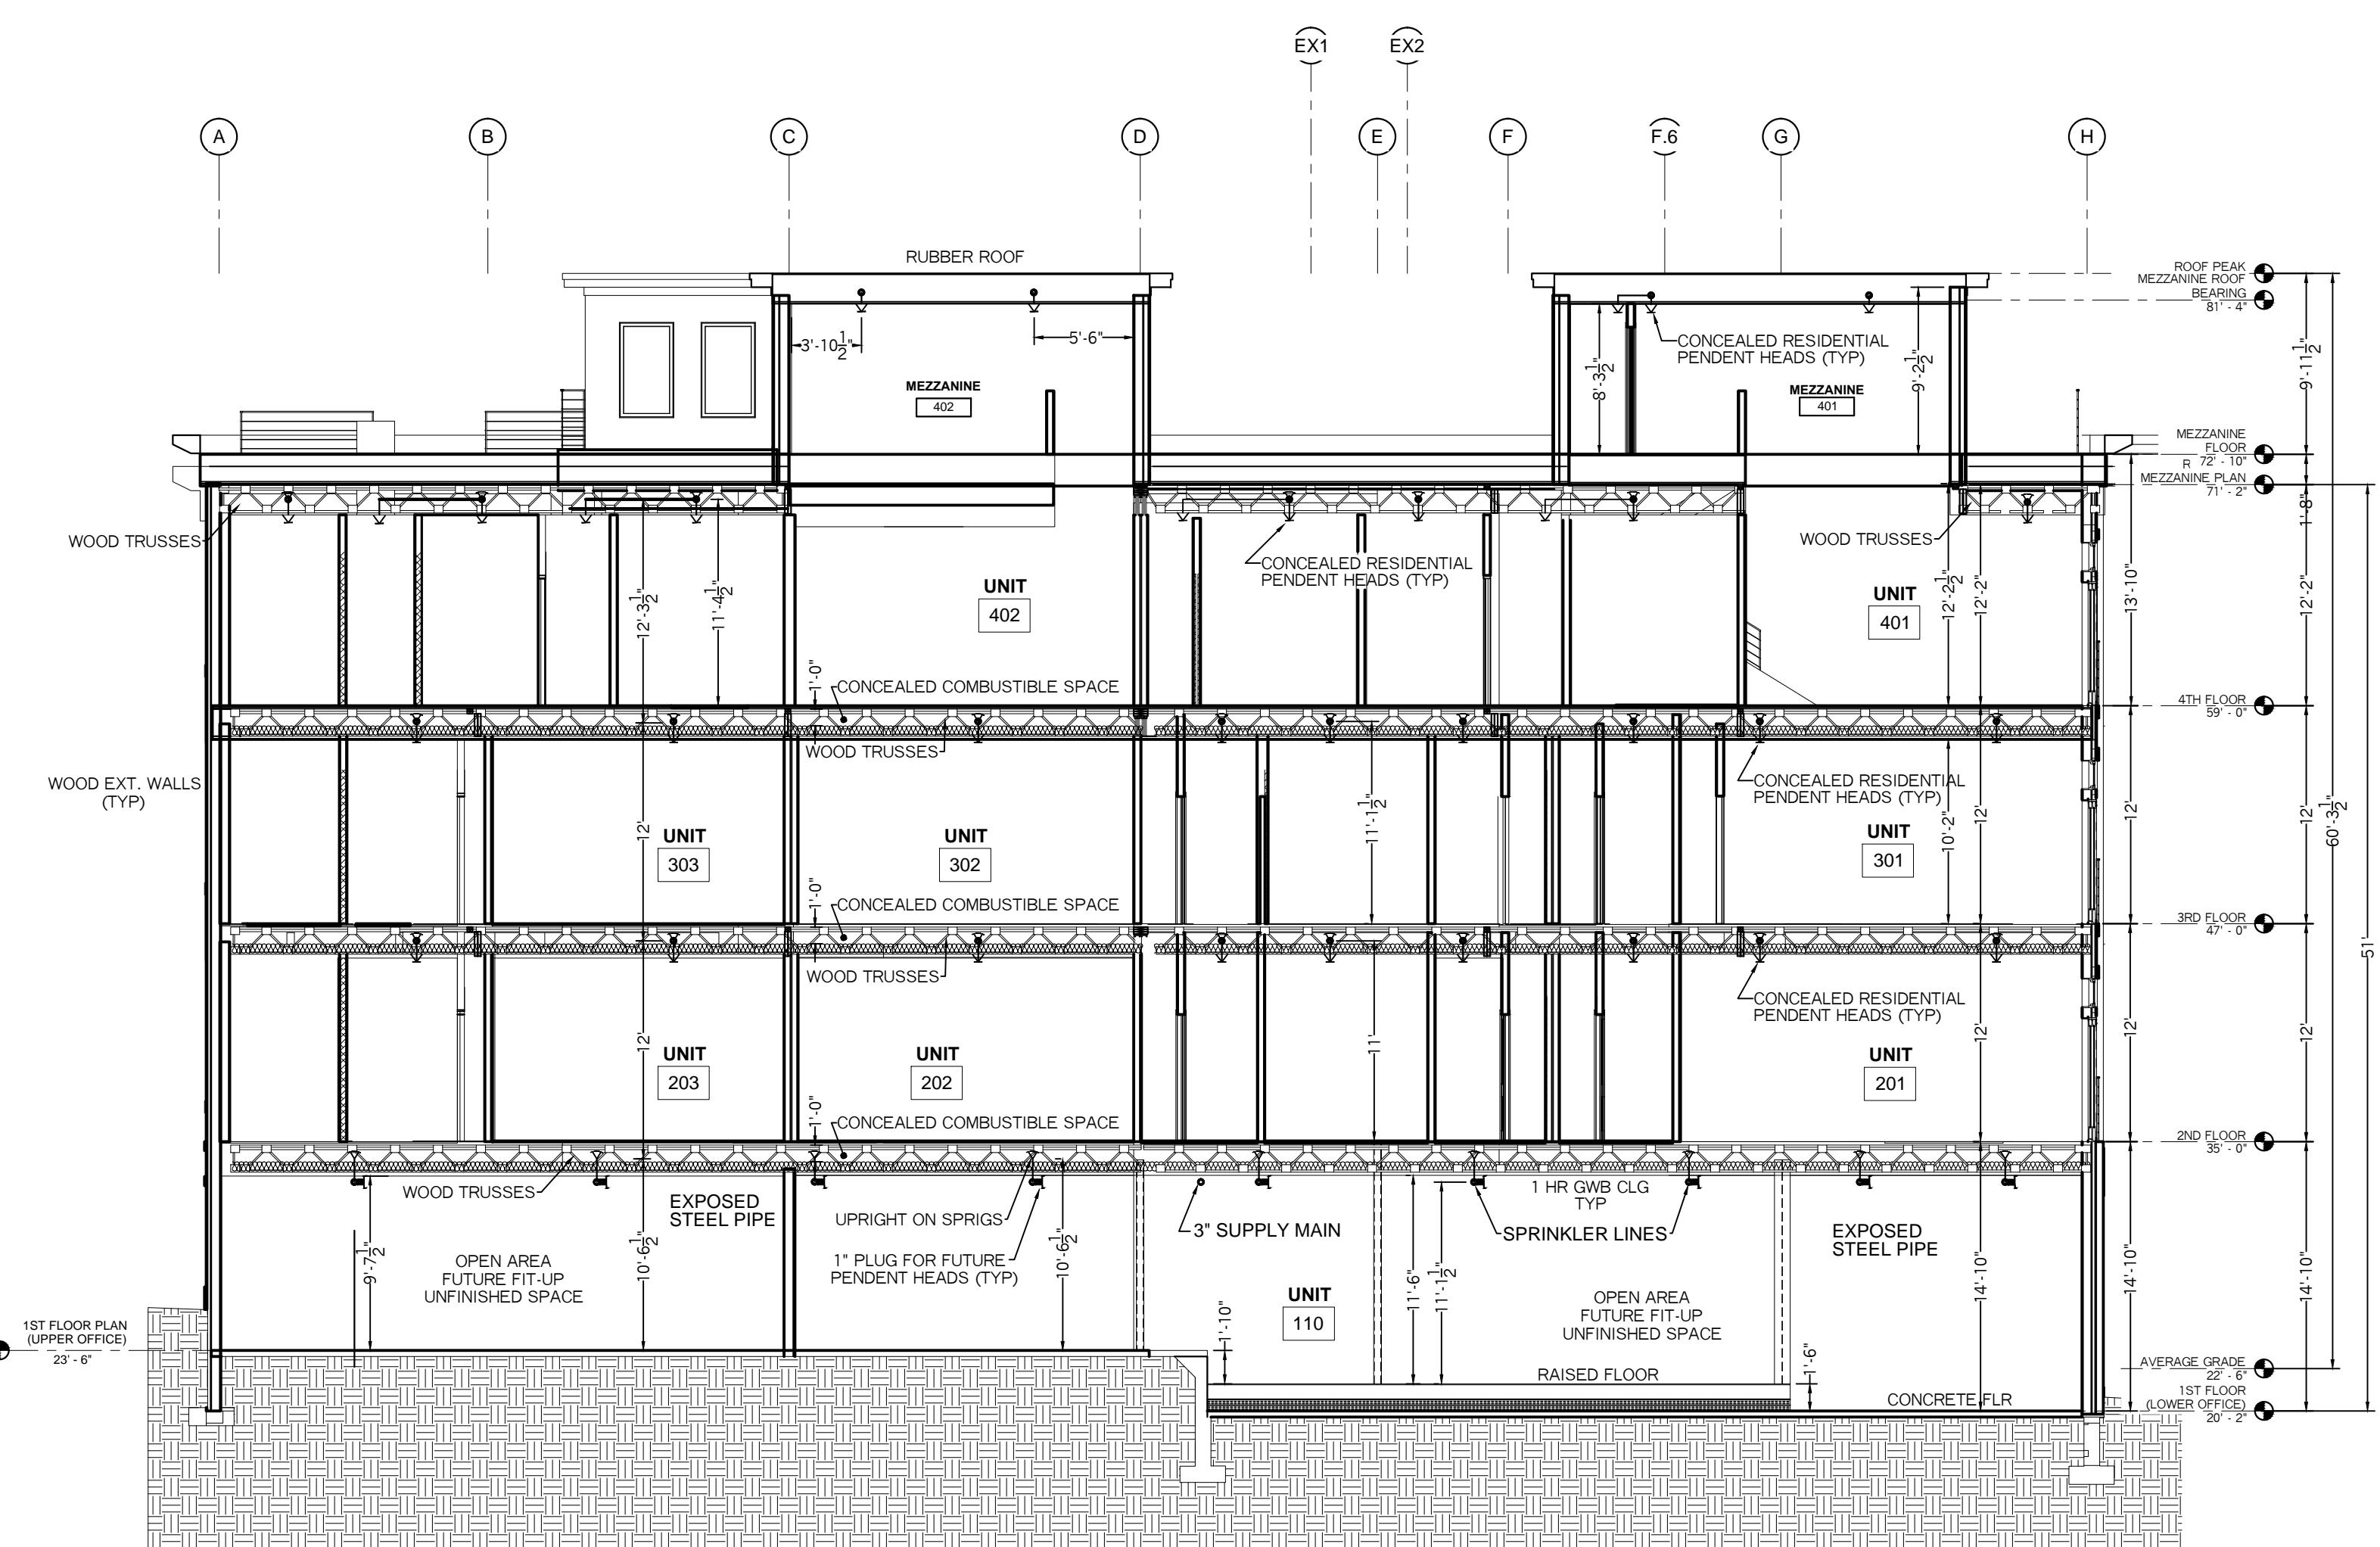


BUILDING SECTION A-A
SCALE: 1/8" = 1'-0"

- VALVE RISER LEGEND**
- 6" DI CL U.G. SPIGOT, PLUMB AND LEVEL (BY OTHER'S)
 - 6" UNI-FLANGE (BY OTHER'S)
 - 6" GROOVED FLANGE
 - 6" X 3" GROOVED CONCENTRIC REDUCER
 - 3" BUTTERFLY VLV W/ TAMPER SWITCH (N.O.)
 - WATER PRESSURE GAUGE (3.5" DIA.)
 - 3" AMES COLT "C200" DC BFP
 - POTTER VSR-3" VANE TYPE FLOWSWITCH
 - 1 1/4" TEST-N-DRAIN VALVE (7/16" TEST ORIFICE) (N.C.)
 - 3" GROOVED ELBOW
 - SPARE HEAD BOX, 6 HD CAPACITY W/ WRENCH
 - 1/2" AUTOMATIC BALL DRIP
 - 1 1/4" GALV. 45 ELBOW W/ GALV. GRINNELL PLATE (MAIN DRAIN)
 - 2 1/2" x 2 1/2" x 4" SIAMESE FDC W/ WALL PLATE, CAP & CHAIN SEE MAIN FLR PLAN FOR LOCATION
 - ELECTRIC BELL, 6" DIA., WITH BACKBOX, DEDICATED CIRCUIT POWER (MOUNTED TO OUTSIDE BY OTHERS)

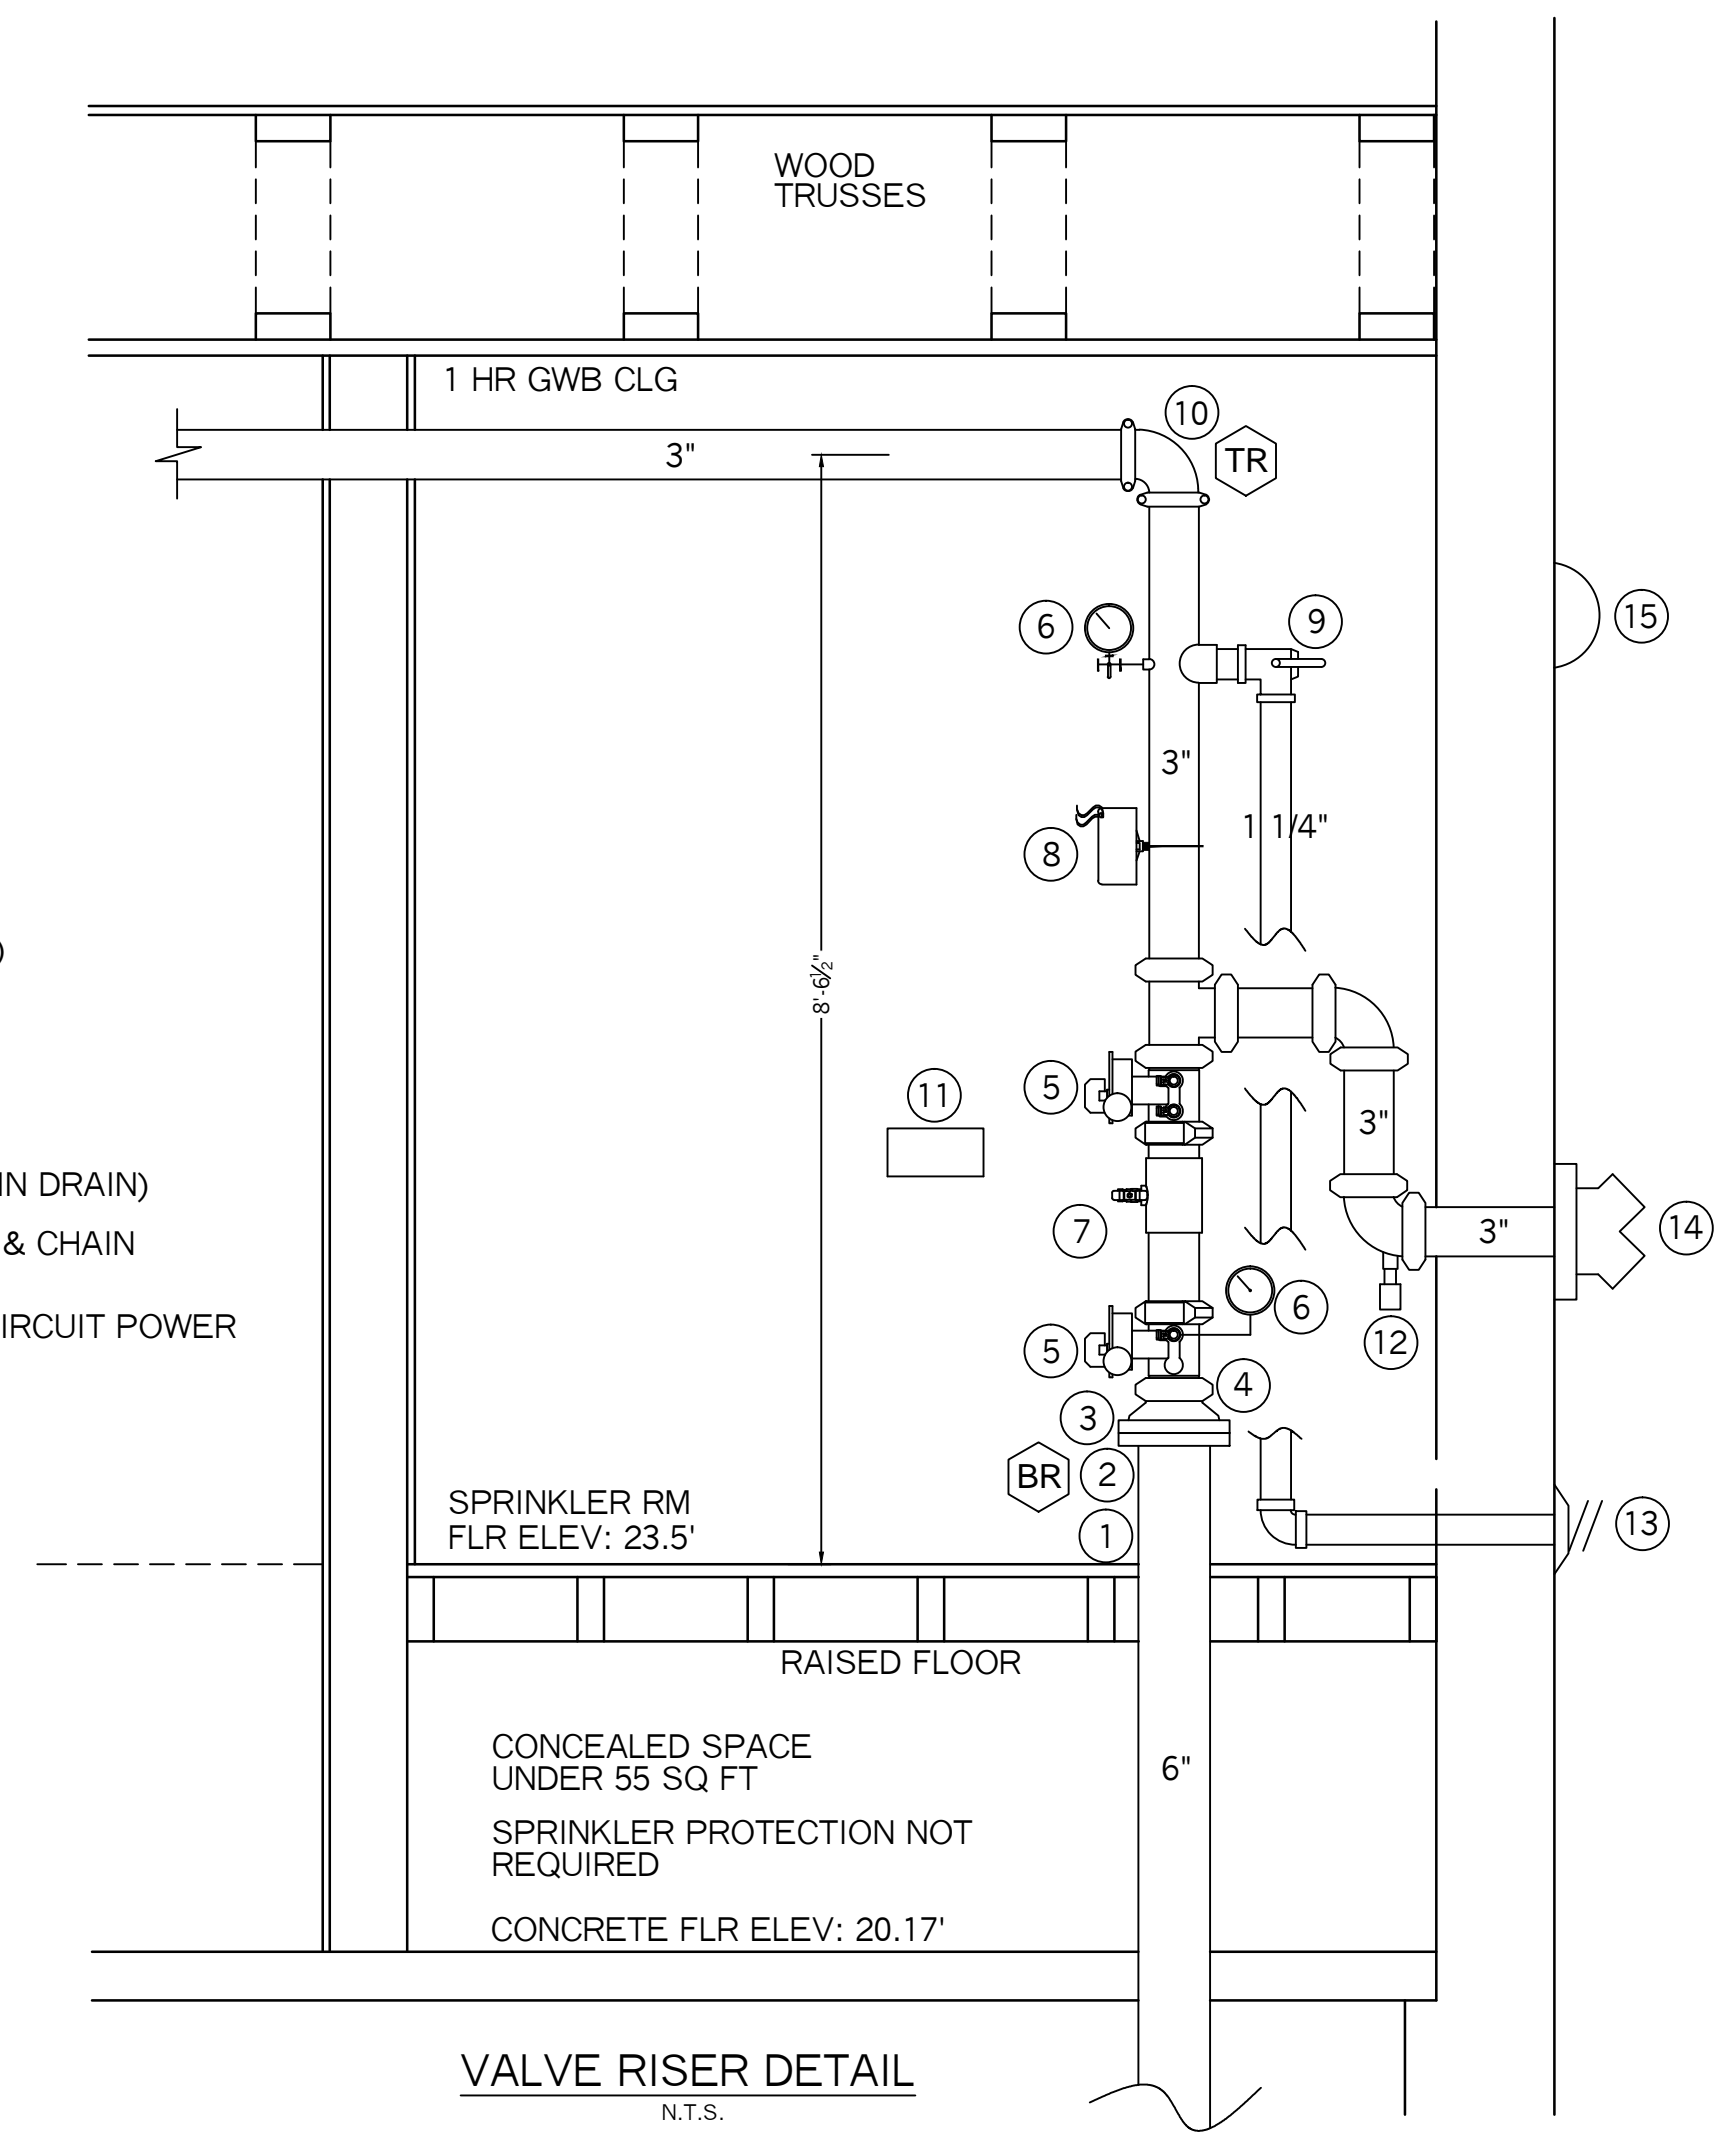

VALVE RISER DETAIL
N.T.S.

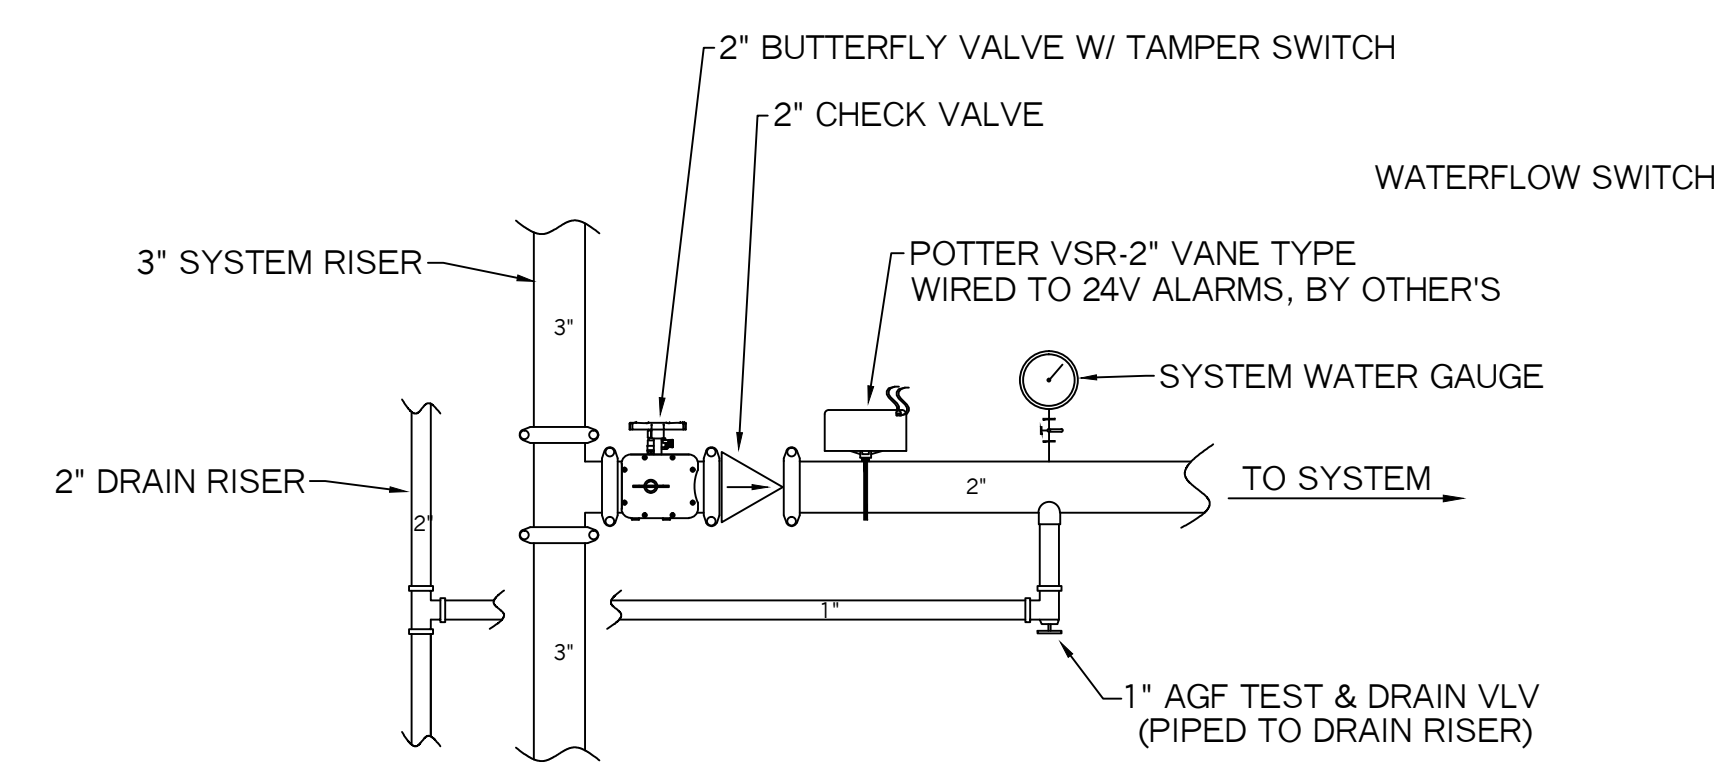

FLOOR CONTROL ASSEMBLY DETAIL
N.T.S.

PROJECT NAME: 185 FORE STREET 185 FORE STREET PORTLAND, ME. 04101	FIRE SPRINKLER PLANS AND DETAILS REQUIRED APPROVALS: STATE FIRE MARSHALS OFFICE LOCAL FIRE DEPARTMENT OWNER	RESIDENTIAL FIRE PROTECTION, LLC
CONTRACT WITH: CRANDALL TOOTHAKER (OWNER) PH: (207) 797-6066	DRAWN BY: TPP NICET III (108864) CERTIFICATION # 100854	DATE: 4-29-2016 SCALE: 1/8" = 1'-0"
RESIDENTIAL FIRE PROTECTION 64 DAGGETT HILL ROAD, GREENE, MAINE 04236 PH: (207) 946-3473 FAX: (207) 946-3474	CHECKED BY: SAC NICET III (108864) CERTIFICATION # 78065	CONTRACT NO. C16011 DRAWING NO. 2 OF 2
	CONTRACTOR LICENSE #511	CONTRACTOR RMS #80