


| | | | |
|-------------|---|------------------------------|-----------|
| REVISION | 0 | ISSUED FOR REVIEW & APPROVAL | 2/16/2016 |
| DESCRIPTION | | | |
| DATE | | | |

RESERVED FOR CITY STAMP

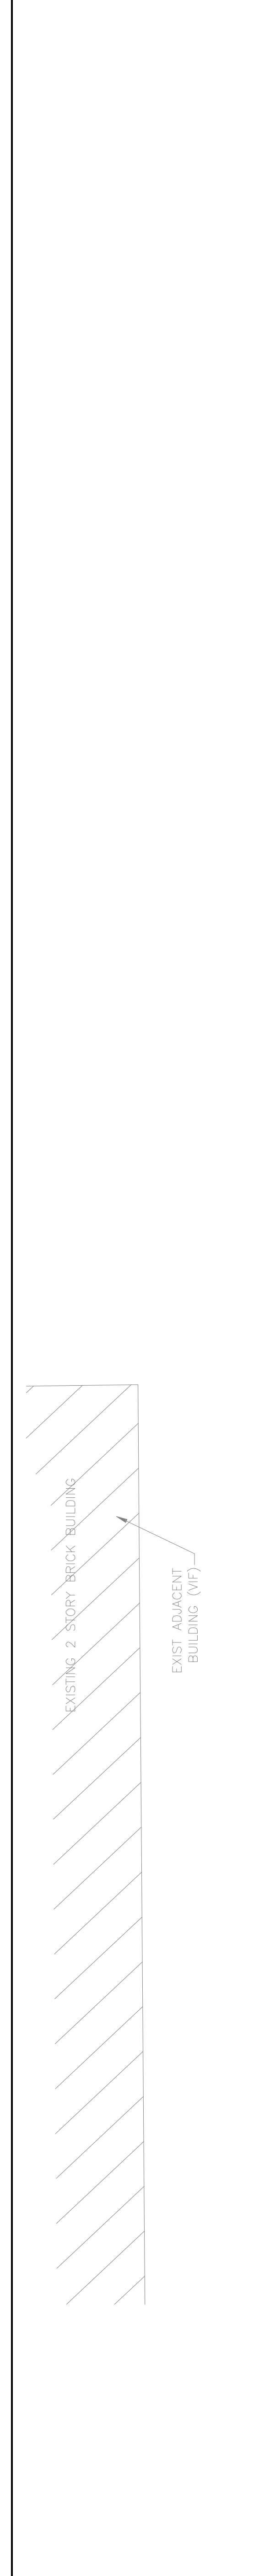


CUNNINGHAM
 Security Systems
 10 Princes Point Road, Yarmouth, Maine 04096
 Office: 207.846.3350 • Fax: 207.846.6080

ETZ CHAIM SYNAGOGUE/MAINE JEWISH MUSEUM
 267 CONGRESS STREET
 PORTLAND, MAINE 04101
SECOND FLOOR FIRE ALARM PLAN

| | |
|----------|--------------------------------|
| DRAWN | JPB UNICAD JOB #16081 |
| CHECKED | WAYNE B. HAWES NCET # 90496 |
| DATE | 2/16/2016 |
| REVISION | 0 |
| SCALE | 1/4" = 1'-0" |

FA-4

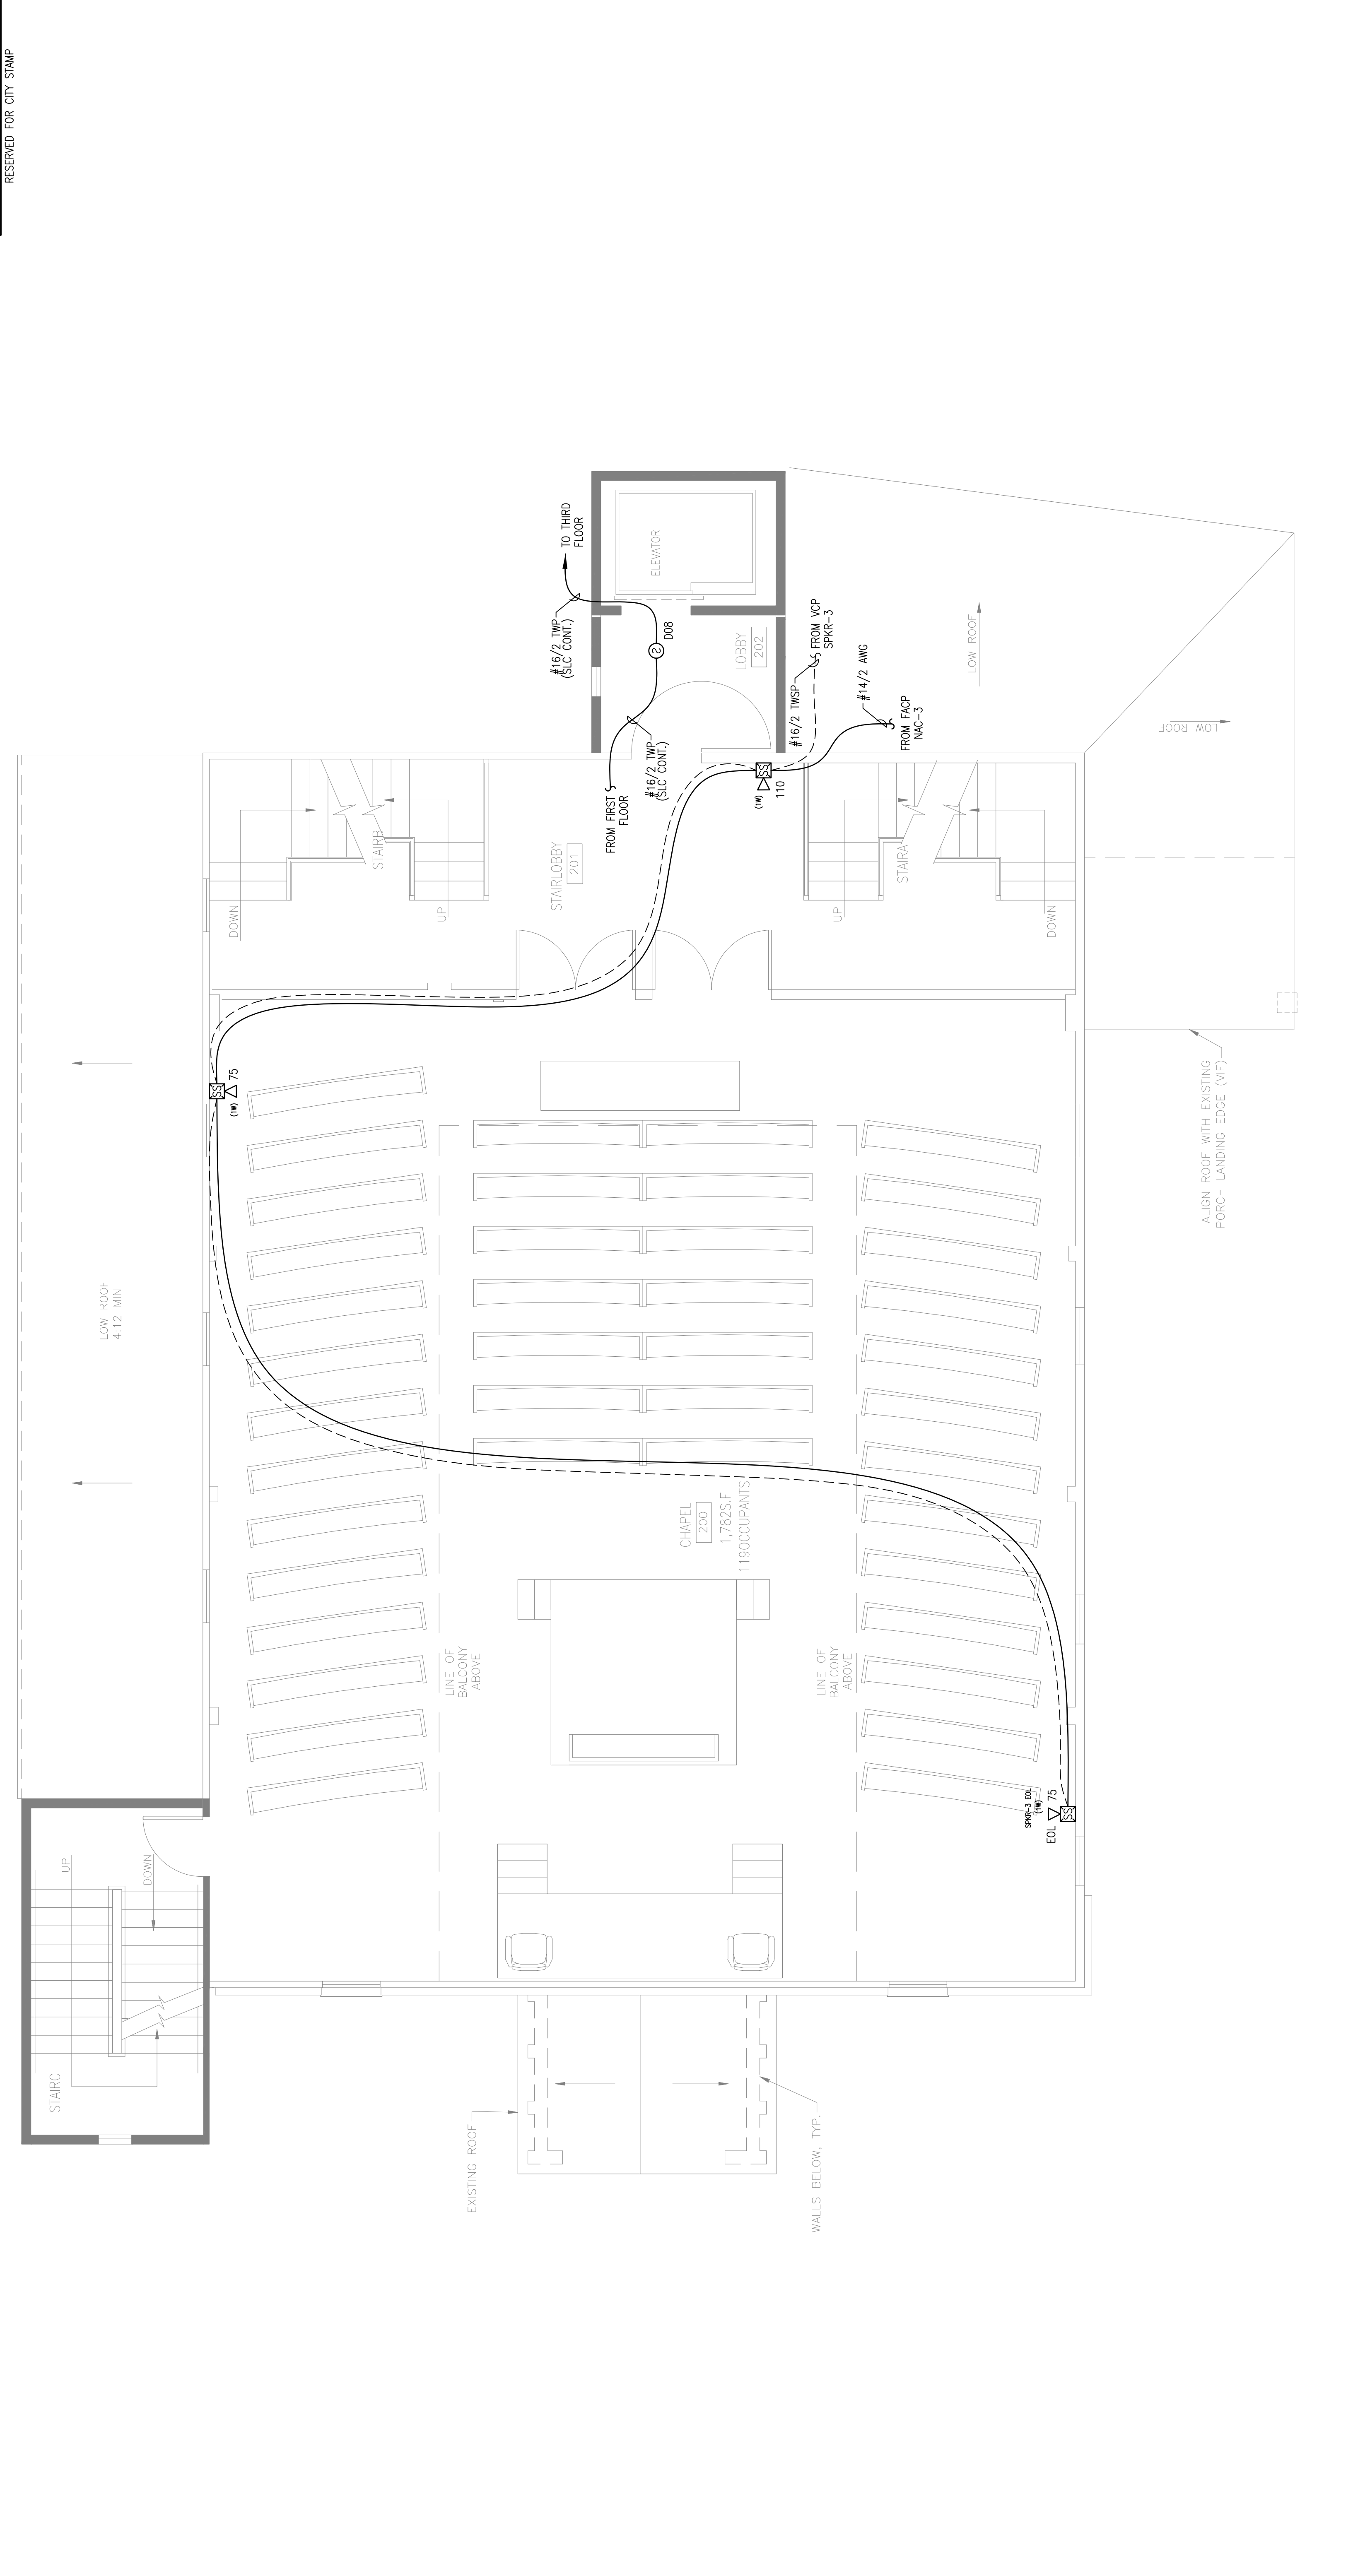

UNICAD Inc.
 Fire Alarm Design & Drafting Services
 578 W. 40th St.
 Portland, ME 04102
 Office: 603.865.6410
 www.unicad.net

SECOND FLOOR FIRE ALARM PLAN
 SCALE: 1/4"=1'-0"

RESERVED FOR CITY STAMP