

REVISION	DESCRIPTION	DATE
0	ISSUED FOR REVIEW & APPROVAL	2/16/2016

RESERVED FOR CITY STAMP


REVISION	DESCRIPTION	DATE
0	ISSUED FOR REVIEW & APPROVAL	2/16/2016

CUNNINGHAM
Security Systems
10 Princes Point Road, Yarmouth, Maine 04096
Office: 207.846.3350 • Fax: 207.846.6080

ETZ CHAIM SYNAGOGUE/MAINE JEWISH MUSEUM
267 CONGRESS STREET
PORTLAND, MAINE 04101
THIRD FLOOR FIRE ALARM PLAN

DRAWN	JPB UNICAD JOB #16081
CHECKED	WAYNE B. HAWES NCET # 90496
DATE	2/16/2016
REVISION	0
SCALE	1/4" = 1'-0"

UNICAD Inc.
Fire Alarm Design & Drafting Services
www.unicad.net
578 W. 400th St.
Portland, ME 04106
Office: 603.865.6410

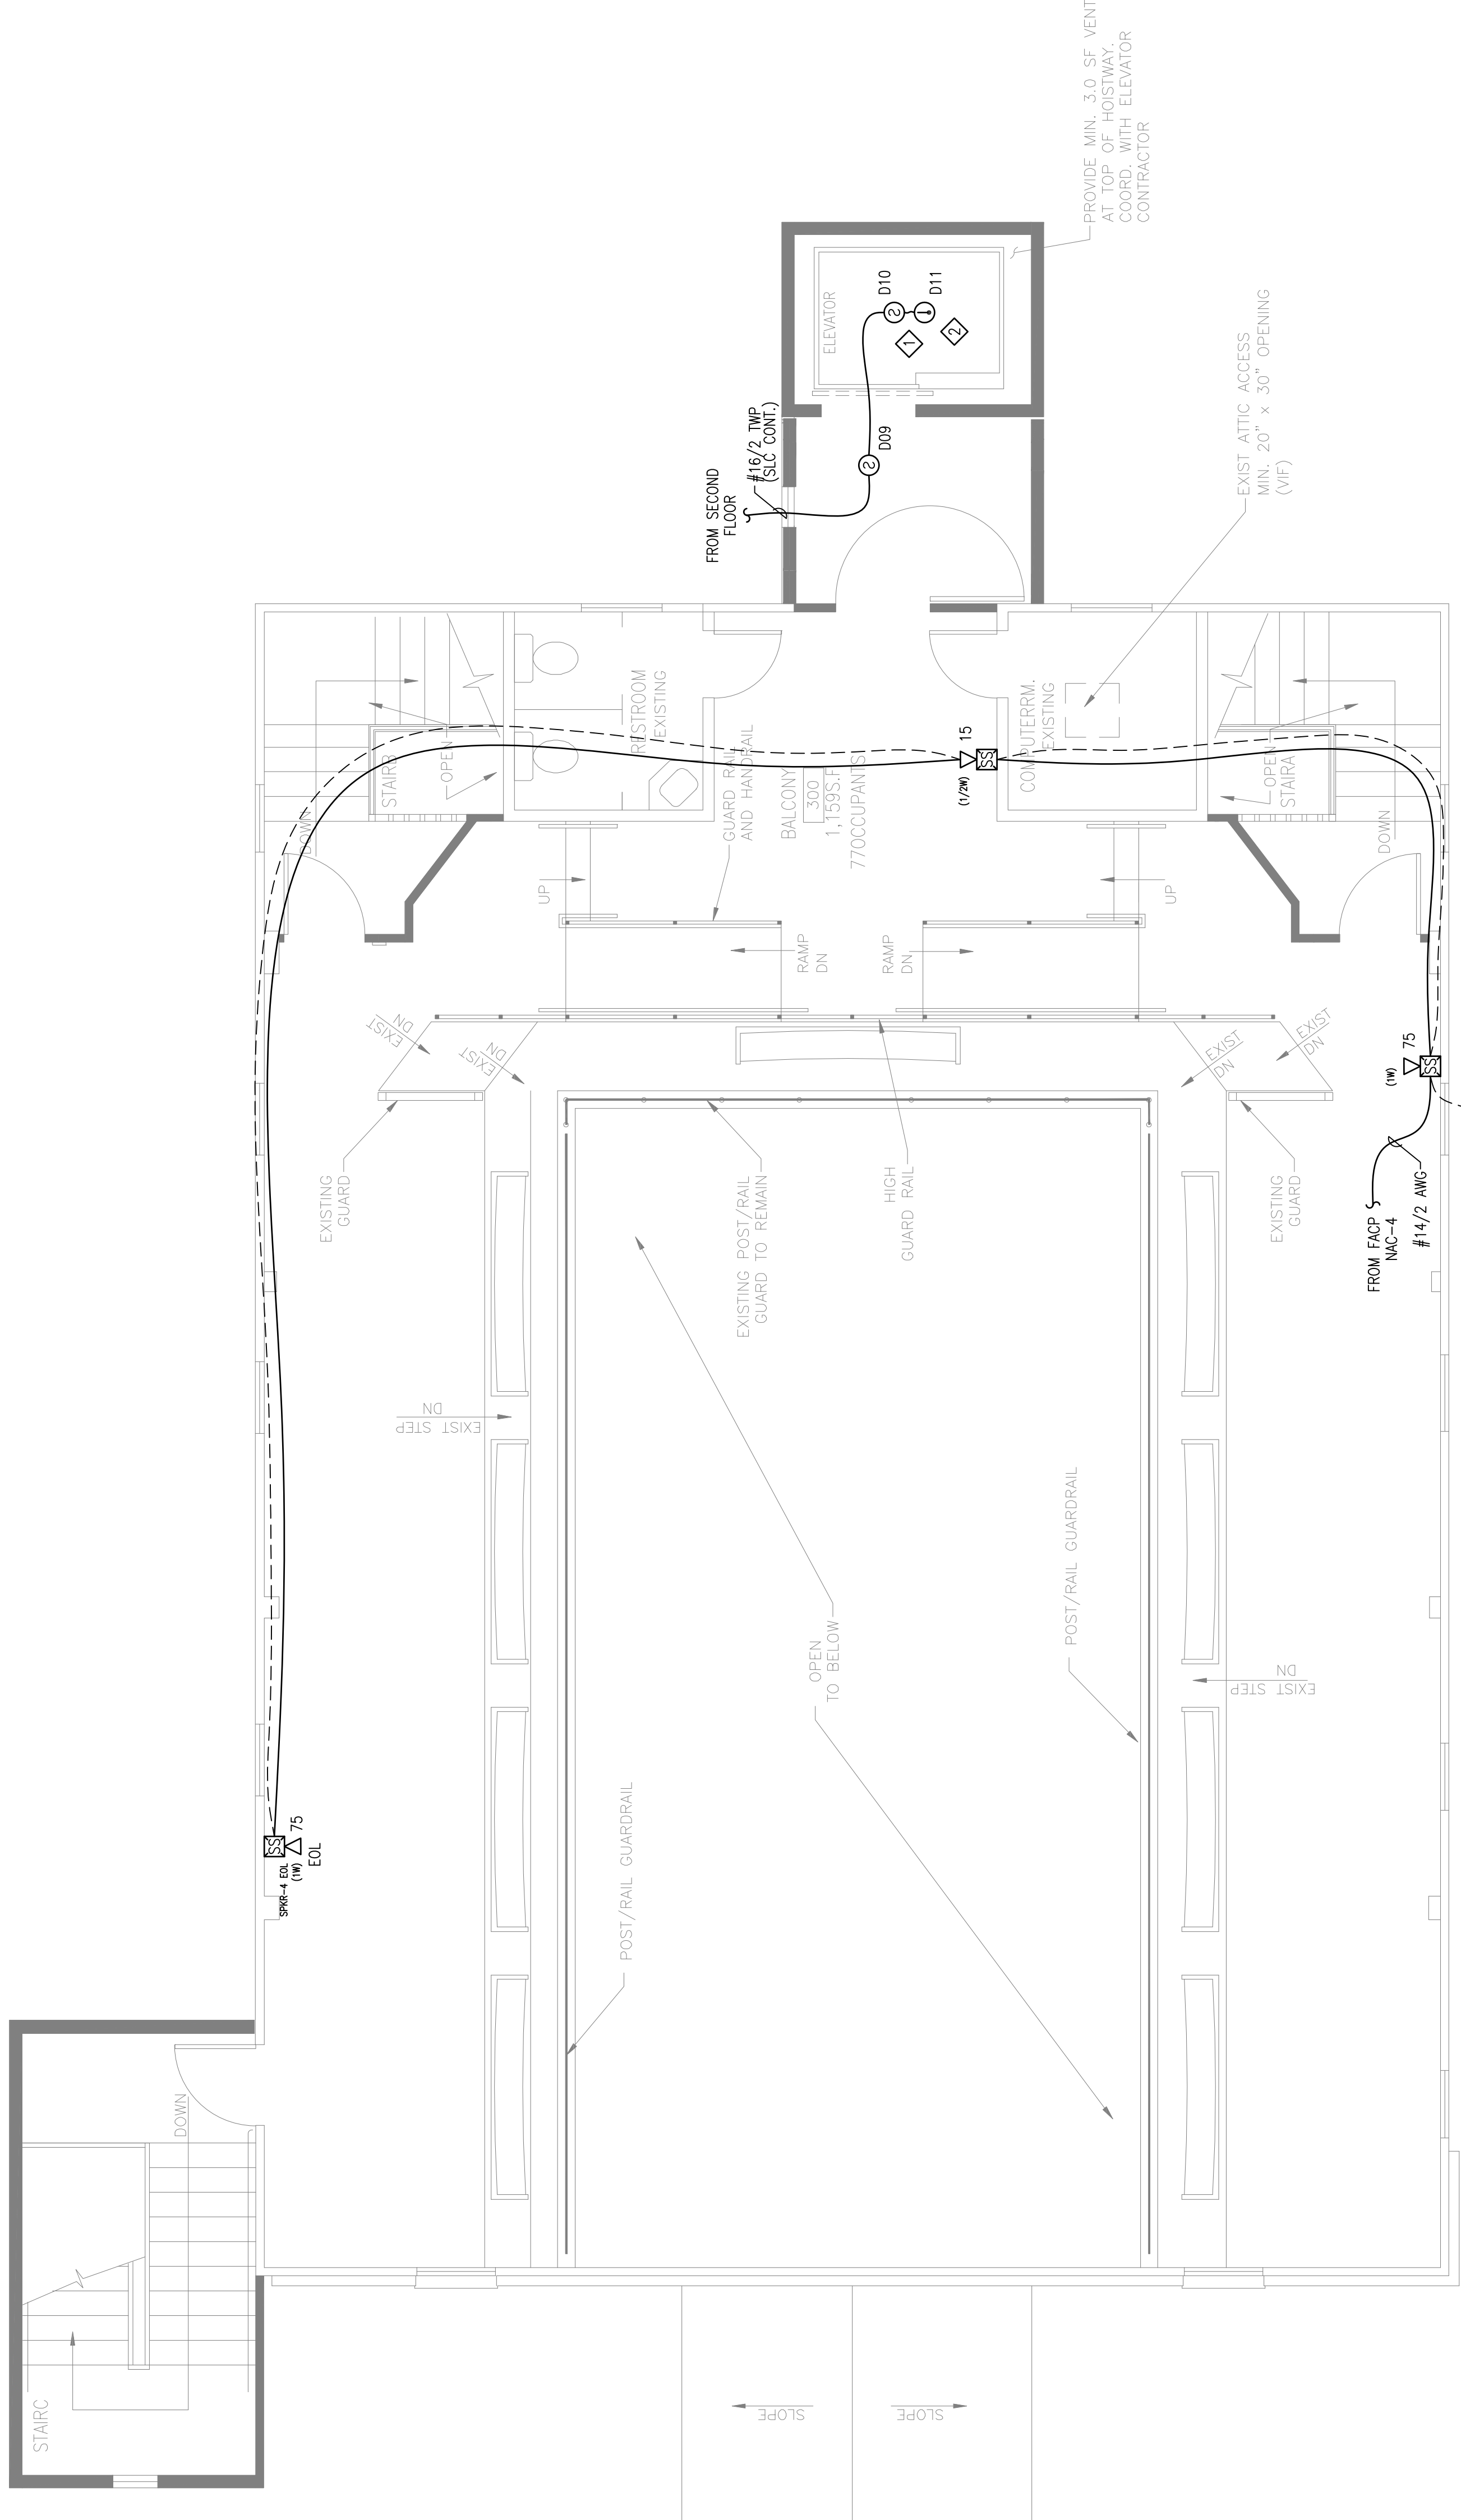

THIRD FLOOR FIRE ALARM PLAN
SCALE: 1/4"=1'-0"

- SHEET NOTES:**
- ◇ LOCATE DETECTOR AT TOP OF ELEVATOR HOISTWAY.
 - ◇ PROVIDE HEAT DETECTOR(S) WITHIN 24" OF EACH SPRINKLER HEAD IN THE ELEVATOR CONTROL ROOM AND HOISTWAY(S). HEAT DETECTORS SHALL HAVE A LOWER TEMPERATURE RATING THAN THE SPRINKLERS IN THE AREA AND BE MONITORED FOR INTEGRITY.