


GENERAL NOTES

- 1. ALL TYPICAL APARTMENT PANELS SHALL BE FLUSH MOUNTED 24 POLE WITH A 100A MAIN BREAKER AND 10 KAIC RATED, SQUARE D QO OR EQUIVALENT.

KEY NOTES

- 1. PROVIDE ELECTRONIC TRIP BREAKER CAPABLE OF SETTING BREAKER TO 95%. SET BREAKER TO 95% OF 1200A RATING PLUG. BREAKER TO BE 100KAIC RATED.
- 2. SEE ELECTRICAL PLAN FOR ROUTING AND LENGTH OF CONDUITS.
- 3. PROVIDE 5 - 4" CONDUITS WITH PULL ROPES INSTALLED AND CAPPED ENDS FOR FUTURE BUILDING SERVICE ENTRANCE.
- 4. PROVIDE SERVICE ENTRANCE NEUTRAL TO EQUIPMENT GROUND BOND IN ACCORDANCE WITH NEC. SEE DETAIL 8, SHEET E402

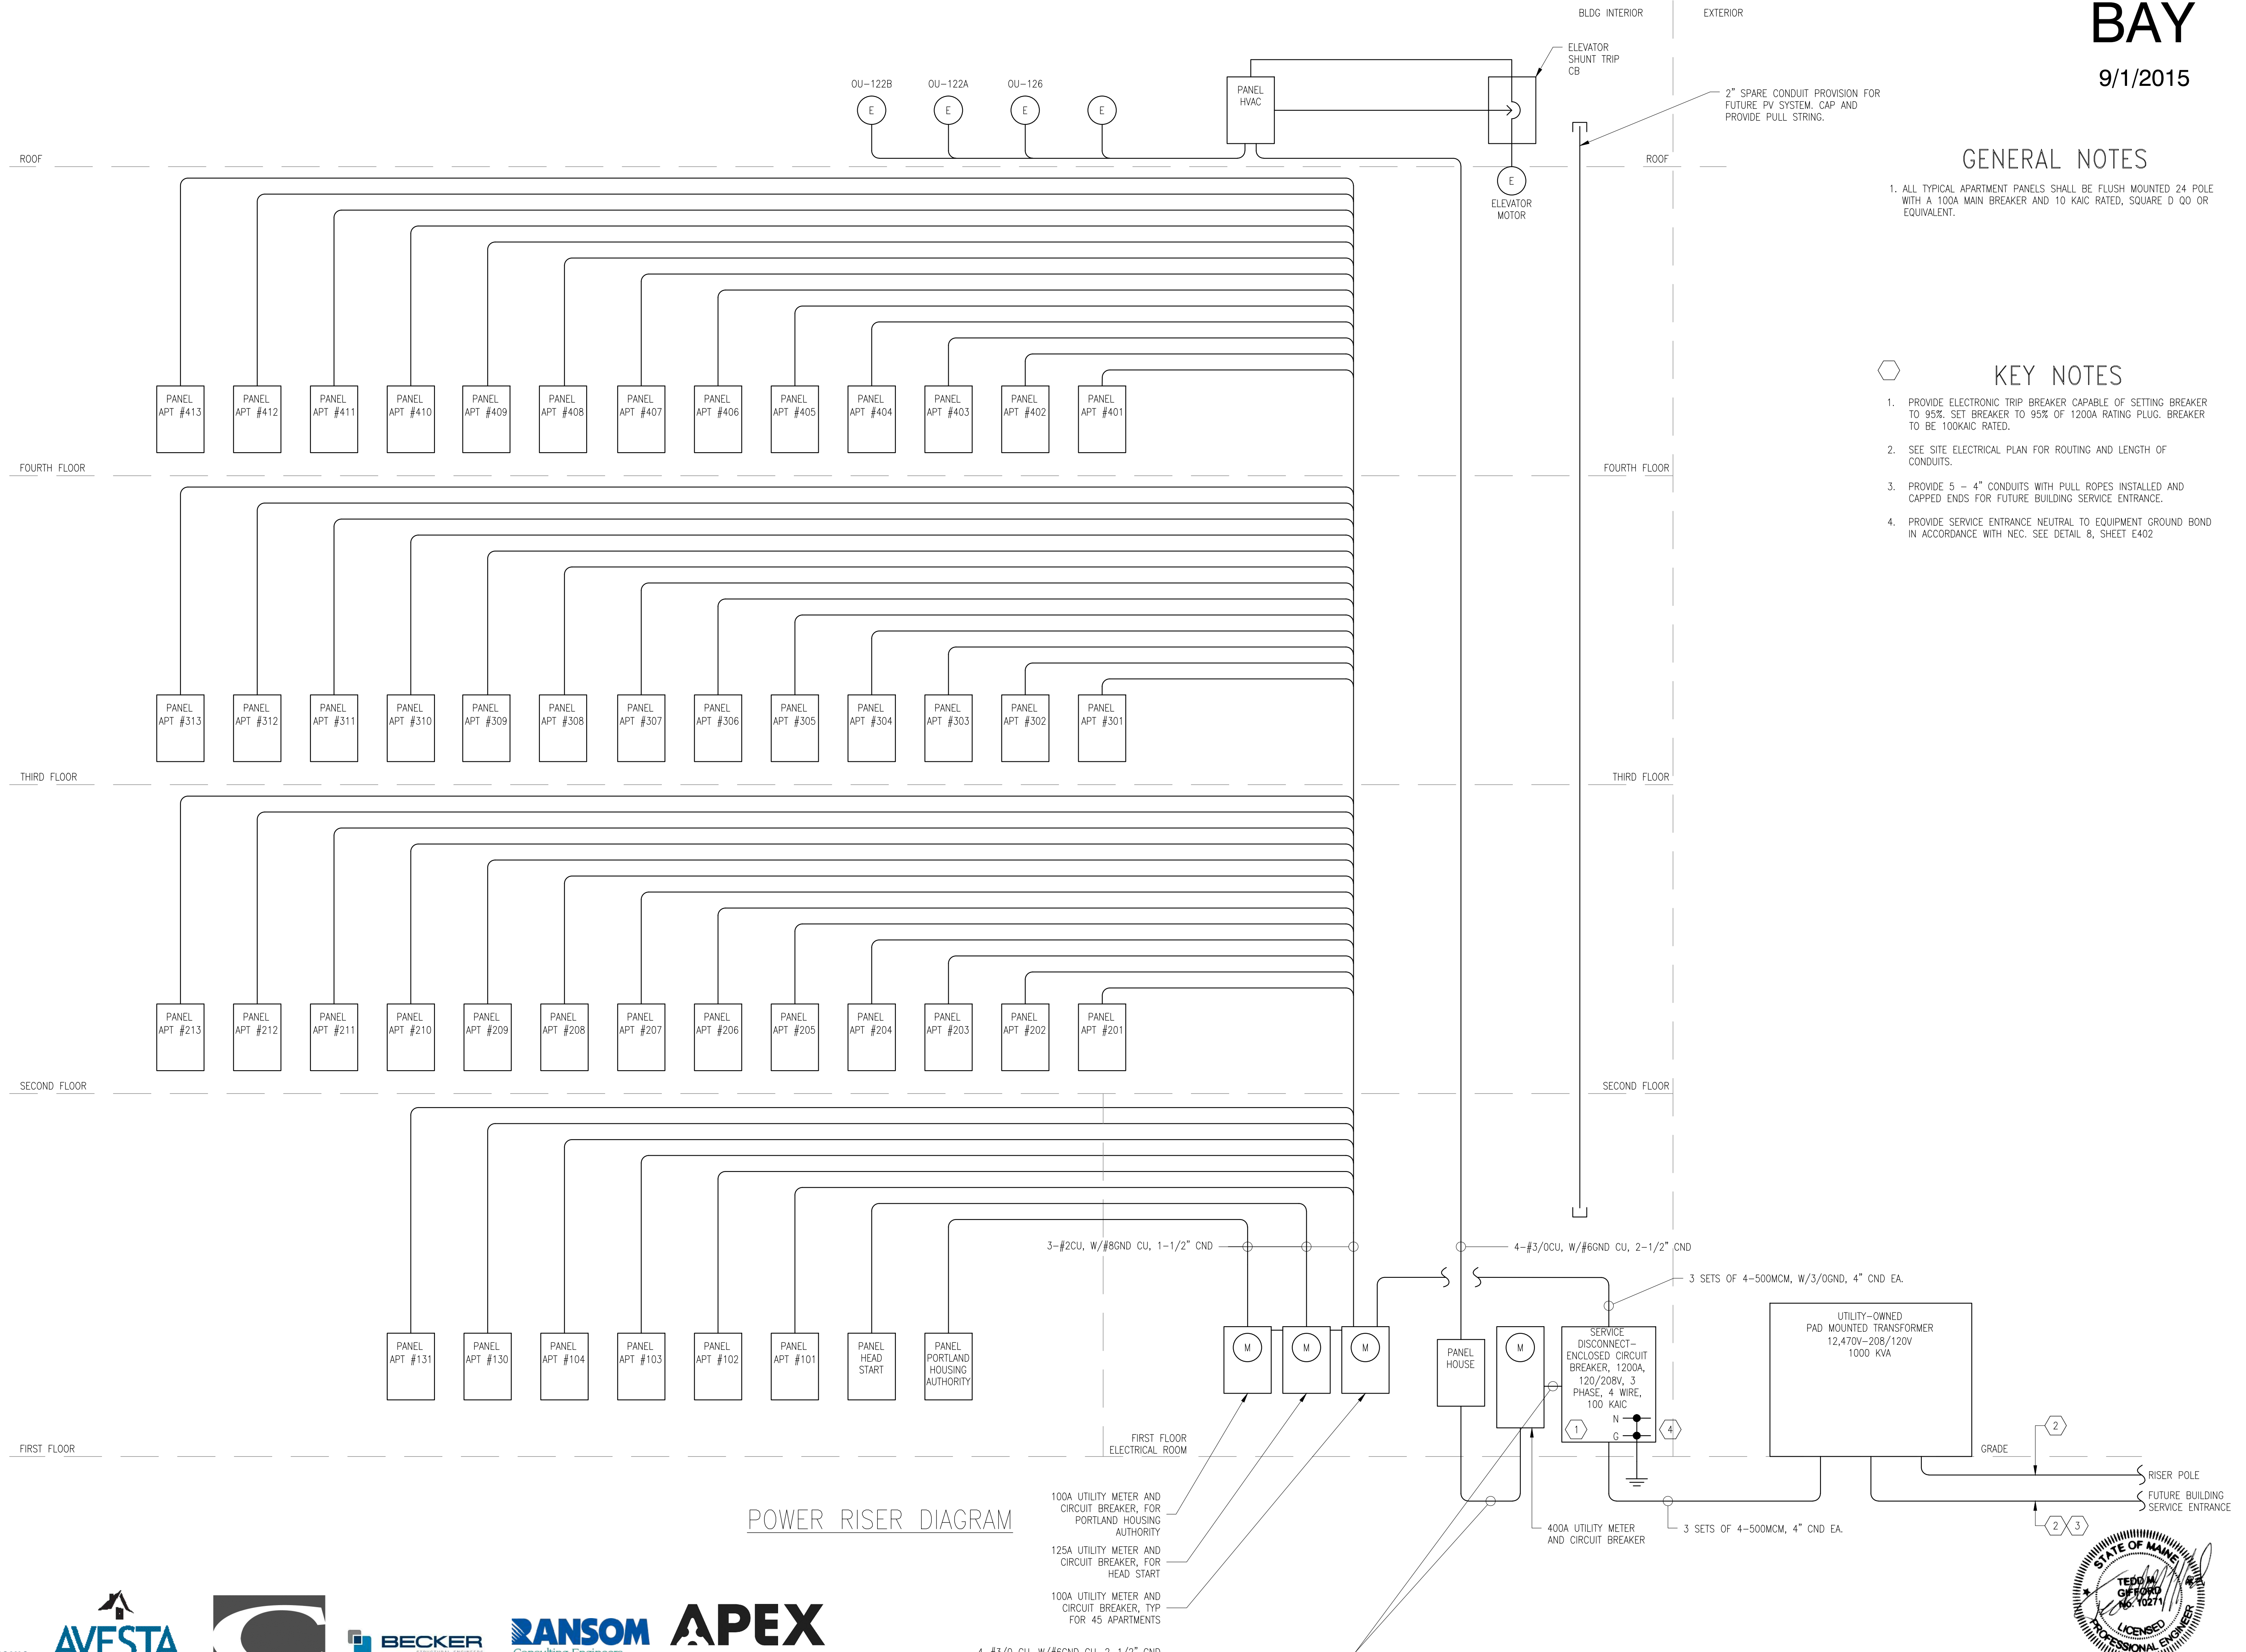

POWER RISER DIAGRAM

100% ISSUE FOR CONSTRUCTION

Project:  
**BAYSIDE ANCHOR**  
 PHDC & Avesta  
 81 East Oxford Street  
 Portland, ME

Drawing: **ELECTRICAL - POWER RISER DIAGRAM**  
 Scale: NONE  
 Date: 9/1/15  
 Drawn by: ACY  
 Revised:

E200

