


○ KEY NOTES

1. TYPICAL FOR APARTMENTS 101, 102, 104, 131.
2. TYPICAL FOR APARTMENTS 201, 203, 204, 205, 207, 208, 209, 210, 211, 212.
3. TYPICAL FOR APARTMENTS 301, 303, 304, 305, 307, 308, 309, 310, 311, 312.
4. TYPICAL FOR APARTMENTS 401, 403, 404, 405, 407, 408, 409, 410, 411, 412.

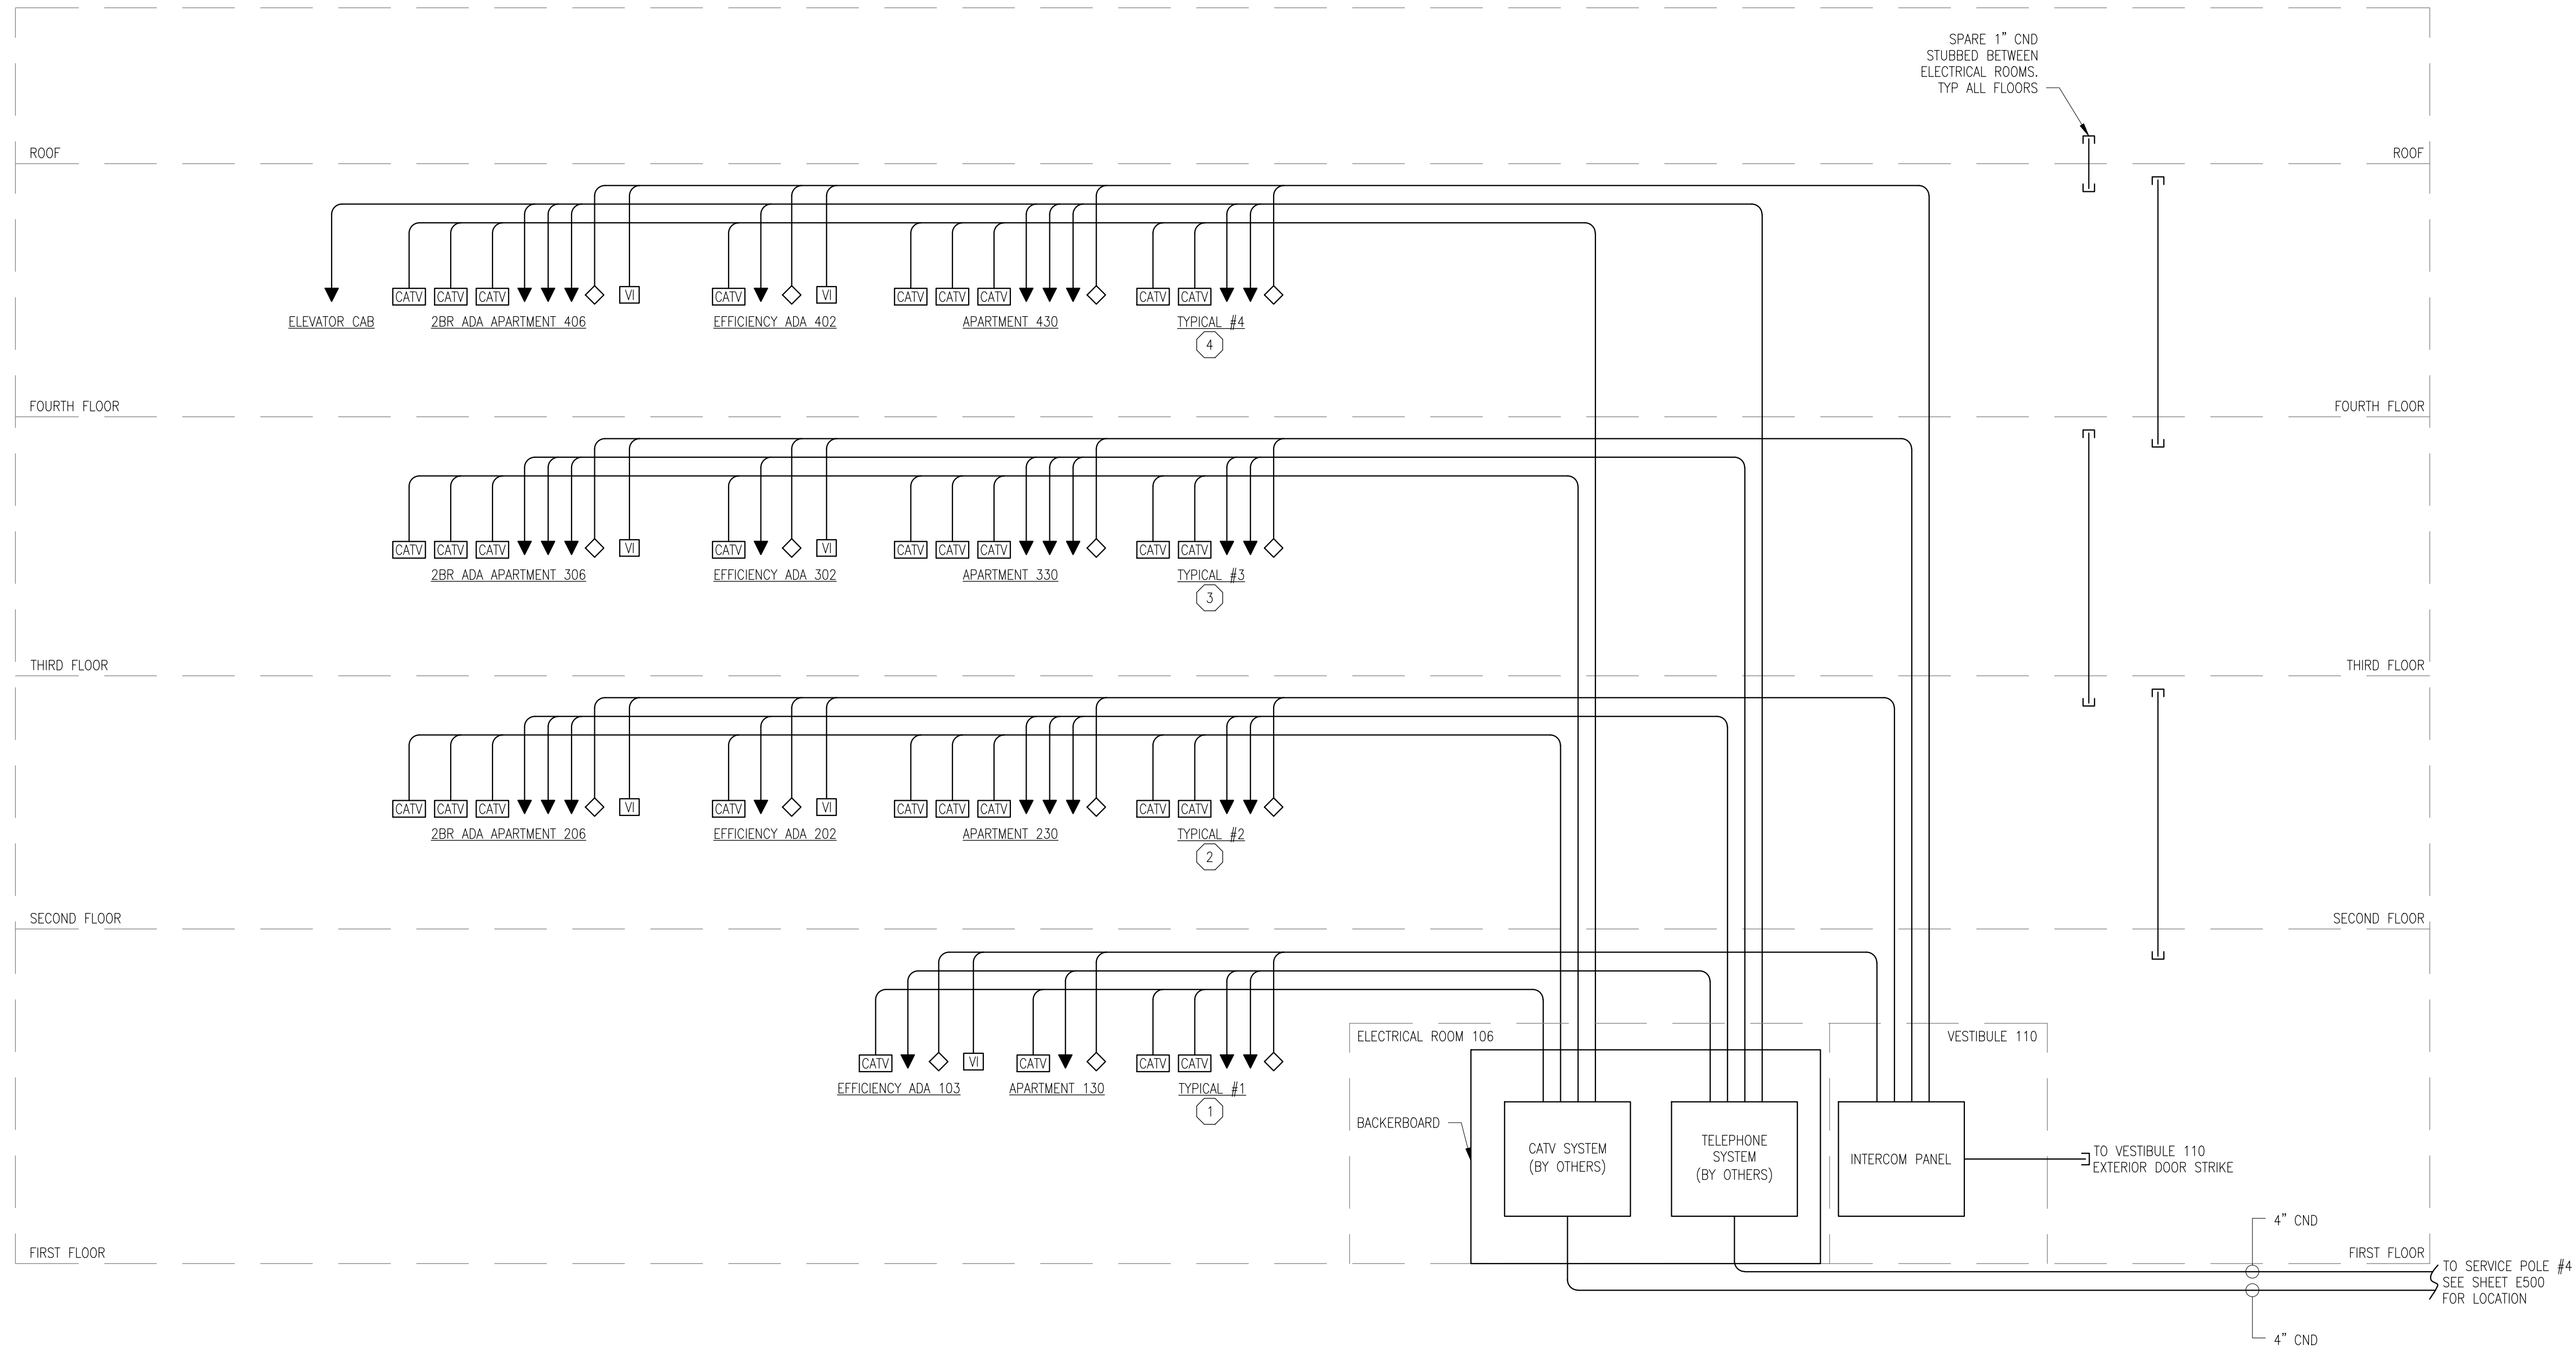

1 TELECOMMUNICATIONS RISER DIAGRAM




424 FORE ST.
PORTLAND, ME 04101
207-842-2888



14 BAXTER BLVD
PORTLAND, ME 04101
P: 207.773.4753



307 CUMBERLAND AVE
PORTLAND, ME 04101
P: 207.553.7777

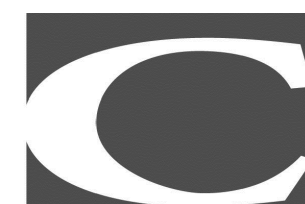


217 COMMERCIAL STREET, STE 200
PORTLAND, MAINE 04101
207.772.1562 V. F. 207.772.0712



75 YORK ST.
PORTLAND, ME 04101
P: 207.879.1838



400 COMMERCIAL ST.
SUITE 404
PORTLAND, ME 04101
P: 207.772.2891

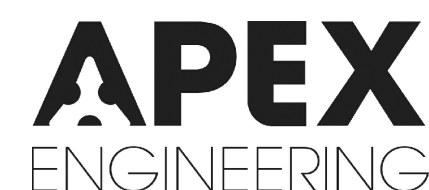

190 US ROUTE ONE
PMB 346 FALMOUTH, ME
04105
P: 207.847.3445


100% ISSUE FOR
CONSTRUCTION

Project:
BAYSIDE ANCHOR
PHDC & Avesta
81 East Oxford Street
Portland, ME

Drawing: ELECTRICAL - TELECOMMUNICATIONS & FIRE ALARM RISER DIAGRAM

Scale: NONE Drawn by: ACY

Date: 9/1/15 Revised:

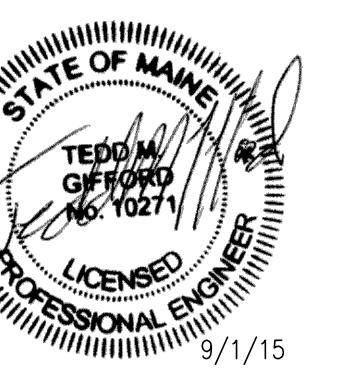

E201