


FIRE ALARM  
FIRST FLOOR PLAN

SCALE: 1/8" = 1'-0"

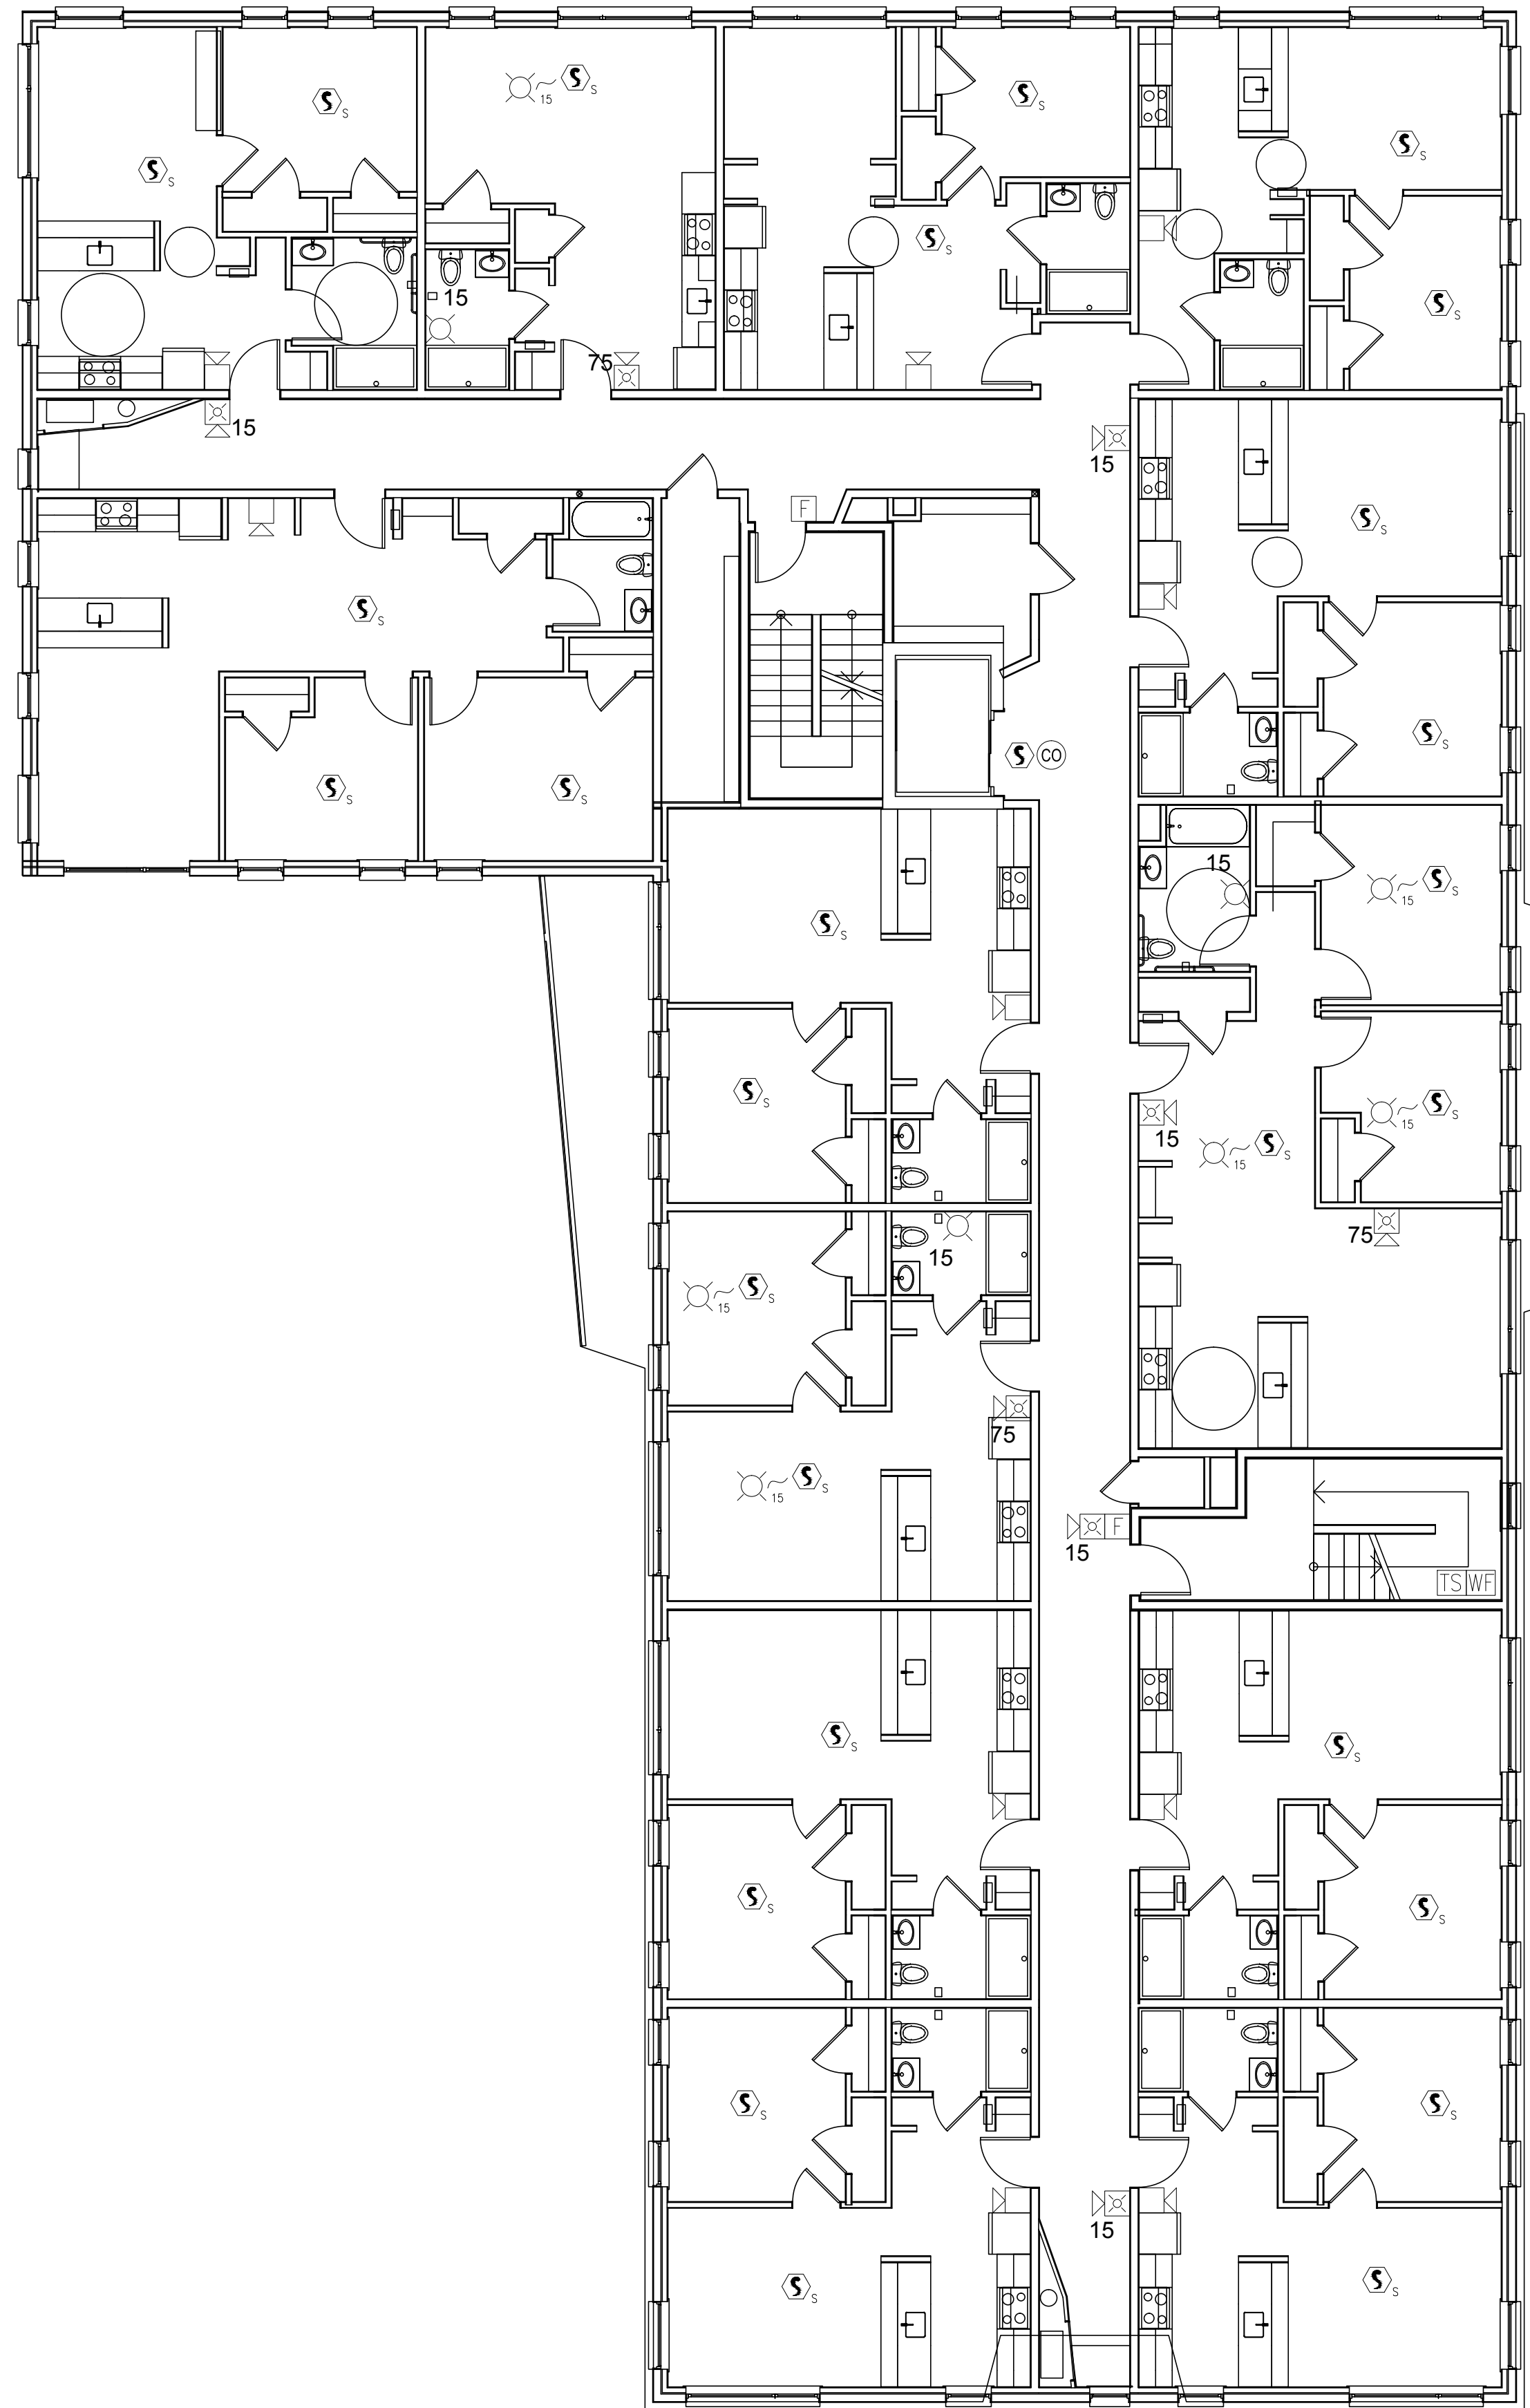

FIRE ALARM  
SECOND FLOOR PLAN

SCALE: 1/8" = 1'-0"




424 FORE ST.  
PORTLAND, ME 04101  
207-842-2888



14 BAXTER BLVD  
PORTLAND, ME 04101  
P: 207.773.4753



307 CUMBERLAND AVE  
PORTLAND, ME 04101  
P: 207.553.7777

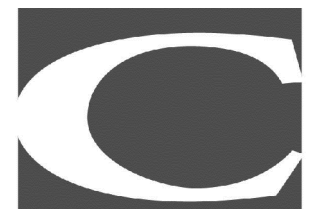

217 COMMERCIAL STREET, STE 200  
PORTLAND, MAINE 04101  
207.772.1592 V. F. 207.772.0712



75 YORK ST.  
PORTLAND, ME 04101  
P: 207.879.1838



400 COMMERCIAL ST.  
SUITE 404  
PORTLAND, ME 04101  
P: 207.772.2891



190 US ROUTE ONE  
PMB 346 FALMOUTH, ME  
04105  
P: 207.847.3445

PRICING DOCUMENTS

Project:  
BAYSIDE ANCHOR  
PHDC & Avesta  
81 East Oxford Street  
Portland, ME

Drawing: FIRE ALARM - FLOOR PLANS

Scale: 1/8" = 1'-0"

Date: 9/1/15

Drawn by: JM

Revised:

**FIRE RISK MANAGEMENT, INC.**  
Fire Protection Engineers & Code Consultants  
1 Front St., Bath, ME 04530 / 207-442-7200