

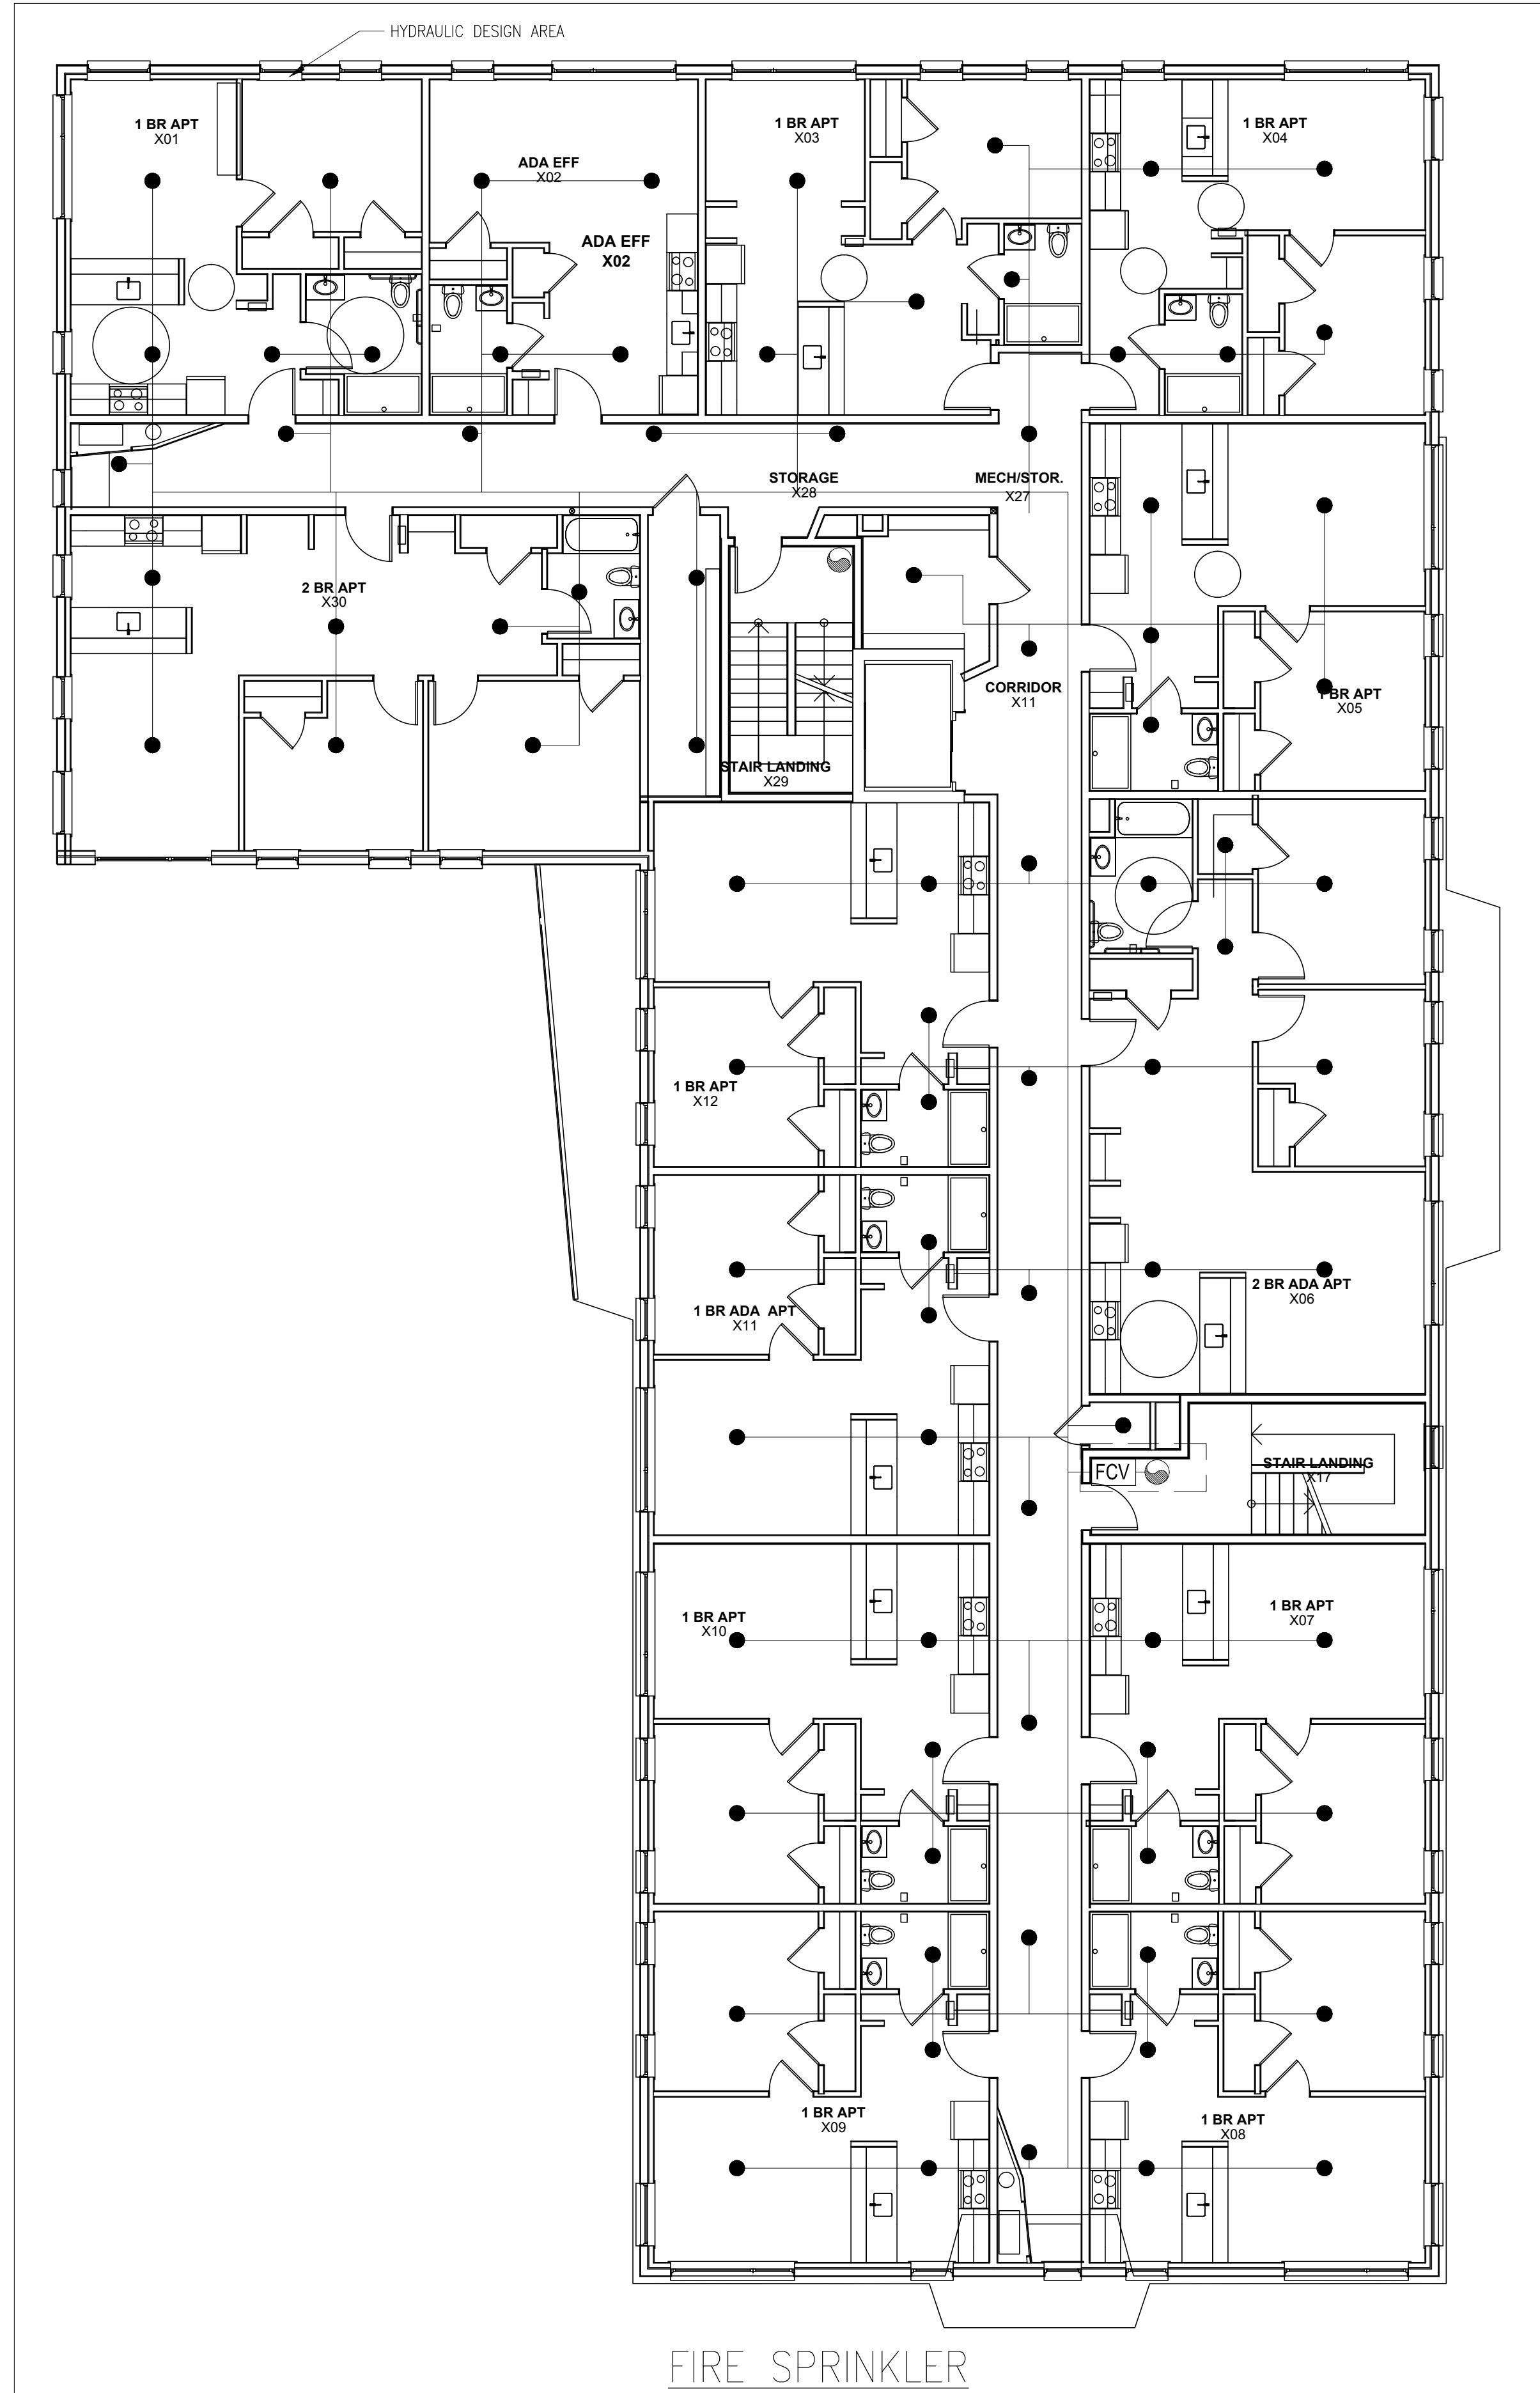


FIRE SPRINKLER FIRST FLOOR PLAN

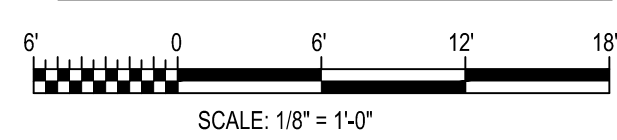

FIRE SPRINKLER SECOND FLOOR PLAN

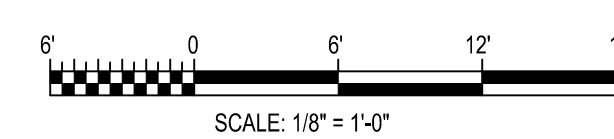

NOTES:

1. SPRINKLERS ARE REQUIRED IN CLOSETS GREATER THAN 24 SQUARE FEET AND/OR IN CLOSETS WITH A LEAST DIMENSION EXCEEDING 3 FEET.
2. BACKFLOW FORWARD TEST CAN BE ACCOMPLISHED VIA FIRST FLOOR STANDPIPE HOSE CONNECTION IN STAIR ENCLOSURE.




424 FORE ST.
PORTLAND, ME 04101
207-842-2888



14 BAXTER BLVD
PORTLAND, ME 04101
P: 207.773.4753



307 CUMBERLAND AVE
PORTLAND, ME 04101
P: 207.553.7777

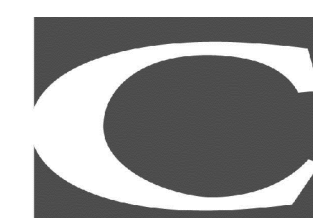

217 COMMERCIAL STREET, STE 200
PORTLAND, MAINE 04101
207.772.1502 V. F. 207.772.0112



75 YORK ST.
PORTLAND, ME 04101
P: 207.879.1838



400 COMMERCIAL ST.
SUITE 404
PORTLAND, ME 04101
P: 207.772.2891



190 US ROUTE ONE
PMB 346 FALMOUTH, ME
04105
P: 207.847.3445

PRICING DOCUMENTS

Project:
BAYSIDE ANCHOR
PHDC & Avesta
81 East Oxford Street
Portland, ME

Drawing: FIRE SPRINKLER - FLOOR PLANS

Scale: 1/8" = 1'-0"

Date: 9/1/15

Drawn by: JM

Revised:

FX101

