


GENERAL NOTES

- 1. SEE DRAWING PLO01 FOR GENERAL NOTES.
- 2. REFER TO ARCHITECTURAL DRAWINGS FOR UNDER SLAB RADON PITS. ABOVE SLAB RADON SHOWN THIS SHEET.
- 3. CONNECT SANITARY BRANCHES TO EACH PLUMBING FIXTURE. ROUTE PLUMBING BRANCHES DOWN TO UNDER SLAB SANITARY MAIN.
- 4. SLOPE SANITARY A MINIMUM 1/4" PER FOOT FOR PIPING LESS THAN 4" AND 1/8" PER FOOT FOR PIPING GREATER THAN 4".


KEY NOTES

- 1 PROVIDE WALL CLEAN OUT AT BASE OF RAIN LEADER / SECONDARY RISERS.

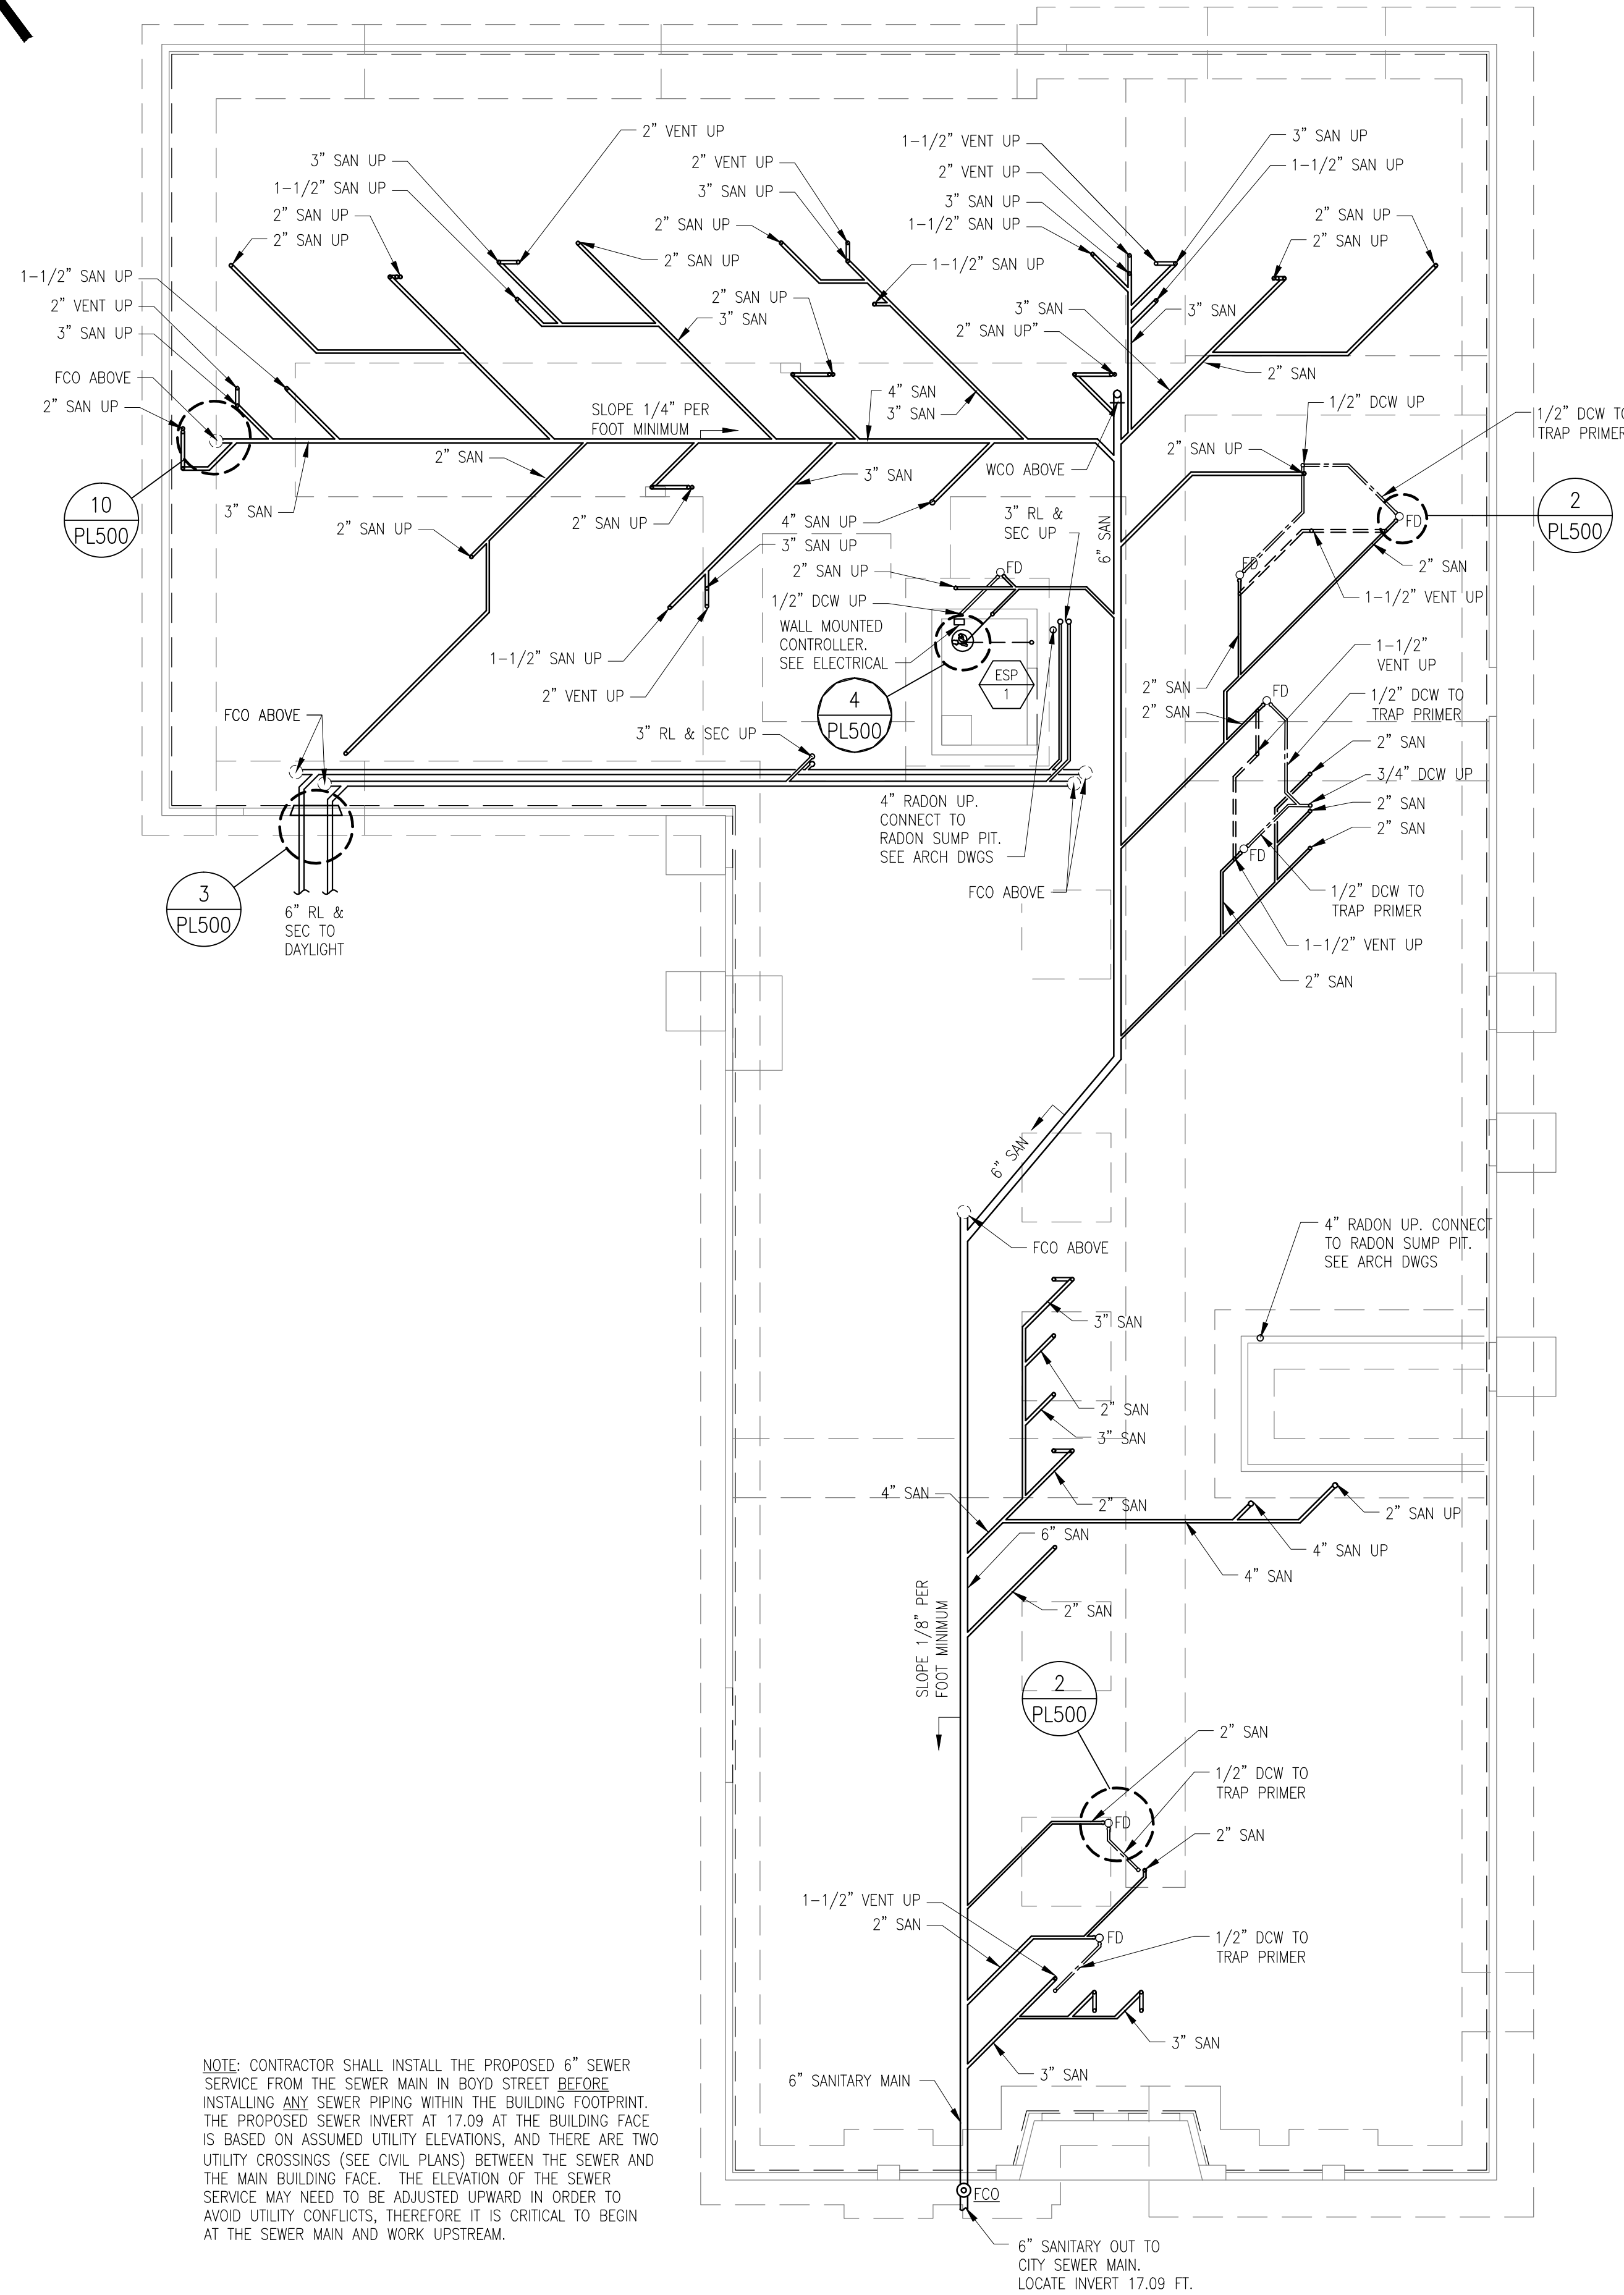

UNDERSLAB PIPING PLAN

SCALE: 1/8"=1'-0"

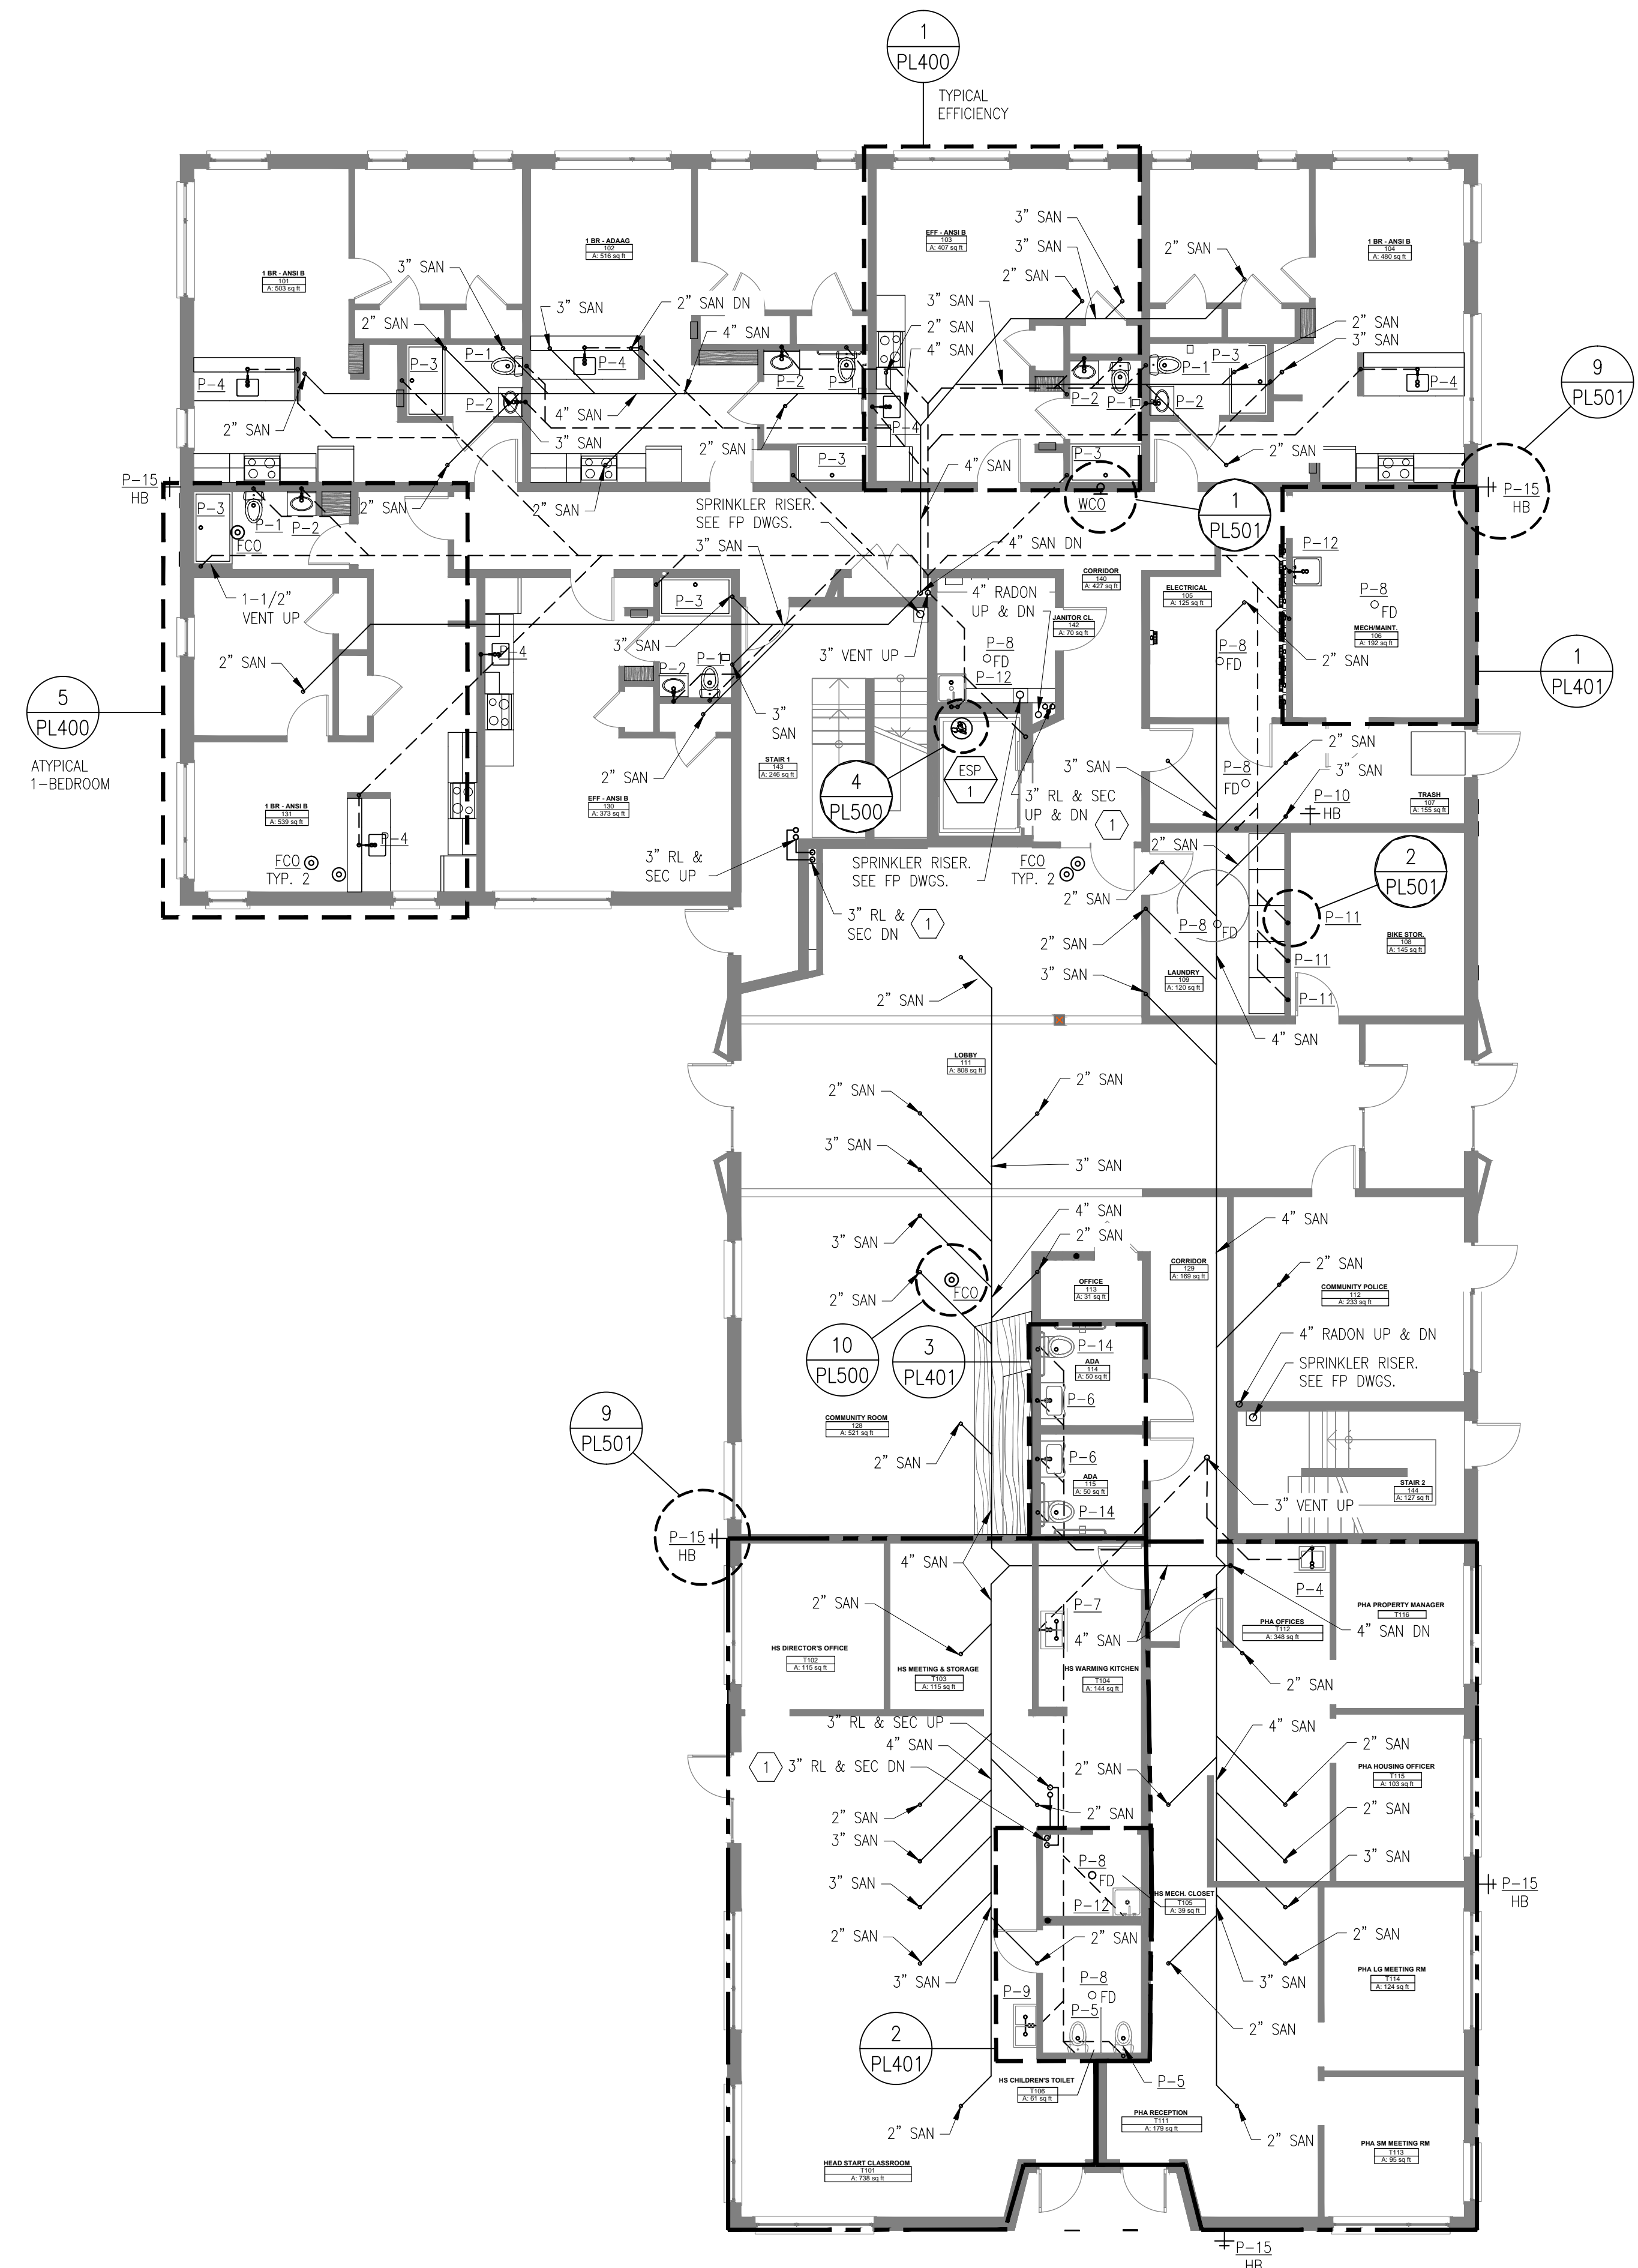

FIRST FLOOR DRAIN, WASTE, VENT PLAN

SCALE: 1/8"=1'-0"

HEAD START BASE BID SCOPE: ROUGH OUT SANITARY & VENT PIPING TO FIXTURE FLANGES.

HEAD START ALTERNATE FIT-OUT SCOPE: PLUMBING FIXTURES, VENT AND SANITARY LINE CONNECTIONS.

PHA BASE BID SCOPE: ROUGH OUT SANITARY & VENT PIPING TO FIXTURE FLANGES.

PHA ALTERNATE FIT-OUT SCOPE: PLUMBING FIXTURES, VENT AND SANITARY LINE CONNECTIONS.



424 FORE ST. PORTLAND, ME 04101 207-842-2888



14 BAXTER BLVD PORTLAND, ME 04101 P: 207.773.4753



307 CUMBERLAND AVE PORTLAND, ME 04101 P: 207.553.7777



217 COMMERCIAL STREET, SUITE 200 PORTLAND, MAINE 04101 207.772.1522 V. F. 207.772.0112



75 YORK ST. PORTLAND, ME 04101 P: 207.879.1838



400 COMMERCIAL ST. SUITE 404 PORTLAND, ME 04101 P: 207.772.2891



190 US ROUTE ONE PMB 346 FALMOUTH, ME 04105 P: 207.847.3445

PRICING DOCUMENTS

Project: BAYSIDE ANCHOR PHDC & Avesta 81 East Oxford Street Portland, ME


Drawing: PLUMBING UNDERSLAB PIPING & FIRST FLOOR WASTE & VENT PLANS

Scale: 1/8" = 1'-0"

Drawn by: AEW

Date: 9/1/15

Revised:

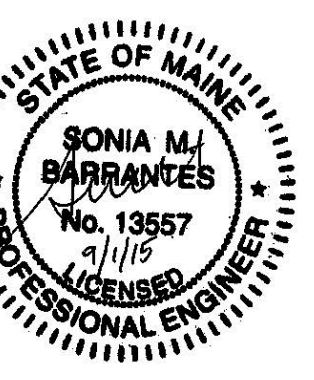

PL100