
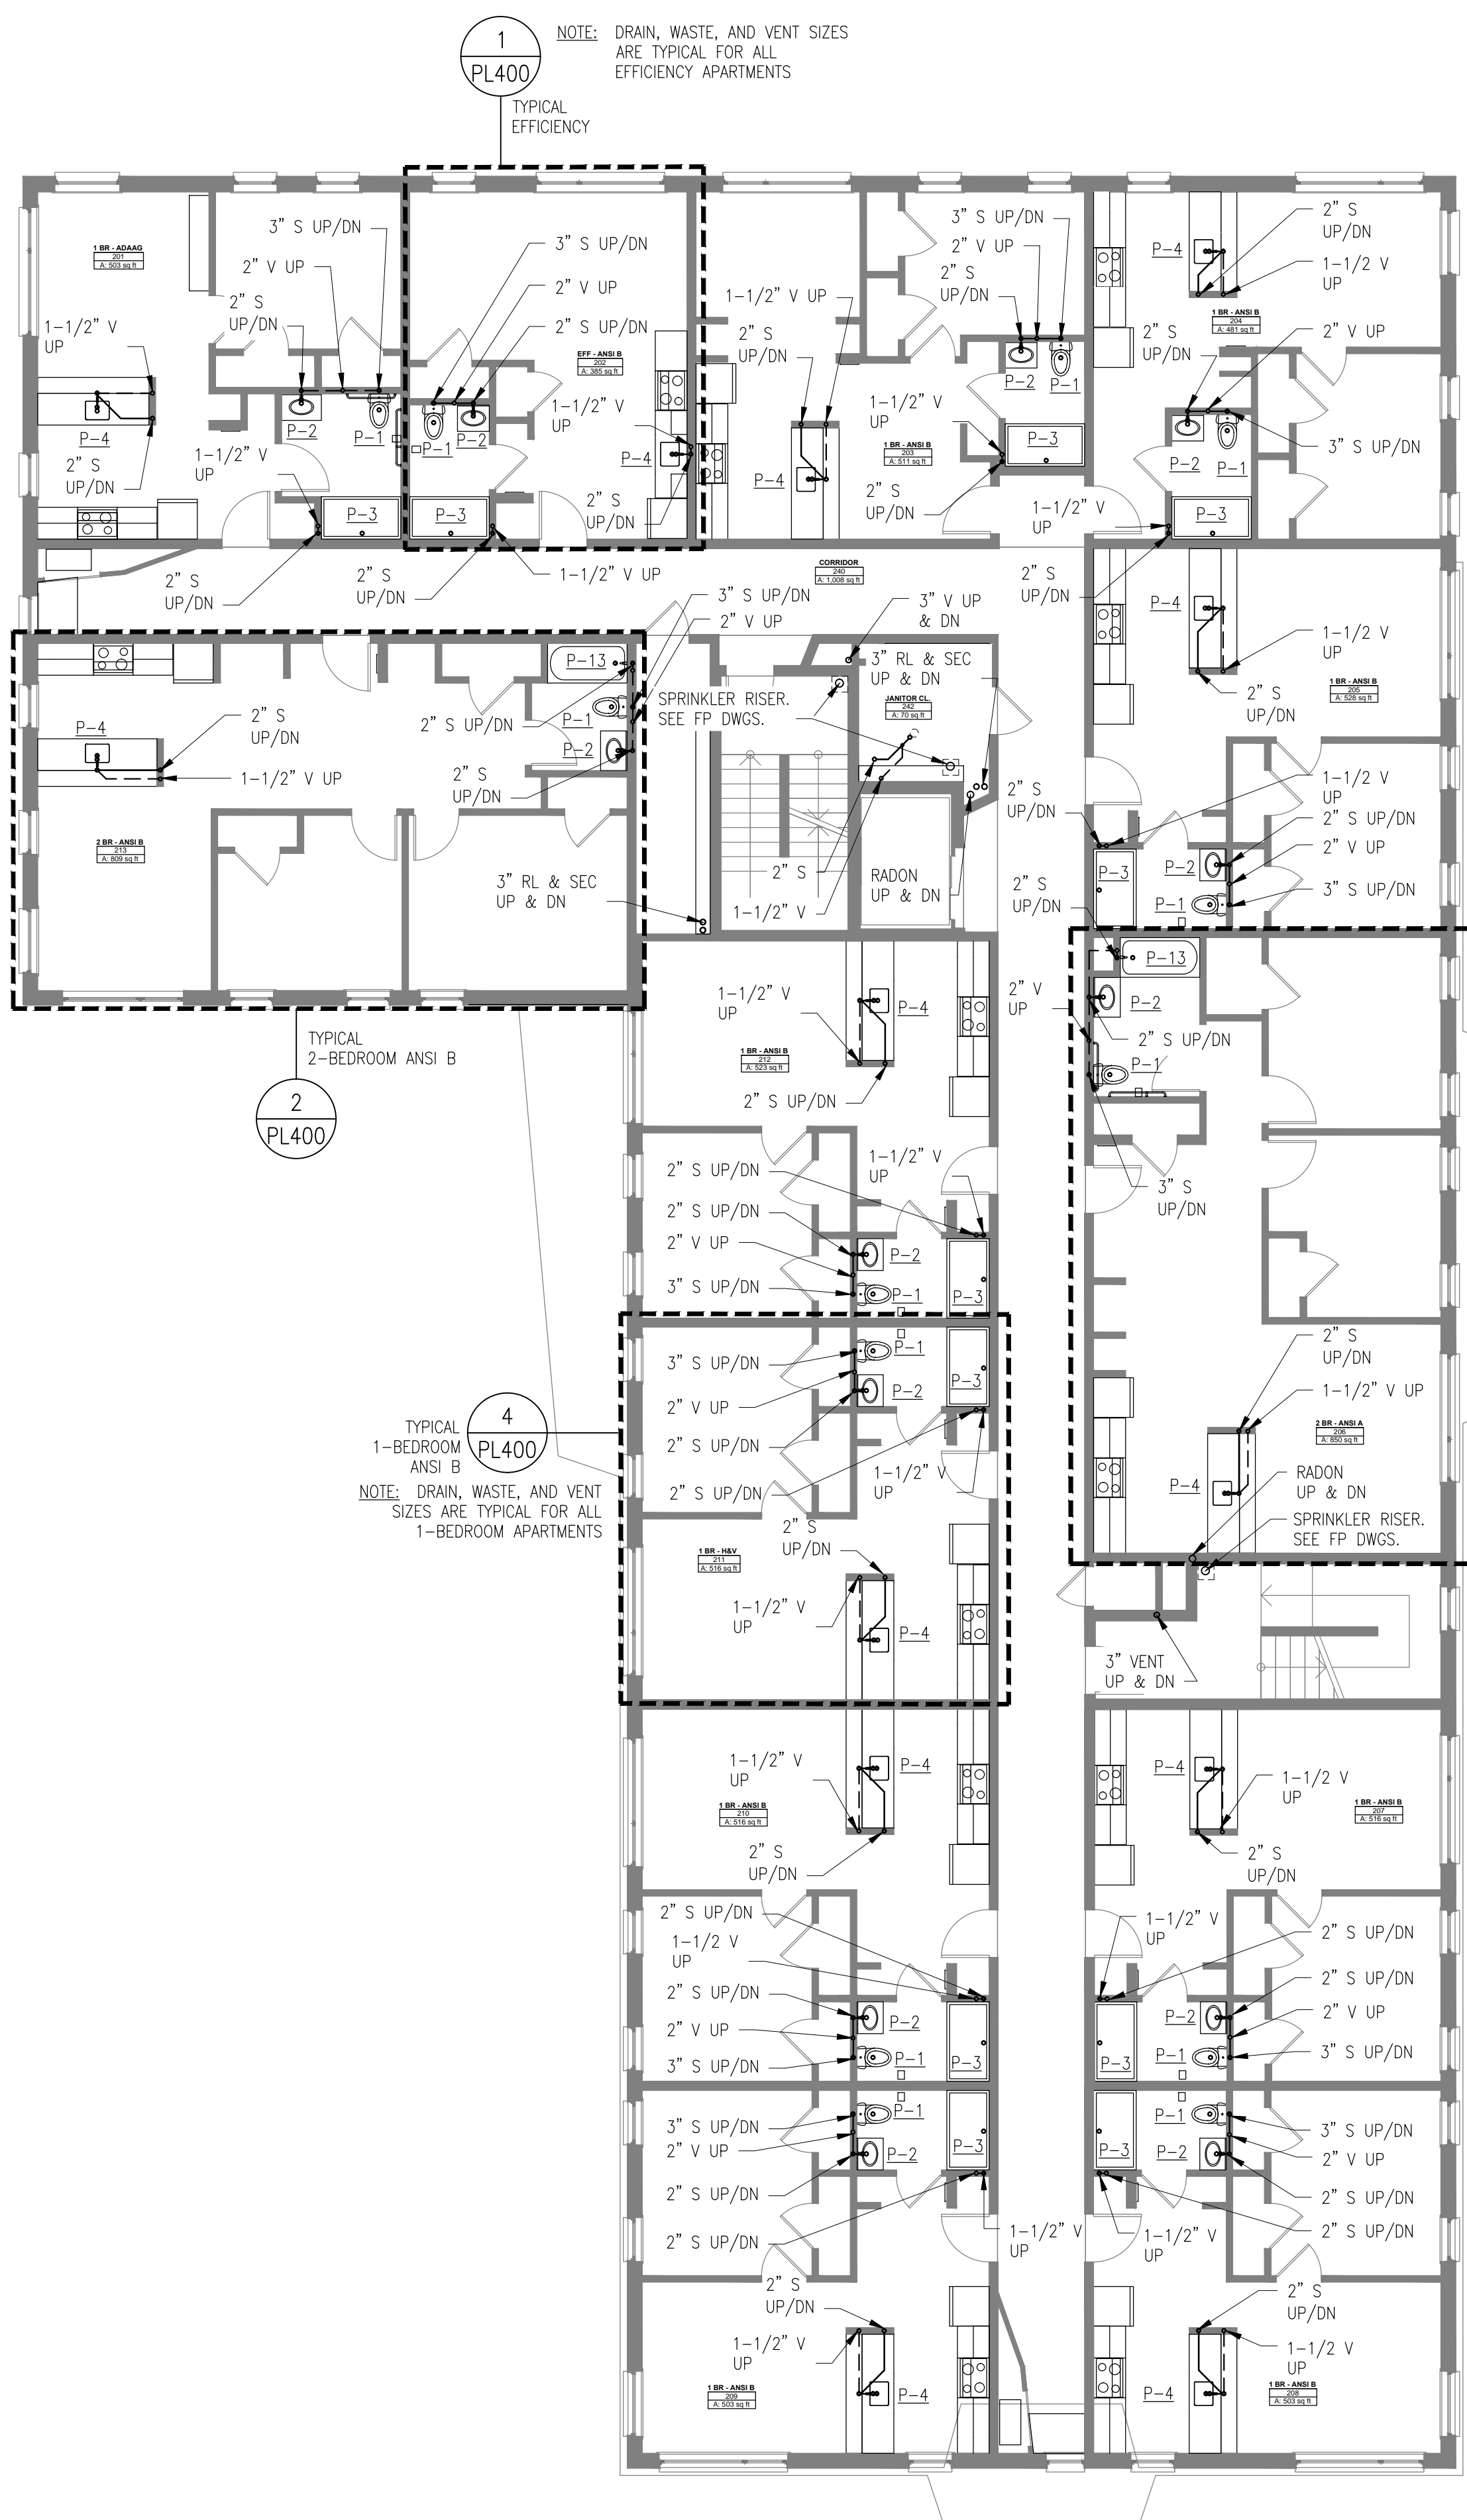



GENERAL NOTES

- SEE DRAWING PL001 FOR GENERAL NOTES.
- CONNECT SANITARY BRANCHES TO EACH PLUMBING FIXTURE. ROUTE PLUMBING BRANCHES DOWN TO UNDER SLAB SANITARY MAIN.
- CONNECT SANITARY VENT PIPING TO EACH PLUMBING FIXTURE. ROUTE SANITARY VENT PIPING UP THROUGH THE ROOF. SEE DRAWING PL102 FOR VENT THROUGH ROOF LOCATIONS.
- REFER TO TYPICAL RISER DIAGRAMS FOR RISER SIZING.
- REFER TO ENLARGED FLOOR PLANS FOR FIXTURE BRANCH SIZES.

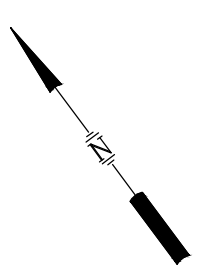

SECOND FLOOR DRAIN WASTE VENT PLAN

SCALE: 1/8"=1'-0"

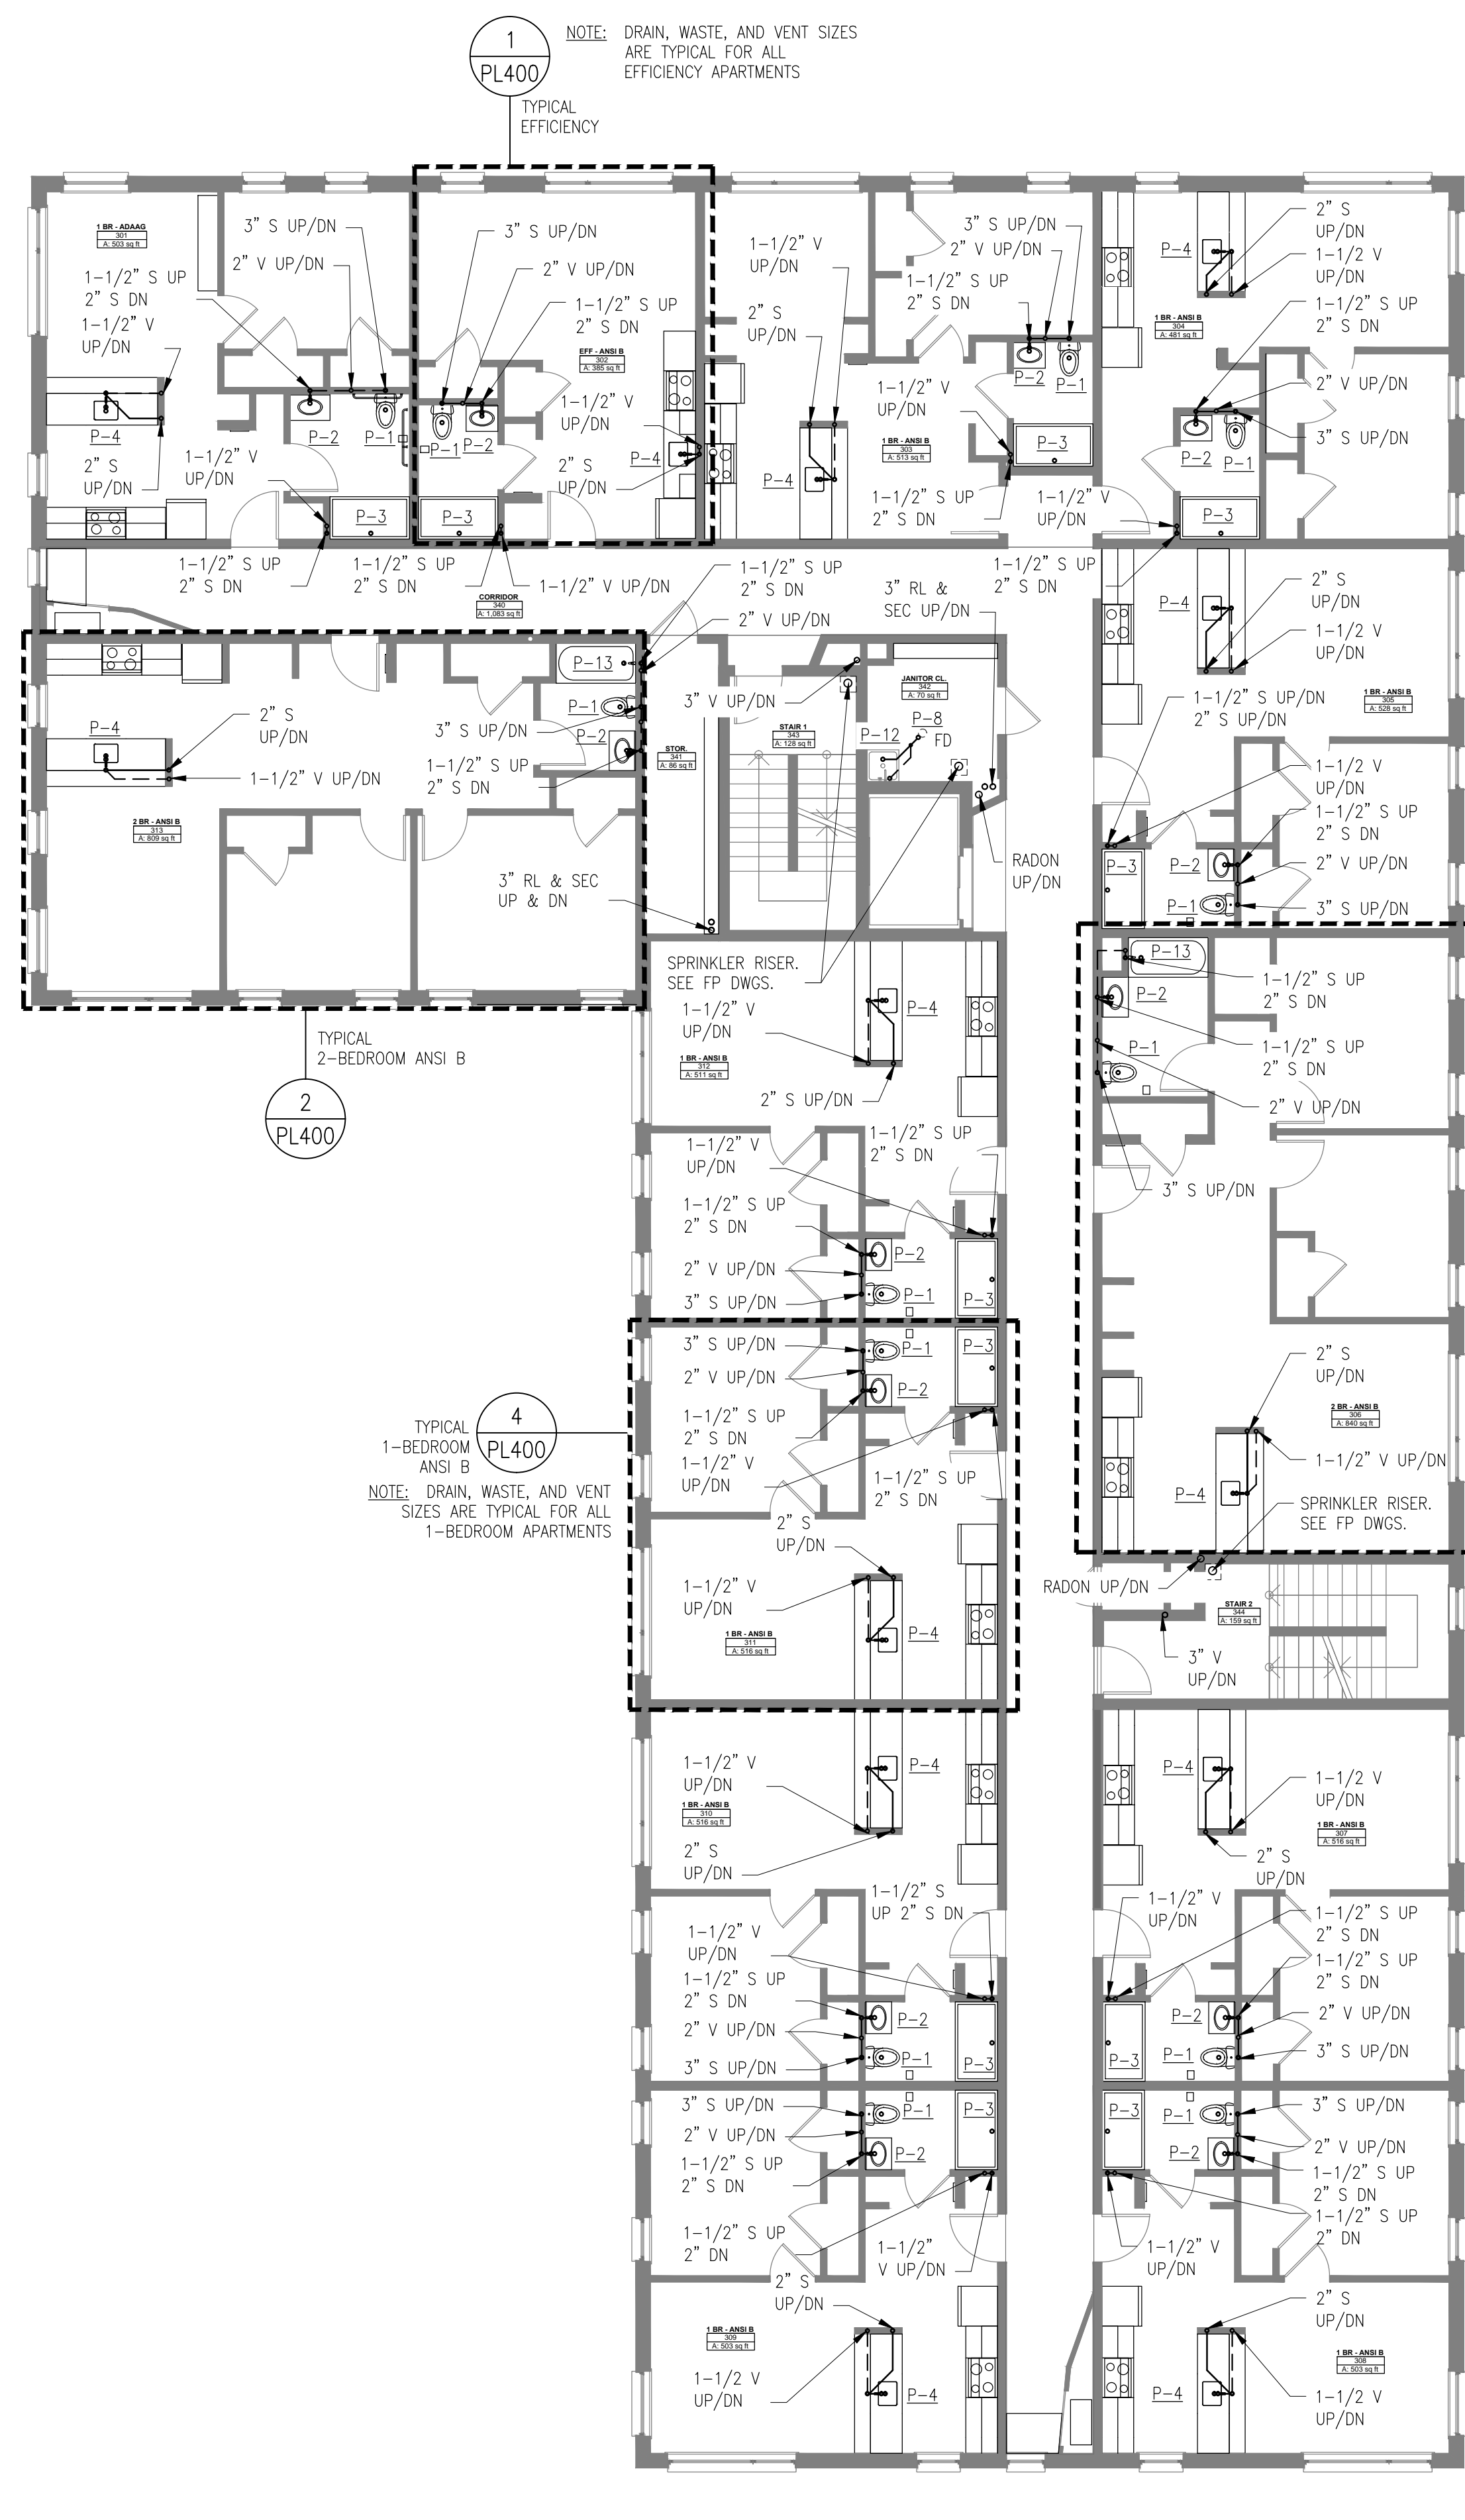

THIRD FLOOR DRAIN, WASTE, VENT PLAN


SCALE: 1/8"=1'-0"

KAPLAN THOMPSON ARCHITECTS
424 FORE ST.
PORTLAND, ME 04101
207-842-2888

PORTLAND HOUSING MAINE
14 BAXTER BLVD
PORTLAND, ME 04101
P: 207.773.4753



AVESTA HOUSING
307 CUMBERLAND AVE
PORTLAND, ME 04101
P: 207.553.7777

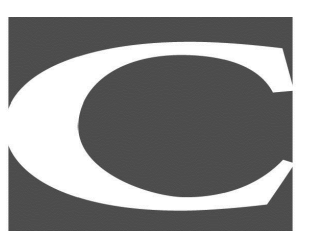


CARROLL ASSOCIATES LANDSCAPE ARCHITECTS
217 COMMERCIAL STREET, SUITE 200
PORTLAND, MAINE 04101
207.772.1992 V. F. 207.772.0712



BECKER CONSULTING ENGINEERS AND SCIENTISTS
75 YORK ST.
PORTLAND, ME 04101
P: 207.879.1838



RANSOM CONSULTING ENGINEERS AND SCIENTISTS
400 COMMERCIAL ST. SUITE 404
PORTLAND, ME 04101
P: 207.772.2891

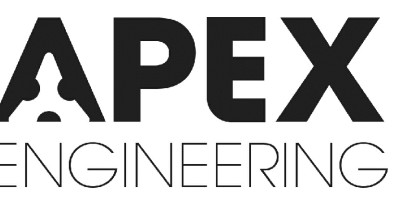

APEX ENGINEERING
190 US ROUTE ONE
PMB 346 FALMOUTH, ME
04105
P: 207.847.3445

PRICING DOCUMENTS

Project: BAYSIDE ANCHOR
PHDC & Avesta
81 East Oxford Street
Portland, ME

Drawing: PLUMBING SECOND & THIRD FLOOR DRAIN, WASTE, & VENT PLANS

Scale: 1/8" = 1'-0"

Drawn by: AEW

Date: 9/1/15

Revised:

