


GENERAL NOTES

- 1. SEE DRAWING PLO01 FOR GENERAL NOTES.
- 2. CONNECT SANITARY BRANCHES TO EACH PLUMBING FIXTURE.
- 3. SLOPE RAIN LEADERS AND SECONDARY PIPING A MINIMUM OF 1/4" PER FOOT.


KEY NOTES

- 1 BI-FUNCTIONAL ROOF DRAIN FOR PRIMARY AND OVERFLOW DRAINAGE.
- 2 SEE ELECTRICAL DRAWINGS FOR ELECTRICAL SUPPLY TO FUTURE ROOF MOUNTED RADON FAN.

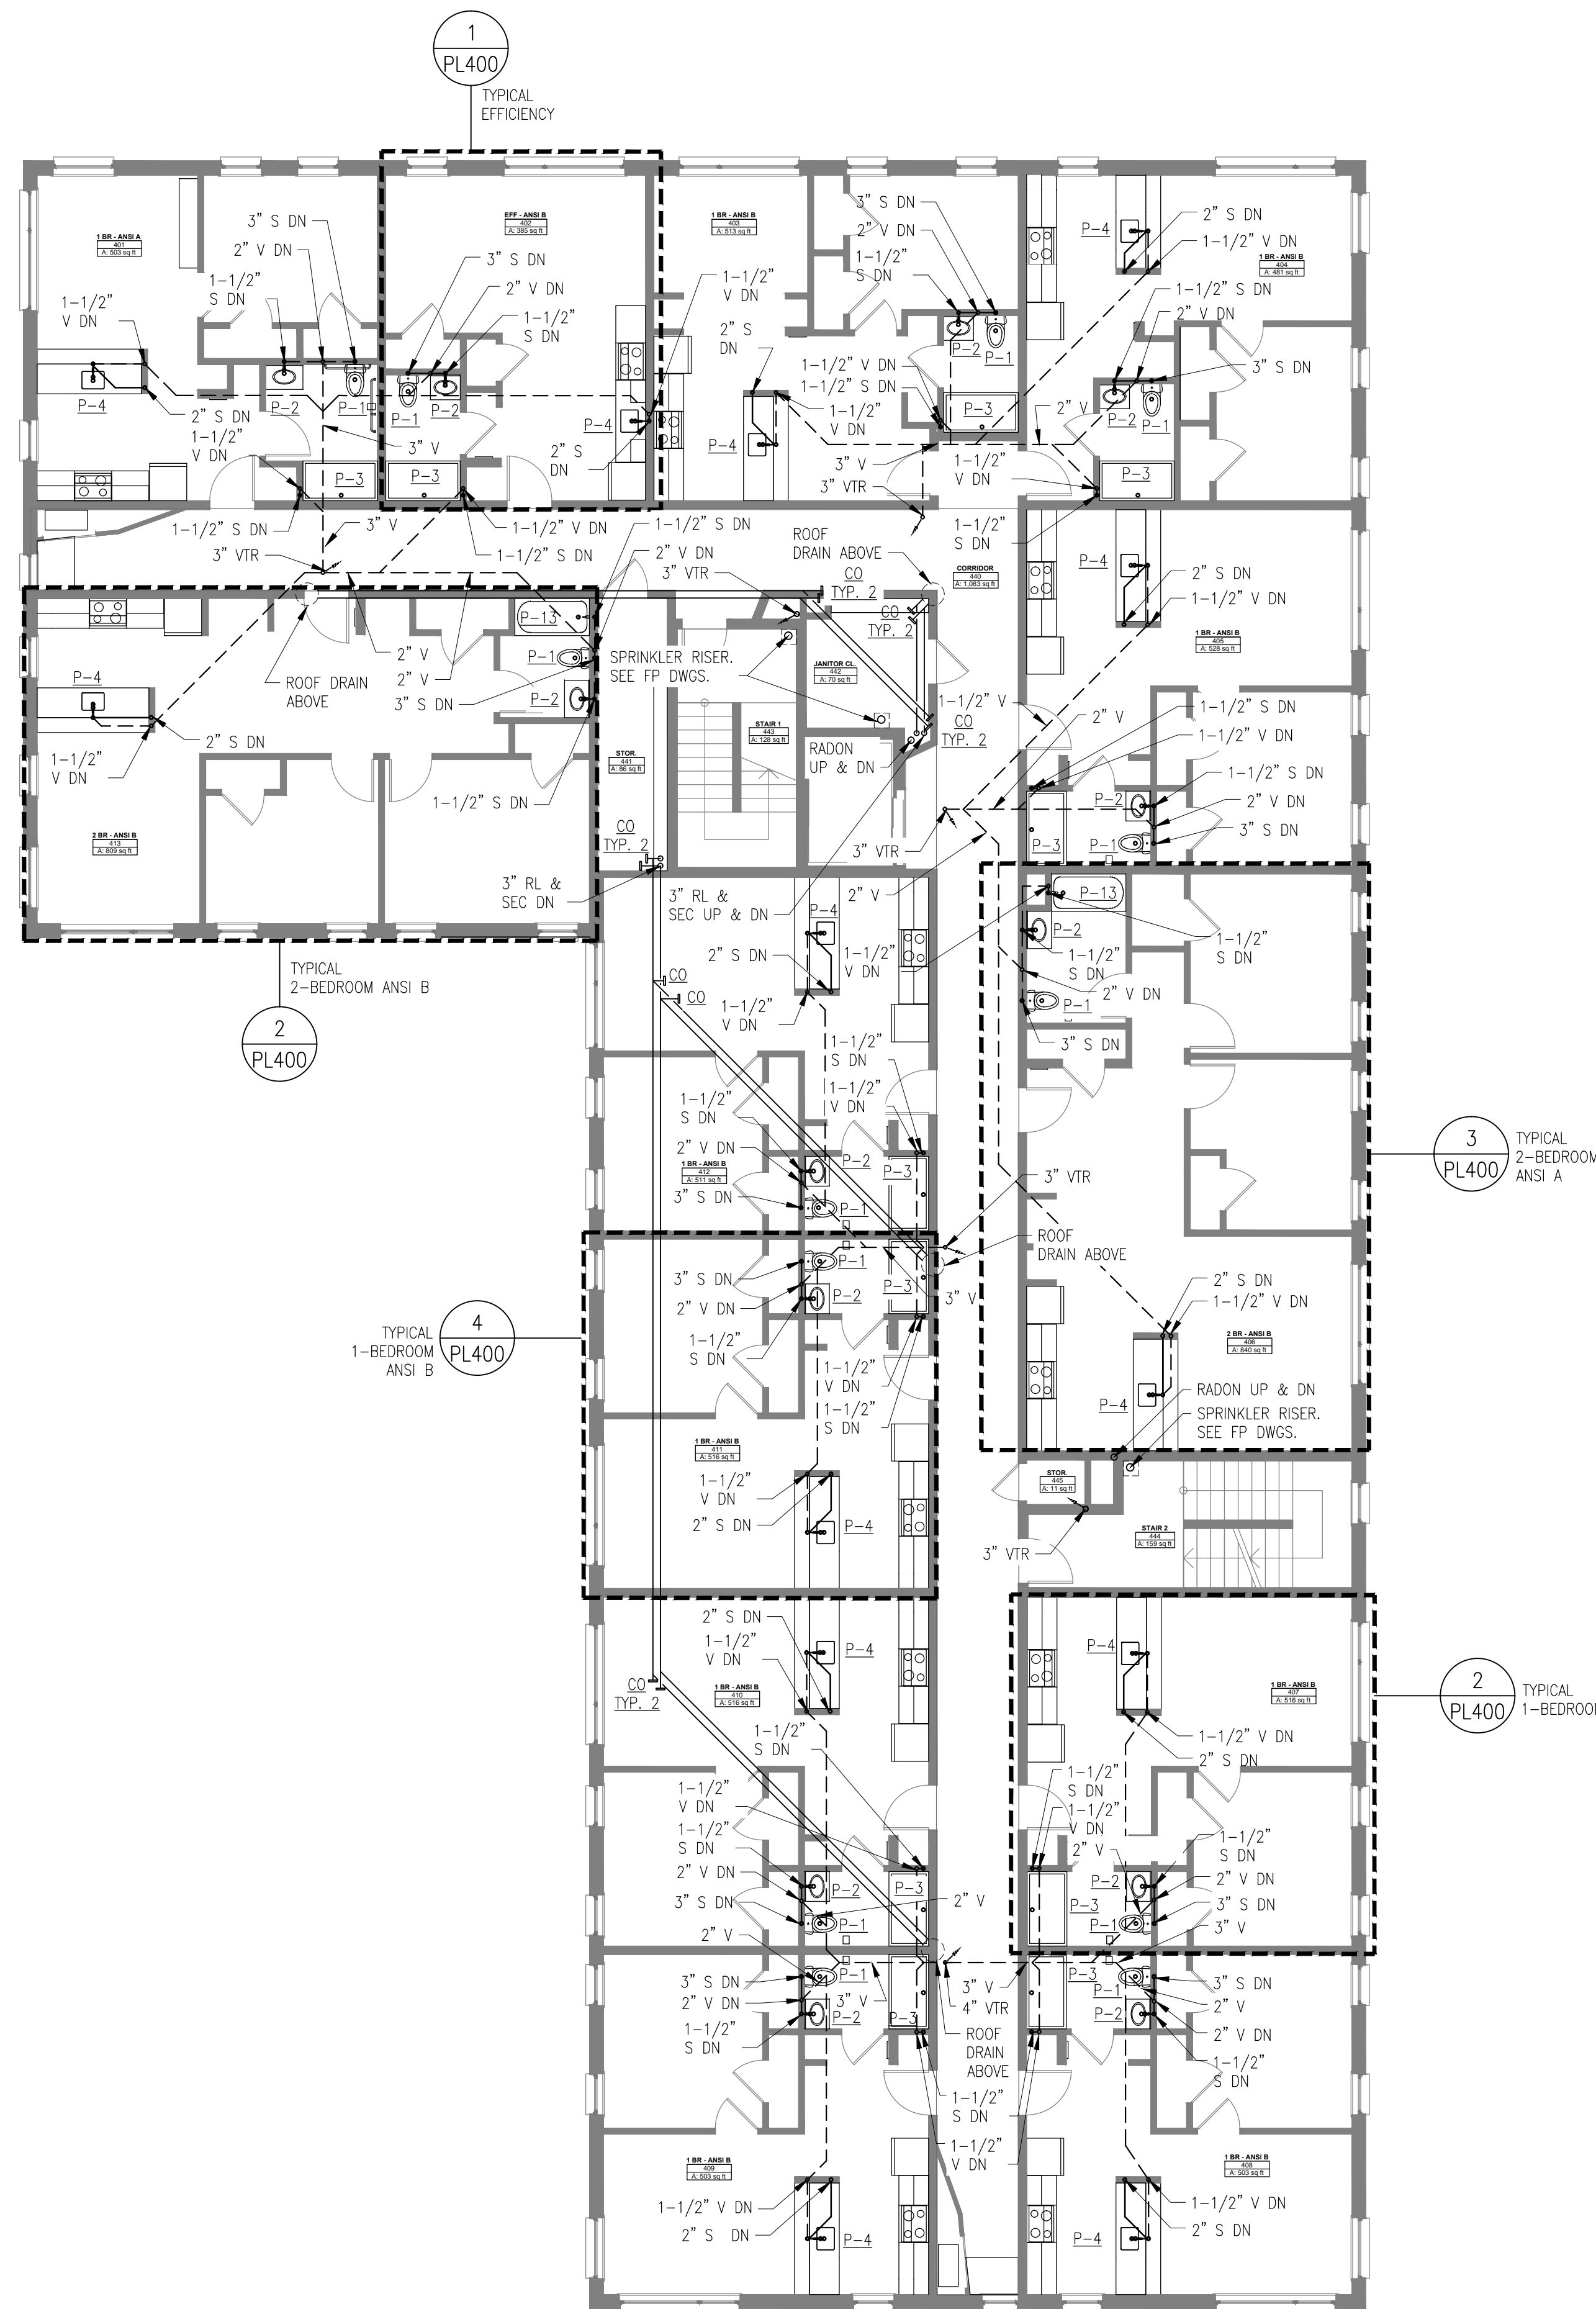

FOURTH FLOOR DRAIN, WASTE, VENT PLAN

SCALE: 1/8"=1'-0"

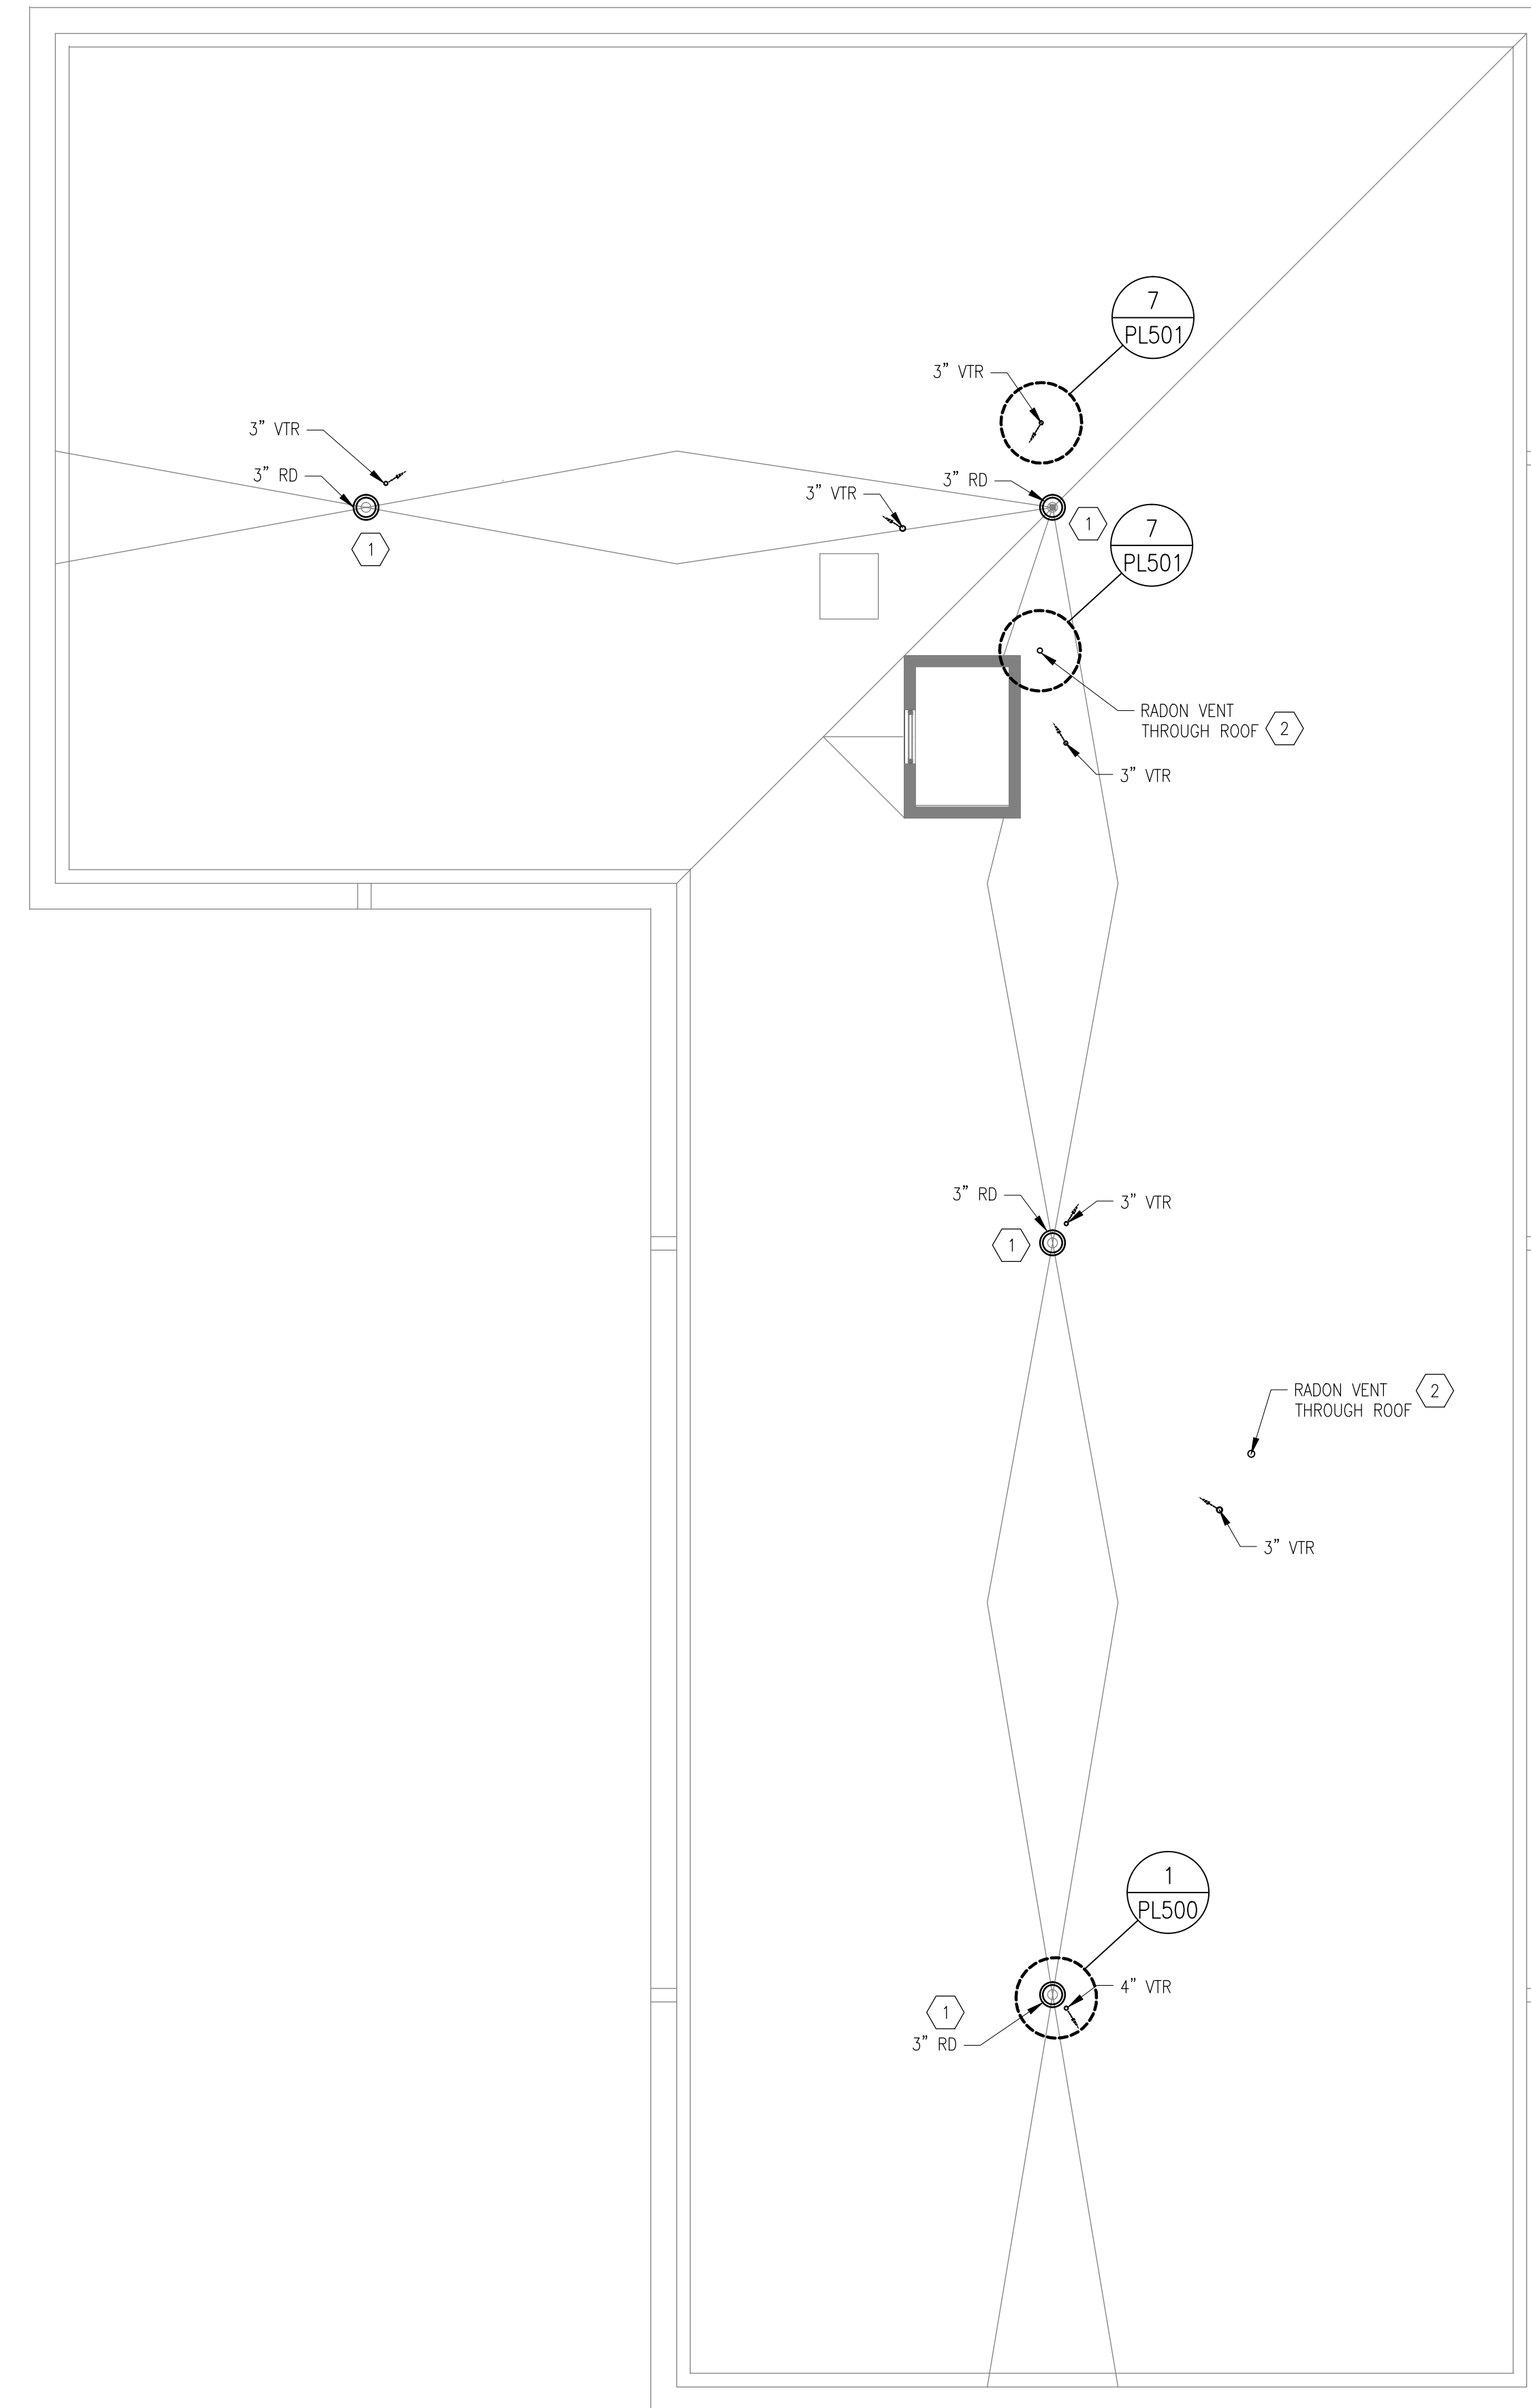

PLUMBING ROOF PLAN

SCALE: 1/8"=1'-0"