



GENERAL NOTES

1. "RTF" IS THE ABBREVIATION FOR "RUN TO FIXTURES" RUN PIPING TO ALL PLUMBING FIXTURES IN THE RESPECTIVE UNIT. SEE TYPICAL APARTMENT DOMESTIC WATER PIPING CONFIGURATIONS FOR EXAMPLES OF LAYOUT AND SIZES. MODIFY AS REQUIRED FOR INDIVIDUAL FIELD CONDITIONS.
2. SEE DRAWING PL100 FOR UNDER SLAB PIPING.
3. SEE DRAWING PLO01 FOR GENERAL NOTES.

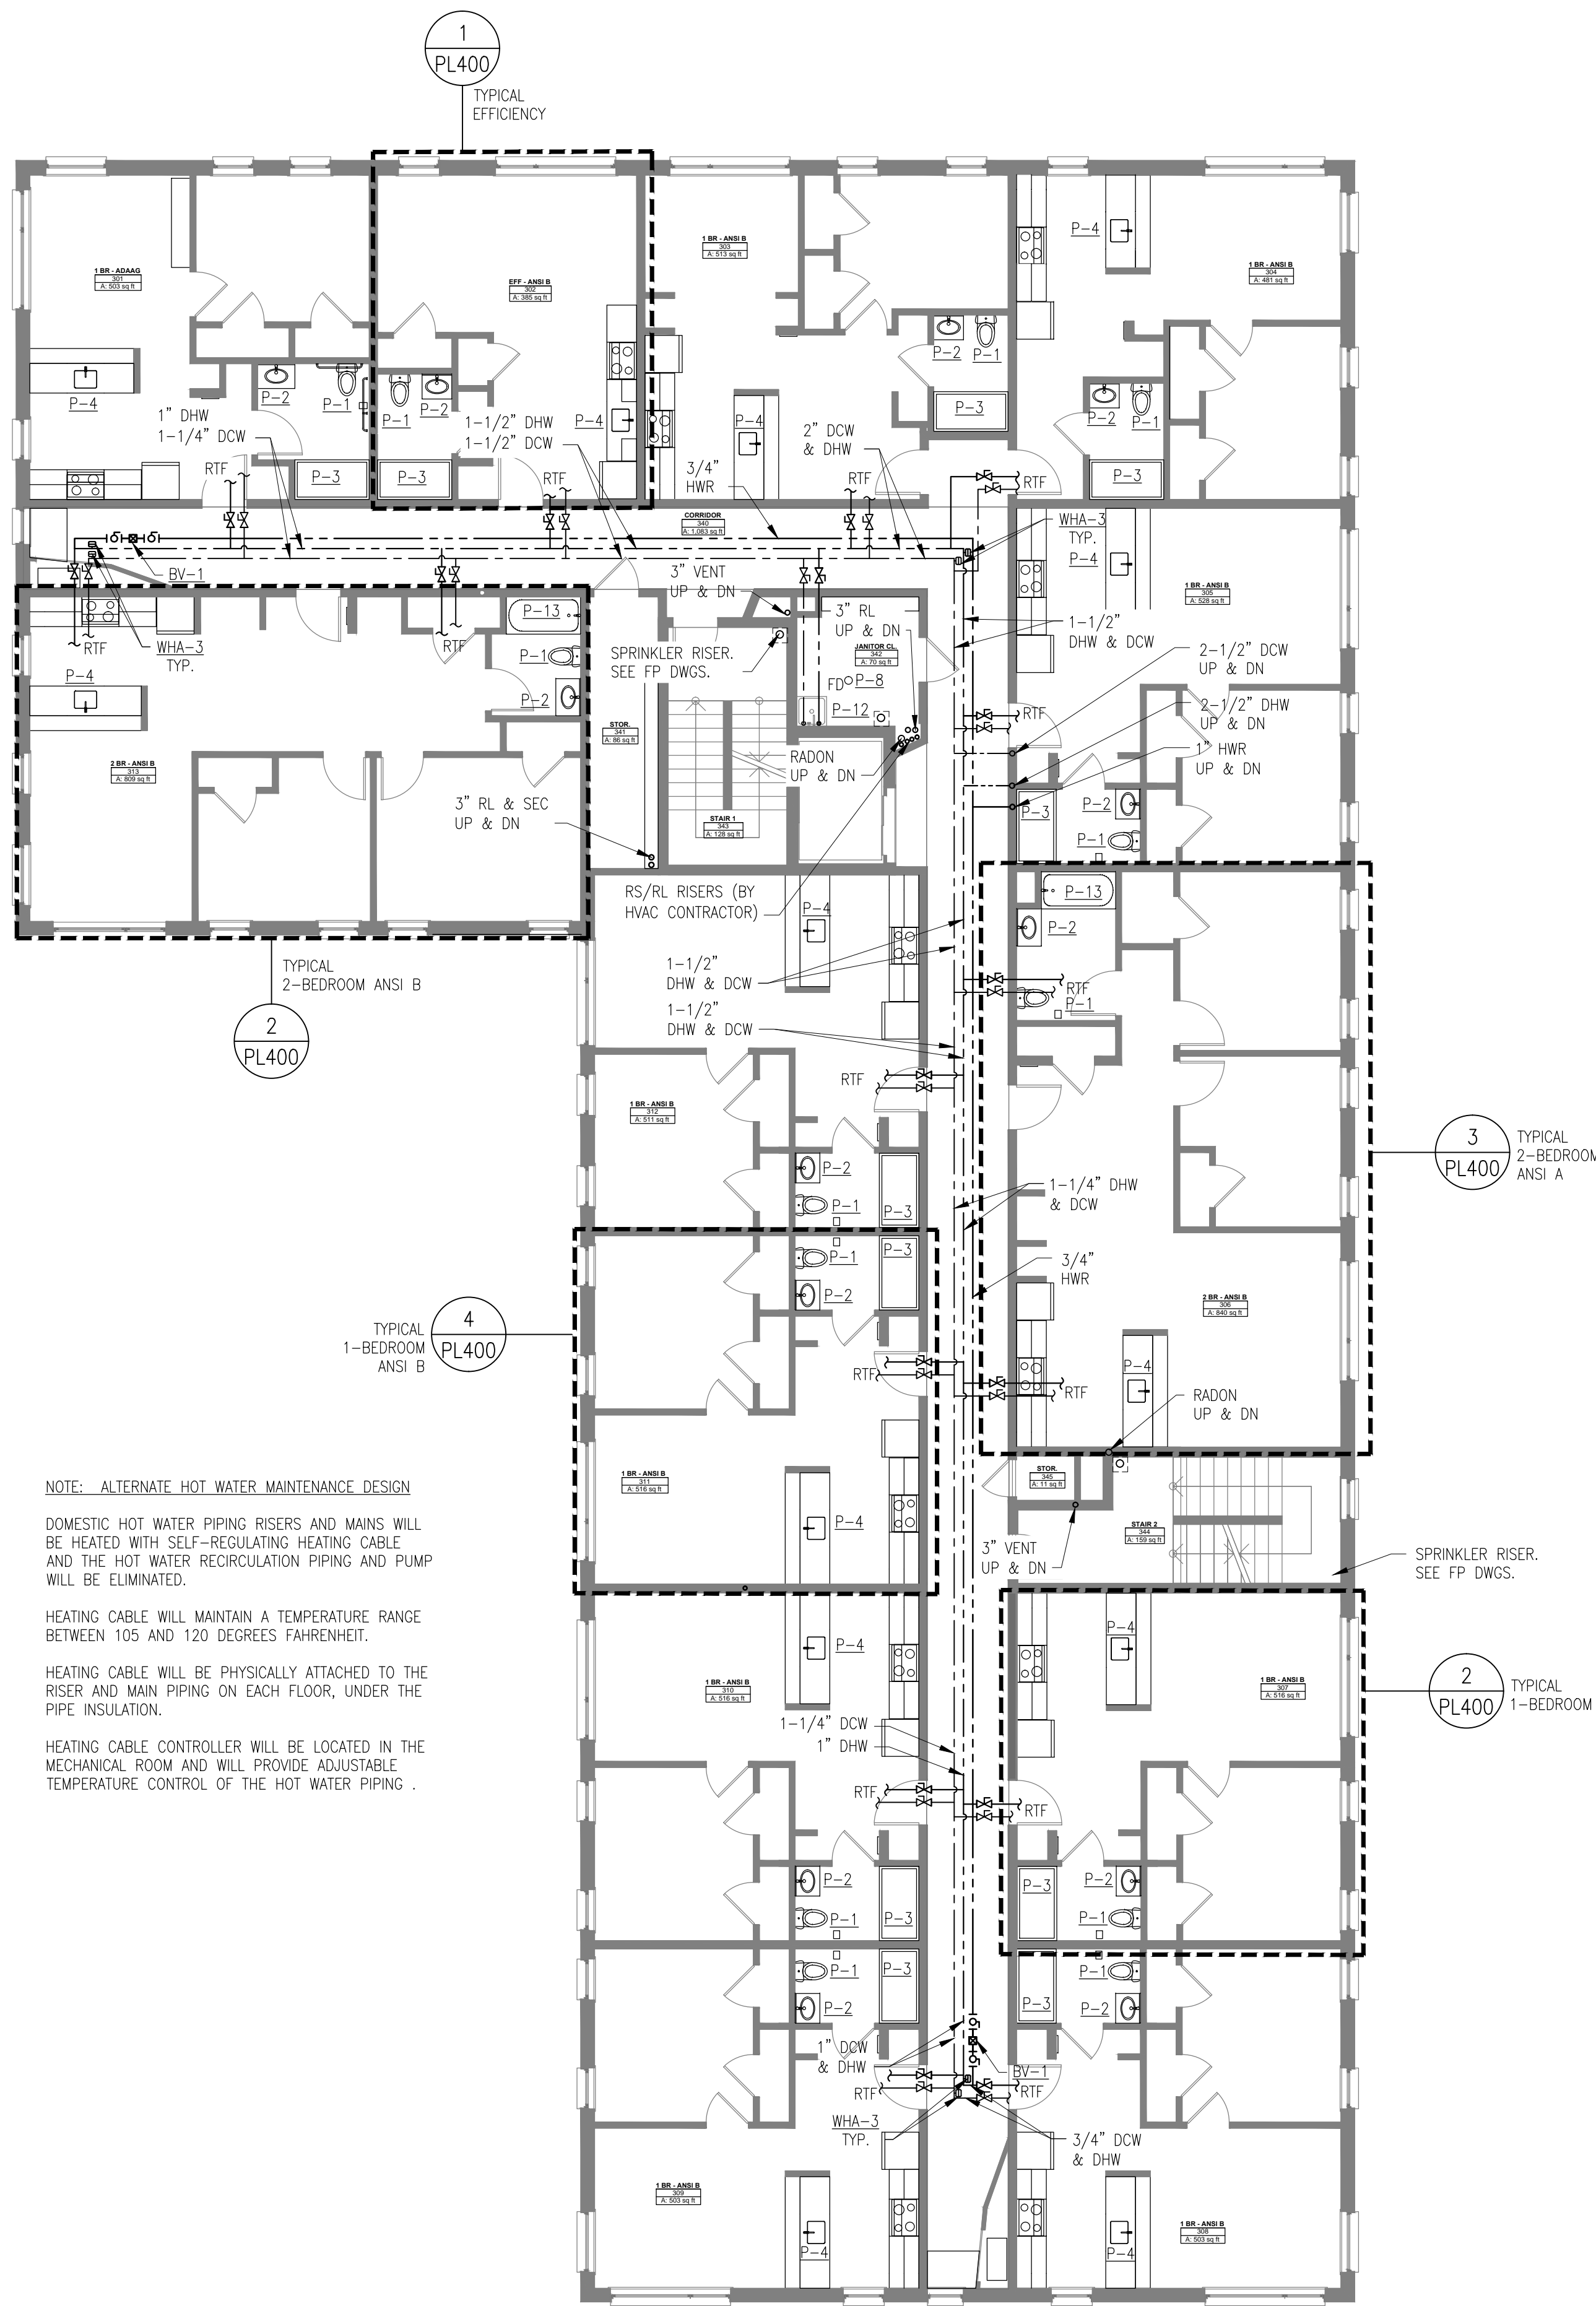

THIRD FLOOR PIPING PLAN

SCALE: 1/8"=1'-0"

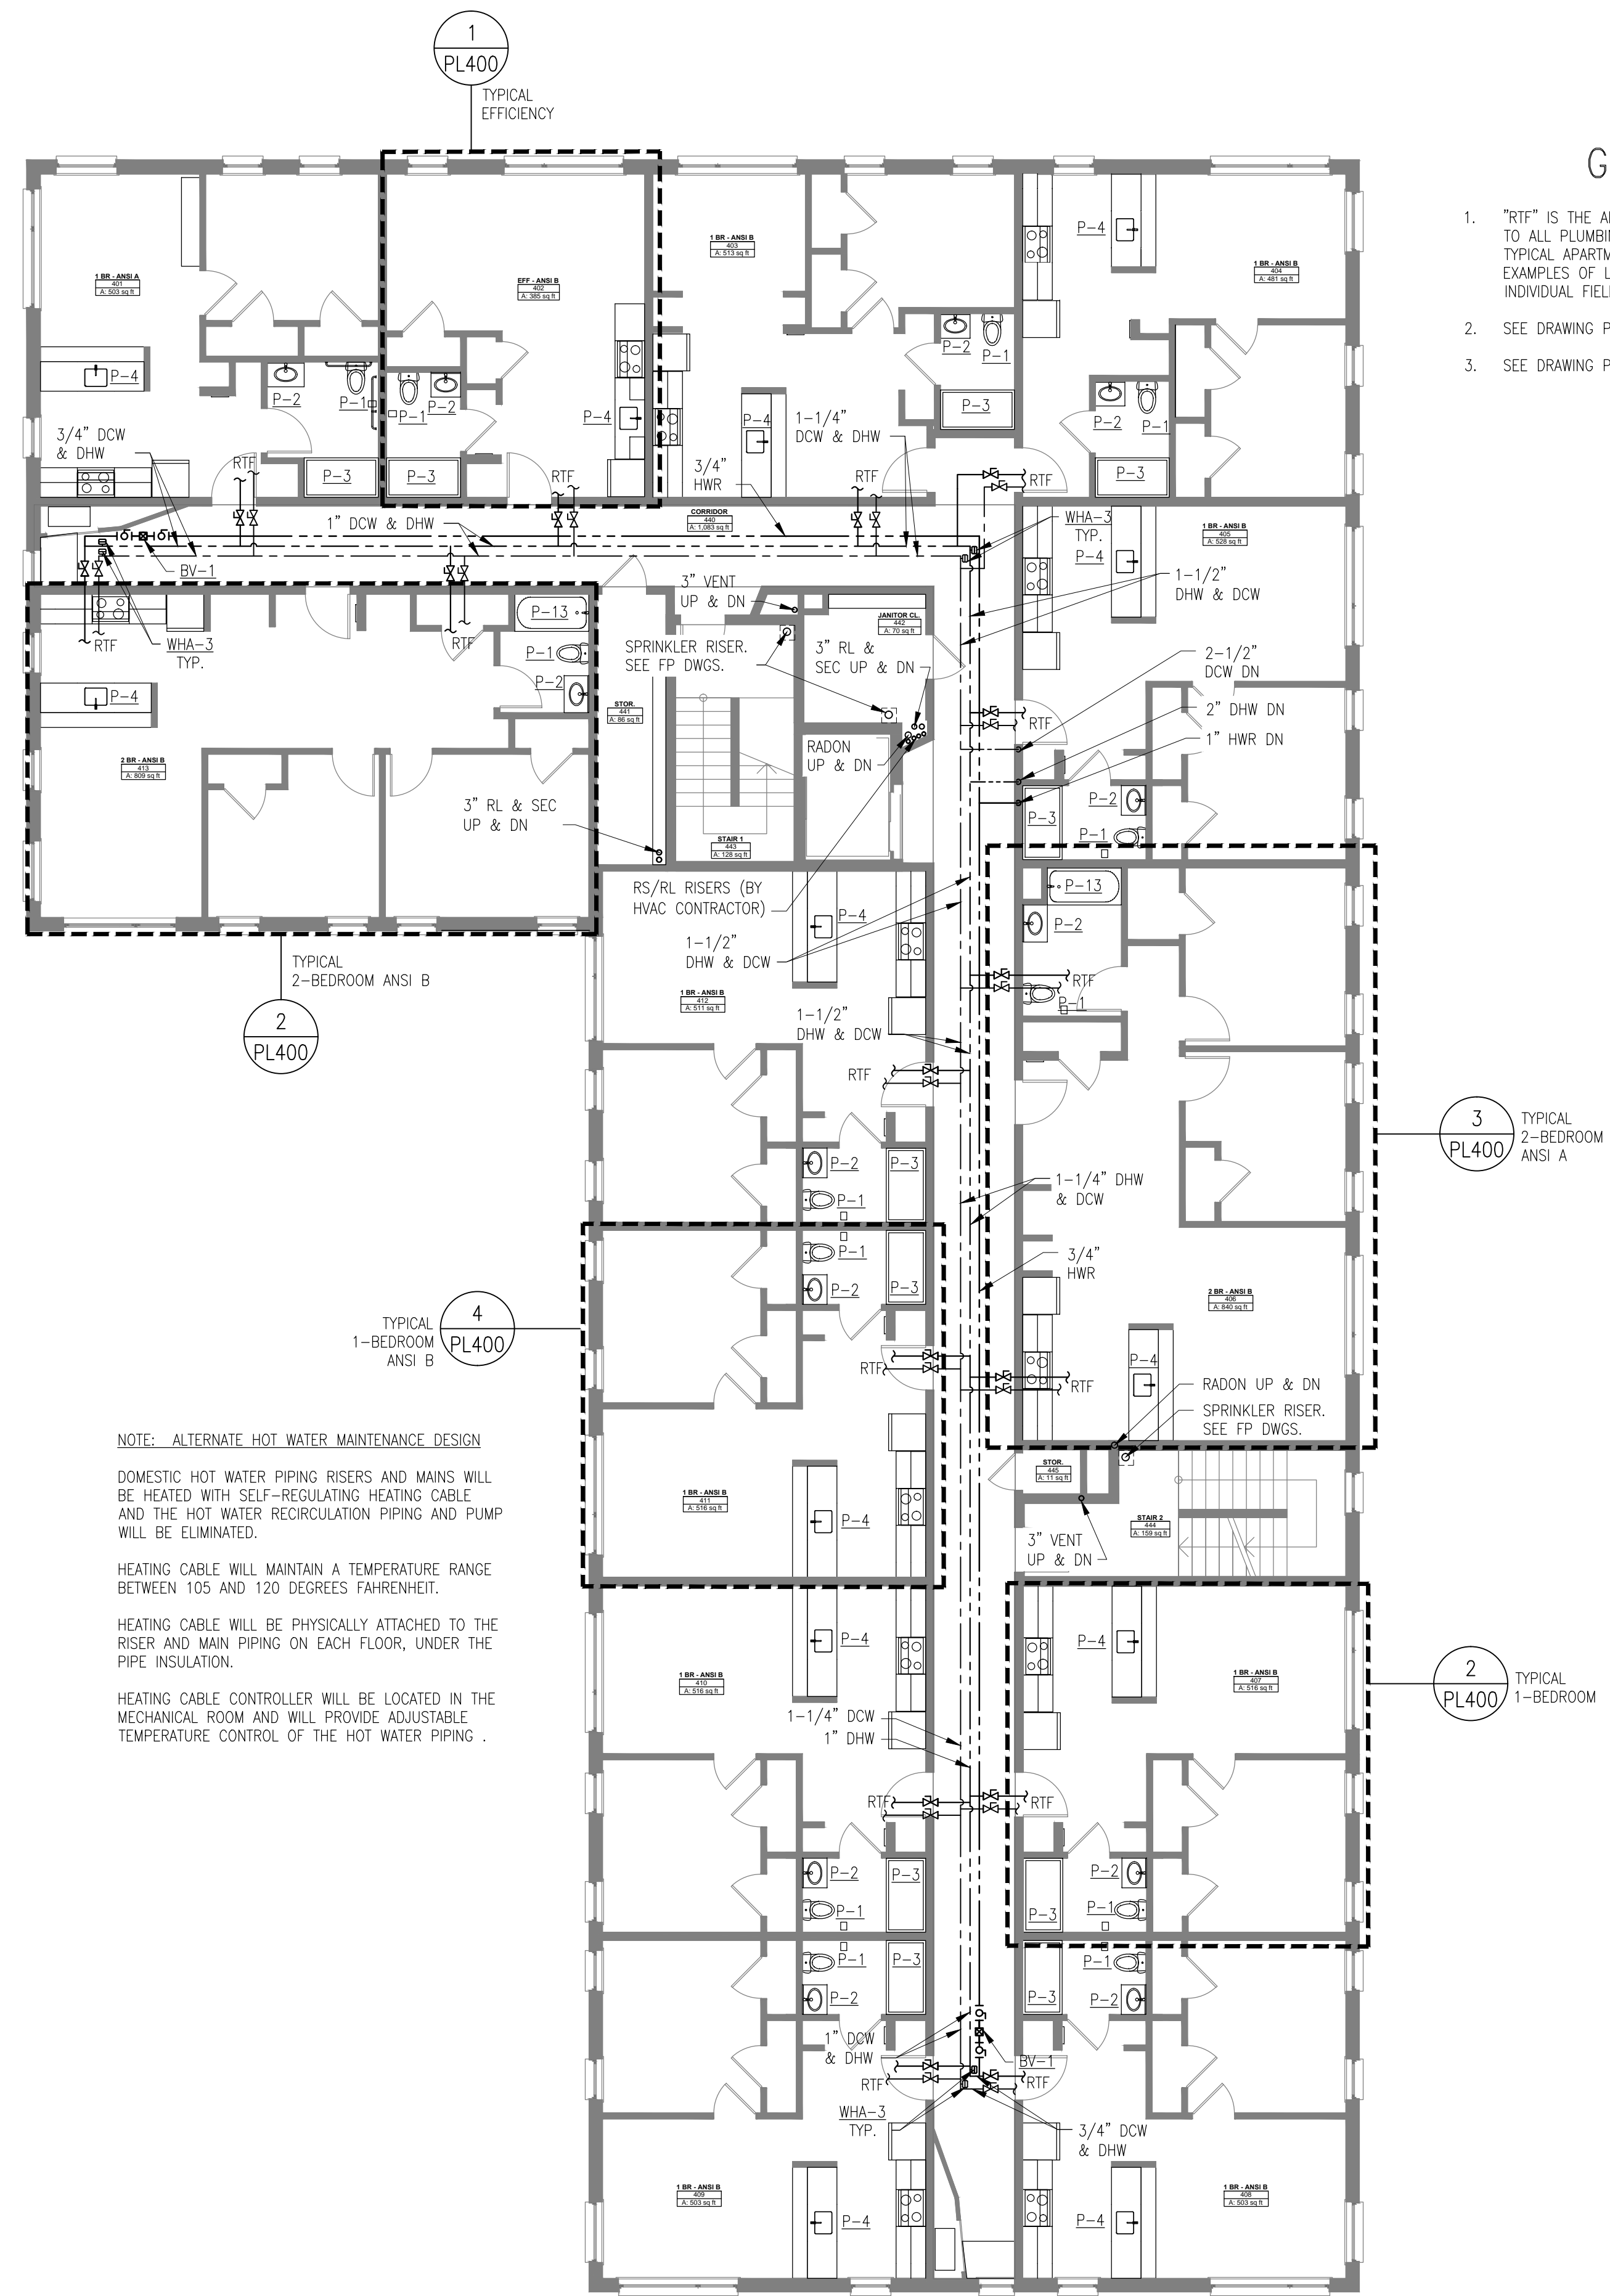

FOURTH FLOOR PIPING PLAN

SCALE: 1/8"=1'-0"




424 FORE ST.
PORTLAND, ME 04101
207-842-2888



14 BAXTER BLVD
PORTLAND, ME 04101
P: 207.773.4753



307 CUMBERLAND AVE
PORTLAND, ME 04101
P: 207.553.7777

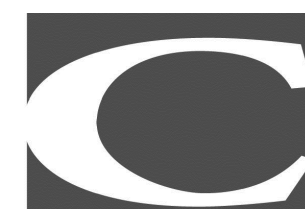


217 COMMERCIAL STREET, STE 200
PORTLAND, MAINE 04101
207.772.1592 V. F. 207.772.0712



75 YORK ST.
PORTLAND, ME 04101
P: 207.879.1838



400 COMMERCIAL ST.
SUITE 404
PORTLAND, ME 04101
P: 207.772.2891

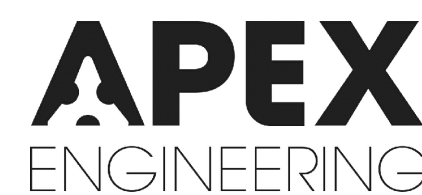

190 US ROUTE ONE
PMB 346 FALMOUTH, ME
04105
P: 207.847.3445

PRICING DOCUMENTS

Project: BAYSIDE ANCHOR
PHDC & Avesta
81 East Oxford Street
Portland, ME

Drawing: PLUMBING - THIRD & FOURTH FLOOR PIPING FLOOR PLANS

Scale: 1/8" = 1'-0"

Drawn by: AEW

Date: 9/1/15

Revised:

