


**35 Mayo Street Re-Model**  
Portland, Maine  
Fowler-Greeves Construction

**General Notes:**

1. See A2.4 for wall types and partition types and window schedule
2. Place additional sprinkler heads at windows located in the 1 hour rated wall assembly

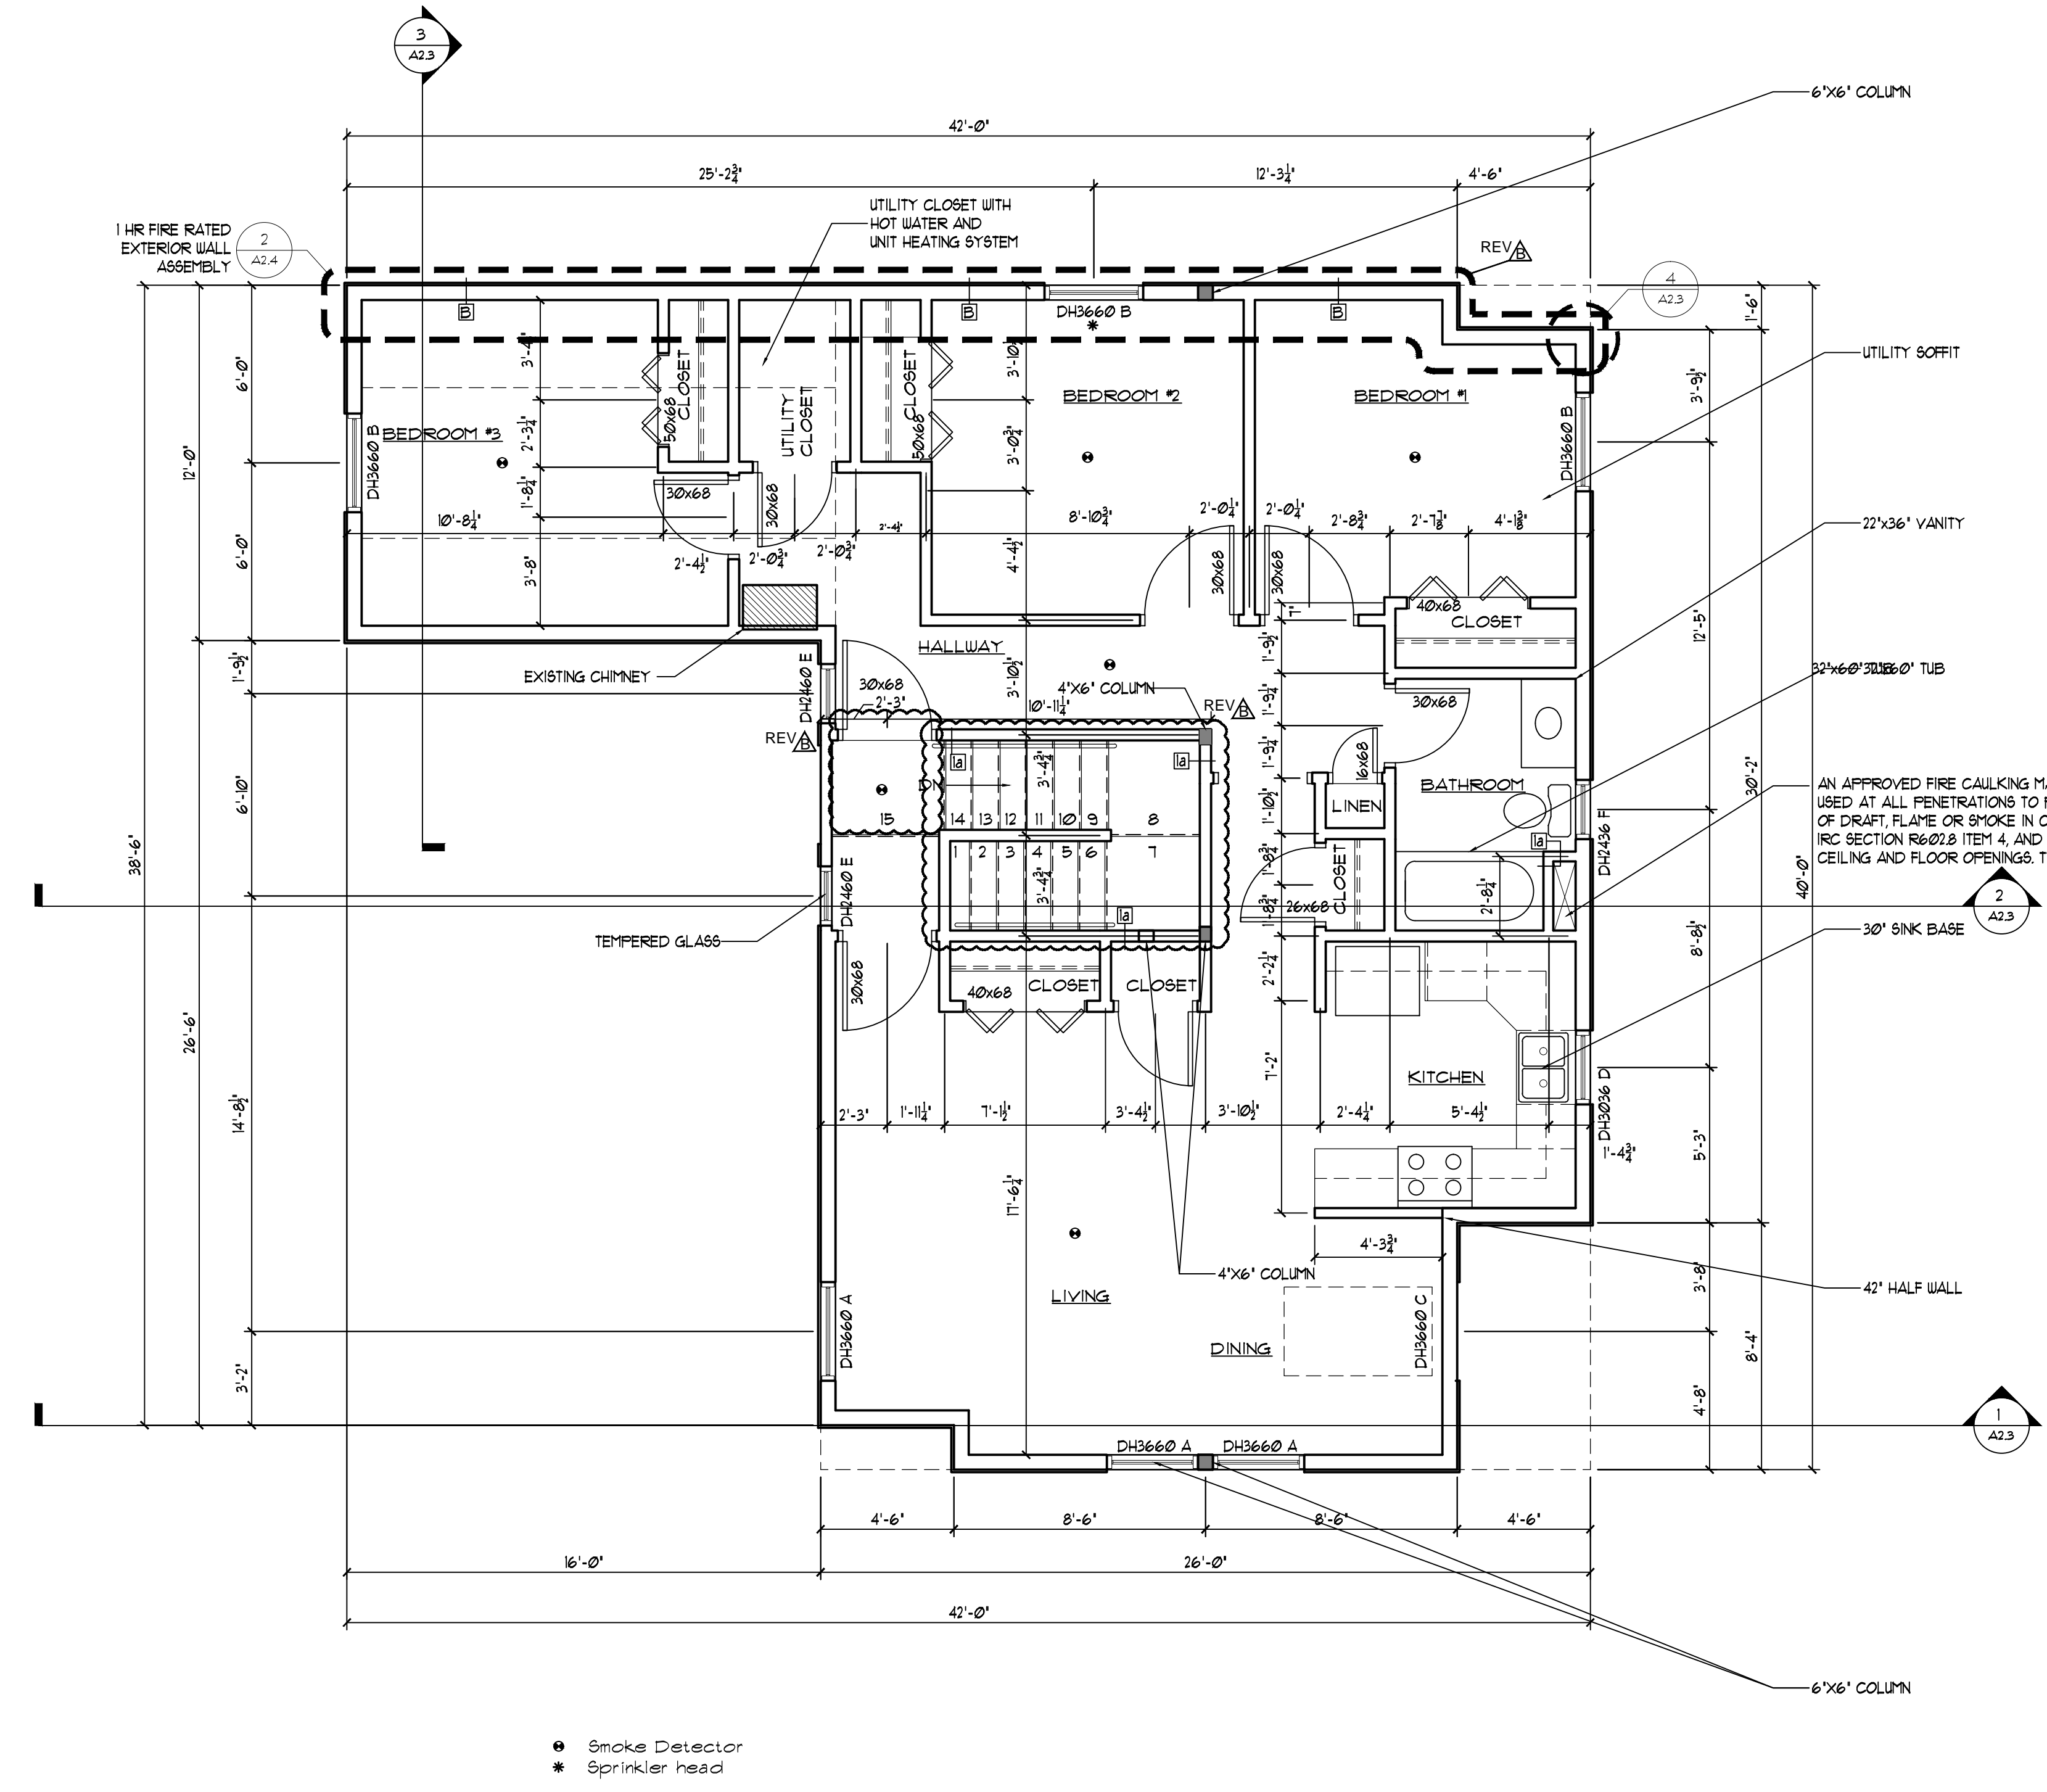

1 New Third Floor Plan  
Scale: 1/4" = 1'-0"

- Smoke Detector
- \* Sprinkler head

1. Contractor/owner responsible for securing all necessary permits.  
2. Contractor/owner will comply with all applicable codes and ordinances.  
3. Contractor/owner to verify all site grades and dimensions.

DATE	NO	REMARKS	BY
08-03-09	A	ISSUED FOR PERMITTING	JJO
09-24-09	B	REVISED AS PER CITY COMMENT	JJO
10-08-09	C	REVISED AS PER CITY COMMENT	JJO

CODE: IRC 2003  
TOWN: Portland  
DATE: 06-16-09  
SCALE: AS NOTED  
DRAWN: JJO  
TITLE:  
New Third Floor Plan  
FILE: 015-017-09  
SHEET:  
A1.4