


- General Notes:**
- See A2.4 for wall types and partition types and window schedule
 - Place additional sprinkler heads at windows located in the 1 hour rated wall assembly

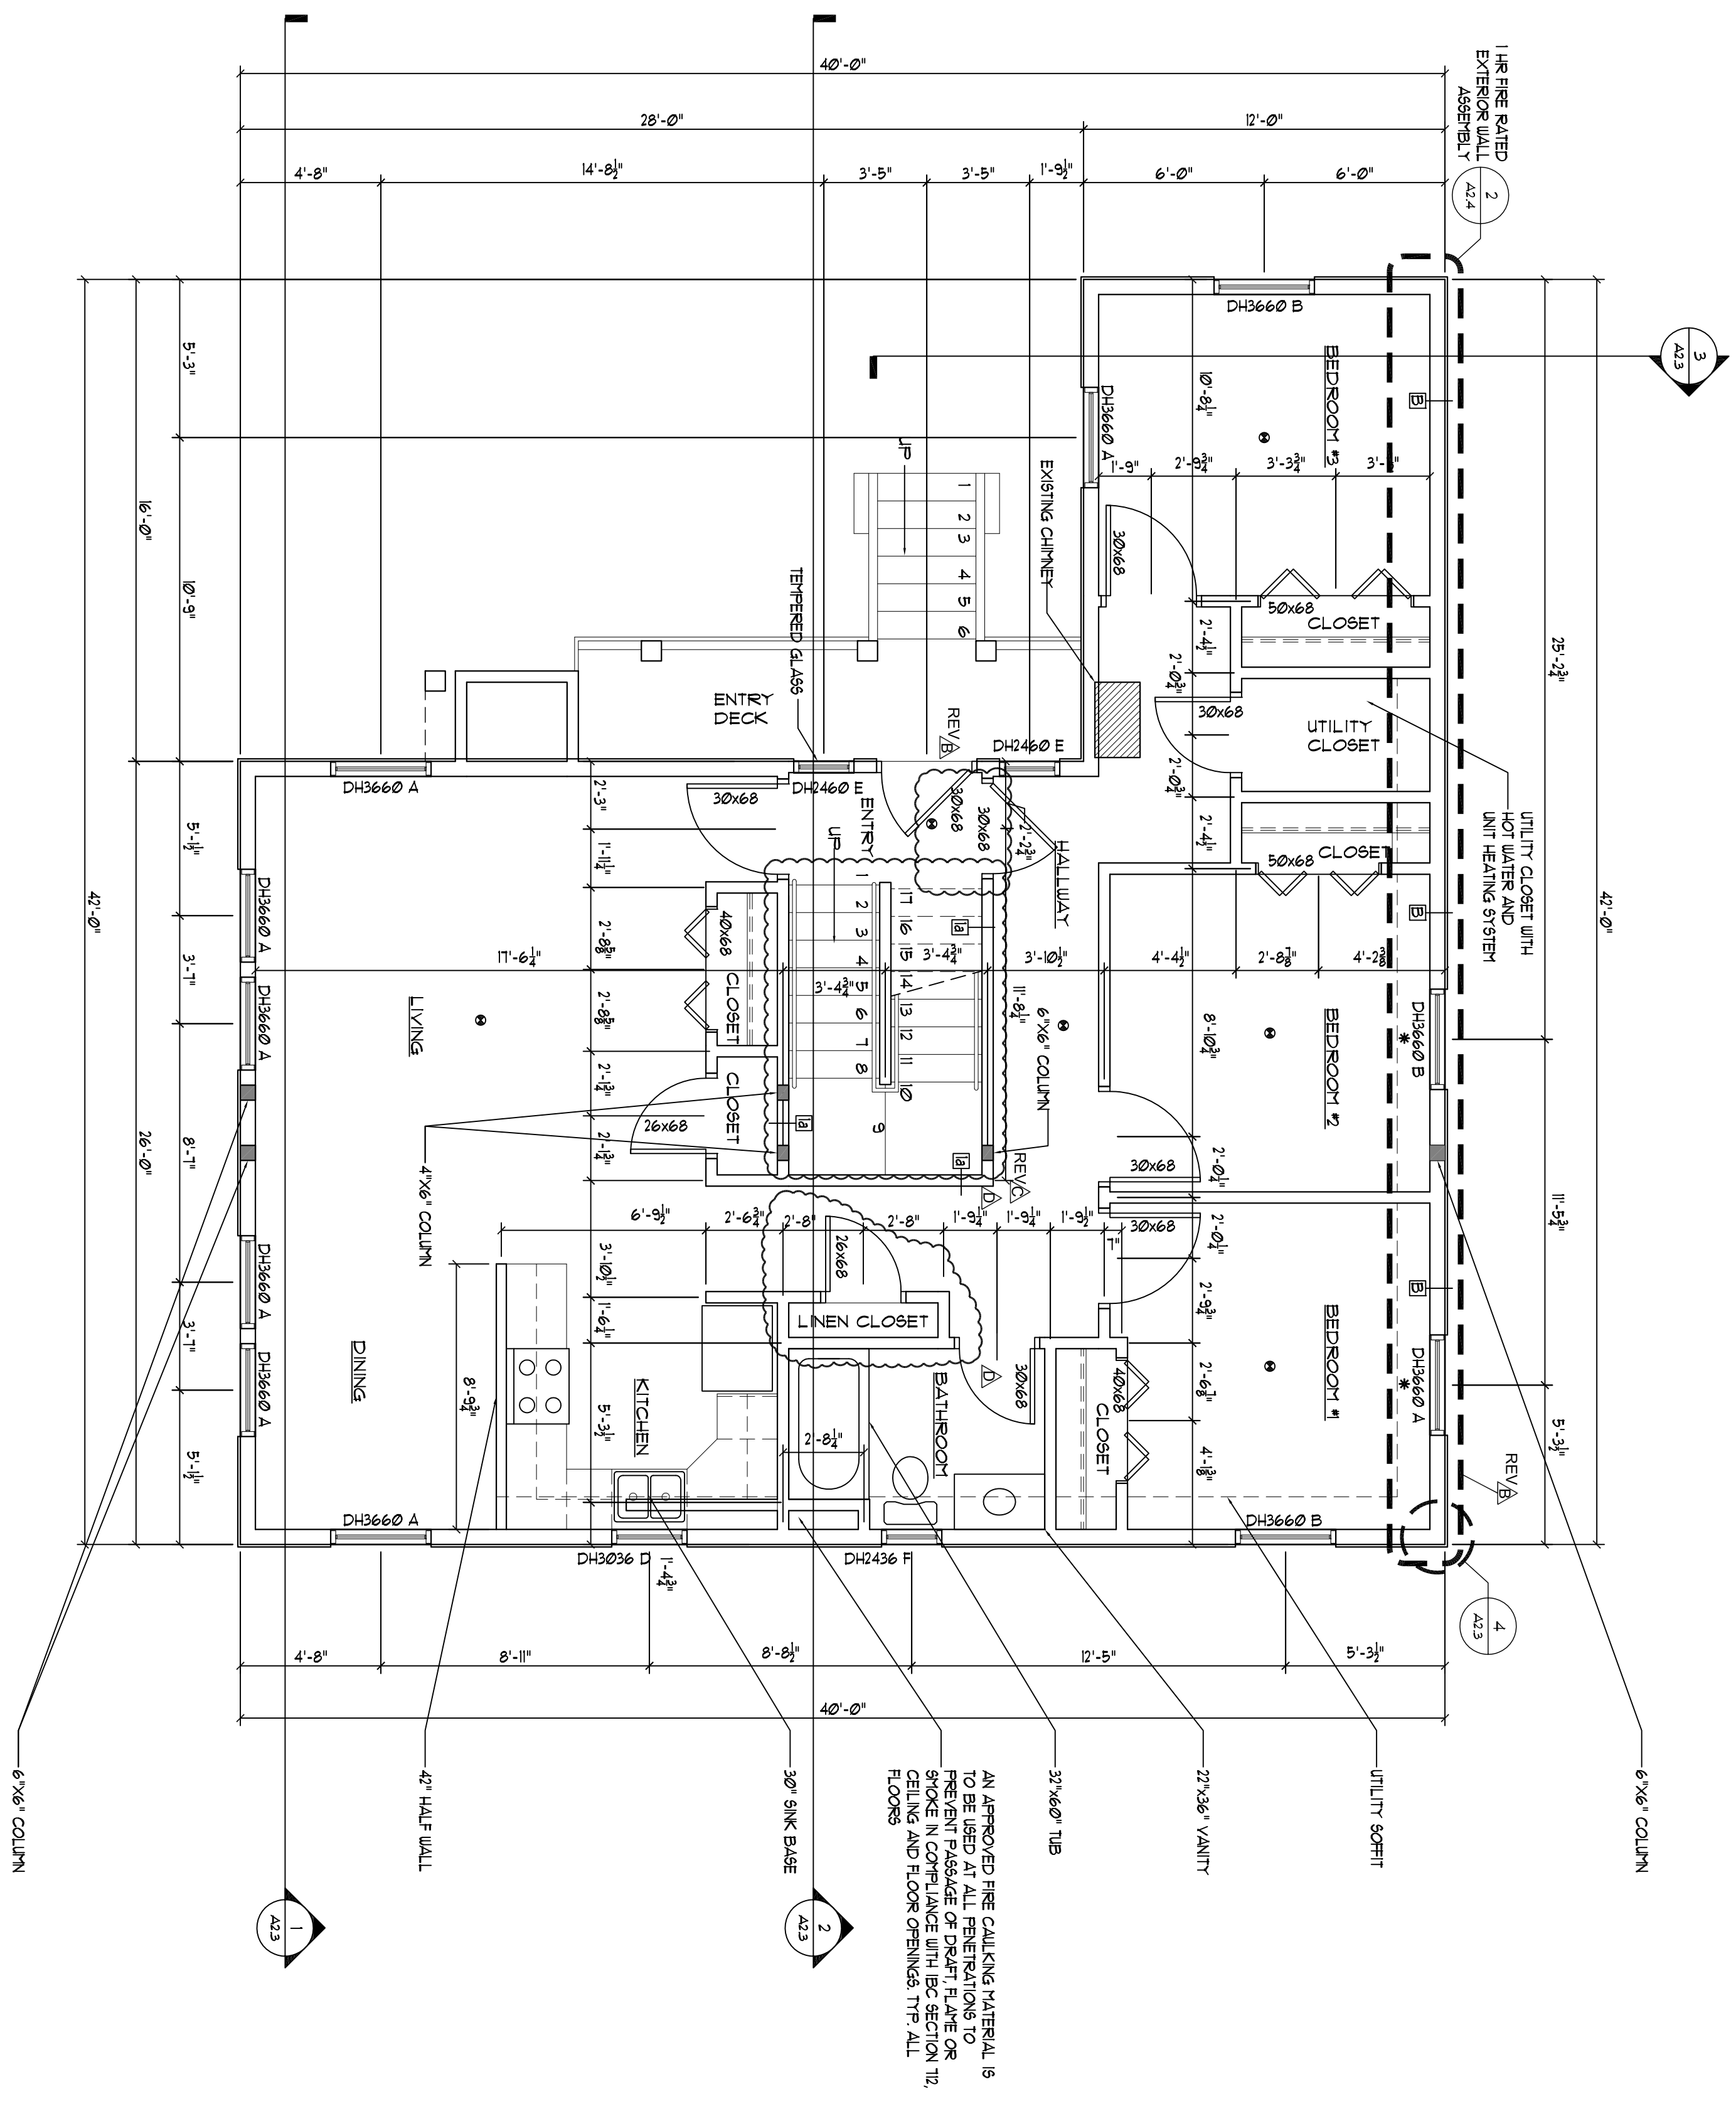

● Smoke Detector
 * Sprinkler head
 1 New First Floor Plan
 Scale: 1/4" = 1'-0"

- Contractor/owner responsible for securing all necessary permits.
- Contractor/owner will Comply with all applicable codes and ordinances.
- Contractor/owner to verify all site grades and dimensions.

DATE	NO	REMARKS	BY
08-03-09	A	ISSUED FOR PERMITTING	JJO
09-24-09	B	REVISED AS PER CITY COMMENT	JJO
10-08-09	C	REVISED AS PER CITY COMMENT	JJO
10-26-09	D	REVISED AS PER CITY COMMENT	JJO

35 Mayo Street Re-Model
 Portland, Maine
 Fowler-Greeves Construction

DOWNEAST STRUCTURAL CONSULTANTS, LLC
 5 Oak Street
 Cumberland, Maine 04021
 phone: 207.829.8015
 email: croy@downeaststructural.com

STATE OF MAINE
 CHRISTOPHER RAY
 No. 10847
 LICENSED PROFESSIONAL ENGINEER

@d-de-Tech
 235 Riverside Industrial Parkway
 Portland, ME 04102

PROPERTY OF