

- General Notes:**
1. See A2.4 for wall types and partition types and window schedule
  2. Place additional sprinkler heads at windows located in the 1 hour rated wall assembly

**@d-de-Tech**  
 235 Riverside Industrial Parkway  
 Portland, ME 04102


Downeast Structural Consultants, LLC  
  
 5 Oak Street  
 Cumberland, Maine 04021  
 phone: 207.829.8015  
 email: croy@downeaststructural.com

STATE OF MAINE  
 CHRISTOPHER RAY  
 No. 10847  
 LICENSED PROFESSIONAL ENGINEER  


**35 Mayo Street Re-Model**  
 Portland, Maine  
 Fowler-Greeves Construction

BY	DATE	REMARKS
JJO	08-03-09	A ISSUED FOR PERMITTING
JJO	09-24-09	B REVISED AS PER CITY COMMENT
JJO	10-08-09	C REVISED AS PER CITY COMMENT
JJO	10-26-09	D REVISED AS PER CITY COMMENT

CODE:	IBC 2003
TOWN:	Portland
DATE:	06-16-09
SCALE:	AS NOTED
DRAWN:	JJO
TITLE:	New Third Floor Plan
FILE:	015-017-09
SHEET:	A1.4

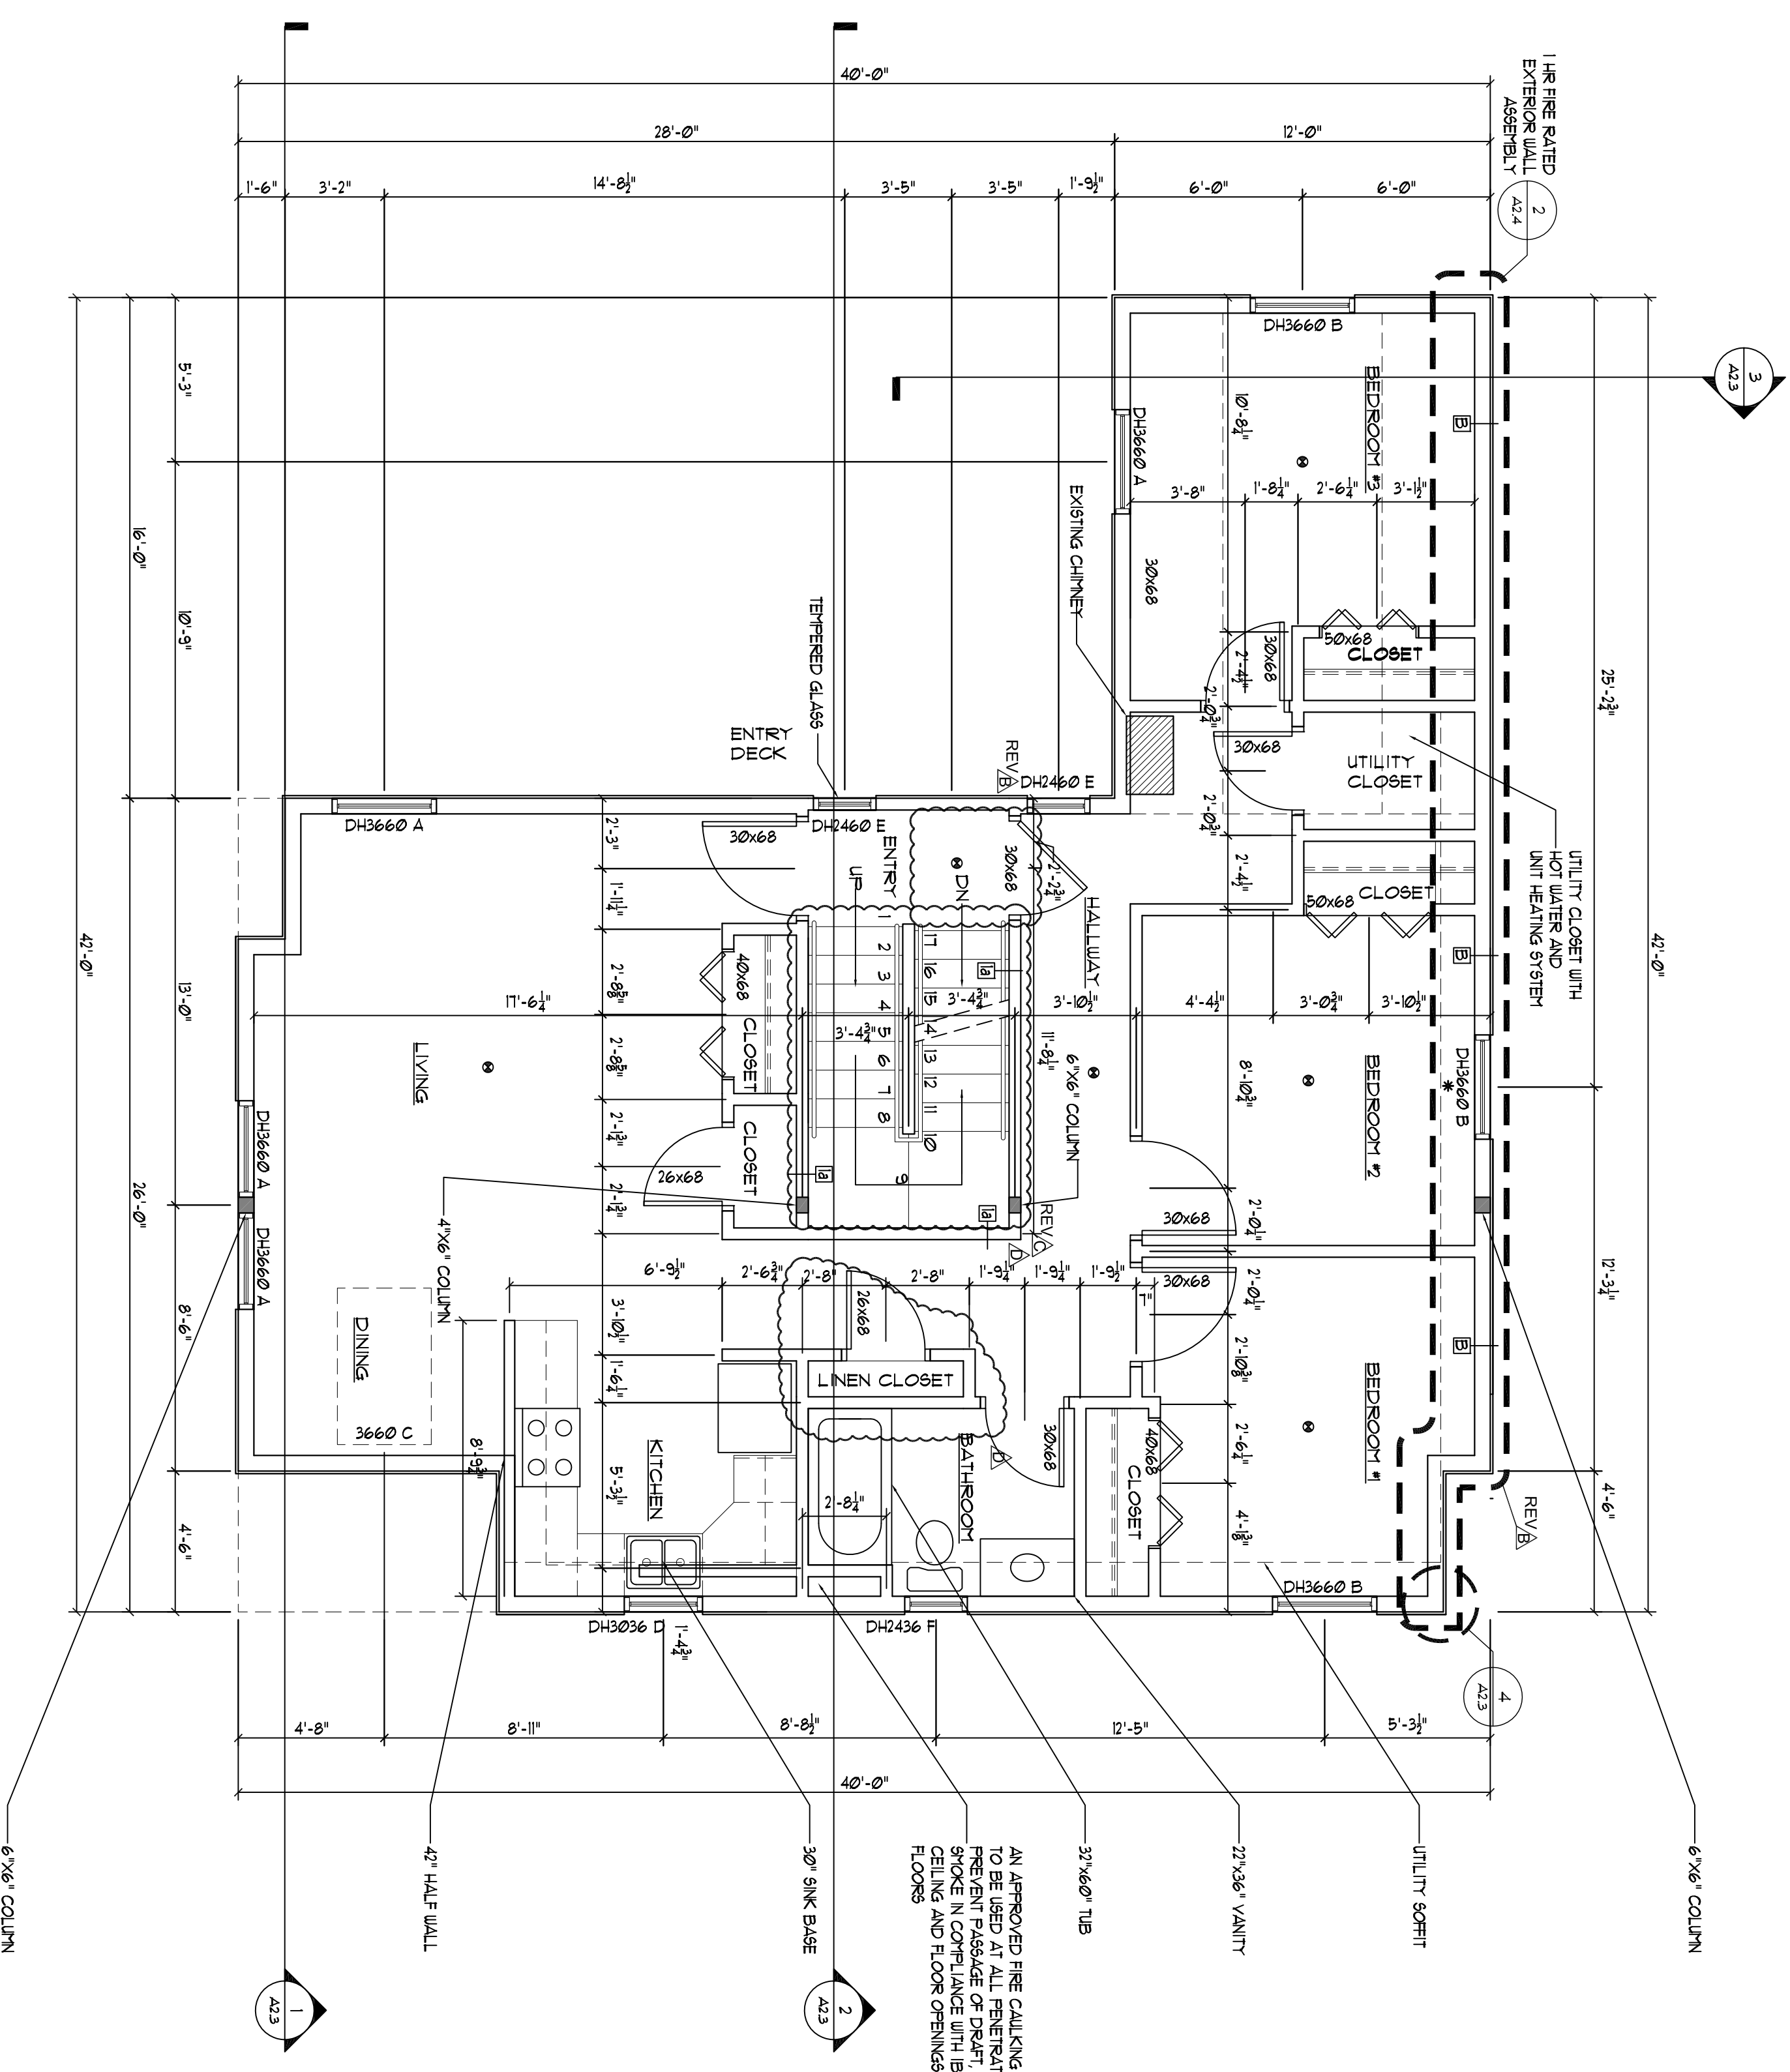

1 New Third Floor Plan  
 Scale: 1/4" = 1'-0"

● Smoke Detector  
 \* Sprinkler head

1. Contractor/owner responsible for securing all necessary permits.
2. Contractor/owner will comply with all applicable codes and ordinances.
3. Contractor/owner to verify all site grades and dimensions.