


Notes:

Electrical:

- All electric on second floor updated to code
- Master and stairway to have ceiling fan/lights
- Small bedrooms to have wall sconces
- Outlets placed per code
- GFCI in bath
- Arc fault protection in bedrooms
- Exhaust fan at bathroom

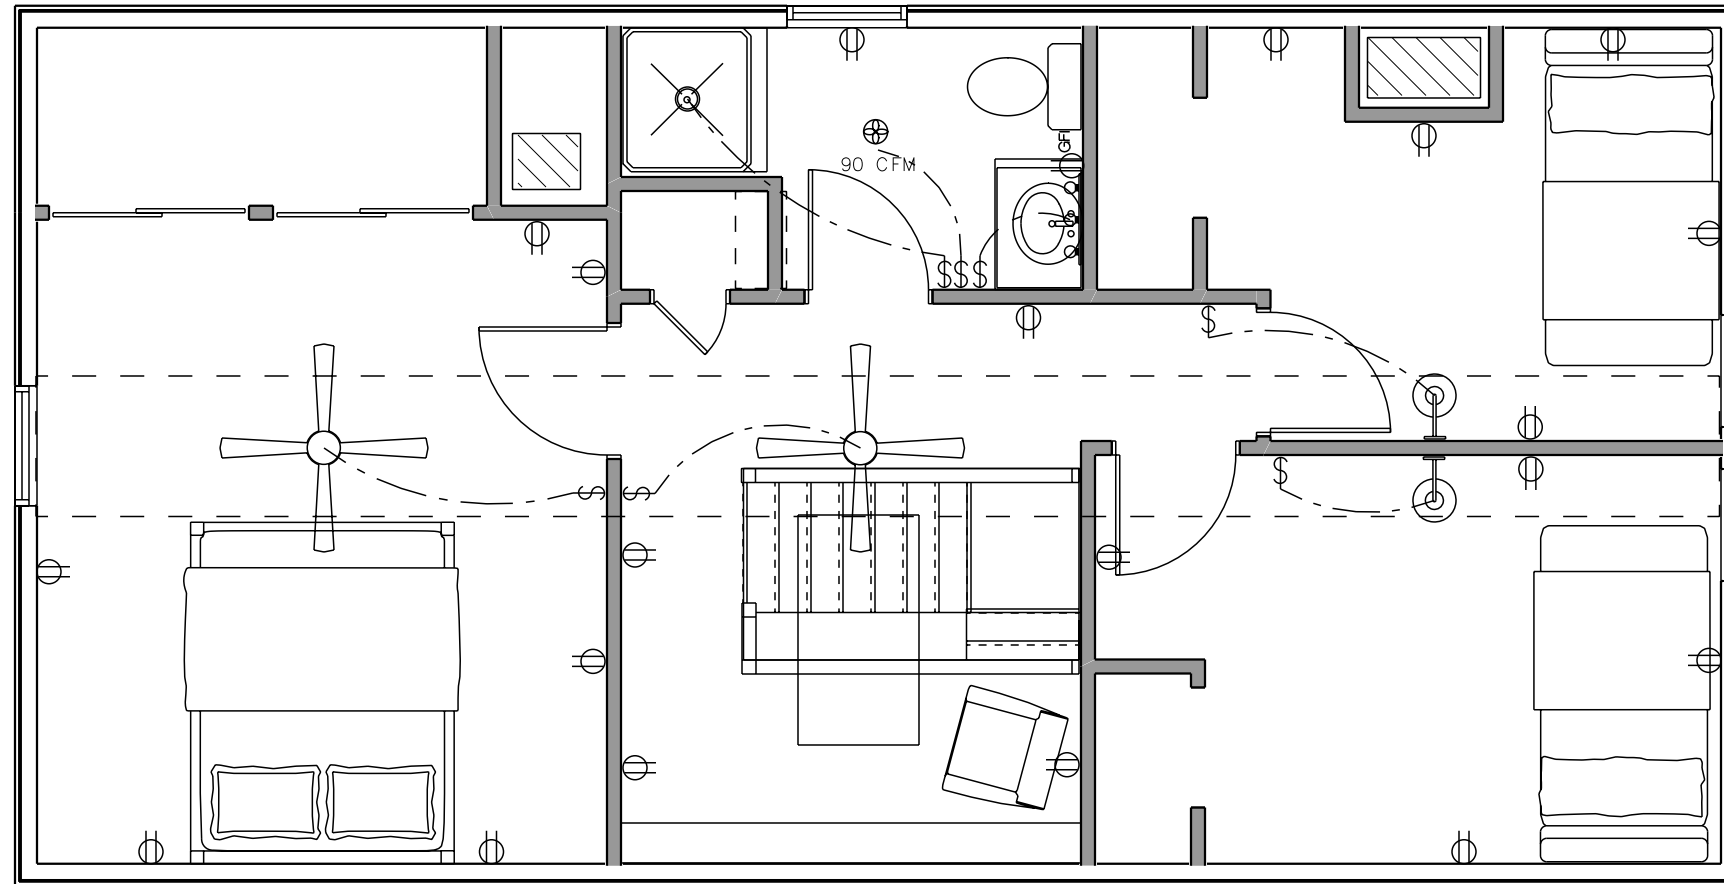

Proposed Second Floor Electrical Plan

<p><b>Joe Lucey Carpentry Inc.</b></p>			<p><b>Ward Willis &amp; Belinda Ray</b></p>	
<p>482 Walnut Hill Rd North Yarmouth ME 04097</p>			<p>65 East Oxford St. Portland ME 04101</p>	
<p>PHONE: 207-671-4249 Joe@joeluceycarpentry.com</p>		<p>PHONE: FAX:</p>		
		<p>DRAWN BY: Joe Lucey</p>		<p>PAGE: <b>5 / 6</b></p>
		<p>SCALE: 1/4" = 1'-0"</p>		
		<p>DATE: Monday, October 10, 2016</p>		