


**BAYSIDE EAST**  
PROPOSED ELDERLY HOUSING  
47 SMITH STREET, PORTLAND  
FOR BAYSIDE EAST LP

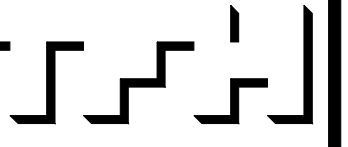

TFH ARCHITECTS  
100 COMMERCIAL STREET  
PORTLAND MAINE 04101  
TELEPHONE 207 775 6141  
ARCHITECTURE PLANNING


CONSULTANTS:  
**BENNETT ENGINEERING**  
CONSULTING ENGINEERS  
1000 BROAD STREET  
PORTLAND, MAINE 04101  
TEL: 207 775 6141

REVISIONS:

DATE: MAY 18, 2007  
PROJECT No. 0514  
DRAWN BY: SPD  
CHECKED BY: CWA  
SCALE: AS NOTED

SHEET TITLE:  
**THIRD FLOOR  
ELECTRICAL  
PLAN**

**E2.5**

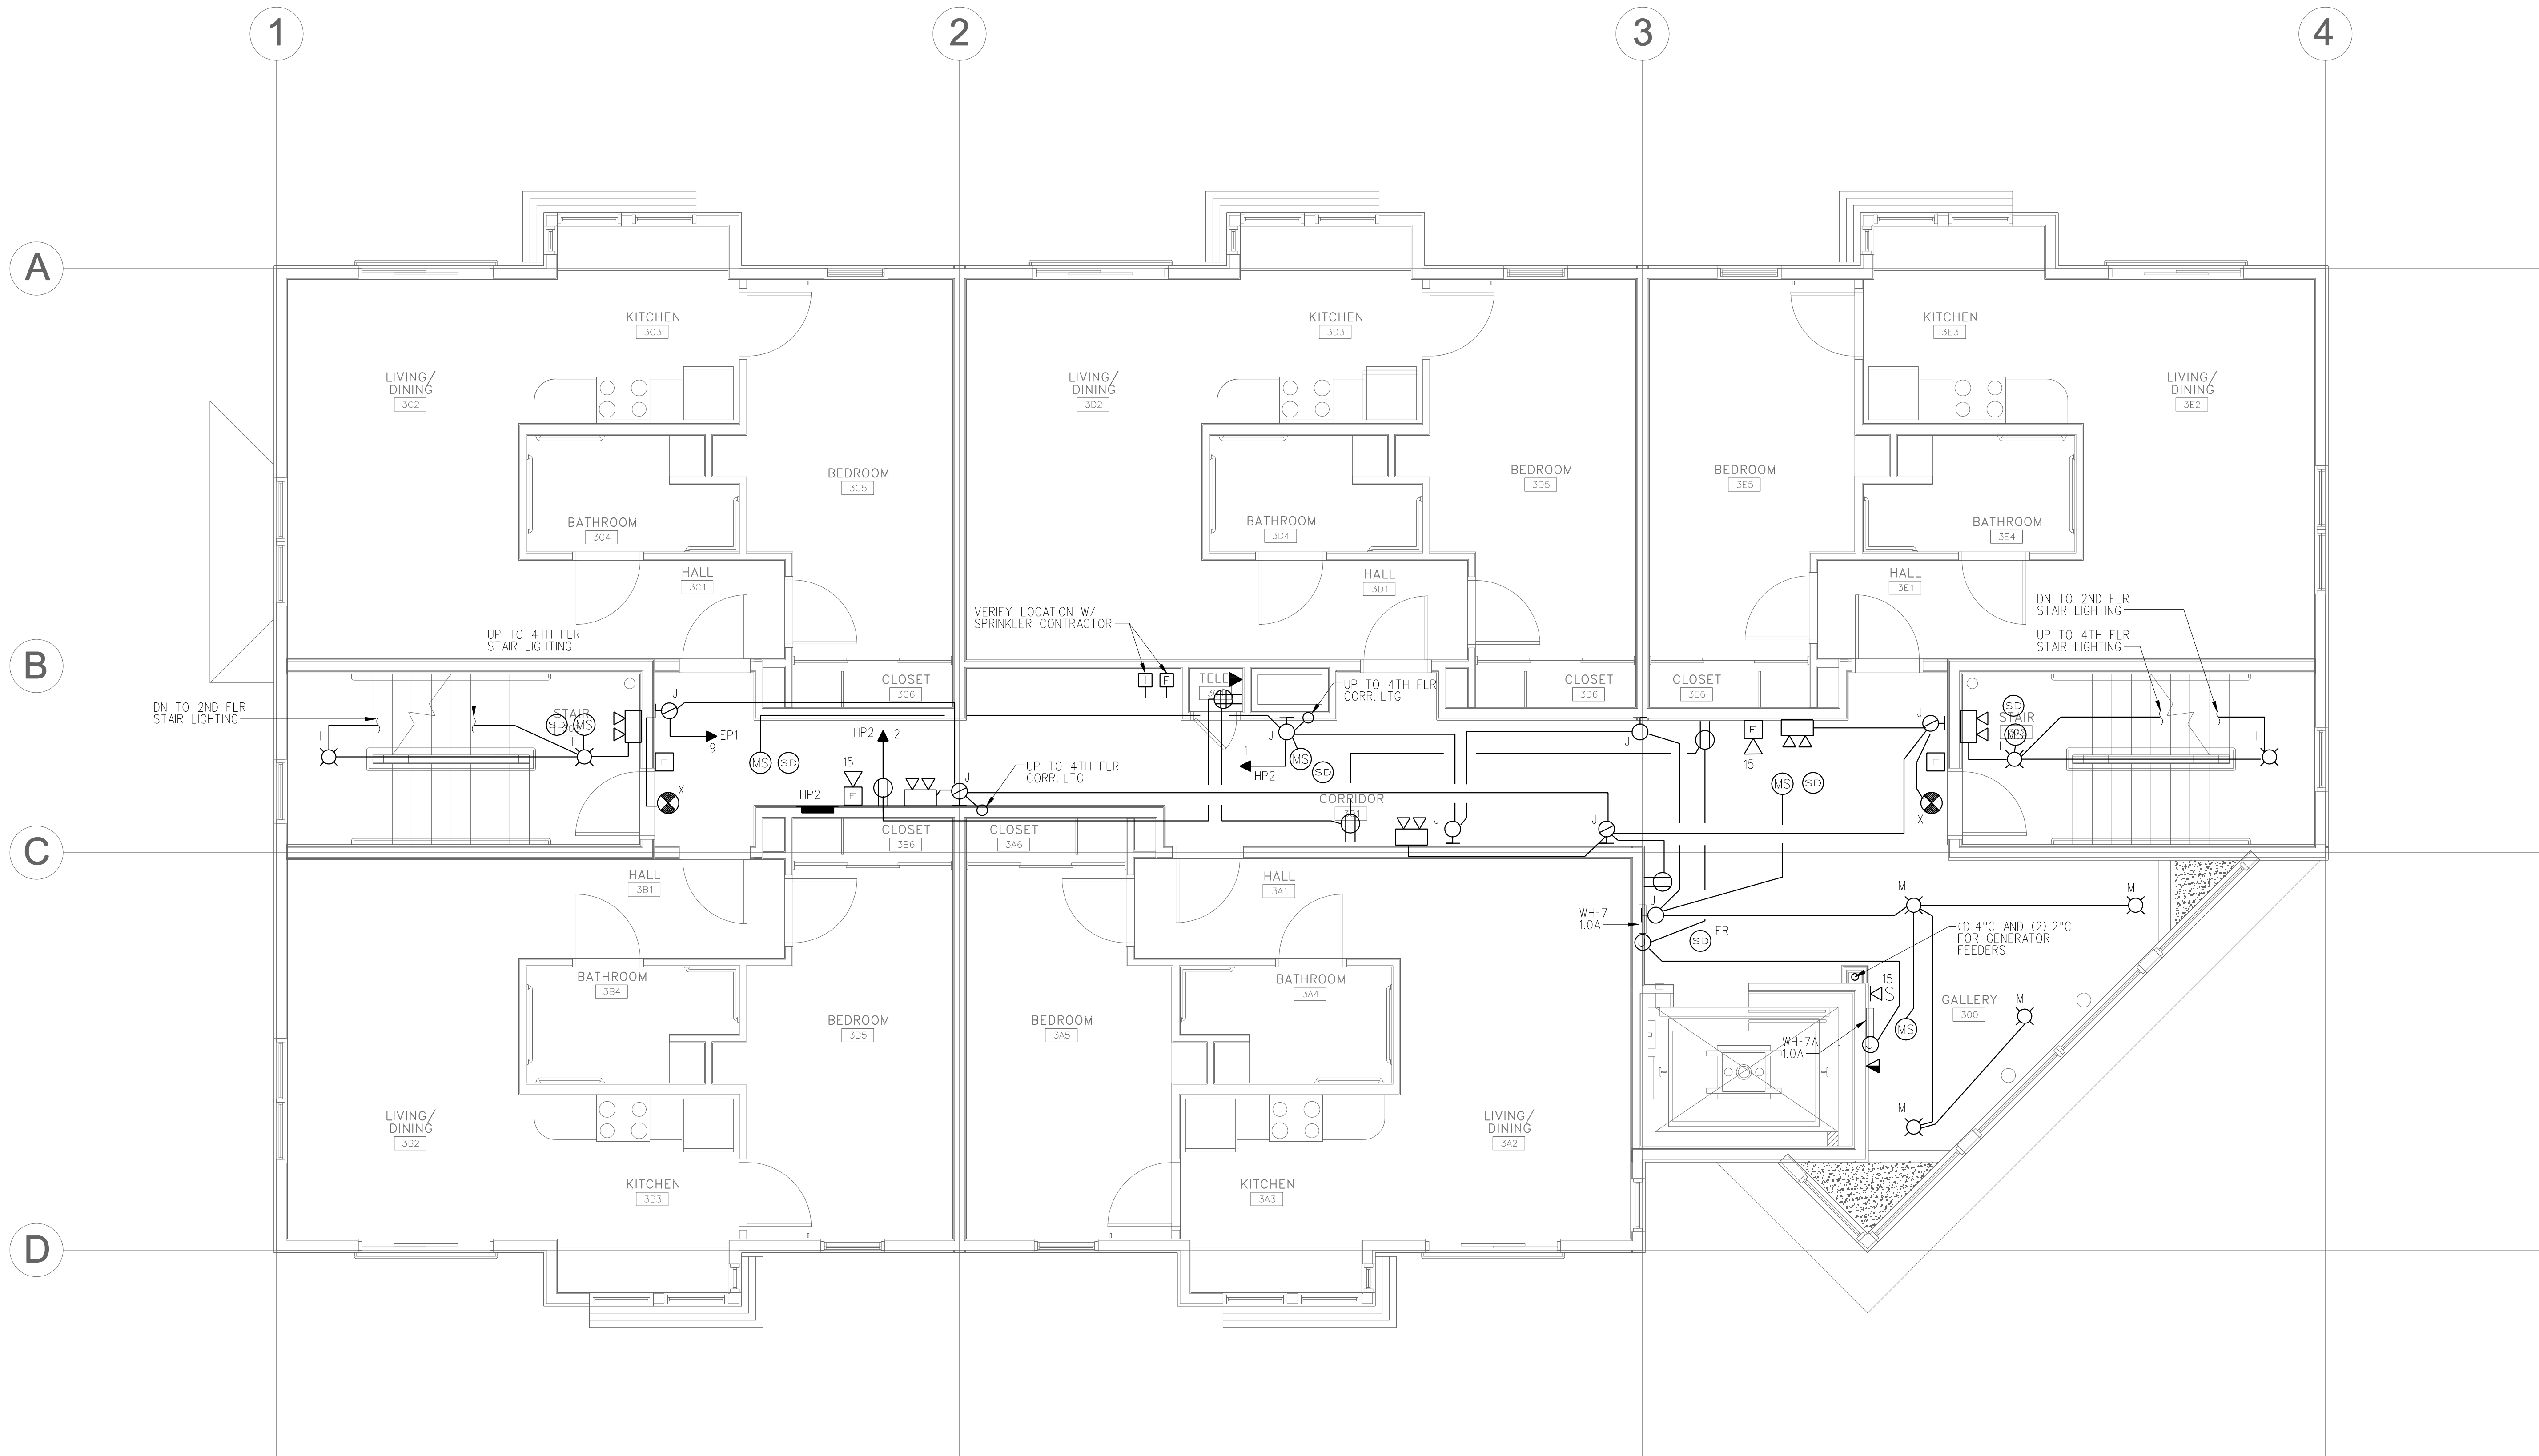

**THIRD FLOOR ELECTRICAL PLAN**  
SCALE: 1/4"=1'-0"

**NOTES:**  
1. PROVIDE AIR-VAPOR BARRIER ELECTRICAL BOXES AT EXTERIOR WALLS.  
AIRFOIL OR EQUIVALENT. VAPOR BARRIER SHALL BE SEALED TO FLANGE.

