

BAYSIDE EAST
 PROPOSED ELDERLY HOUSING
 47 SMITH STREET, PORTLAND
 FOR BAYSIDE EAST LP

TFH ARCHITECTS
 100 COMMERCIAL STREET
 PORTLAND MAINE 04101
 TELEPHONE 207 775 6141
 ARCHITECTURE PLANNING


CONSULTANTS:
BENNETT ENGINEERING
 CONSULTING ENGINEERS
1000 BROAD STREET, PORTLAND, ME 04101
 TEL: 207 775 6141 FAX: 207 775 6142

REVISIONS:

DATE: MAY 18, 2007
 PROJECT No. 0514
 DRAWN BY: SPD
 CHECKED BY: CWA
 SCALE: AS NOTED

SHEET TITLE:
**FOURTH FLOOR
 ELECTRICAL
 PLAN**

E2.6

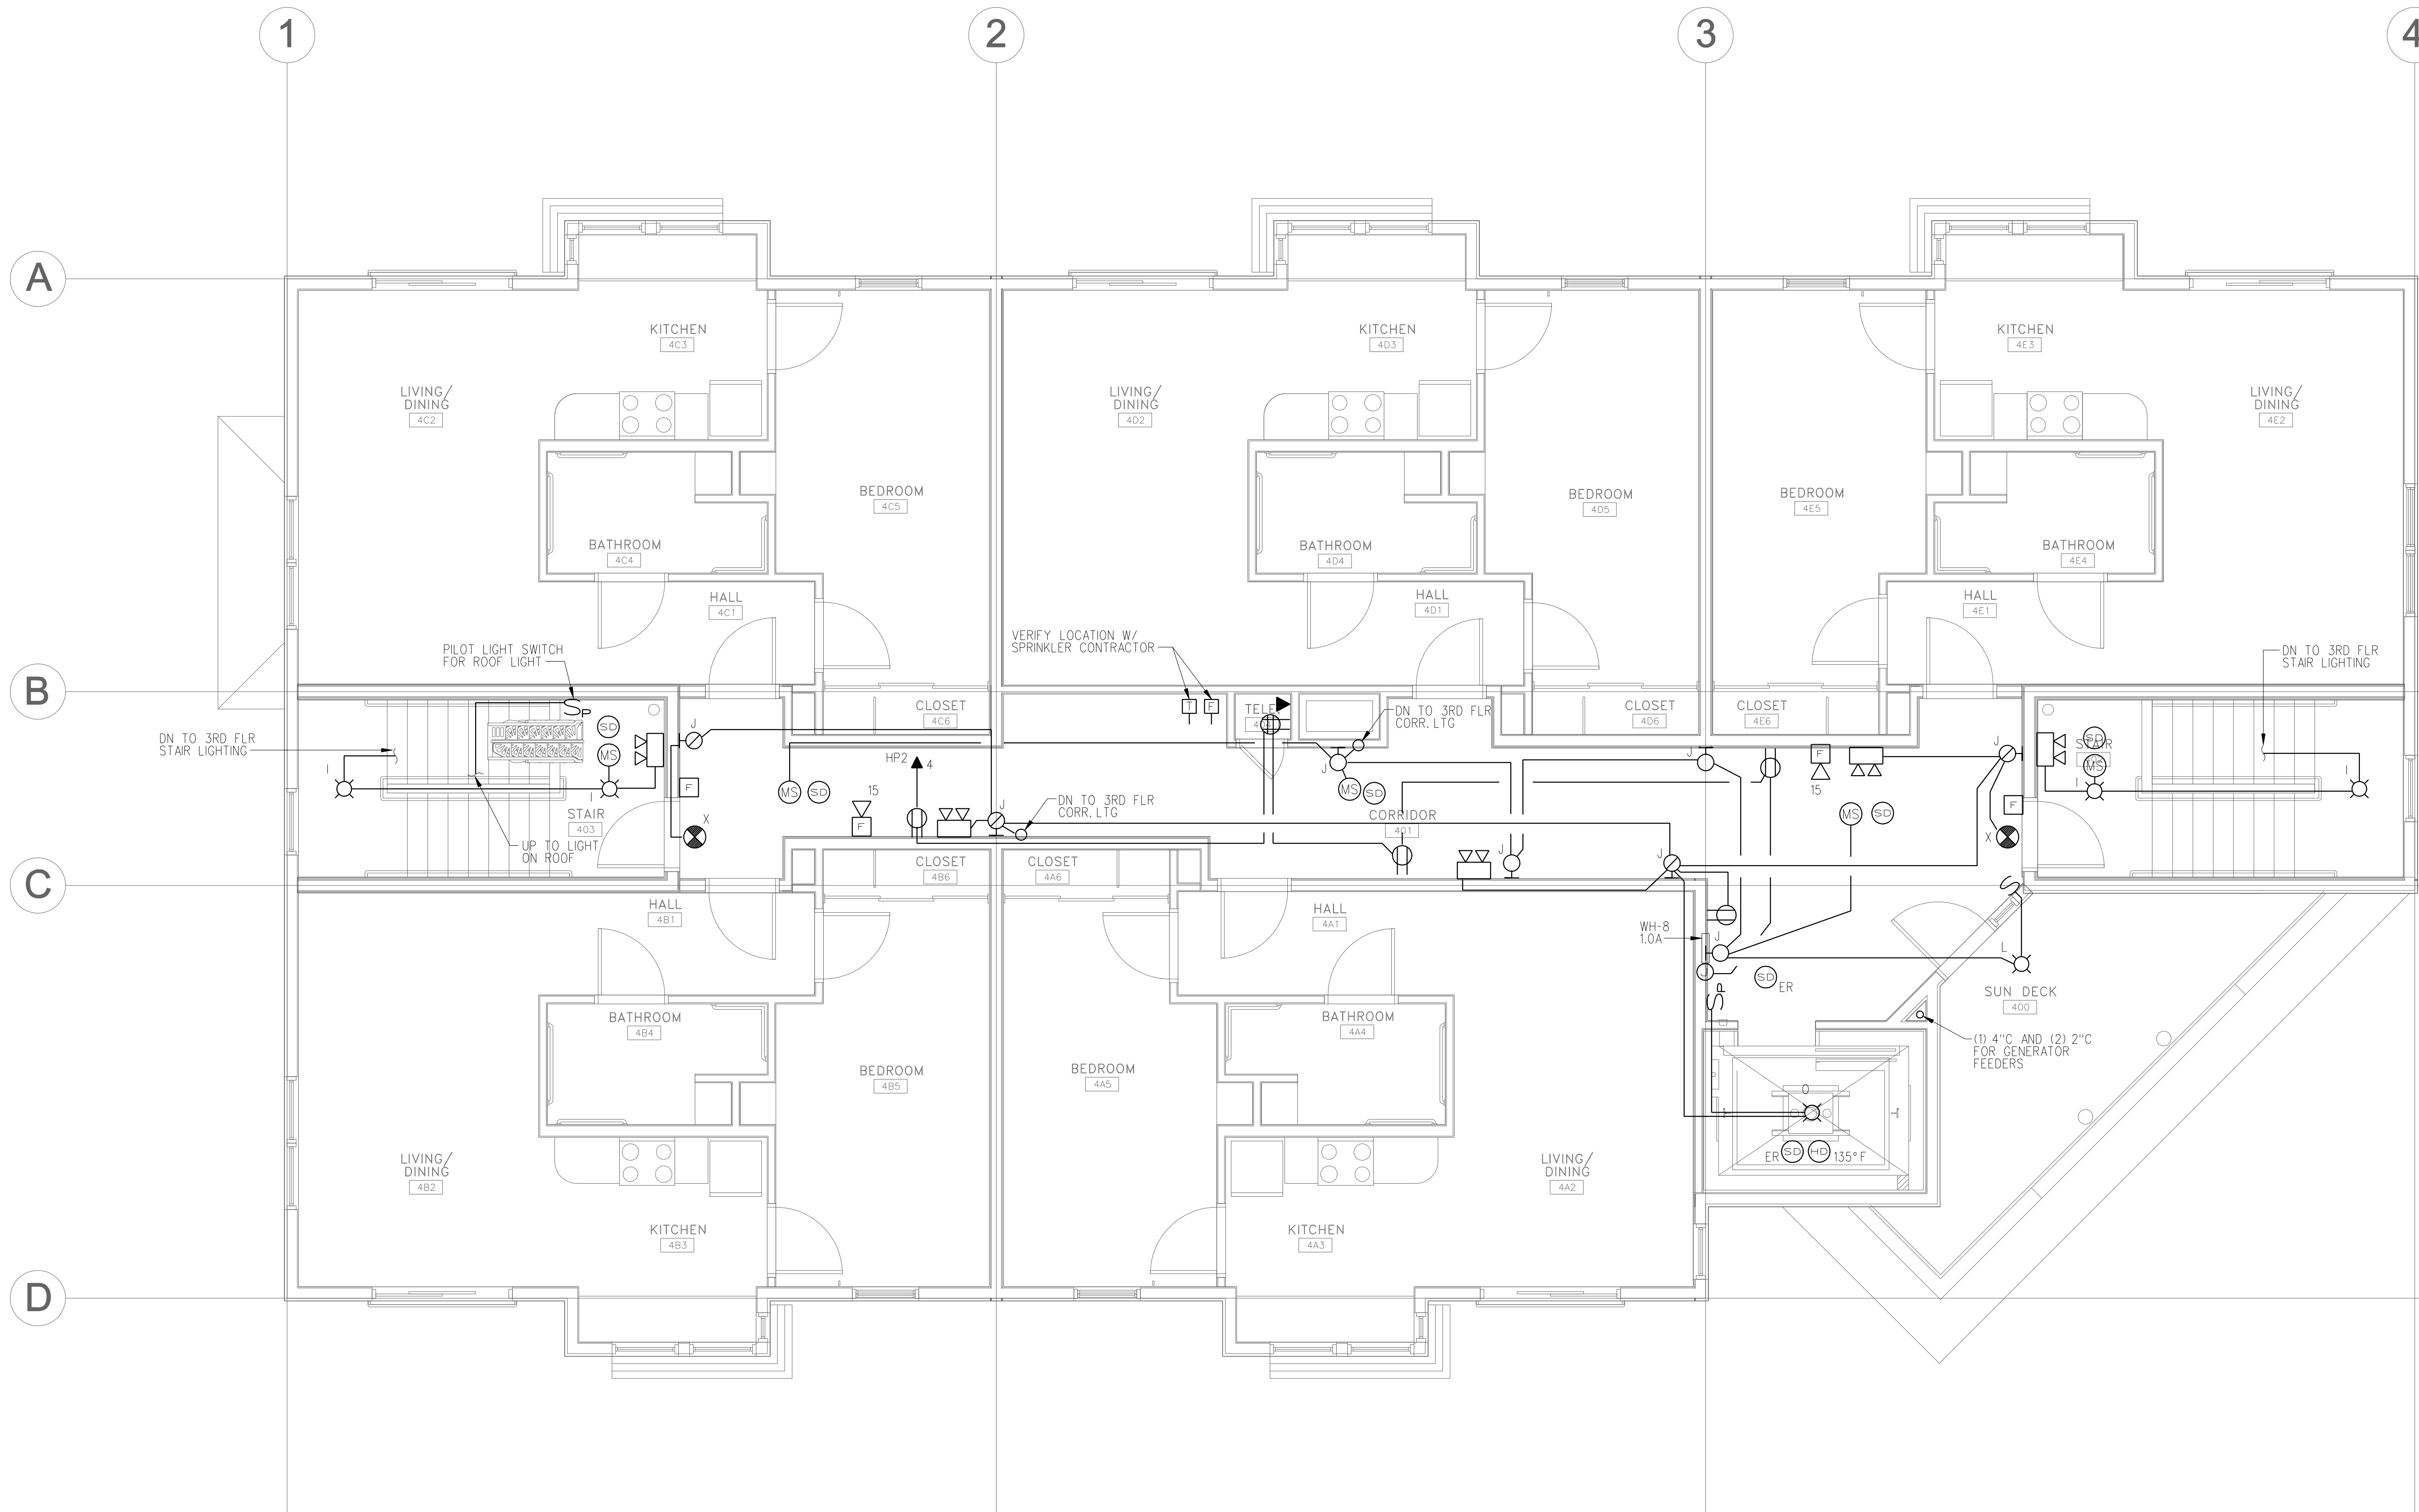

FOURTH FLOOR ELECTRICAL PLAN
 SCALE: 1/4"=1'-0"

NOTES:
 1. PROVIDE AIR-VAPOR BARRIER ELECTRICAL BOXES AT EXTERIOR WALLS. AIRFOIL OR EQUIVALENT VAPOR BARRIER SHALL BE SEALED TO FLANGE.

