

BAYSIDE EAST
PROPOSED ELDERLY HOUSING
47 SMITH STREET, PORTLAND
FOR BAYSIDE EAST LP

TFH ARCHITECTS
100 COMMERCIAL STREET
PORTLAND MAINE 04101
TELEPHONE 207 775 6141
ARCHITECTURE PLANNING

CONSULTANTS:
BENNETT ENGINEERING
CONSULTING ENGINEERS

REVISIONS:

DATE: MAY 18, 2007

PROJECT No. 0514


DRAWN BY: SPD

CHECKED BY: CWA

SCALE: AS NOTED

SHEET TITLE:
**ROOF
ELECTRICAL
PLAN**

E2.7

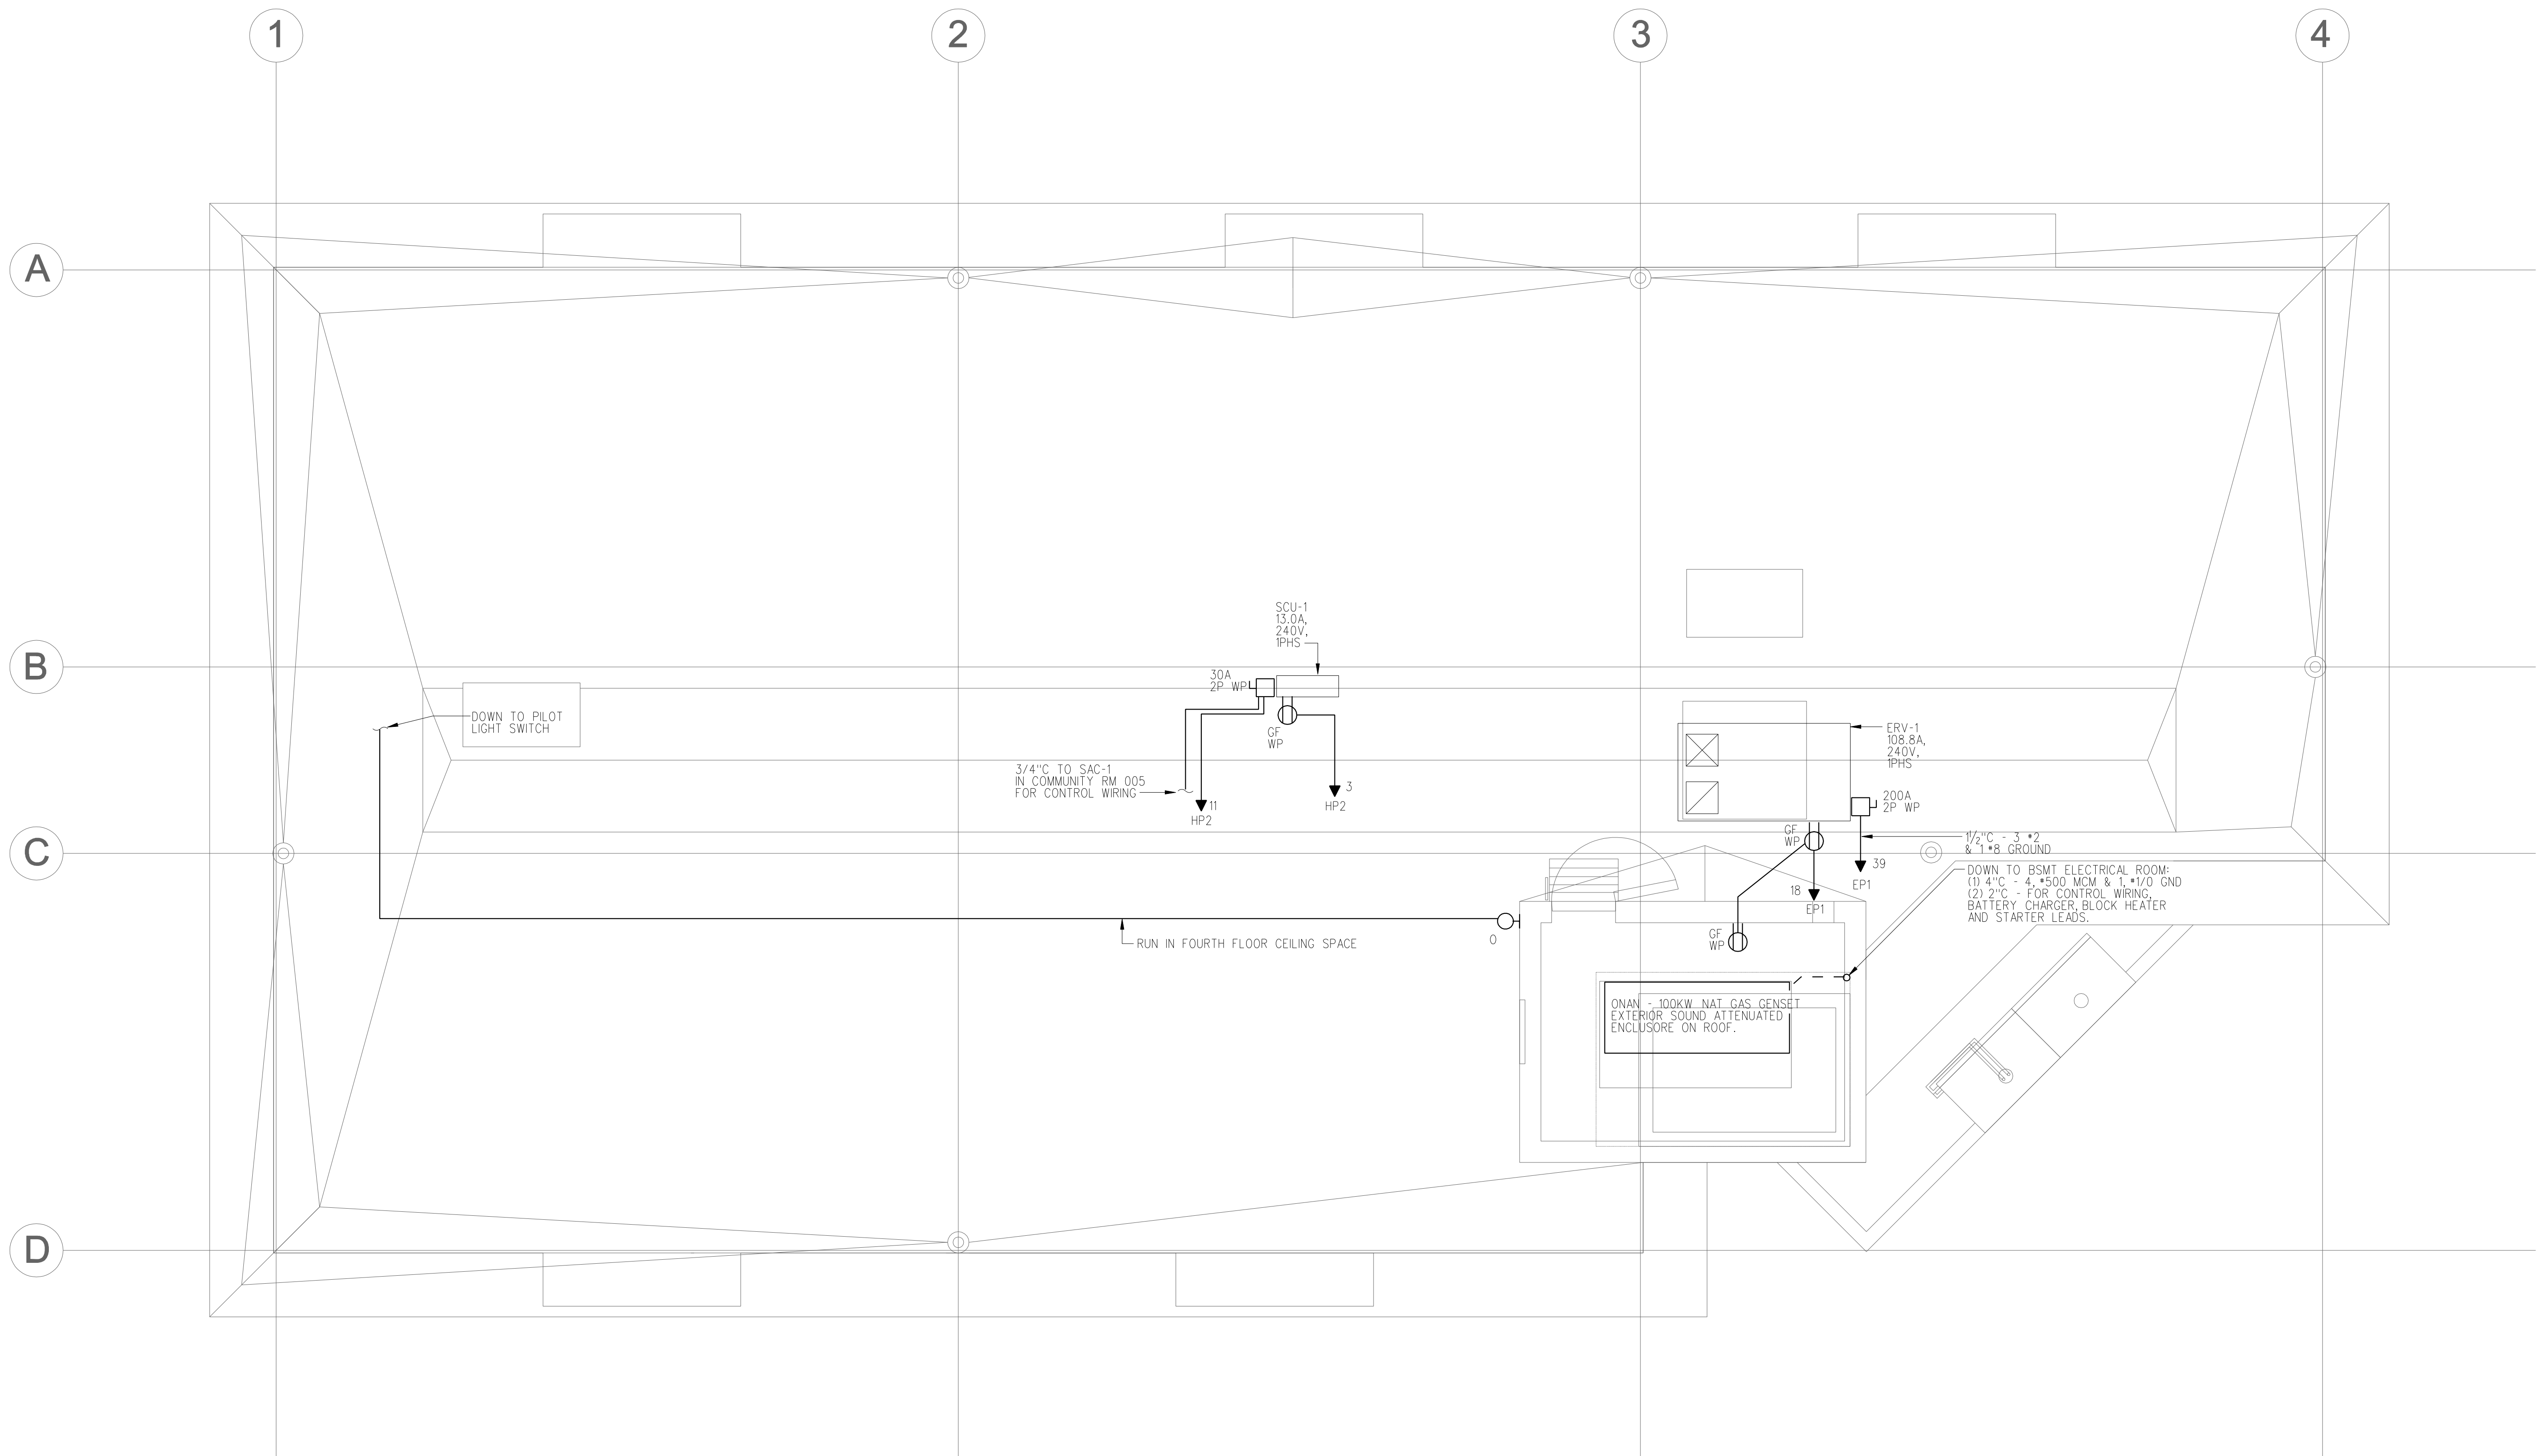

ROOF ELECTRICAL PLAN
SCALE: 1/4"=1'-0"

- NOTES:**
1. PROVIDE AIR-VAPOR BARRIER ELECTRICAL BOXES AT EXTERIOR WALLS. AIRFOIL OR EQUIVALENT VAPOR BARRIER SHALL BE SEALED TO FLANGE.

