

IT IS THE INTENT OF THE DRAWINGS AND SPECIFICATIONS TO PROVIDE FOR THE INSTALLATION OF A HEATING SYSTEM WHICH IS SAFE, QUIET, AND ECONOMICAL IN OPERATION AND COMPLETE IN ALL RESPECTS. THIS SYSTEM WILL PROVIDE A UNIFORM TEMPERATURE OF 75°F IN ALL LIVING SPACES AS MAY BE NOTED ON THE DRAWINGS WHEN THE OUTSIDE TEMPERATURE IS 3°F. ALL MATERIALS AND EQUIPMENT NECESSARY TO ACCOMPLISH THE INTENT SHALL BE FURNISHED AND INSTALLED BY THE CONTRACTOR.

© 2007 TFH ARCHITECTS

BAYSIDE EAST
 PROPOSED ELDERLY HOUSING
 47 SMITH STREET, PORTLAND
 FOR BAYSIDE EAST LP

TFH ARCHITECTS
 100 COMMERCIAL STREET
 PORTLAND MAINE 04101
 TELEPHONE 207 775 6141
 ARCHITECTURE PLANNING

CONSULTANTS:
BENNETT ENGINEERING
 CONSULTING ENGINEERS

REVISIONS:

DATE: MAY 18, 2007

PROJECT No. 0514


DRAWN BY: JMV

CHECKED BY: SPDdel

SCALE: AS NOTED

SHEET TITLE:
BASEMENT MECHANICAL PLAN

M1.1

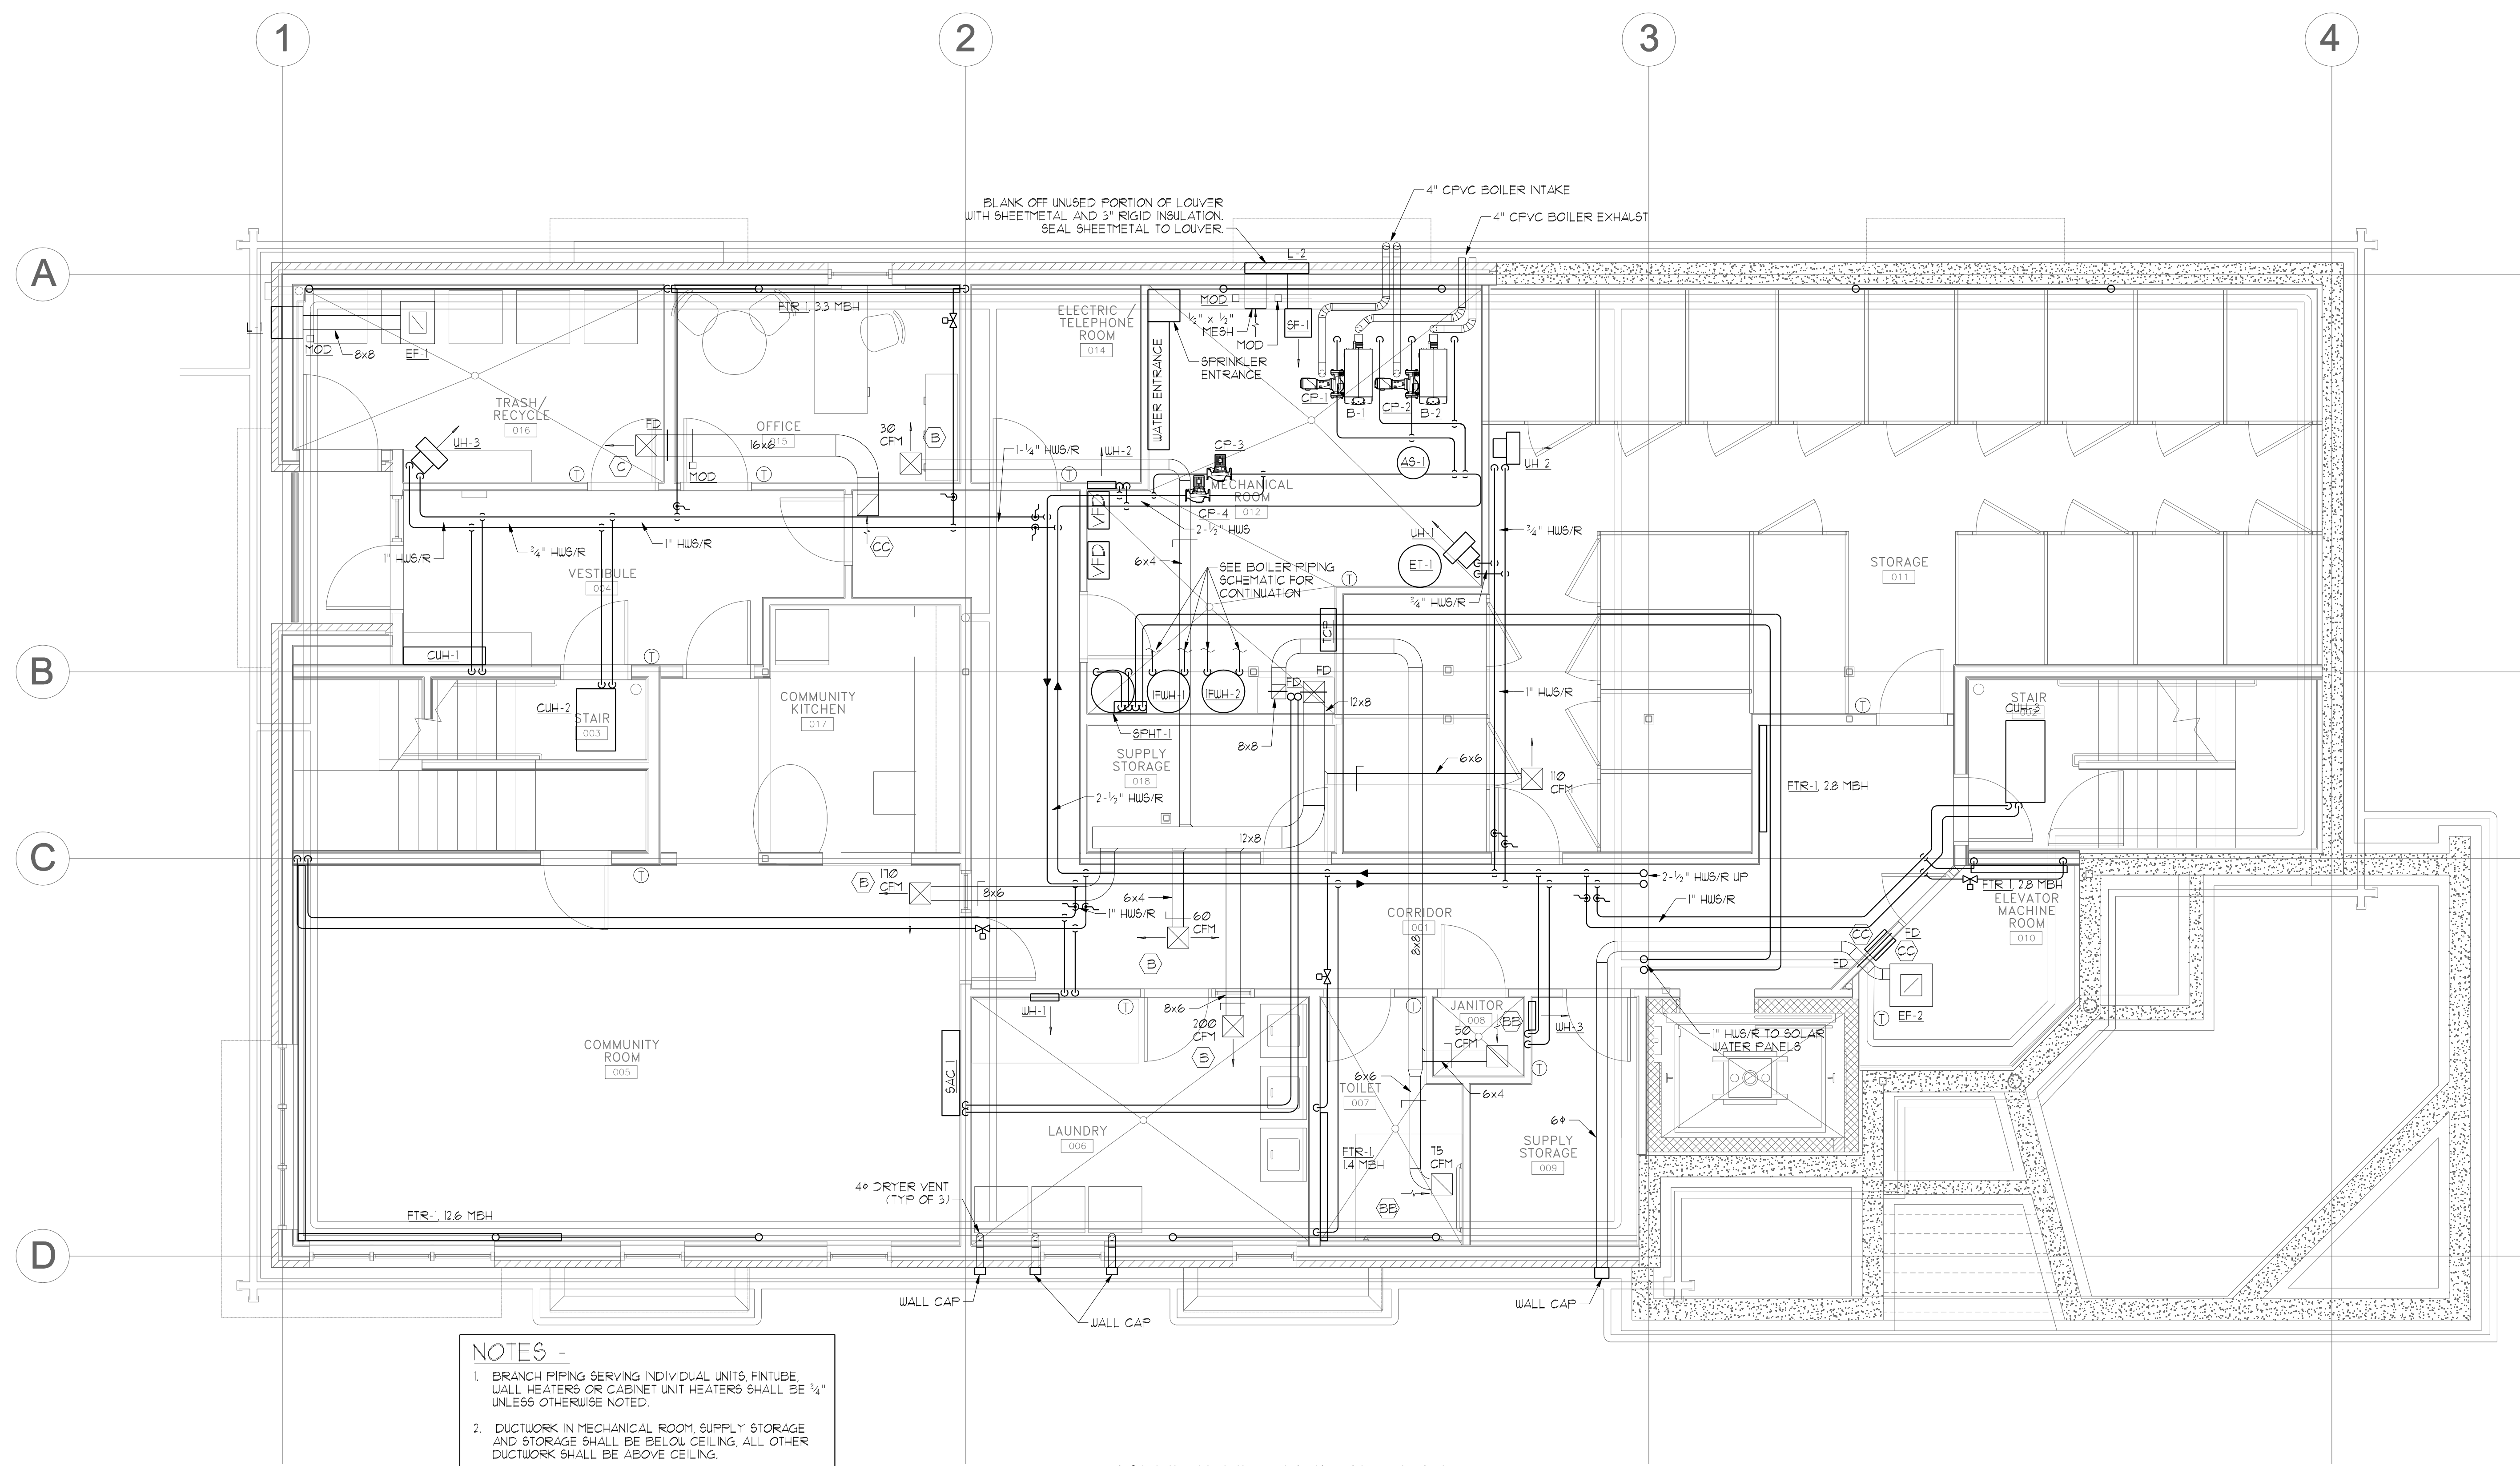

NOTES -

- BRANCH PIPING SERVING INDIVIDUAL UNITS, FINITUBE, WALL HEATERS OR CABINET UNIT HEATERS SHALL BE 1/4" UNLESS OTHERWISE NOTED.
- DUCTWORK IN MECHANICAL ROOM, SUPPLY STORAGE AND STORAGE SHALL BE BELOW CEILING, ALL OTHER DUCTWORK SHALL BE ABOVE CEILING.

BASEMENT MECHANICAL PLAN
 SCALE - 1/4" = 1'-0"

