


© 2005 TFH ARCHITECTS



ANDERSON STREET - BUILDING 2
PEOPLE'S REGIONAL OPPORTUNITY PROGRAM
PORTLAND, MAINE

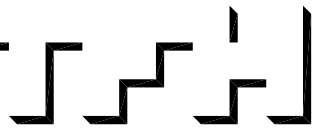

TFH ARCHITECTS
100 COMMERCIAL STREET
PORTLAND MAINE 04101
TELEPHONE 207 775 6141
ARCHITECTURE PLANNING

CONSULTANTS:

SMILL
Pitman & Greer
170 US Route One
Falmouth, ME 04105
207-781-5242
STRUCTURAL:
Structural Design Consulting
Five Balsam Lane
Falmouth, ME 04105-2448
207-676-8008
MECHANICAL:
Whitney Engineering
10 Dunforth Place
Portland, ME 04102
207-833-2921
ELECTRICAL:
Bennett Engineering
7 Bennett Road
Freeport, ME 04032
207-866-9475

REVISIONS:

DATE: 01/14/05

PROJECT No. 0406


DRAWN BY: RPW

CHECKED BY: RPW


SCALE: AS NOTED

SHEET TITLE:
PLUMBING PLAN


M1.2

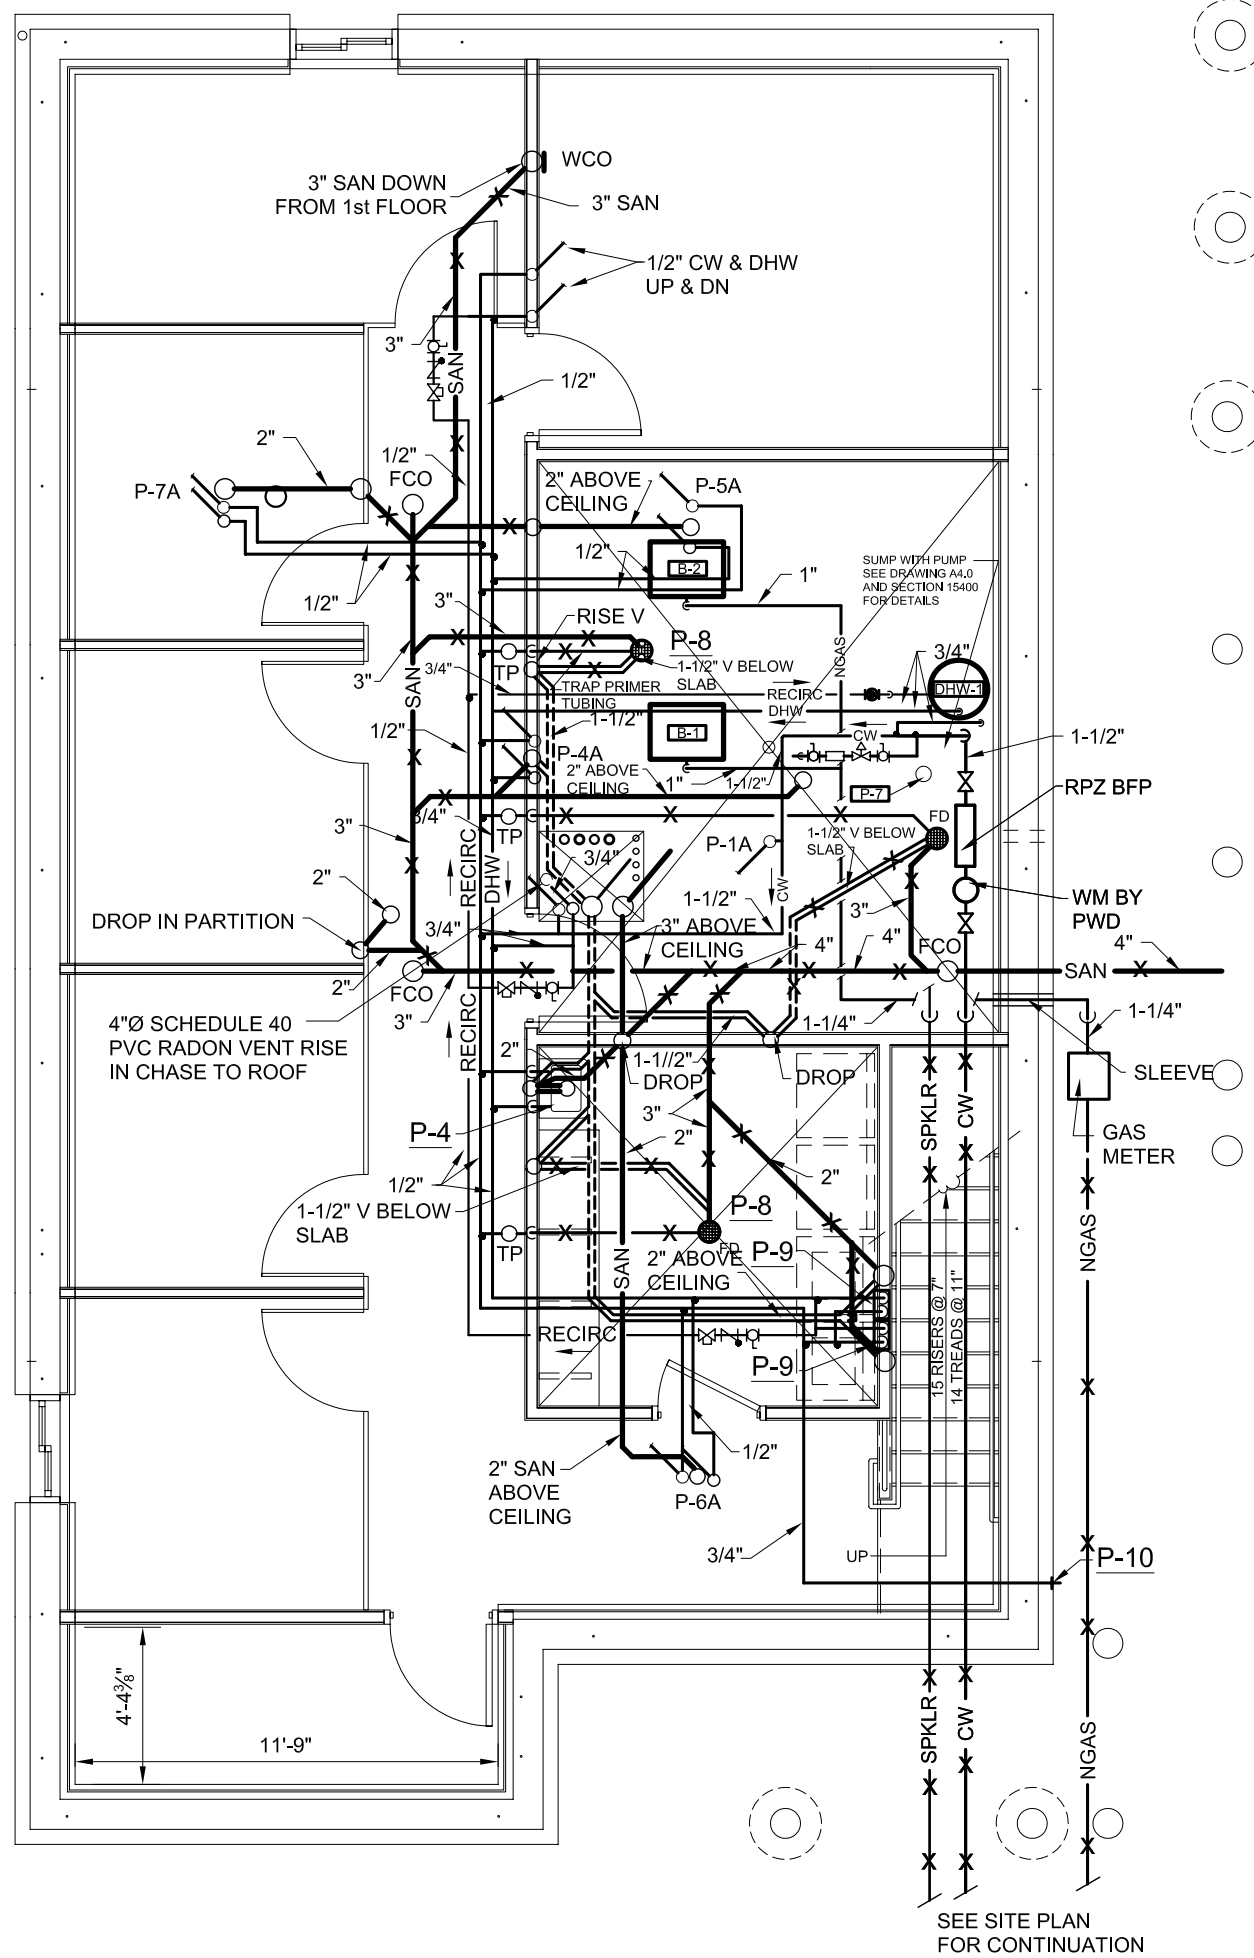


2 BASEMENT
M1.2 3/16" = 1'-0"

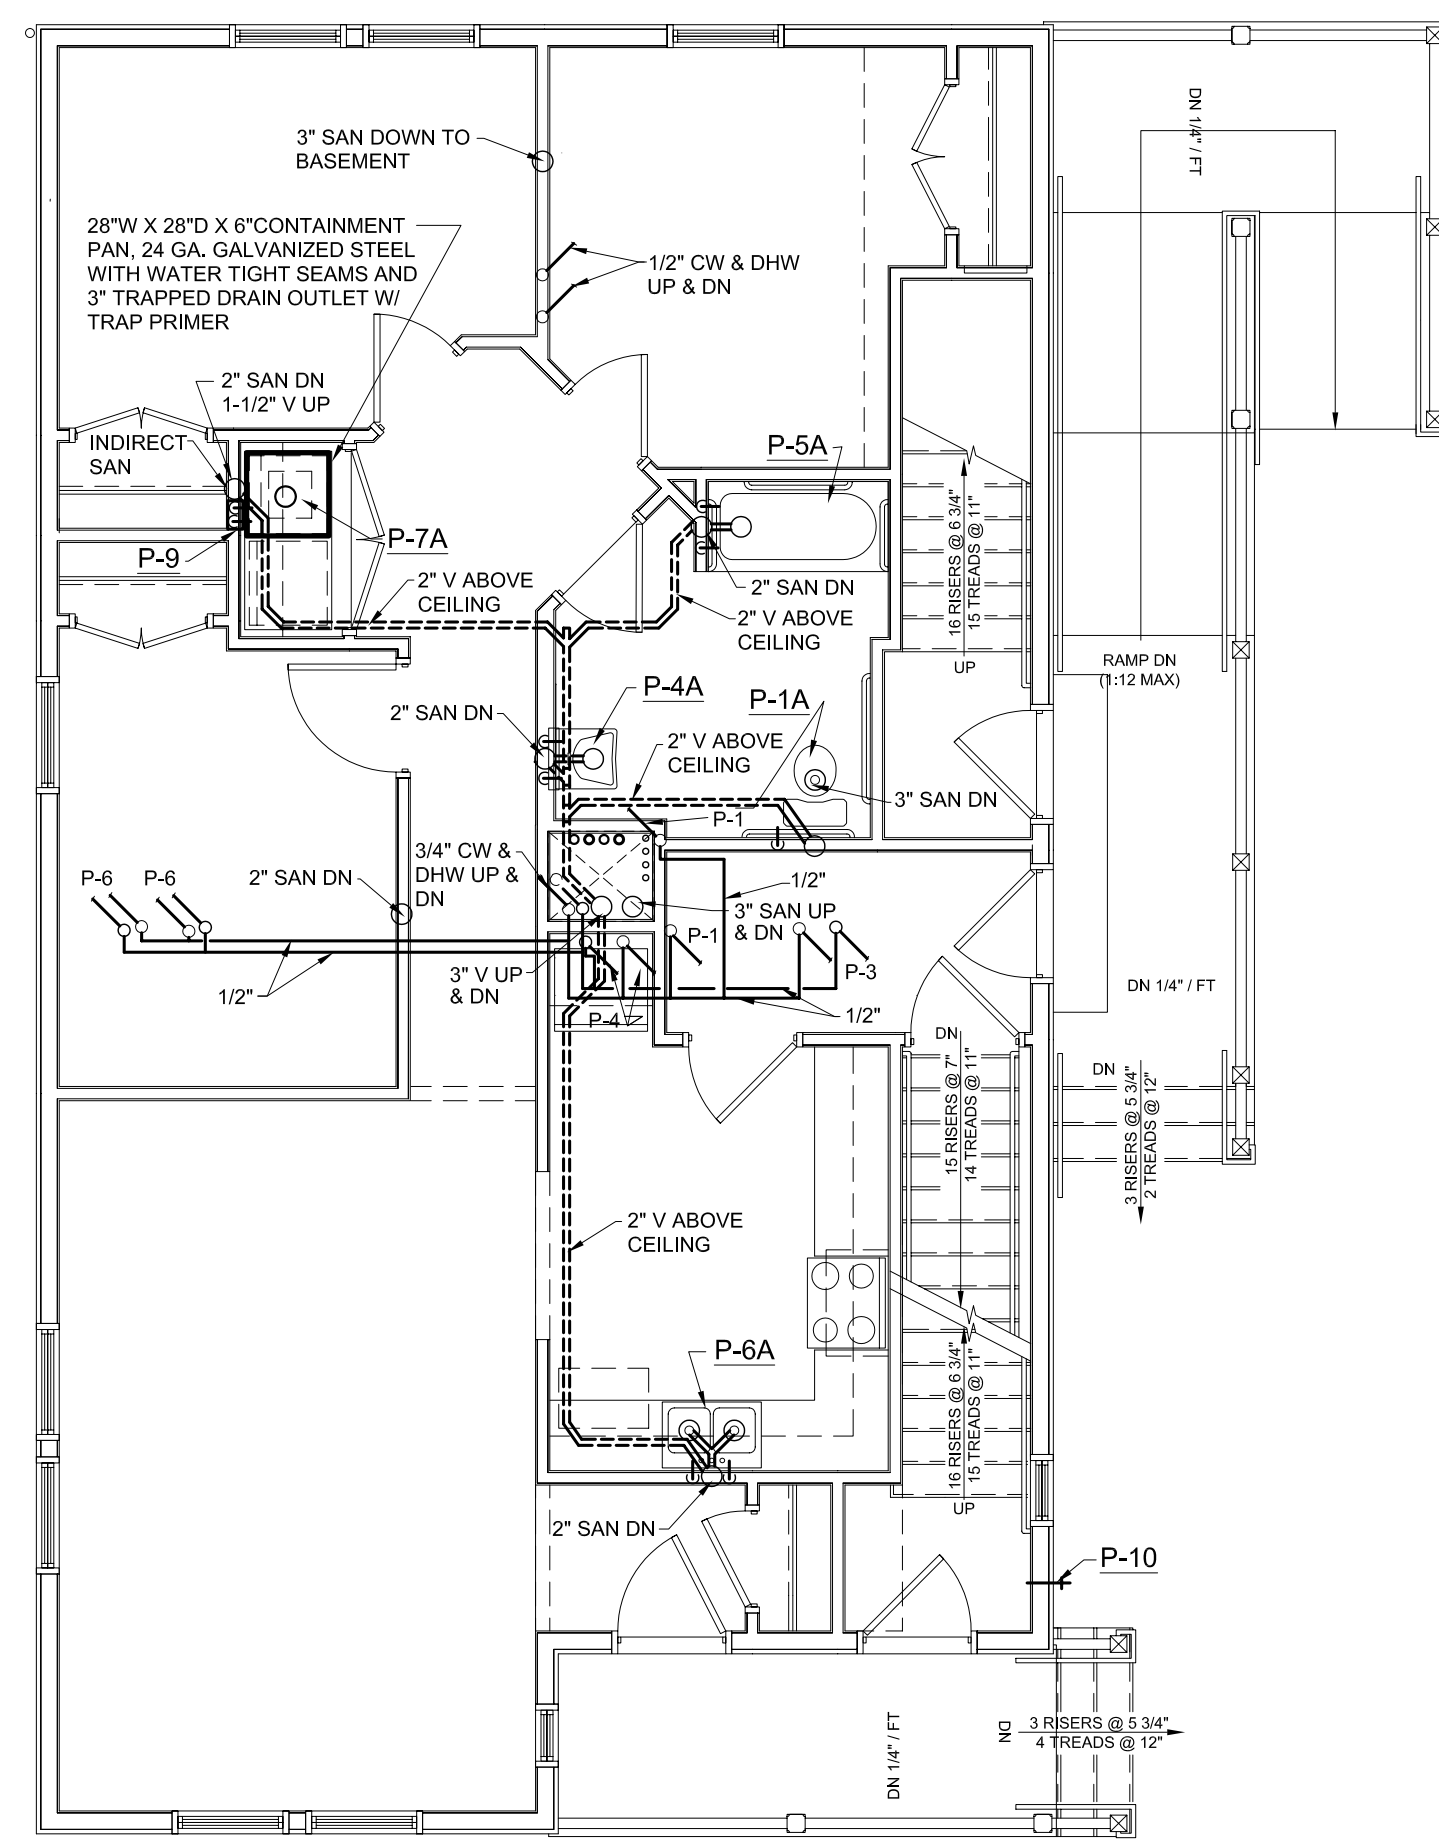

2 FIRST FLOOR
M1.2 3/16" = 1'-0"

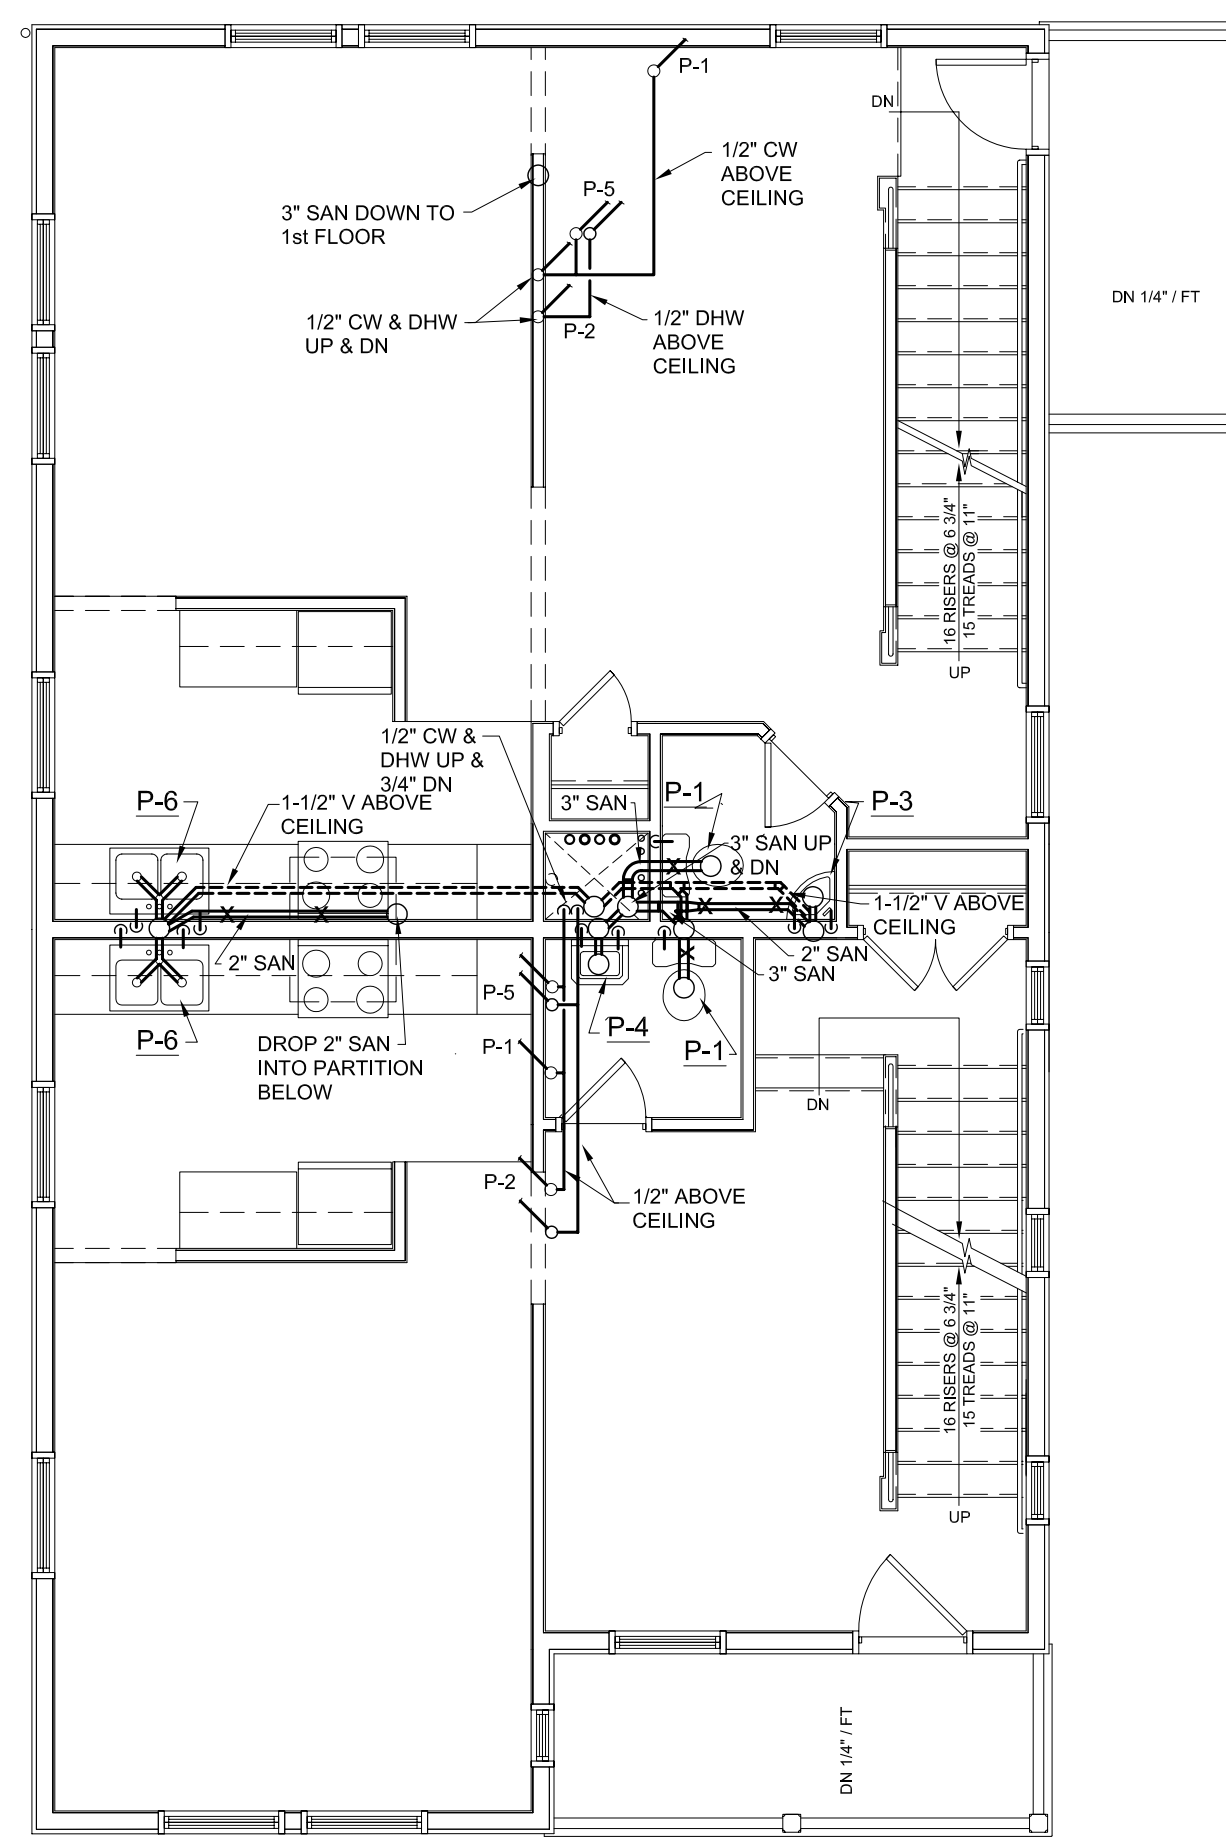

3 SECOND FLOOR
M1.2 3/16" = 1'-0"

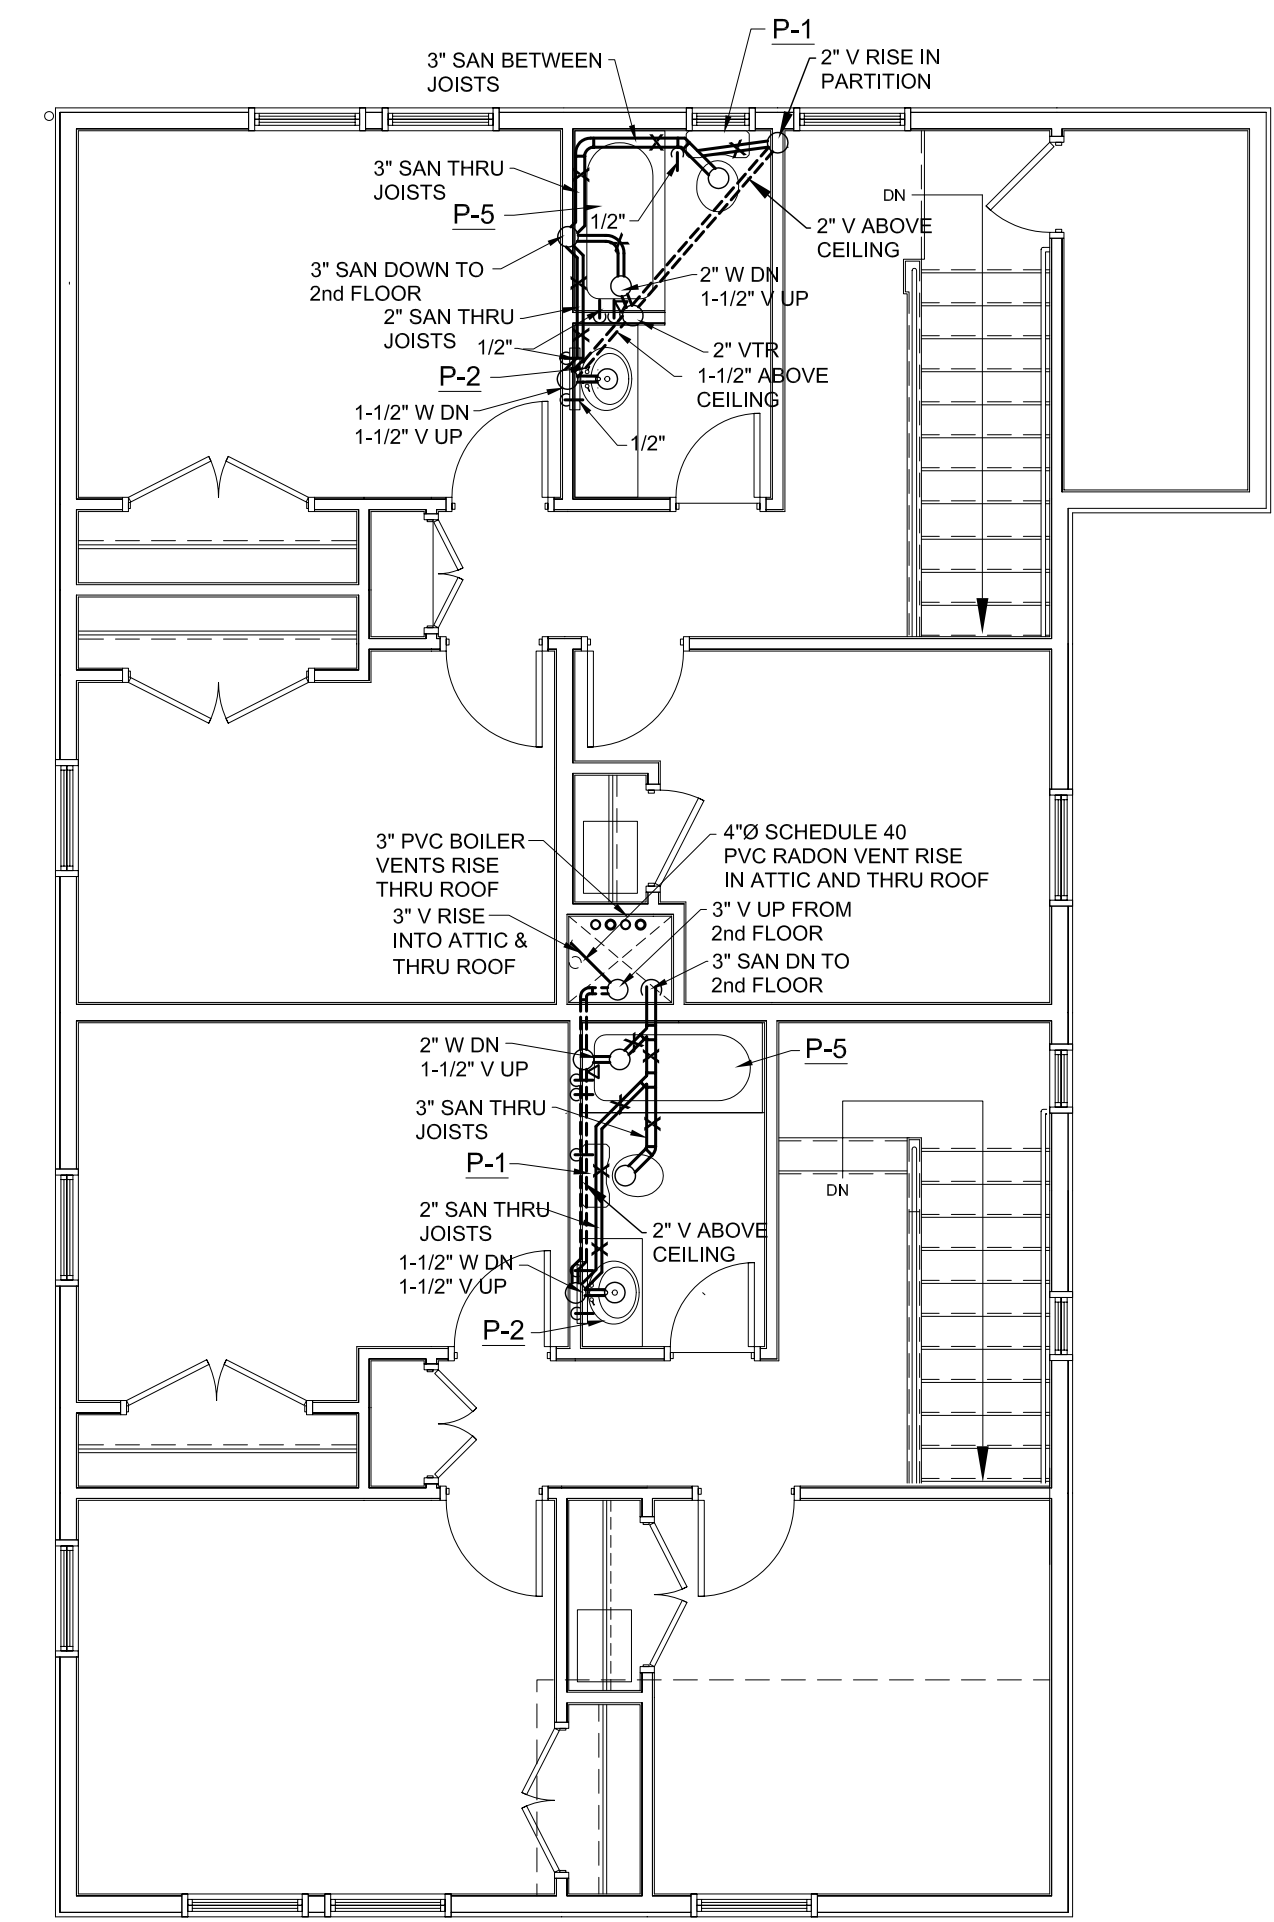

4 THIRD FLOOR
M1.2 3/16" = 1'-0"