

HEMESpHERE
DESIGN LLC



CONSTRUCTION

DIAMOND ST. WAREHOUSE RENOVATION
1-11 DIAMOND ST, PORTLAND, ME
A.D. BEANER, LLC


REFLECTED CEILING PLAN
PERMIT SET

SHEET TITLE

REVISION

DRAWN BY:
DATE: March 16, 2019

A-104

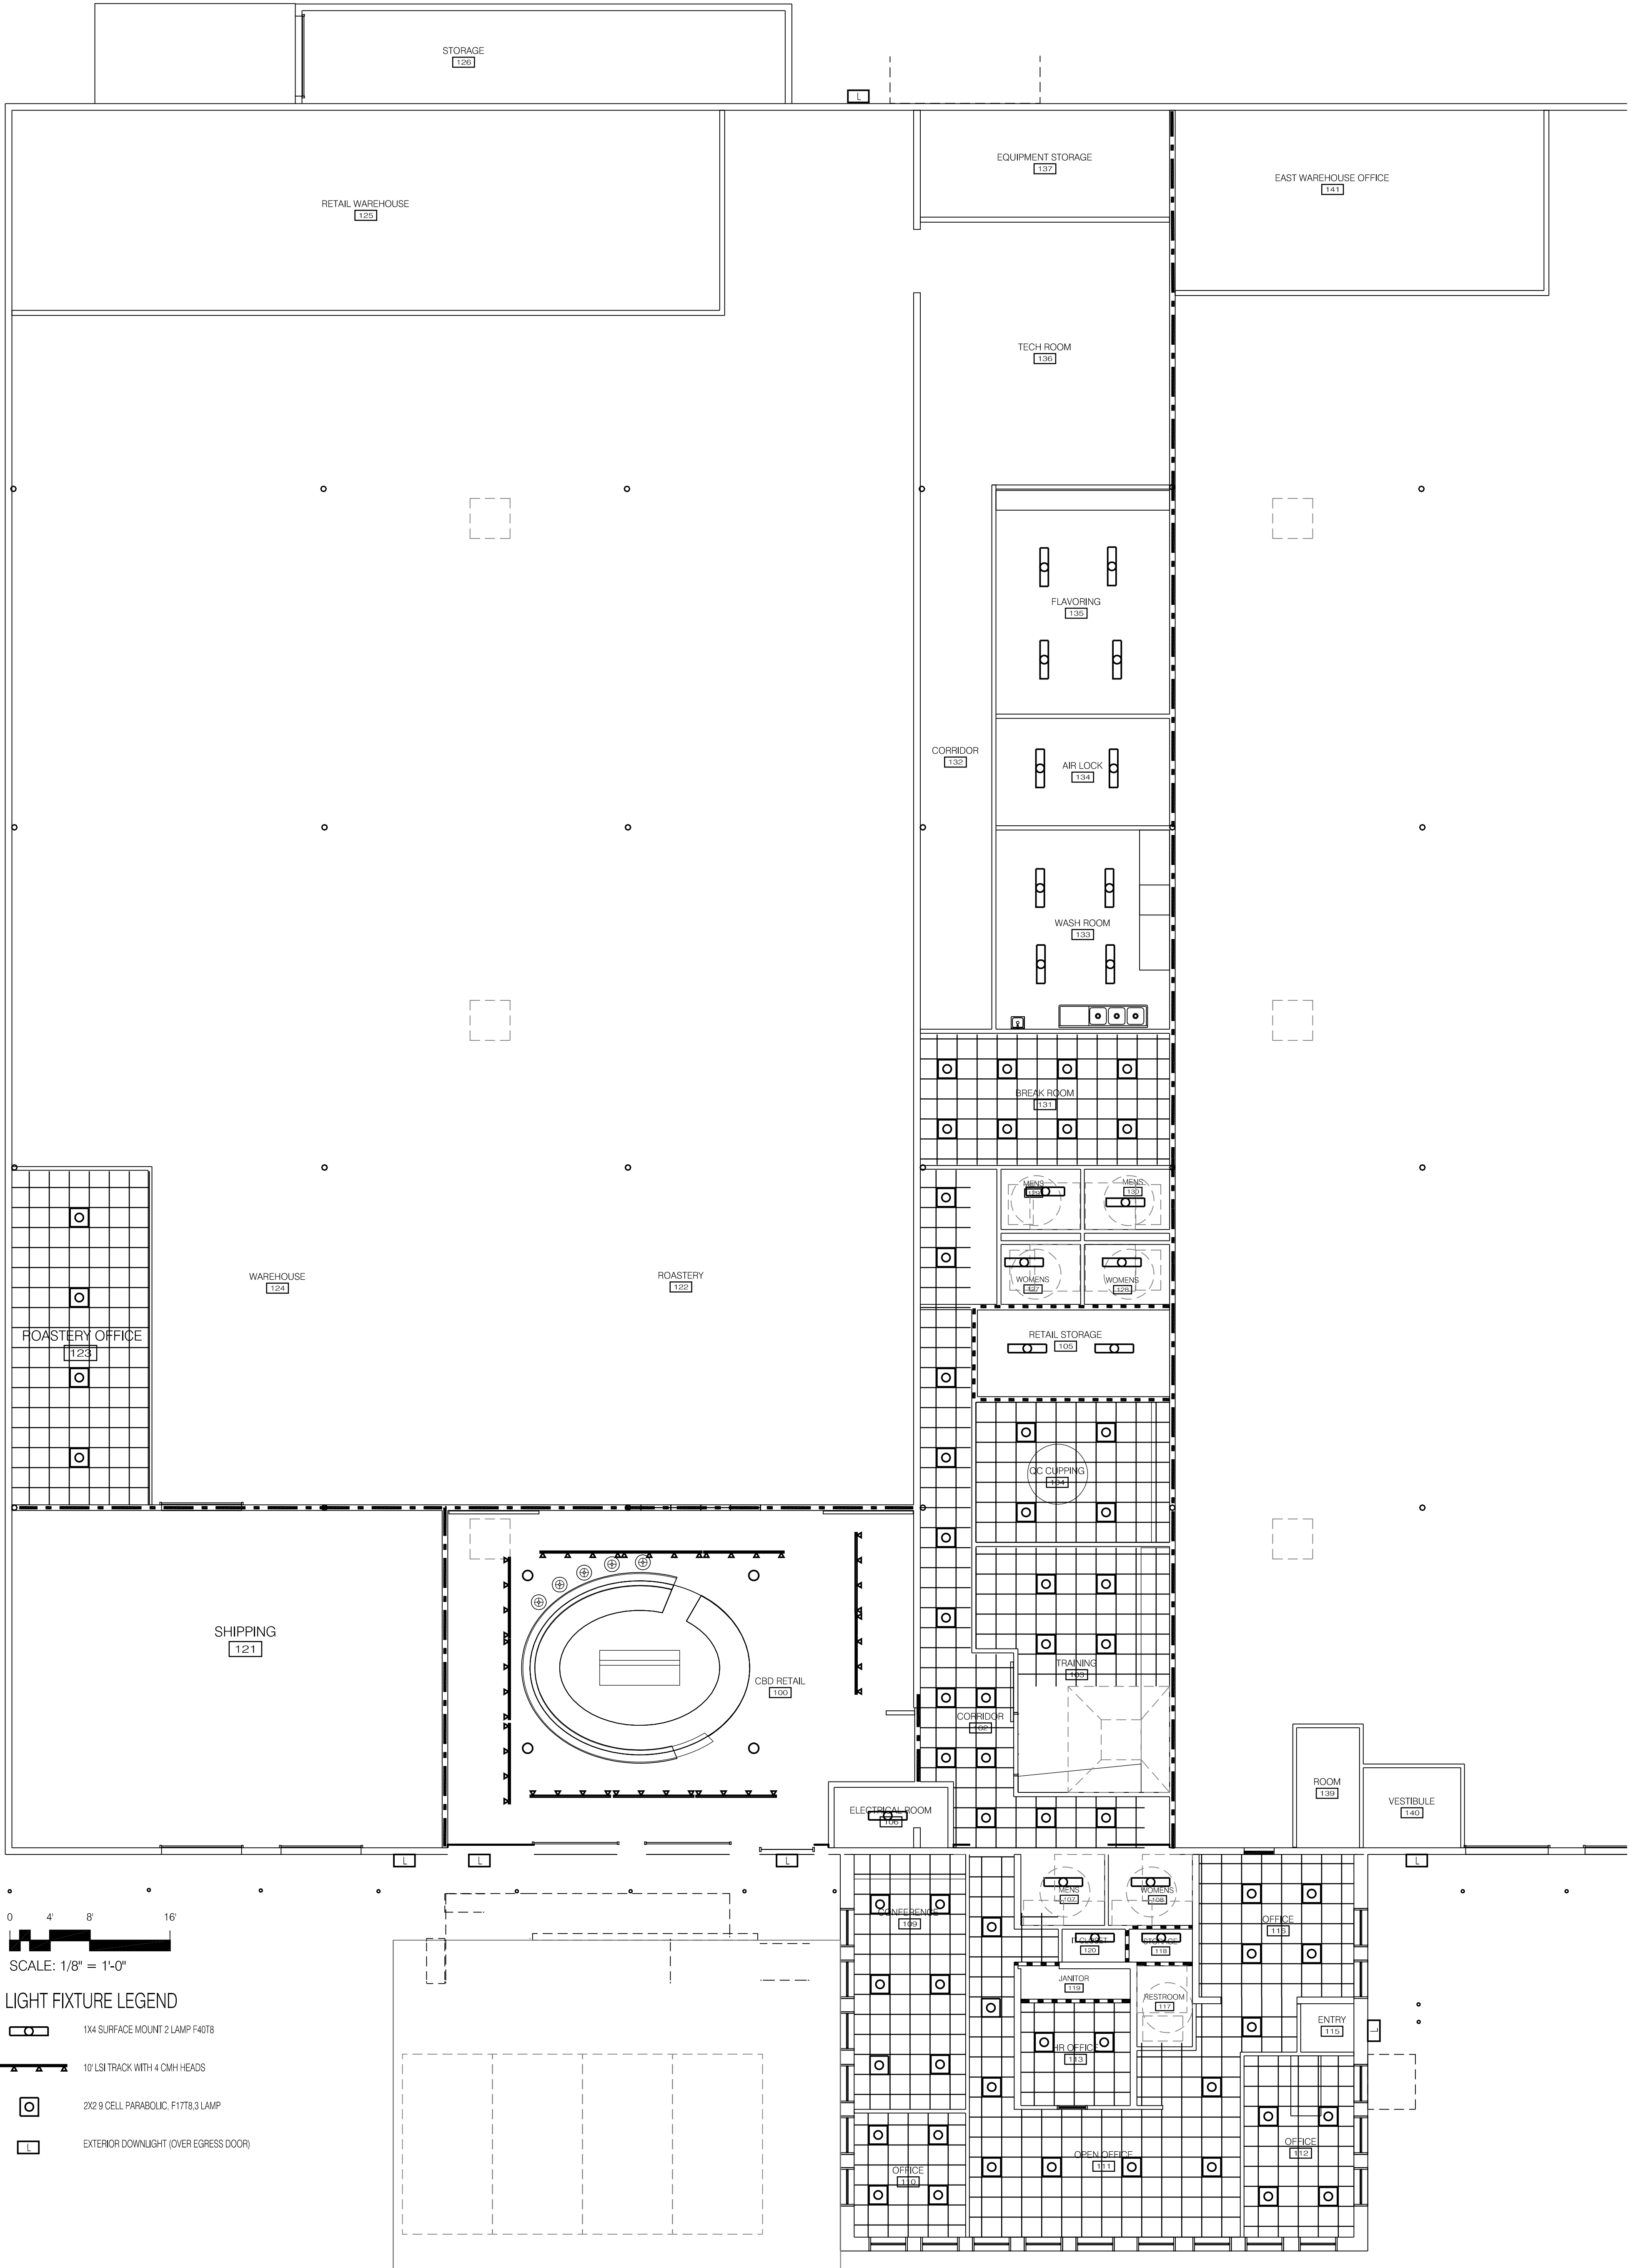

SCALE: 1/8" = 1'-0"

LIGHT FIXTURE LEGEND

- 1X4 SURFACE MOUNT 2 LAMP F40T8
- 10' LSI TRACK WITH 4 CMH HEADS
- 2X2 9 CELL PARABOLIC, F178.3 LAMP
- EXTERIOR DOWNLIGHT (OVER EGRESS DOOR)