
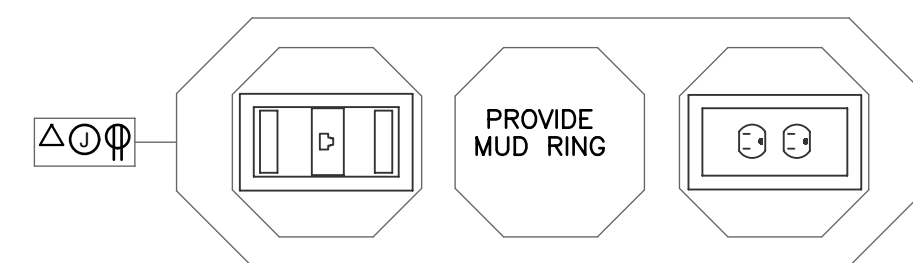



NOTES:

1. REFER TO DRAWING POWER PLAN E2.1 FOR CIRCUIT REQUIREMENTS AND MOUNTING HEIGHTS.


1 TV WALL ELEVATION
E3.2 N.T.S

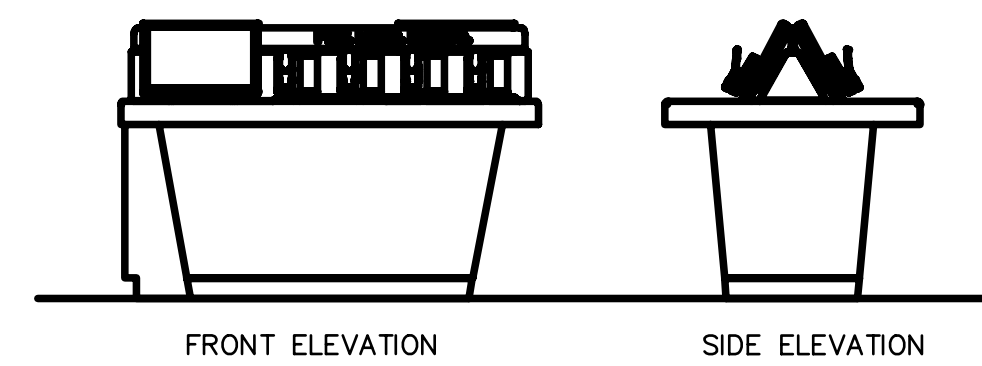

2 HTVE SHELF: DATA / MUD RING / RECEPTACLE
E3.2 N.T.S

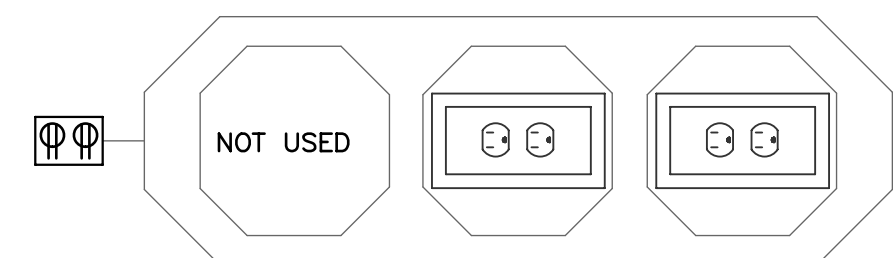


3 HTVE LCD & LIGHTING: RECEPTACLE / RECEPTACLE
E3.2 N.T.S

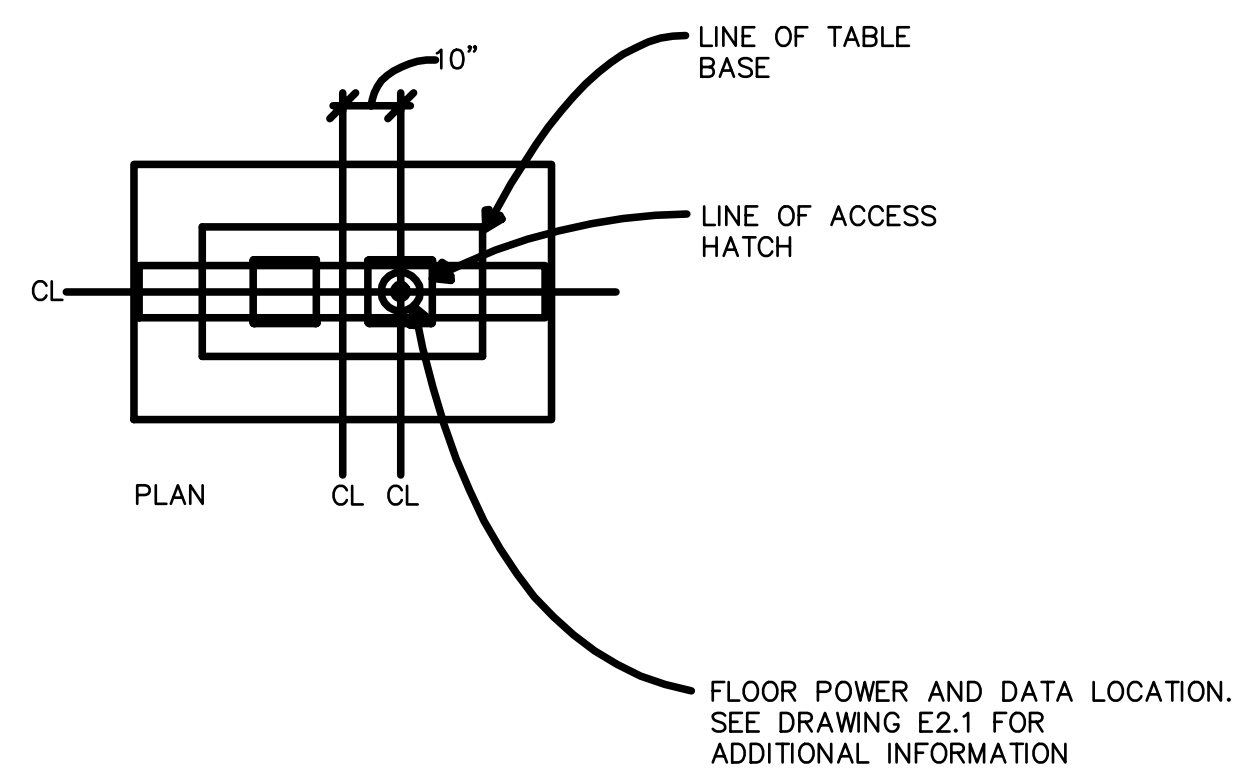


4 EXPERIENCE TABLE POWER/DATA
E3.2 DETAIL


4POS DIAGRAM

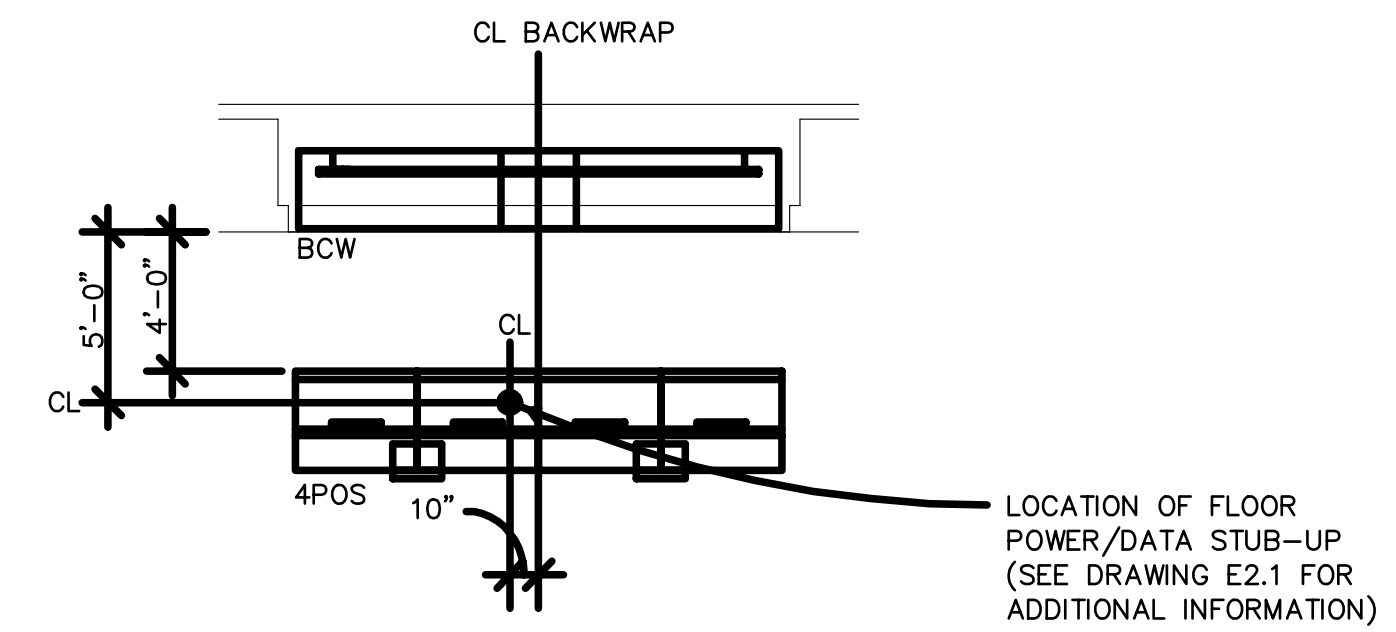

3POS DIAGRAM

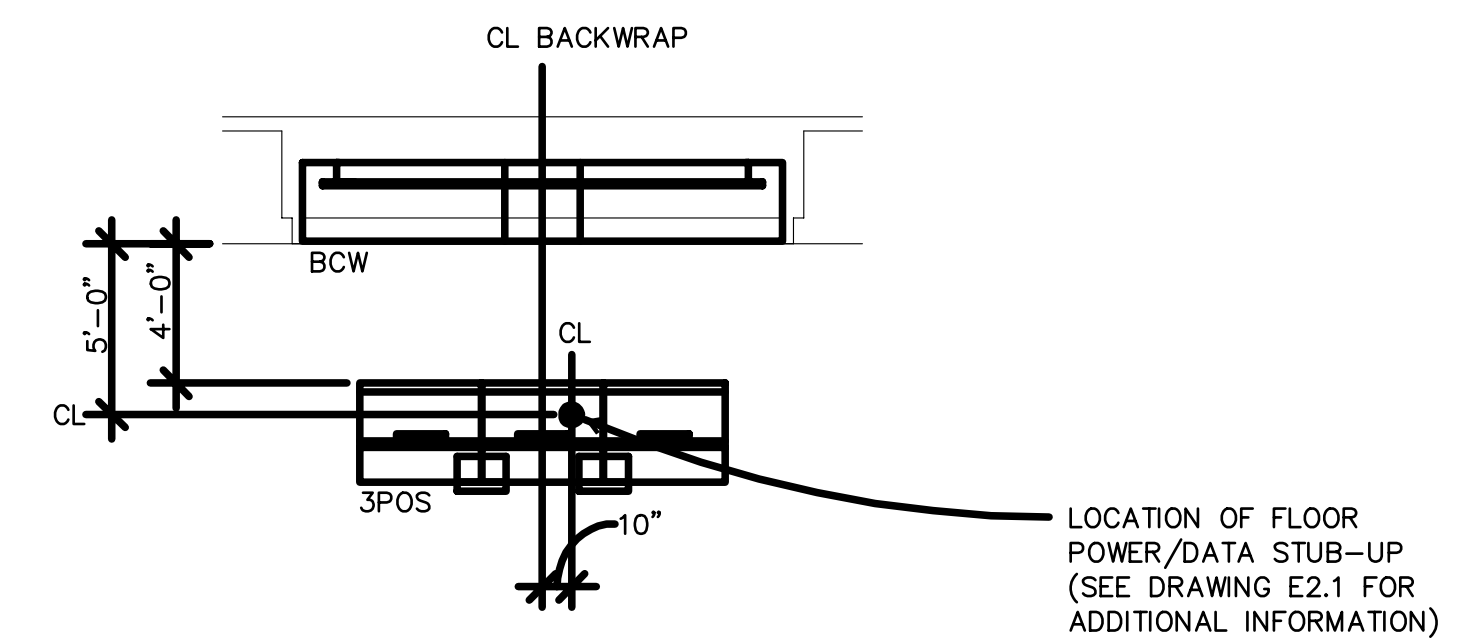

2POS DIAGRAM

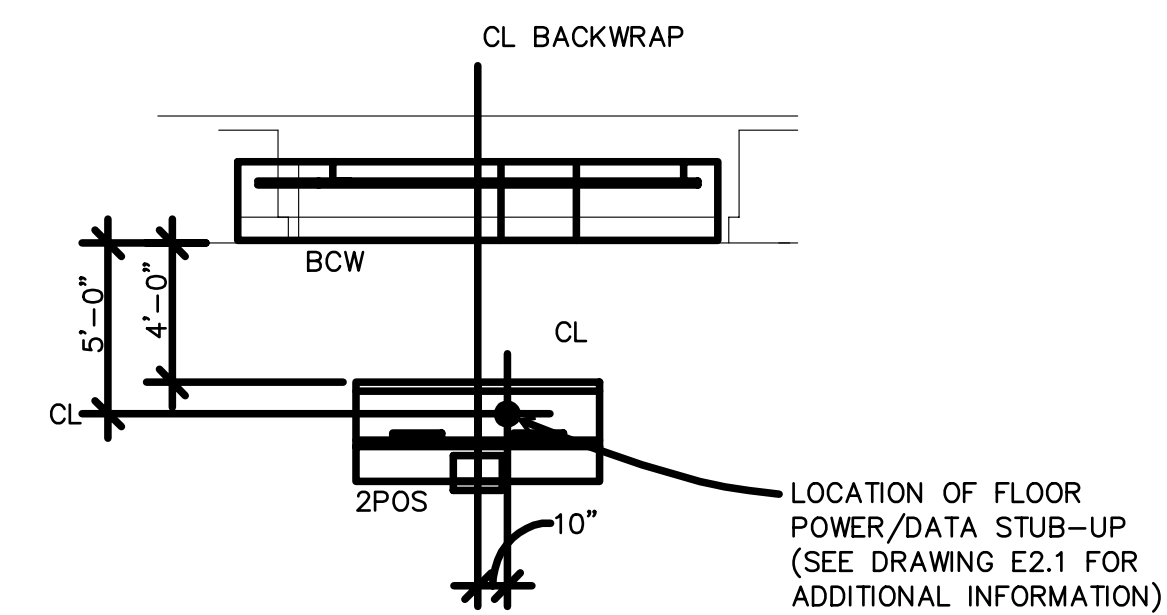

5 POS POWER/DATA DETAIL
E3.2 N.T.S


DATE: 08-14-08
JOB NO: 2982
DRAWN: AD
CHECKED:



711 N. FIELDER RD.
ARLINGTON, TX 76012
PH: (817) 635-5696
FAX: (817) 635-5699

PROJ. COORDINATOR
15 South 2nd Street
Philadelphia, PA 19106
215.922.8930
FAX: 215.922.4448

RICHARD M. COLE
& ASSOCIATES

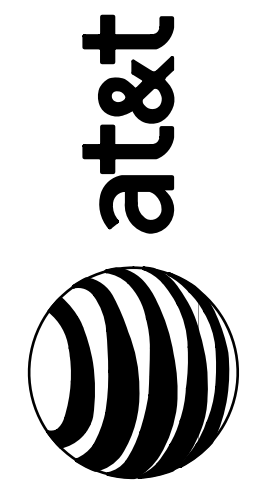

211 MARGINAL WAY
PORTLAND, MAINE 04101



530 Walnut Street | 11th Floor
Philadelphia, PA 19106
TEL 215 923 8270
FAX 215 923 8272
www.mwce.net
a subsidiary of URBAN ENGINEERS, INC.

REVISIONS

ELECTRICAL
DETAILS-
SHEET 2

SHEET NUMBER

E3.2