
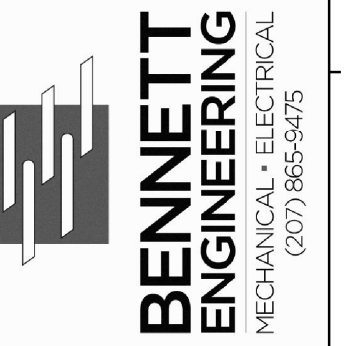
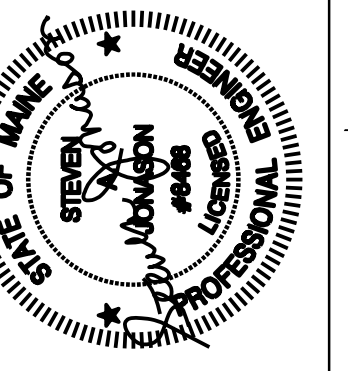
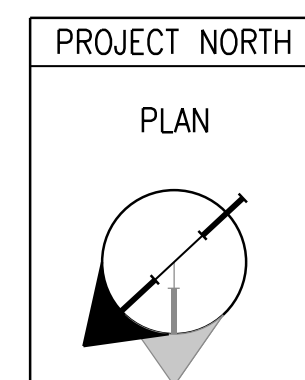
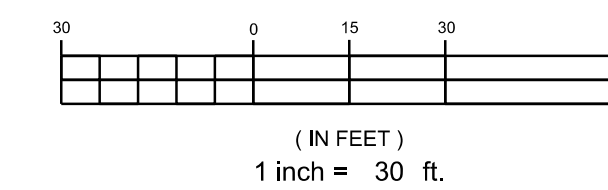


# EXTERIOR LIGHTING NOTES

BUILDING MOUNTED WALL PACK LIGHTING AND SOFFIT MOUNTED EXTERIOR LIGHTING SHALL BE FOUND ON SHEET E1.10

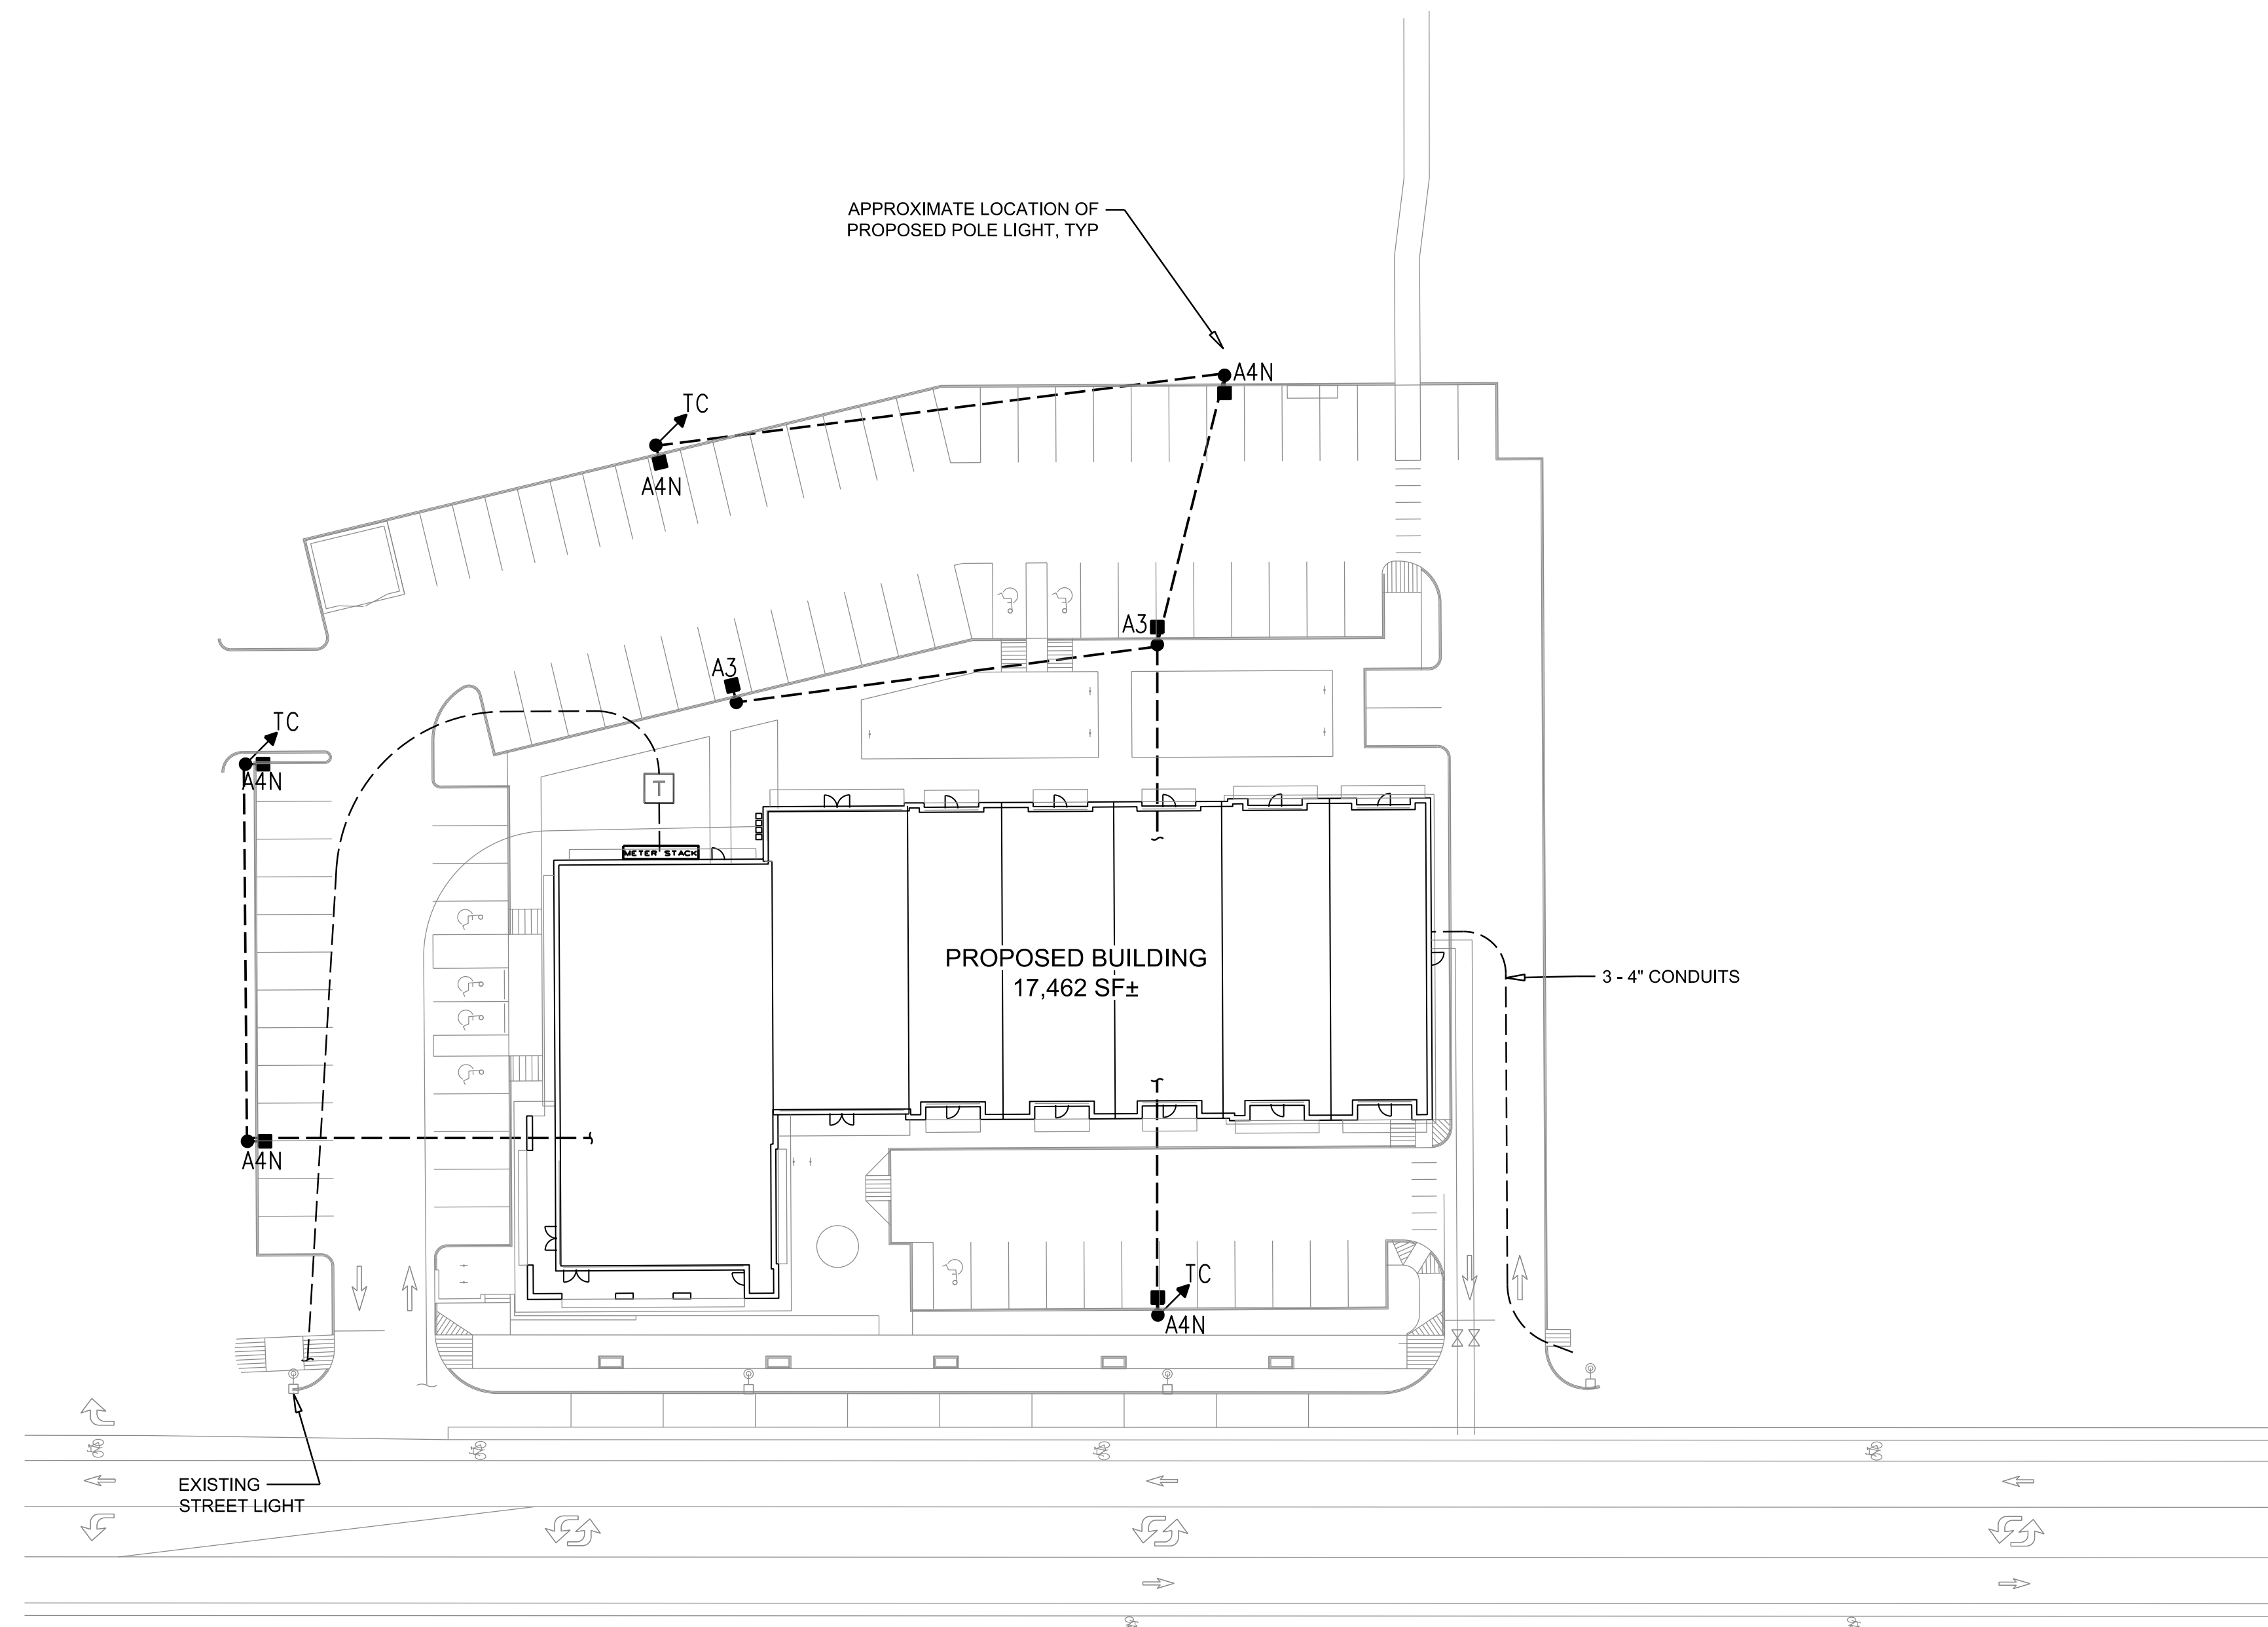

DESIGNER

OWNER  
**EARL W. NOYES & SONS**  
C/O PAUL URENECK

4600 MAYFLOWER HILL  
WATERVILLE, ME 04901  
T: 207-859-4617

PROJECT  
**191 MARGINAL WAY**  
RETAIL CENTER

191 MARGINAL WAY  
PORTLAND, MAINE 04101

DRAWING  
**LIGHTING AND**  
**ELECTRICAL SITE PLAN**

CWS PROJECT NUMBER: 15.063

REVISIONS

NO.	DATE	DESCRIPTION

DRAWING NUMBER  
**E1.00**

SCALE: 1" = 30'-0"  
DATE: 02/10/2017