

DESIGNER

OWNER

PROJECT

DRAWING

REVISIONS

EARL W. NOYES & SONS
C/O PAUL URENECK

191 MARGINAL WAY
RETAIL CENTER

MECHANICAL AND
PLUMBING PLAN

NO.	DESCRIPTION

DRAWING NUMBER
M1.10
SCALE:
DATE: 02/10/2017


4600 MAYFLOWER HILL
WATERVILLE, ME 04901
T: 207-859-4617

191 MARGINAL WAY
PORTLAND, MAINE 04101

CWS PROJECT NUMBER: 15.063

GAS LOAD BREAKDOWN

TENANT	HEATING	OTHER
RETAIL 1	130MBH	
RETAIL 2	130MBH	
RETAIL 3	130MBH	
RETAIL 4	130MBH	
RETAIL 5	130MBH	
RETAIL AB	650MBH	
RETAIL C	150MBH	
FUTURE TENANT LOAD	1500MBH	

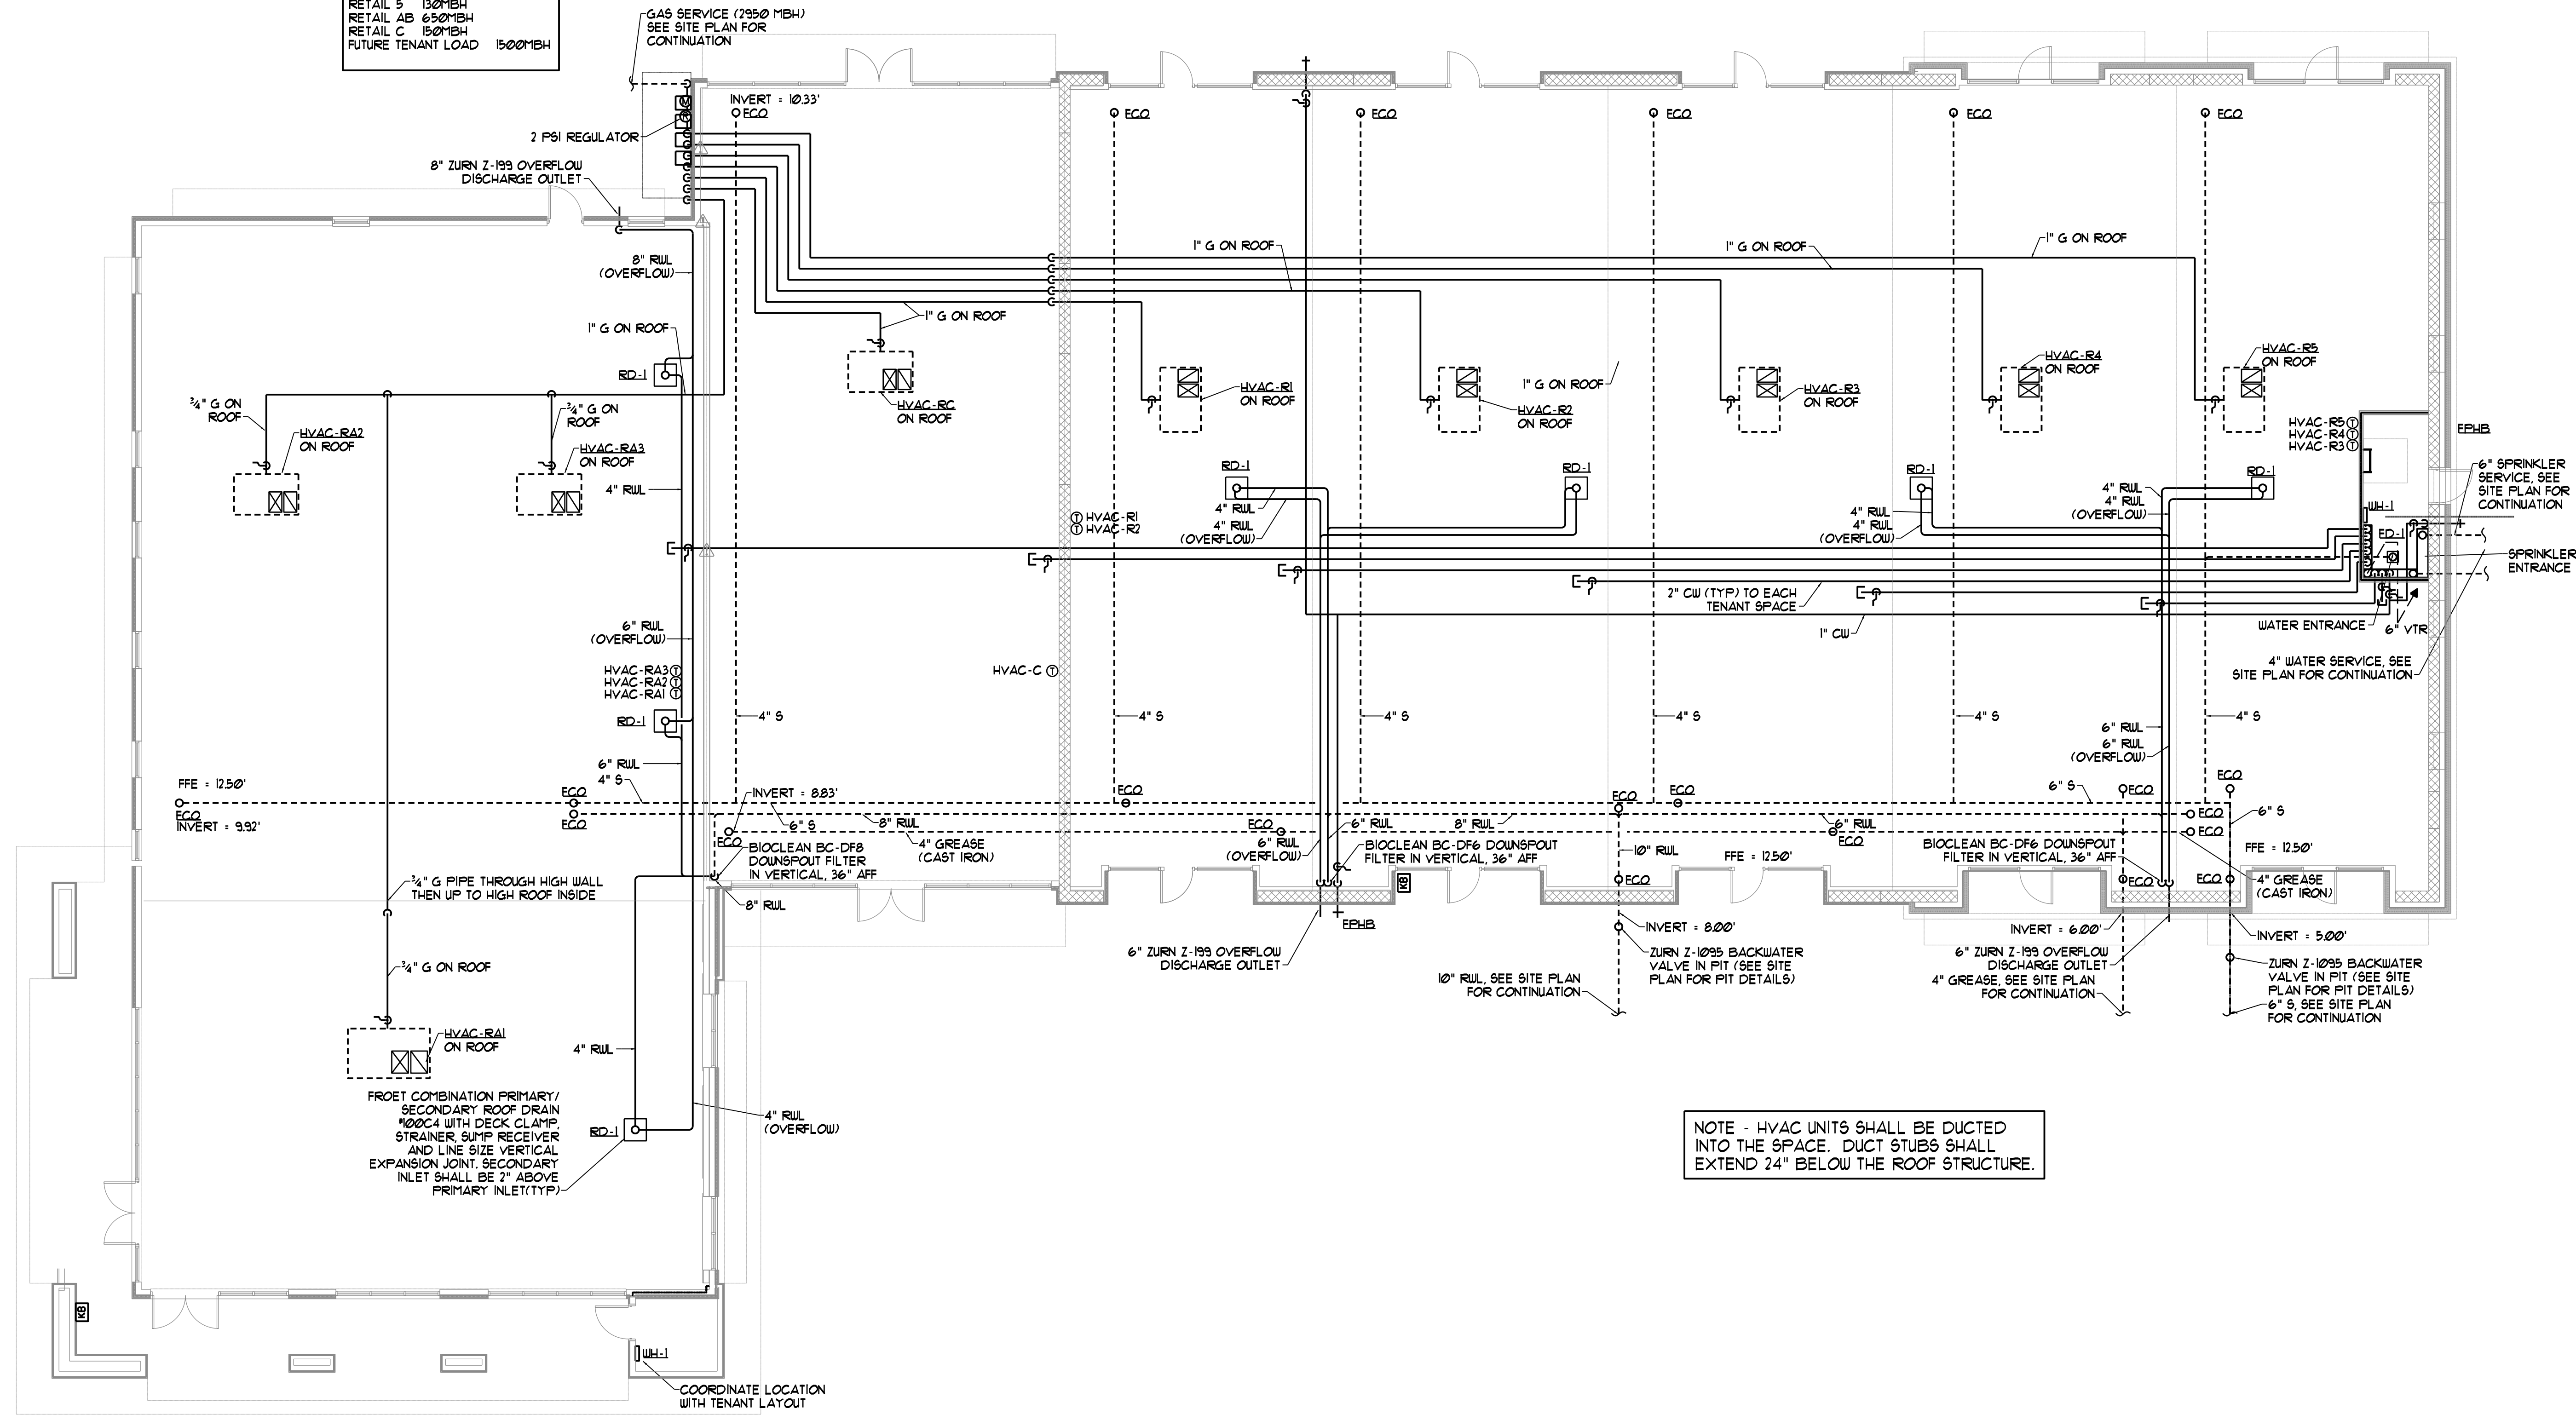

NOTE - HVAC UNITS SHALL BE DUCTED INTO THE SPACE. DUCT STUBS SHALL EXTEND 24" BELOW THE ROOF STRUCTURE.

