


ABBREVIATIONS USED IN THE PLUMBING TRADES


A. AREA	BOO. BIOCHEMICAL OXYGEN DEMAND	CW. COLD WATER	FH. FIRE HYDRANT	Hd. HEAD	Mfr. MANUFACTURER	PO. PLUGGED OUTLET	Serv. Wt. SERVICE WEIGHT	UL. UNDERWRITERS' LABORATORIES, INC.
Ab. ABOVE	Br. BRANCH	CY. CUBIC YARDS	FHR. FIRE HOSE RACK	Hgr. HORSEPOWER	MGD. MILLION GALLONS PER DAY	Parts P.M. PARTS PER MILLION	or SW. SHOWER	USA. USA STANDARDS INSTITUTE
Ab. ABSOLUTE	B&S. BELL AND SPIGOT (ALSO BROWN & SHARPE GAUGE)	D. DRAIN	FHC. FIRE HOSE CABINET	Hr. HOUR	Malleable M. MALLEABLE IRON	Press. P.S.I. POUNDS PER SQUARE INCH	Sh. Shwr. SHOWER	Ur. URINAL
AD. AREA DRAIN	Bt. BATHUB	Dep. or". DEGREE	Fig. FIGURE	Ht. HOUSE TRAP	Mi. MILD STEEL	Press. P.S.I. POUNDS PER SQUARE INCH	Sl. SINK	V. VENT
AFF. ABOVE FINISHED FLOOR	Bv. BRITISH THERMAL UNIT	Df. DOWN	Fxl. FUTURE	Hr. HEATER	Min. MINIMUM (OR MINUTE)	Press. P.S.I. POUNDS PER SQUARE INCH	Sl. SINK	Vb. VACUUM BREAKER
AGA. AMERICAN GAS ASSOCIATION	Bv. BALANCING VALVE	Dn. DOWN	Ff. FIRE FLUG	Hw. HOT WATER	N. NITROGEN	Press. P.S.I. POUNDS PER SQUARE INCH	Sn. SOLDER (OR SOLENOID)	Vc. VACUUM
AL. ALUMINUM	C. CENTER TO CENTER	Dp. DEEP	Ff. FLOOR SINK	Ia. INSIDE DIAMETER	N.A.P.H.C. NATIONAL ASSOCIATION OF PLUMBING AND HEATING CONTRACTORS	Press. P.S.I. POUNDS PER SQUARE INCH	Sp. SPRINKLER	Vd. VALVE IN VERTICAL
ANSI. AMERICAN NATIONAL STANDARDS INSTITUTE	C to C. CUBIC FEET PER MINUTE	Drg. DRAINAGE	Ff. FIRE STANDPIPE	In. INCH	N.B.F.U. NATIONAL BOARD OF FIRE UNDERWRITERS	Quart. QUART	Spec. SPECIFICATION	Vf. VALVE IN VERTICAL
API. AMERICAN PETROLEUM INSTITUTE	Cs. CATCH BASIN	Dwg. DRAWING	Ff. FUTURE UNIT	In. INCH	N.B.S. NATIONAL BUREAU OF STANDARDS	Quart. QUART	Sq. Sq. Ft. SQUARE FEET	Vg. VALVE IN VERTICAL
ASA. AMERICAN STANDARD ASSOCIATION	Cs. CHECK VALVE	Dwg. DRAWING	G. GAS	In. INCH	N.F.P.A. NATIONAL FIRE PROTECTIVE ASSOCIATION	Quart. QUART	Sq. Sq. Ft. SQUARE FEET	Vh. VALVE IN VERTICAL
ASCE. AMERICAN SOCIETY OF CIVIL ENGINEERING	Ck. V. CHECK VALVE	Dwg. DRAWING	G. GALV. GALVANIZED	In. INCH	N.I.C. NATIONAL INSTITUTE OF CLEANING	Quart. QUART	Sq. Sq. Ft. SQUARE FEET	Vl. VOLUME
ASHRAE. AMERICAN SOCIETY OF HEATING, REFRIGERATION, AND AIR CONDITIONING ENGINEERS	Ck. V. CHECK VALVE	Dwg. DRAWING	G. GALV. GALVANIZED	In. INCH	N.I.C. NATIONAL INSTITUTE OF CLEANING	Quart. QUART	Sq. Sq. Ft. SQUARE FEET	Vl. VOLUME
ASME. AMERICAN SOCIETY OF MECHANICAL ENGINEERS	Ck. V. CHECK VALVE	Dwg. DRAWING	G. GALV. GALVANIZED	In. INCH	N.I.C. NATIONAL INSTITUTE OF CLEANING	Quart. QUART	Sq. Sq. Ft. SQUARE FEET	Vl. VOLUME
ASPE. AMERICAN SOCIETY OF PLUMBING ENGINEERS	Ck. V. CHECK VALVE	Dwg. DRAWING	G. GALV. GALVANIZED	In. INCH	N.I.C. NATIONAL INSTITUTE OF CLEANING	Quart. QUART	Sq. Sq. Ft. SQUARE FEET	Vl. VOLUME
ASSE. AMERICAN SOCIETY OF SANITARY ENGINEERING	Ck. V. CHECK VALVE	Dwg. DRAWING	G. GALV. GALVANIZED	In. INCH	N.I.C. NATIONAL INSTITUTE OF CLEANING	Quart. QUART	Sq. Sq. Ft. SQUARE FEET	Vl. VOLUME
ASTM. AMERICAN SOCIETY FOR TESTING AND MATERIALS	Ck. V. CHECK VALVE	Dwg. DRAWING	G. GALV. GALVANIZED	In. INCH	N.I.C. NATIONAL INSTITUTE OF CLEANING	Quart. QUART	Sq. Sq. Ft. SQUARE FEET	Vl. VOLUME
AV. AVERAGE	Ck. V. CHECK VALVE	Dwg. DRAWING	G. GALV. GALVANIZED	In. INCH	N.I.C. NATIONAL INSTITUTE OF CLEANING	Quart. QUART	Sq. Sq. Ft. SQUARE FEET	Vl. VOLUME
AW. ACID WASTE	Ck. V. CHECK VALVE	Dwg. DRAWING	G. GALV. GALVANIZED	In. INCH	N.I.C. NATIONAL INSTITUTE OF CLEANING	Quart. QUART	Sq. Sq. Ft. SQUARE FEET	Vl. VOLUME
AWWA. AMERICAN WATER WORKS ASSOCIATION	Ck. V. CHECK VALVE	Dwg. DRAWING	G. GALV. GALVANIZED	In. INCH	N.I.C. NATIONAL INSTITUTE OF CLEANING	Quart. QUART	Sq. Sq. Ft. SQUARE FEET	Vl. VOLUME
B. BARREL	Ck. V. CHECK VALVE	Dwg. DRAWING	G. GALV. GALVANIZED	In. INCH	N.I.C. NATIONAL INSTITUTE OF CLEANING	Quart. QUART	Sq. Sq. Ft. SQUARE FEET	Vl. VOLUME
Bf. BACKFLOW PREVENTER	Ck. V. CHECK VALVE	Dwg. DRAWING	G. GALV. GALVANIZED	In. INCH	N.I.C. NATIONAL INSTITUTE OF CLEANING	Quart. QUART	Sq. Sq. Ft. SQUARE FEET	Vl. VOLUME
BOCA. BUILDING OFFICIALS CONFERENCE OF AMERICA	Ck. V. CHECK VALVE	Dwg. DRAWING	G. GALV. GALVANIZED	In. INCH	N.I.C. NATIONAL INSTITUTE OF CLEANING	Quart. QUART	Sq. Sq. Ft. SQUARE FEET	Vl. VOLUME

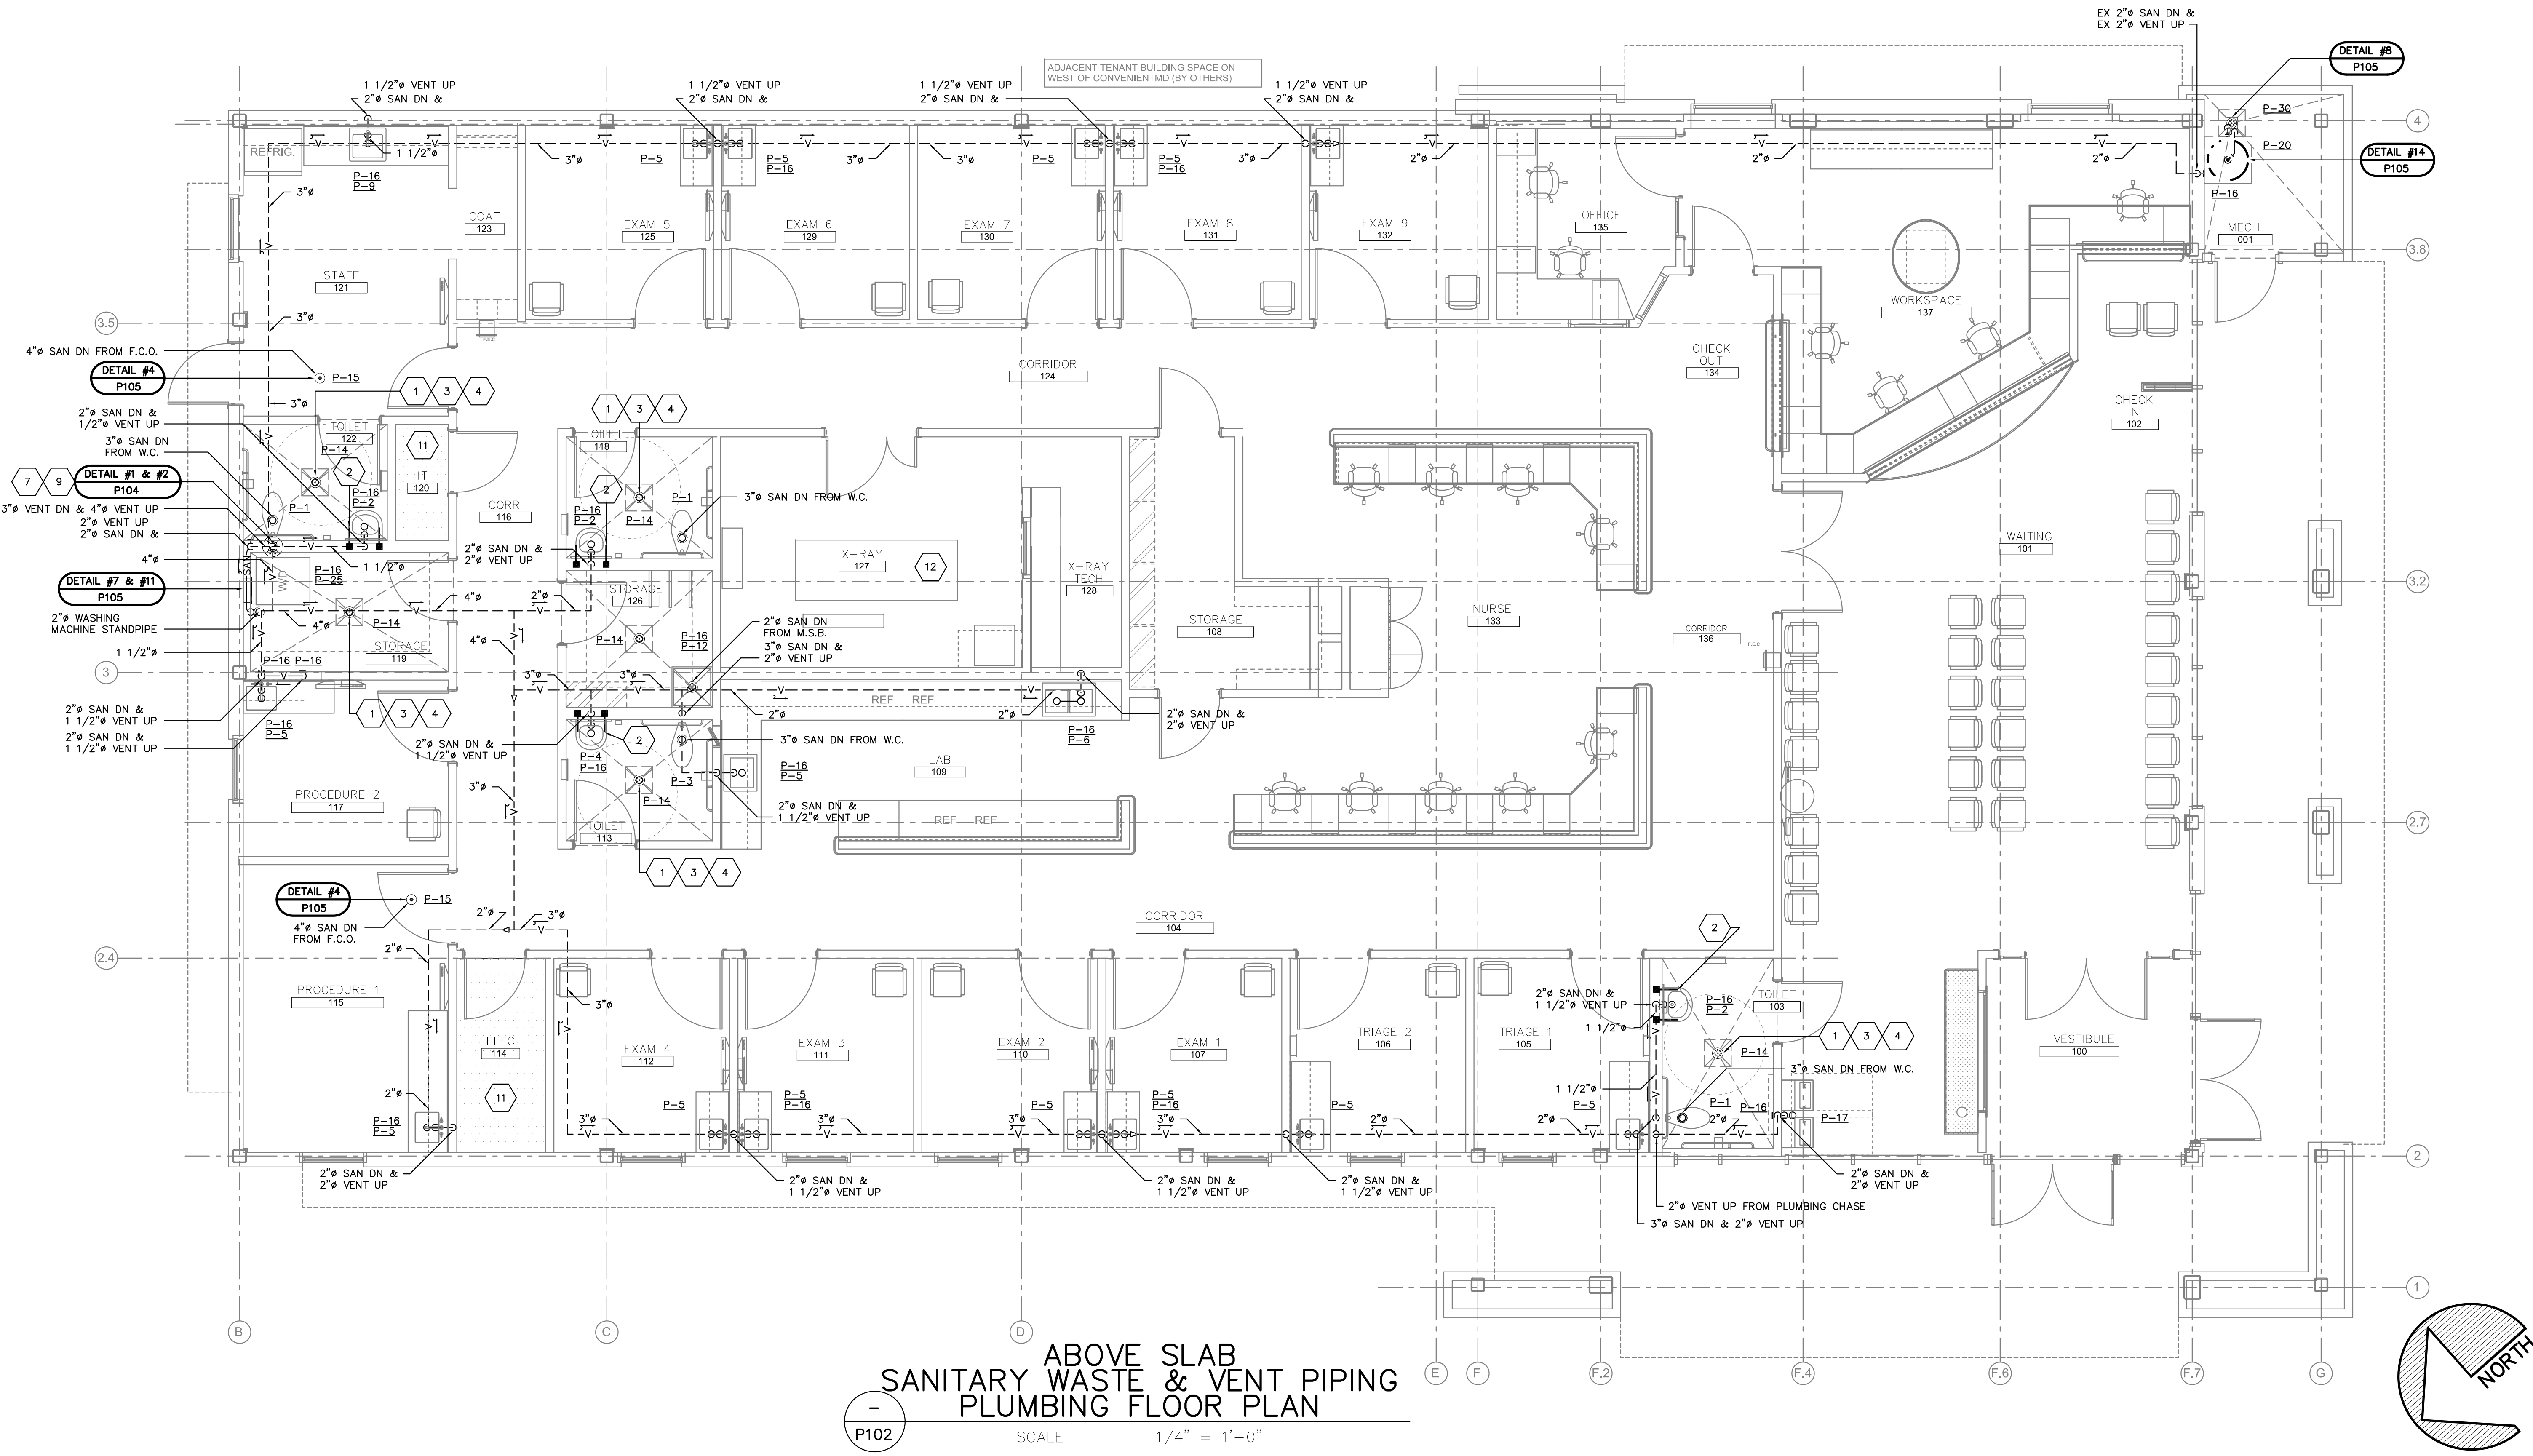

ABOVE SLAB
SANITARY WASTE & VENT PIPING
PLUMBING FLOOR PLAN
SCALE 1/4" = 1'-0"

convenient MD
191 Marginal Way
Portland, Maine

DESIGN DAY
MECHANICALS INC
FOR THE ARCHITECTS
AND CORRESPONDENCE TO THE PROJECT MANAGER.
PLUMBING: RICHARD D. GARDNER
94 GOLF STREET, MANCHESTER, NH 03102

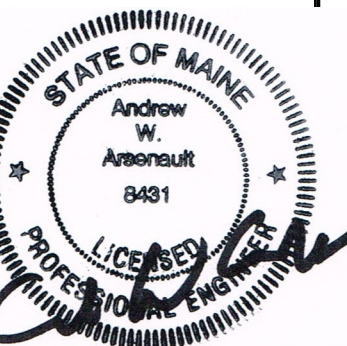

DENNIS MIRE, P.A.
THE ARCHITECTS
697 Union Street, Manchester, NH
603-625-1546 FAX 603-625-1067

This work is prepared by these architects and engineers in accordance with the design they are prepared to convey and the construction of the project. The architect and engineer shall not be held responsible for the construction of the project unless they have specifically agreed to do so in writing. The architect and engineer shall not be held responsible for the construction of the project unless they have specifically agreed to do so in writing. The architect and engineer shall not be held responsible for the construction of the project unless they have specifically agreed to do so in writing.

CMD "FIT-UP"
ABOVE SLAB
SANITARY WASTE
PLUMBING FLOOR
PLAN

SCALE: 1/4" = 1'-0"
revisions:

date: 8/24/17
proj. no. 2014-055
DDM #1016

P102

PLB SHEET 2 OF 7