

DESIGNER
OWNER
EARL W. NOYES & SONS
C/O PAUL URENECK

4600 MAYFLOWER HILL
WATERVILLE, ME 04901
T: 207-859-4617

PROJECT
191 MARGINAL WAY
RETAIL CENTER

191 MARGINAL WAY
PORTLAND, MAINE 04101


DRAWING
MECHANICAL AND
PLUMBING PLAN

CWS PROJECT NUMBER: 15.063

REVISIONS


NO.	DATE	DESCRIPTION

DRAWING NUMBER
M1.10
SCALE:
DATE: 02/21/2017

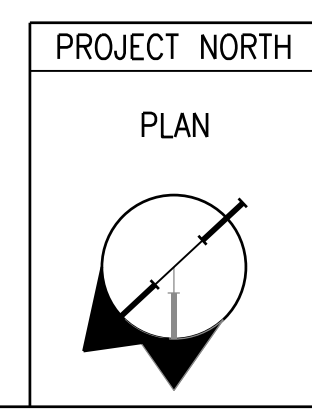

GAS LOAD BREAKDOWN

TENANT	HEATING	OTHER
RETAIL 1	130MBH	
RETAIL 2	130MBH	
RETAIL 3	130MBH	
RETAIL 4	130MBH	
RETAIL 5	130MBH	
RETAIL AB	650MBH	
RETAIL C	150MBH	
FUTURE TENANT LOAD	1500MBH	

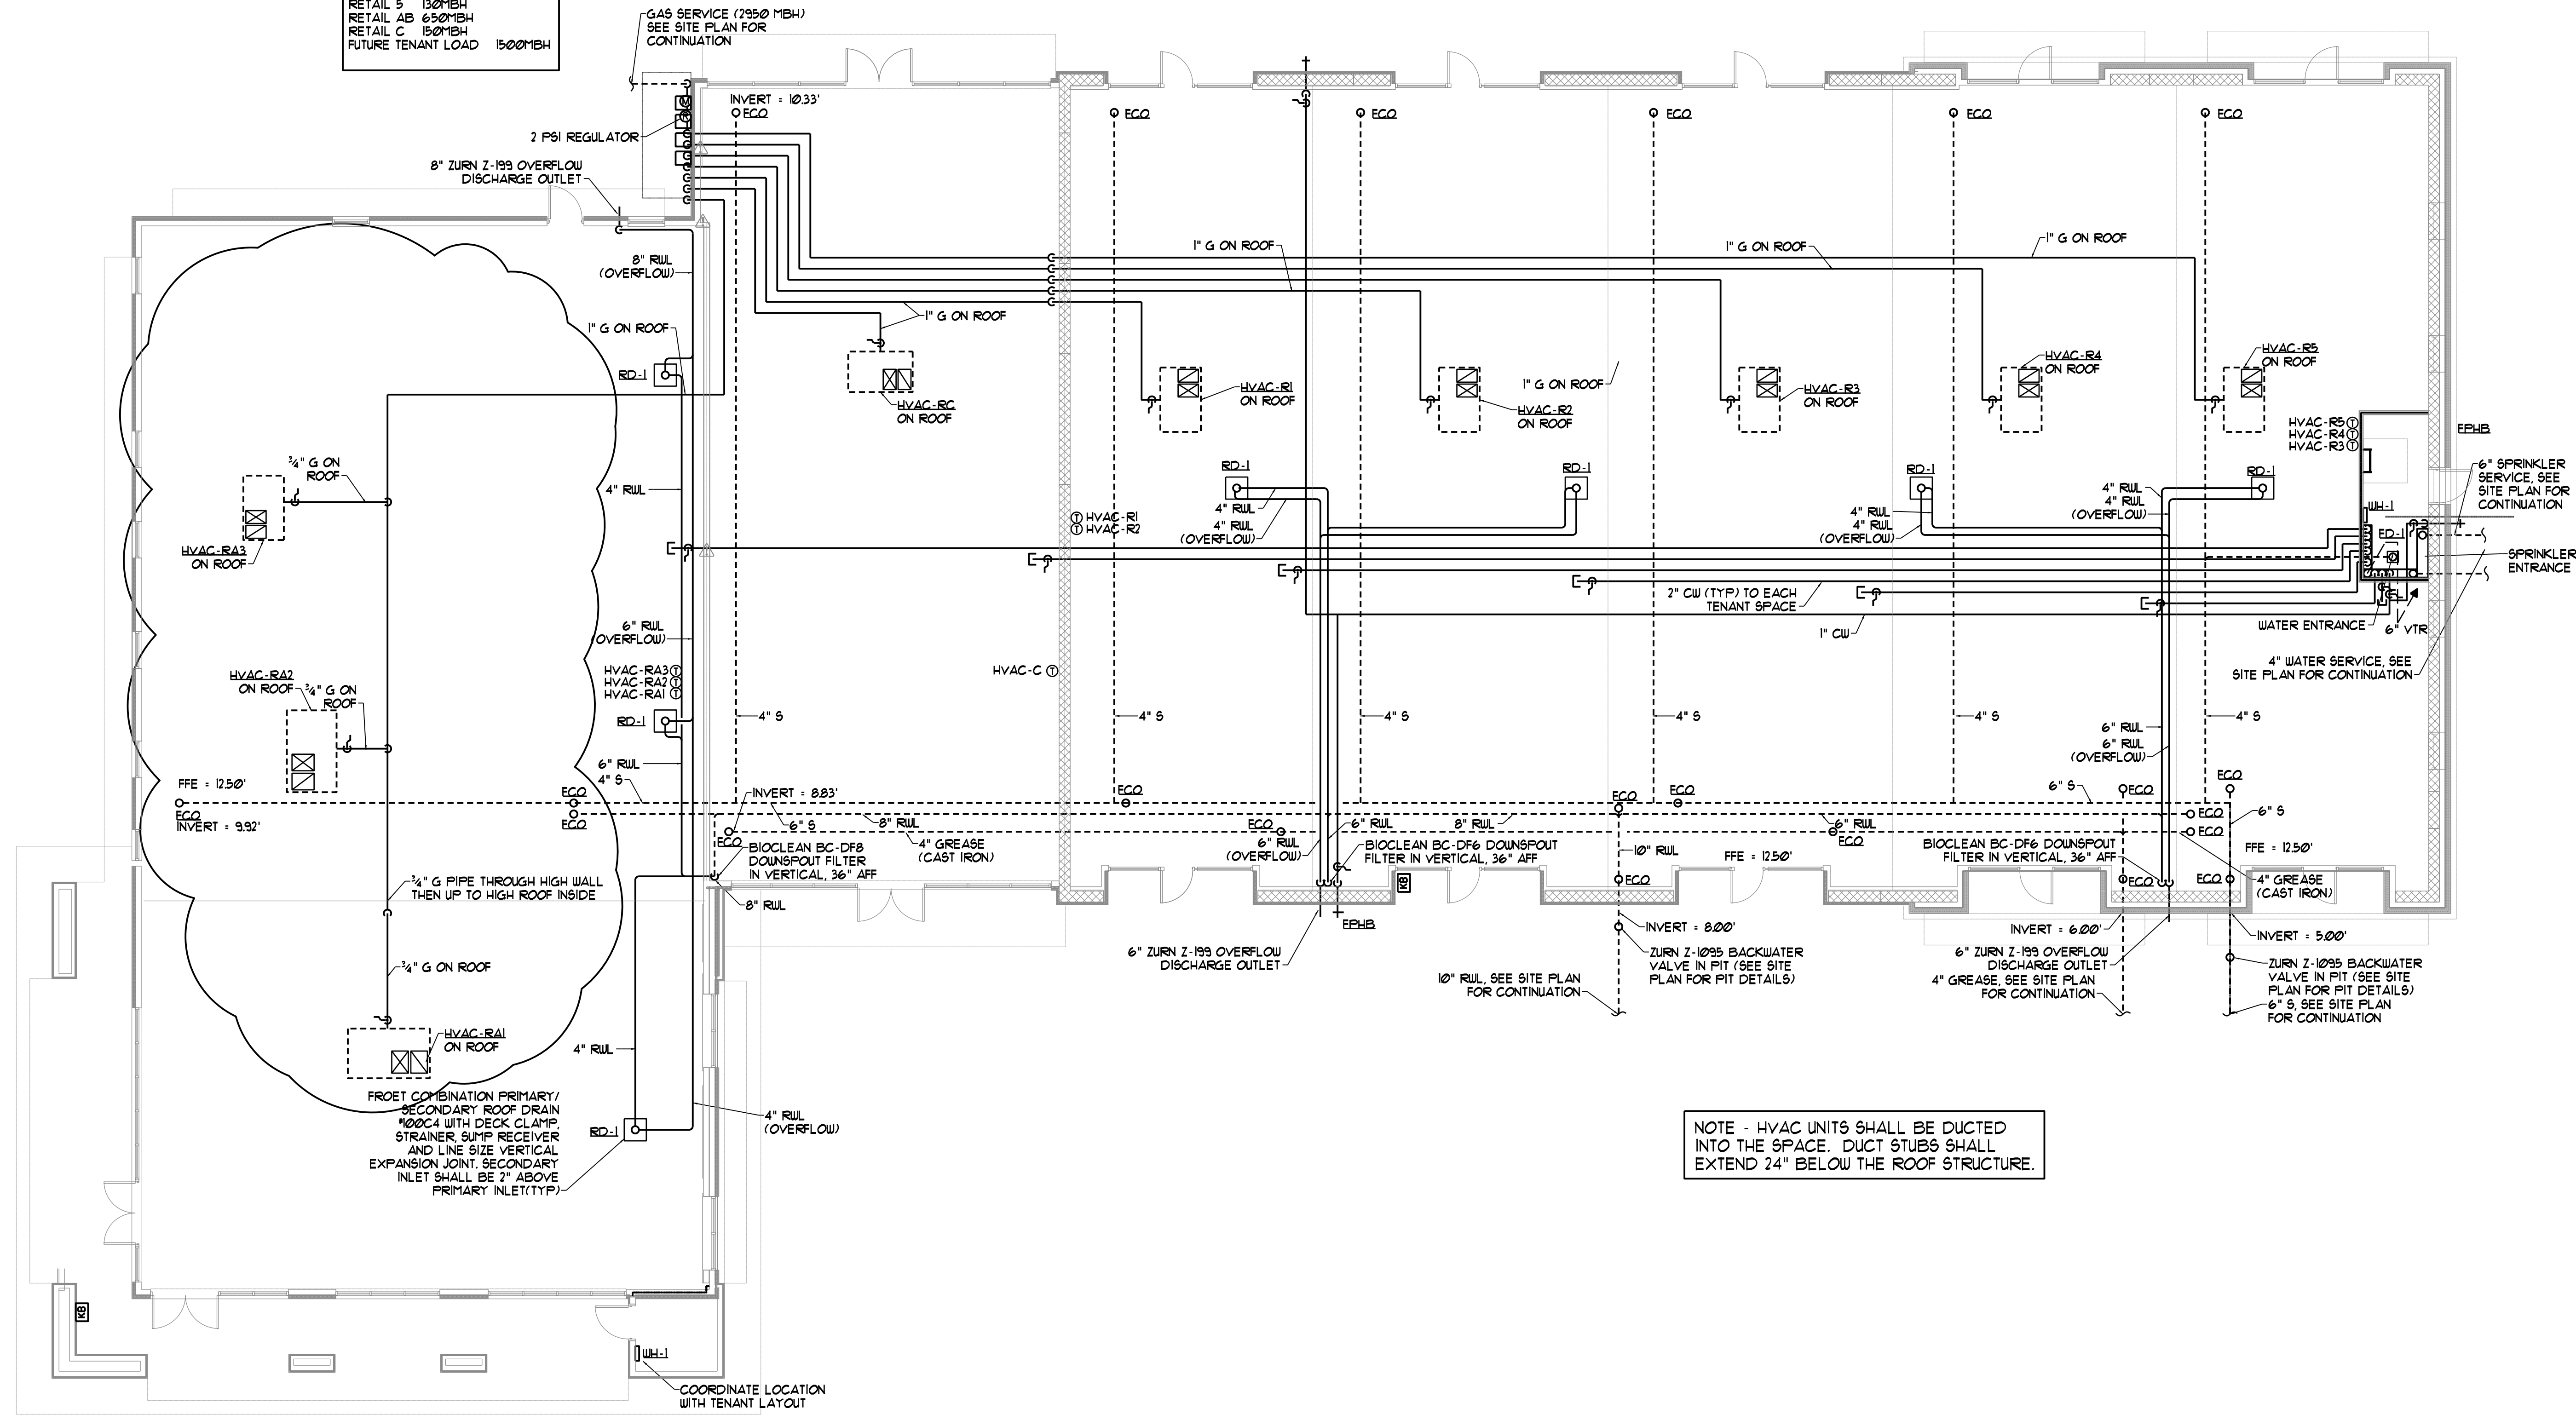

NOTE - HVAC UNITS SHALL BE DUCTED INTO THE SPACE. DUCT STUBS SHALL EXTEND 24" BELOW THE ROOF STRUCTURE.

1
2
3
4
5

A B C D E F G H