

HARRIMAN

AUBURN PORTLAND MANCHESTER




WHOLE FOODS MARKET
PUB DEVELOPMENT AND DEPARTMENT
RELOCATIONS
2 SOMERSET ST
PORTLAND, ME


Harriman Project No. 15103

Key Plan


Proj North

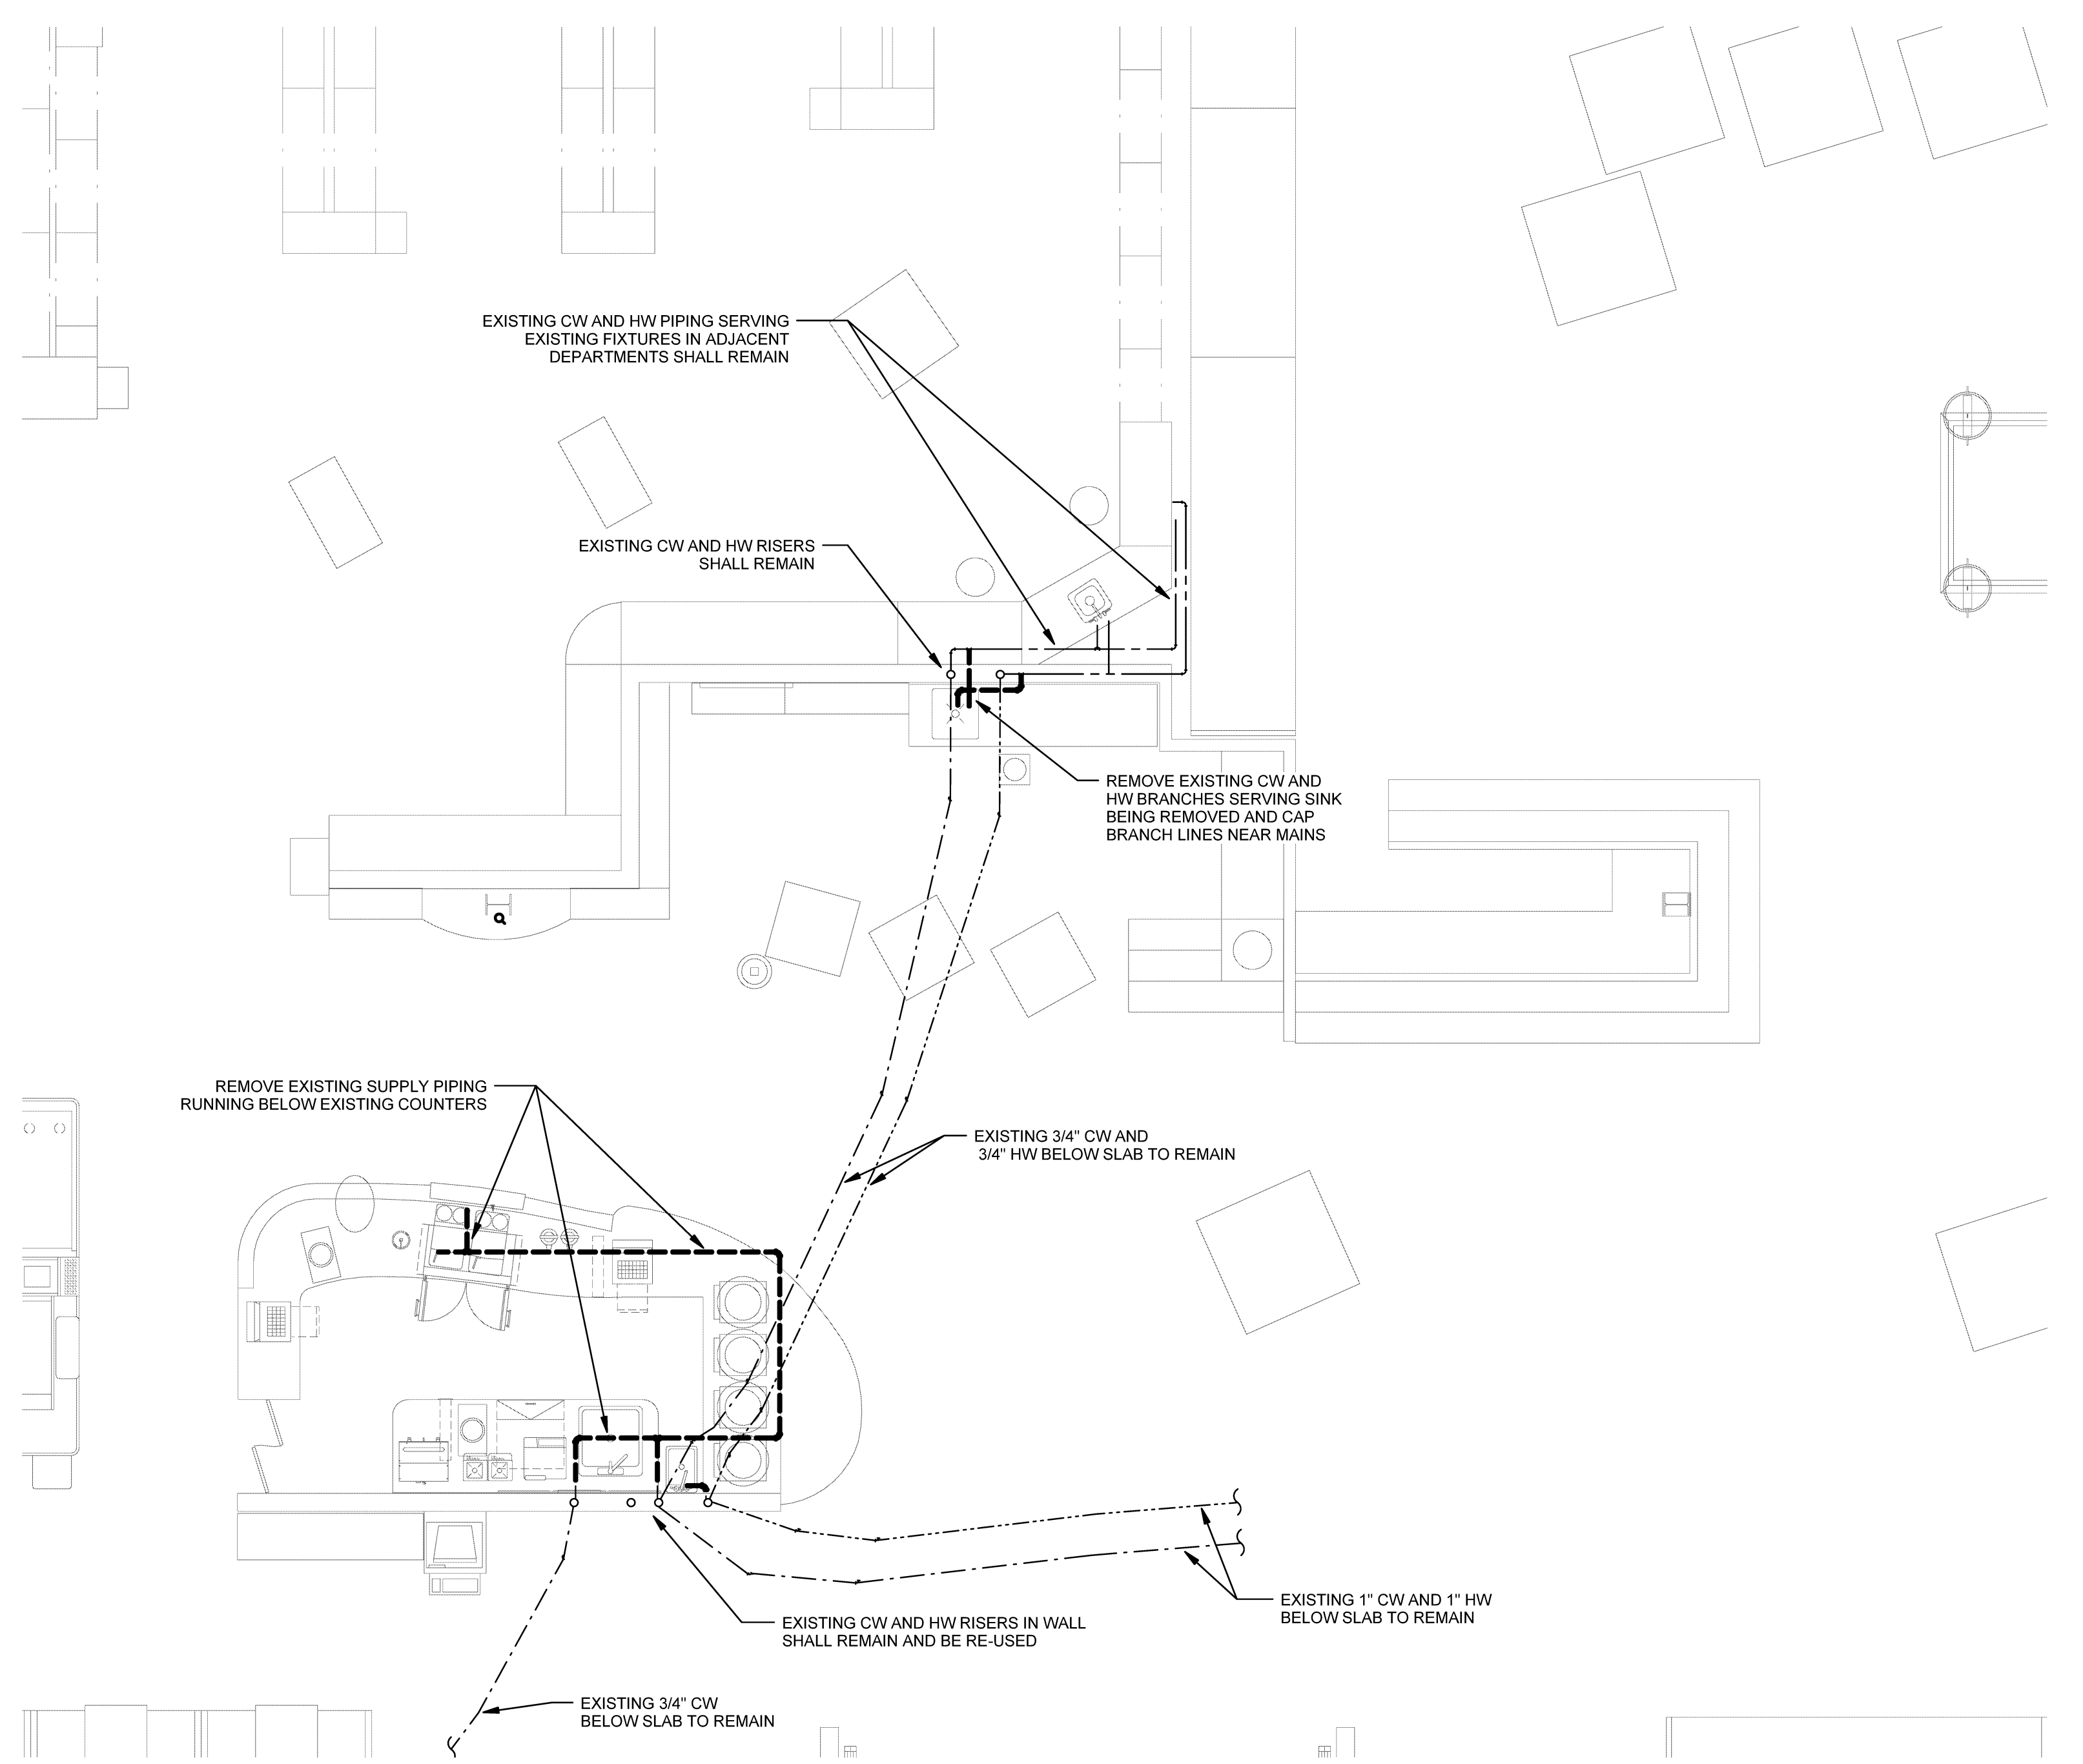


4 DEMOLITION SUPPLY PLAN
SCALE: 1/4" = 1'-0"

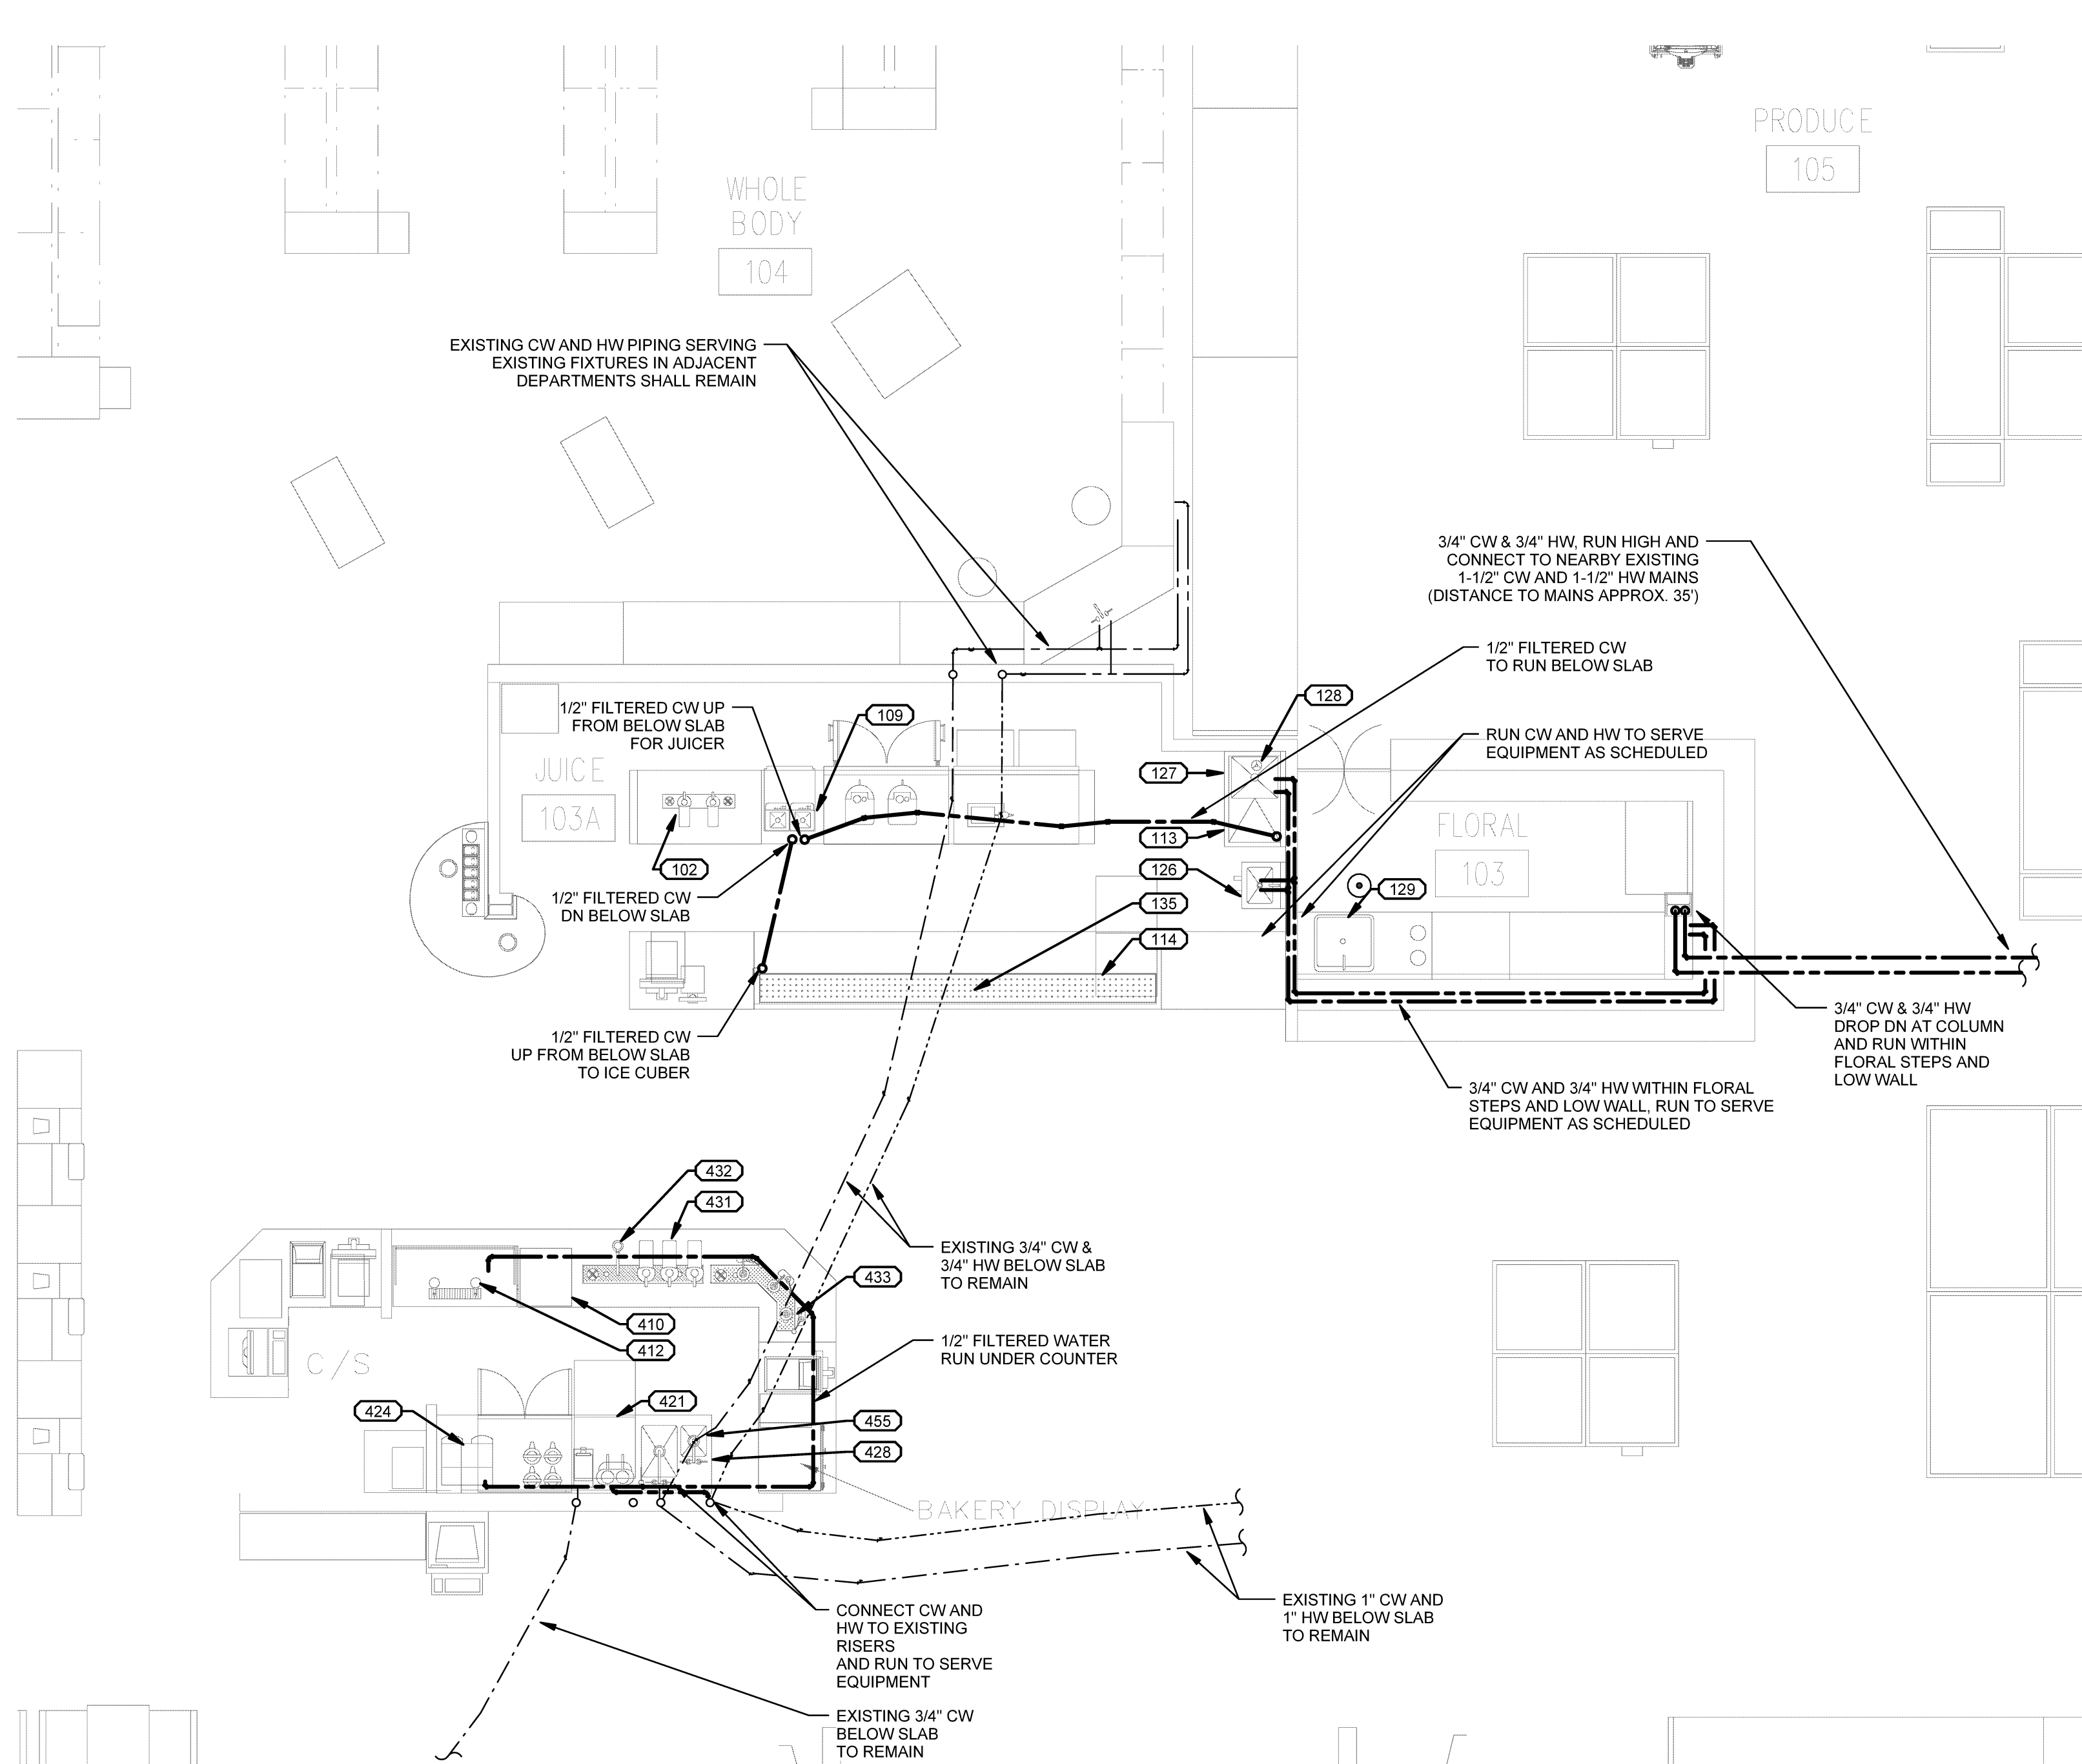

2 JUICE SUPPLY PART-PLAN
SCALE: 1/4" = 1'-0"


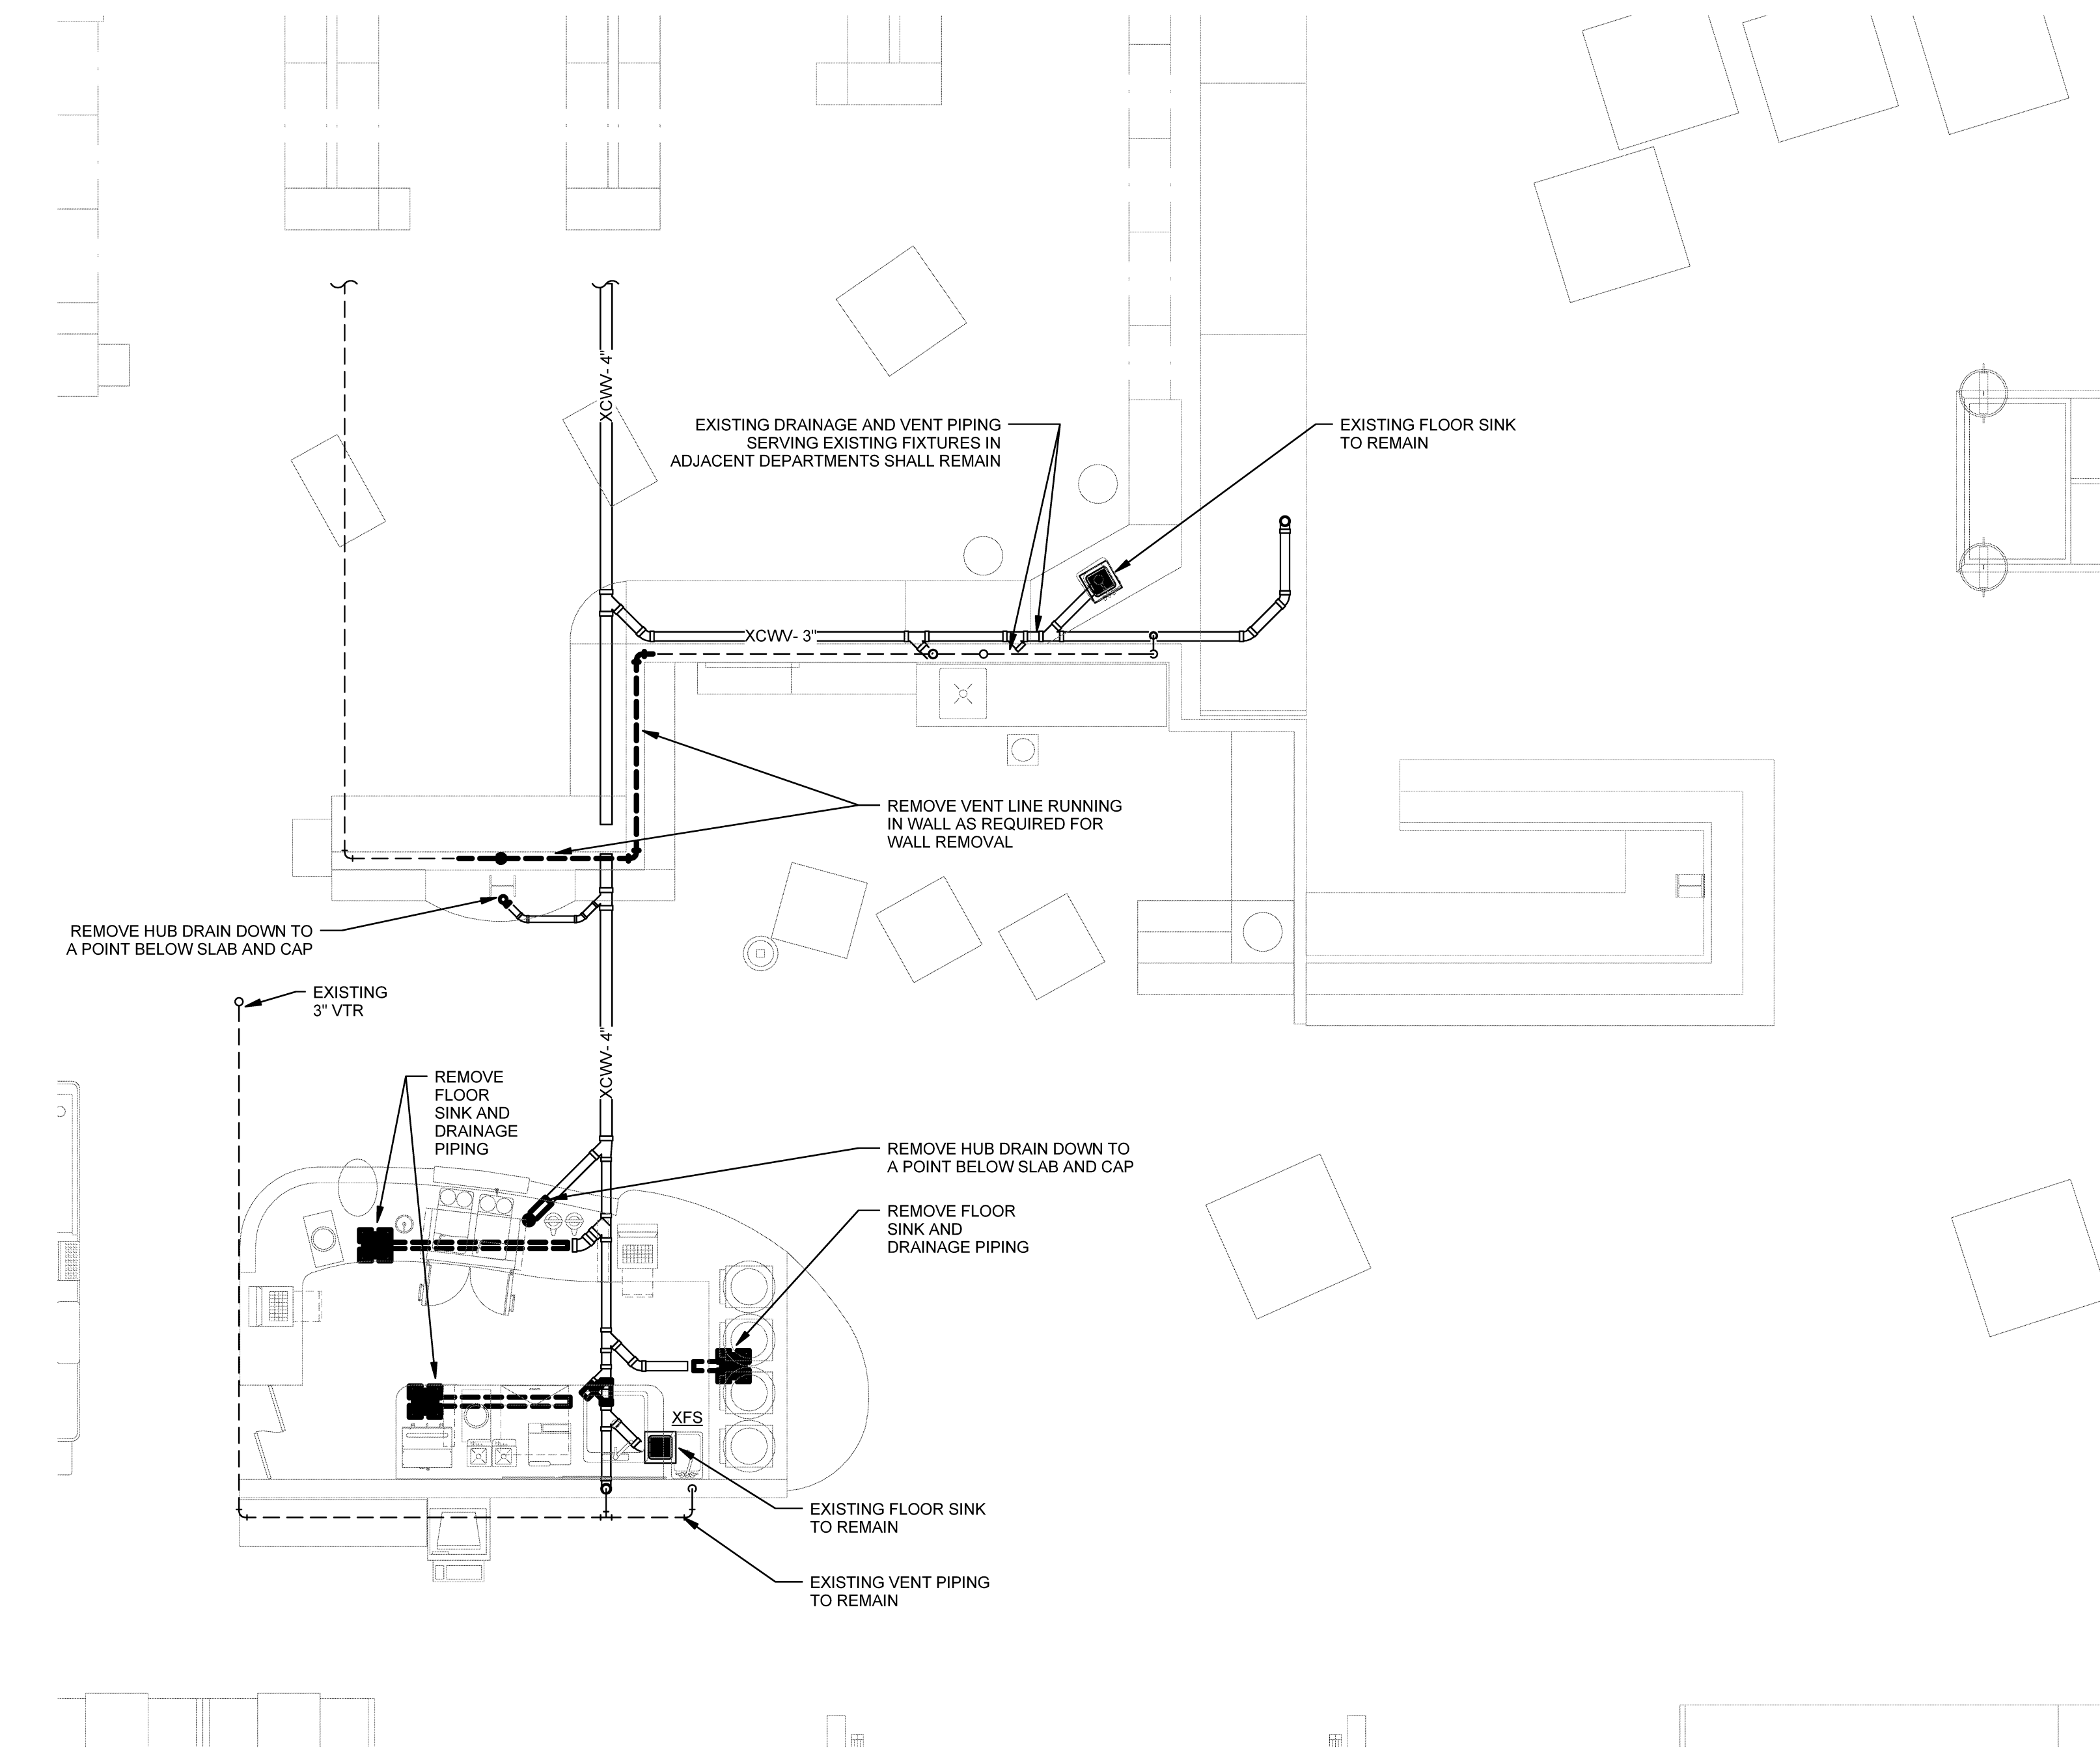


3 DEMOLITION DRAINAGE PLAN
SCALE: 1/4" = 1'-0"

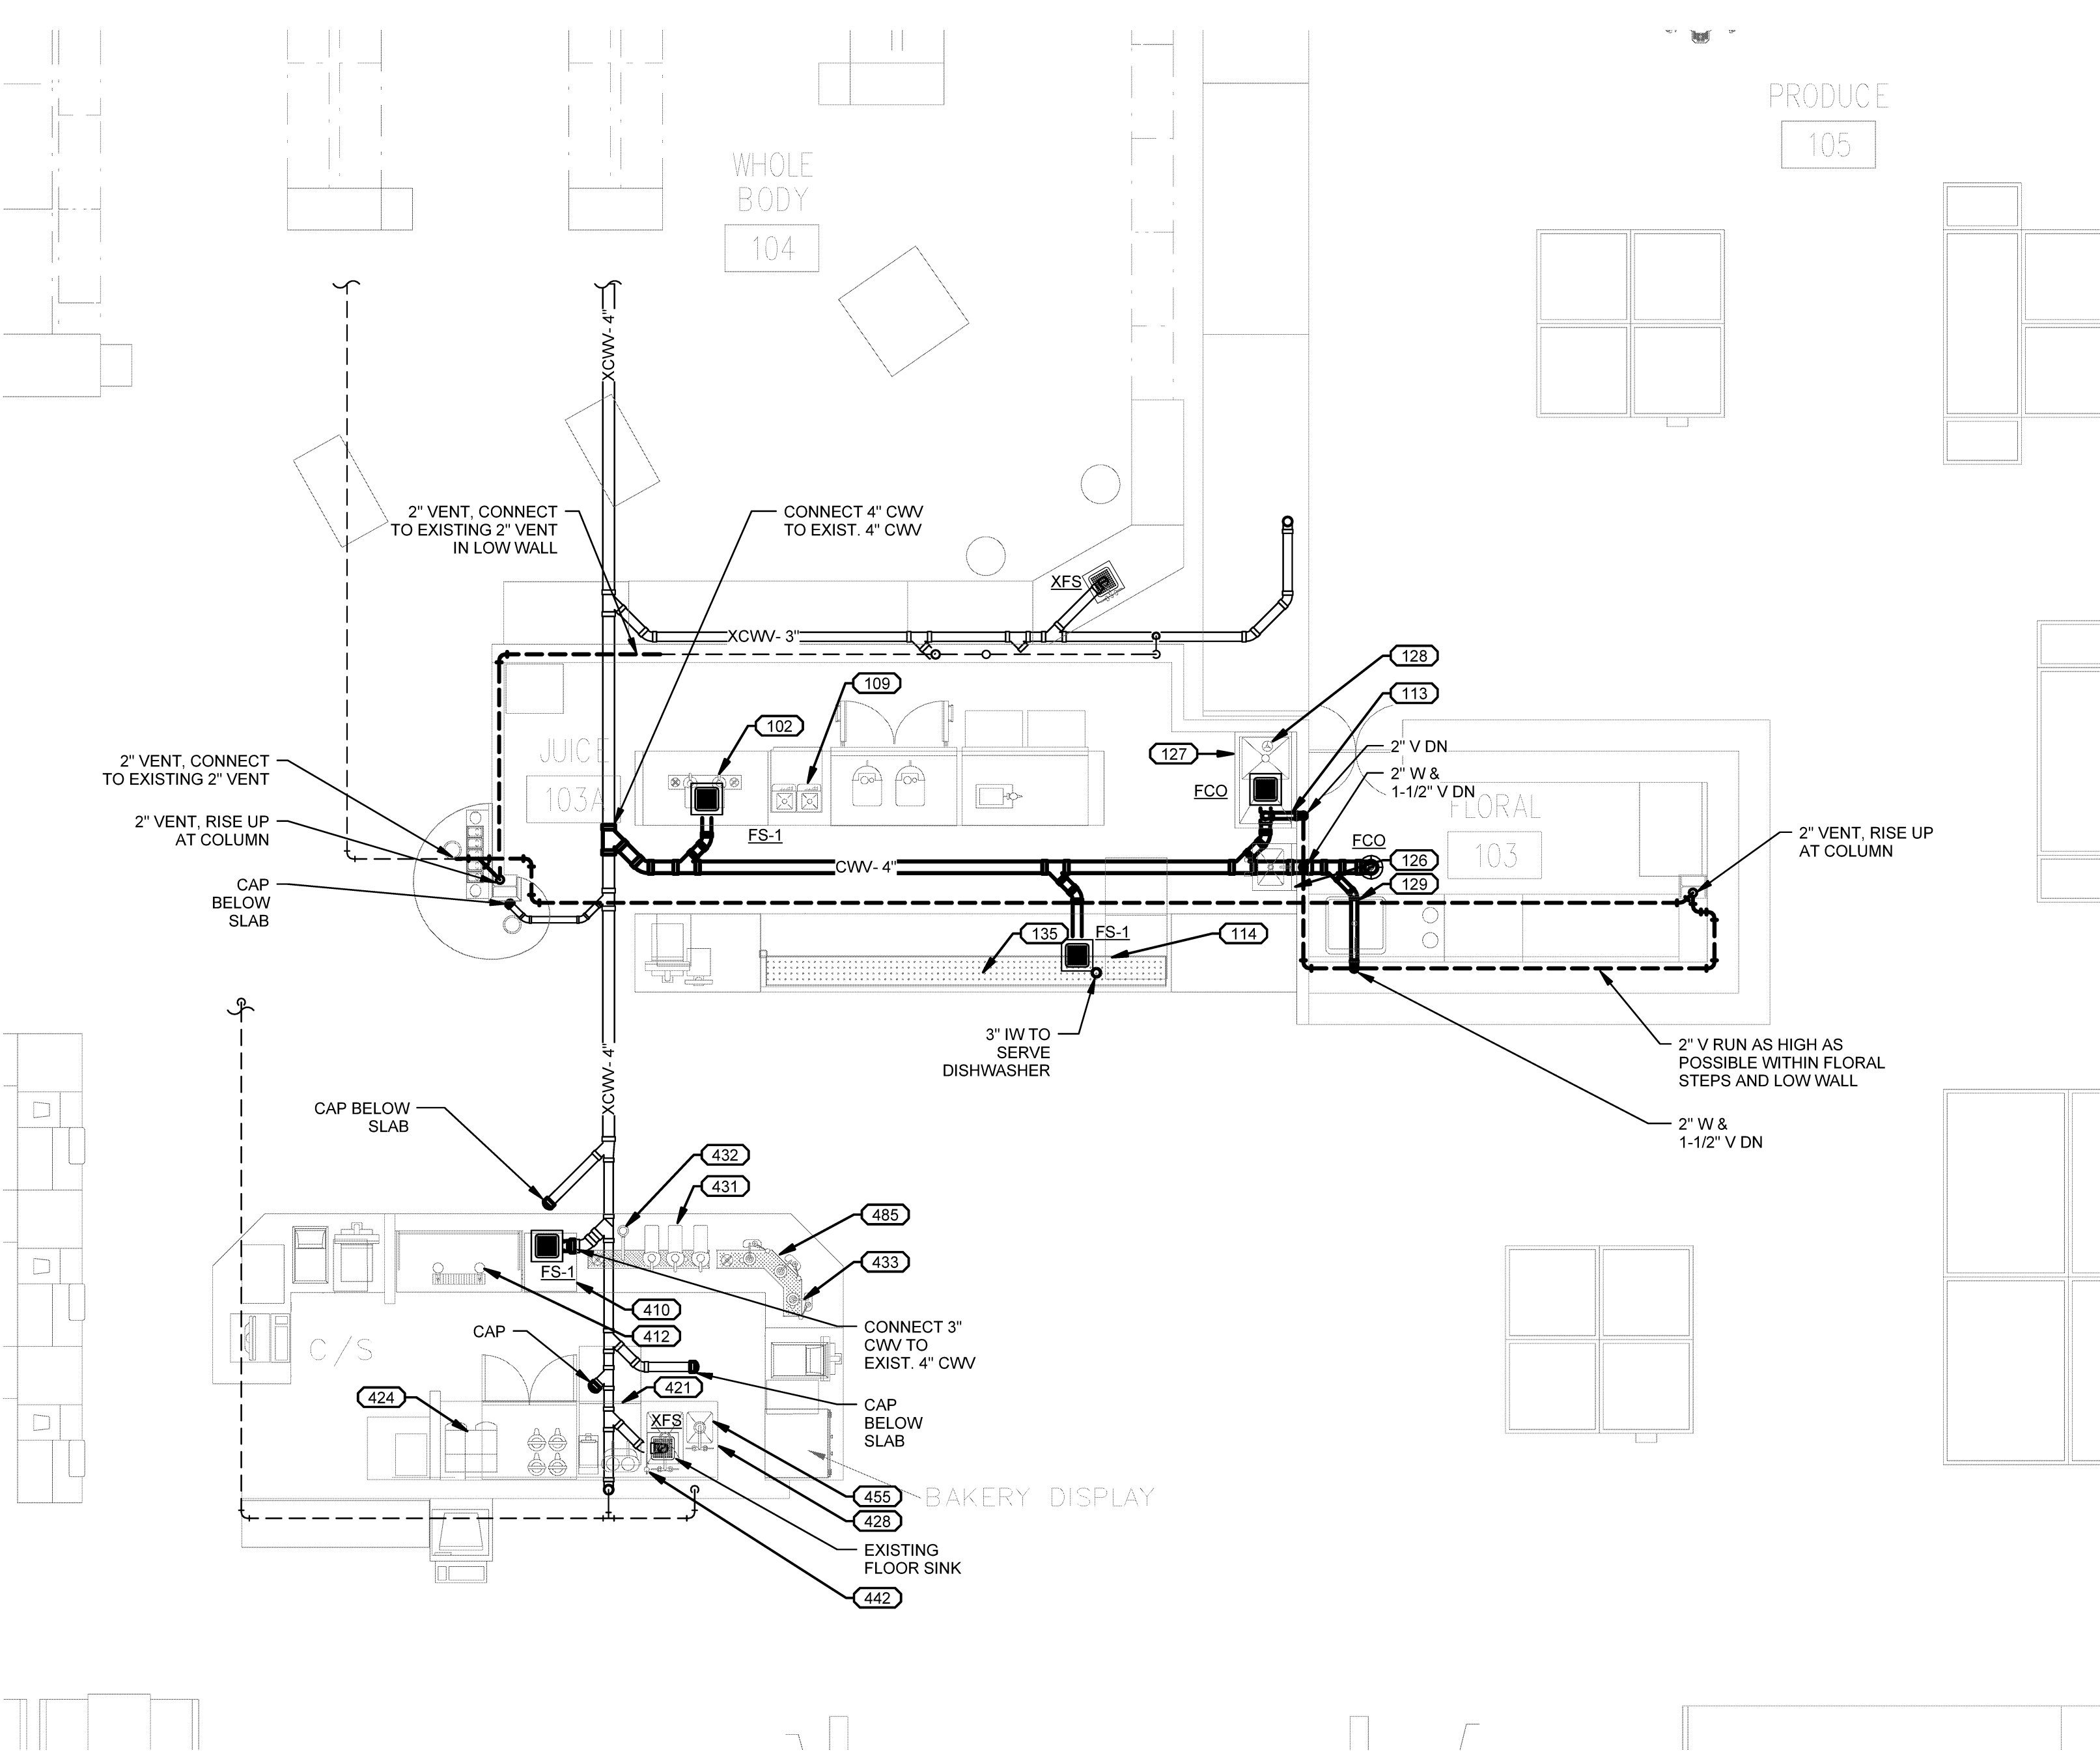

1 JUICE DRAINAGE PART-PLAN
SCALE: 1/4" = 1'-0"

Issues and Revisions		
Mark	Date	Description
-	09-08-15	ISSUED FOR PERMITTING
-	10-08-15	CONSTRUCTION DOCUMENTS

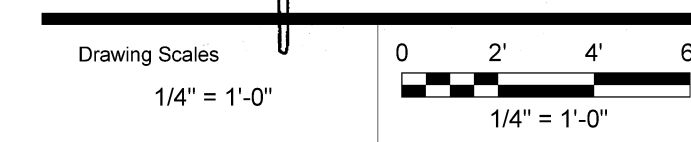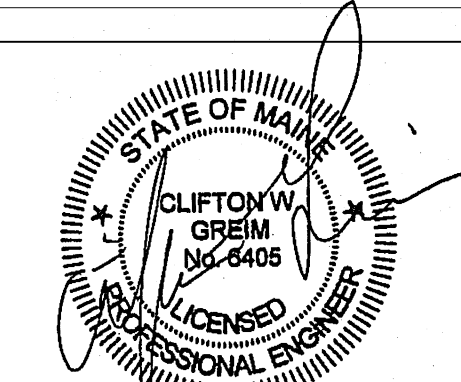

PA/PE: CG © 2015
Drawn By: PSM Harriman Associates

JUICE AREA PLUMBING PLANS

P10.2

Plot Date: 10/08/2015 10:38:29 AM