

HARRIMAN

AUBURN PORTLAND MANCHESTER




PUB DEVELOPMENT AND DEPARTMENT RELOCATIONS
2 SOMERSET ST
PORTLAND, ME


Harriman Project No. 15103

Key Plan


Plot North

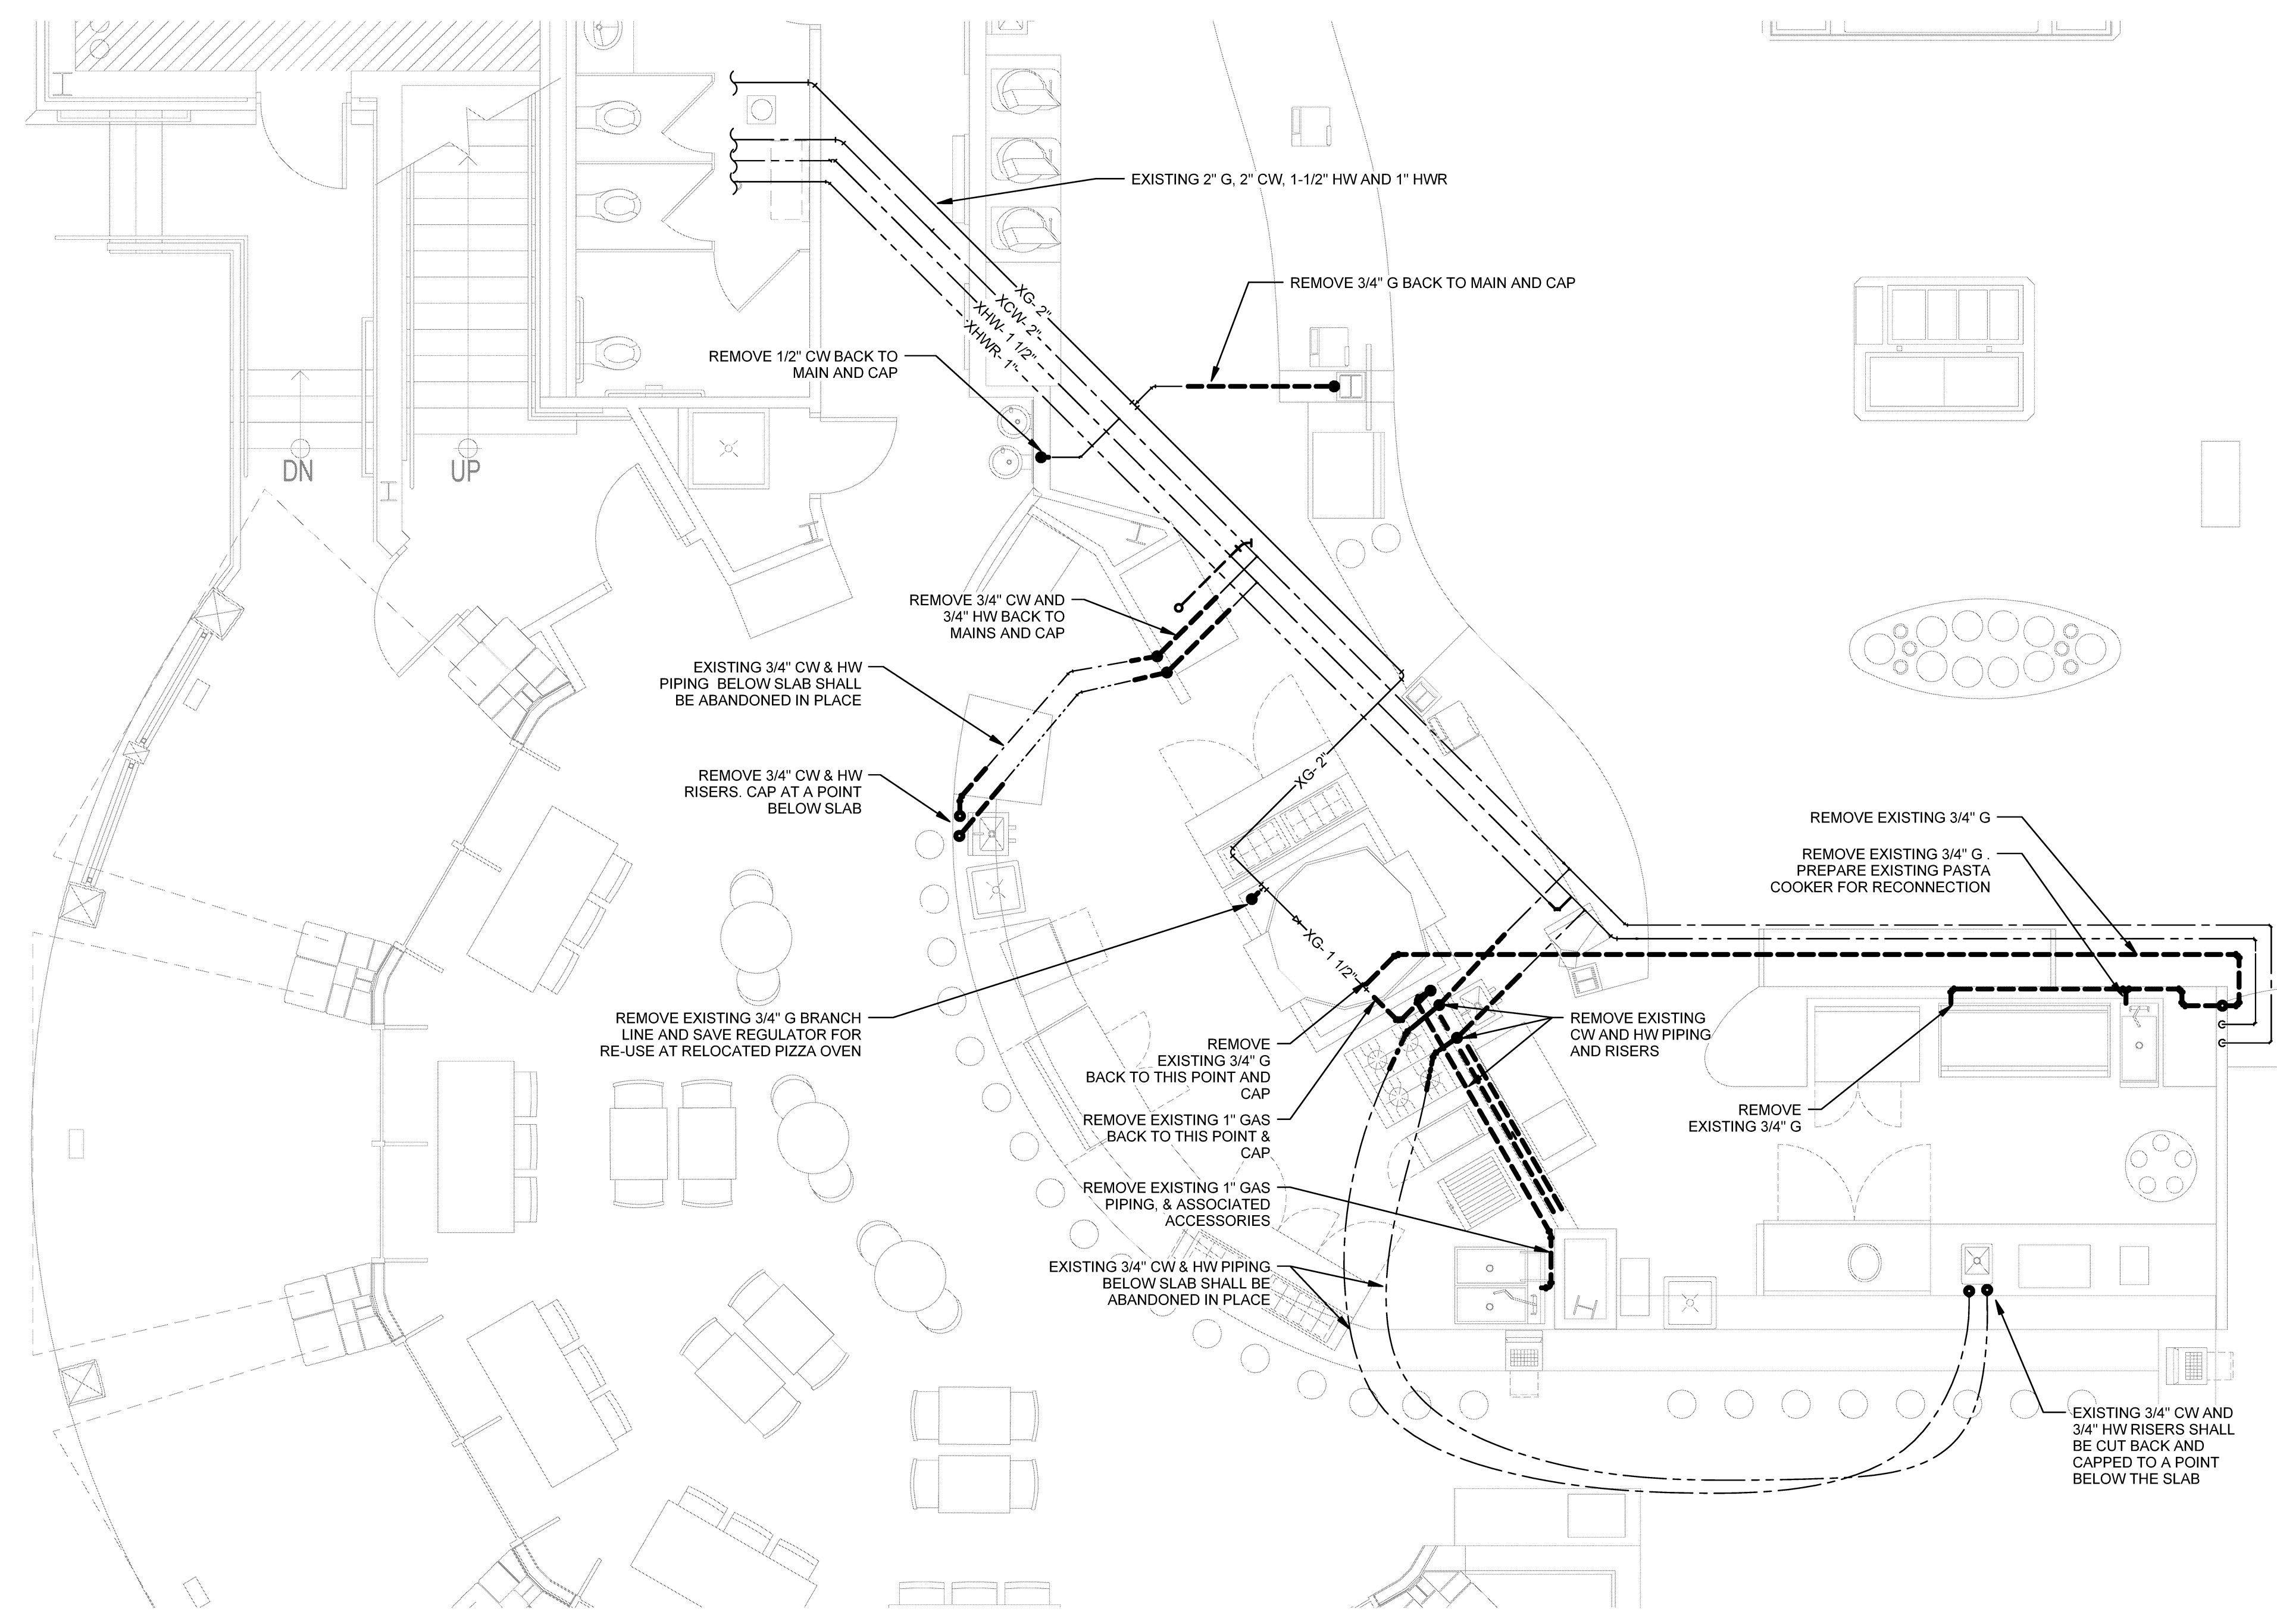


4 DEMOLITION SUPPLY PLAN
SCALE: 1/4" = 1'-0"

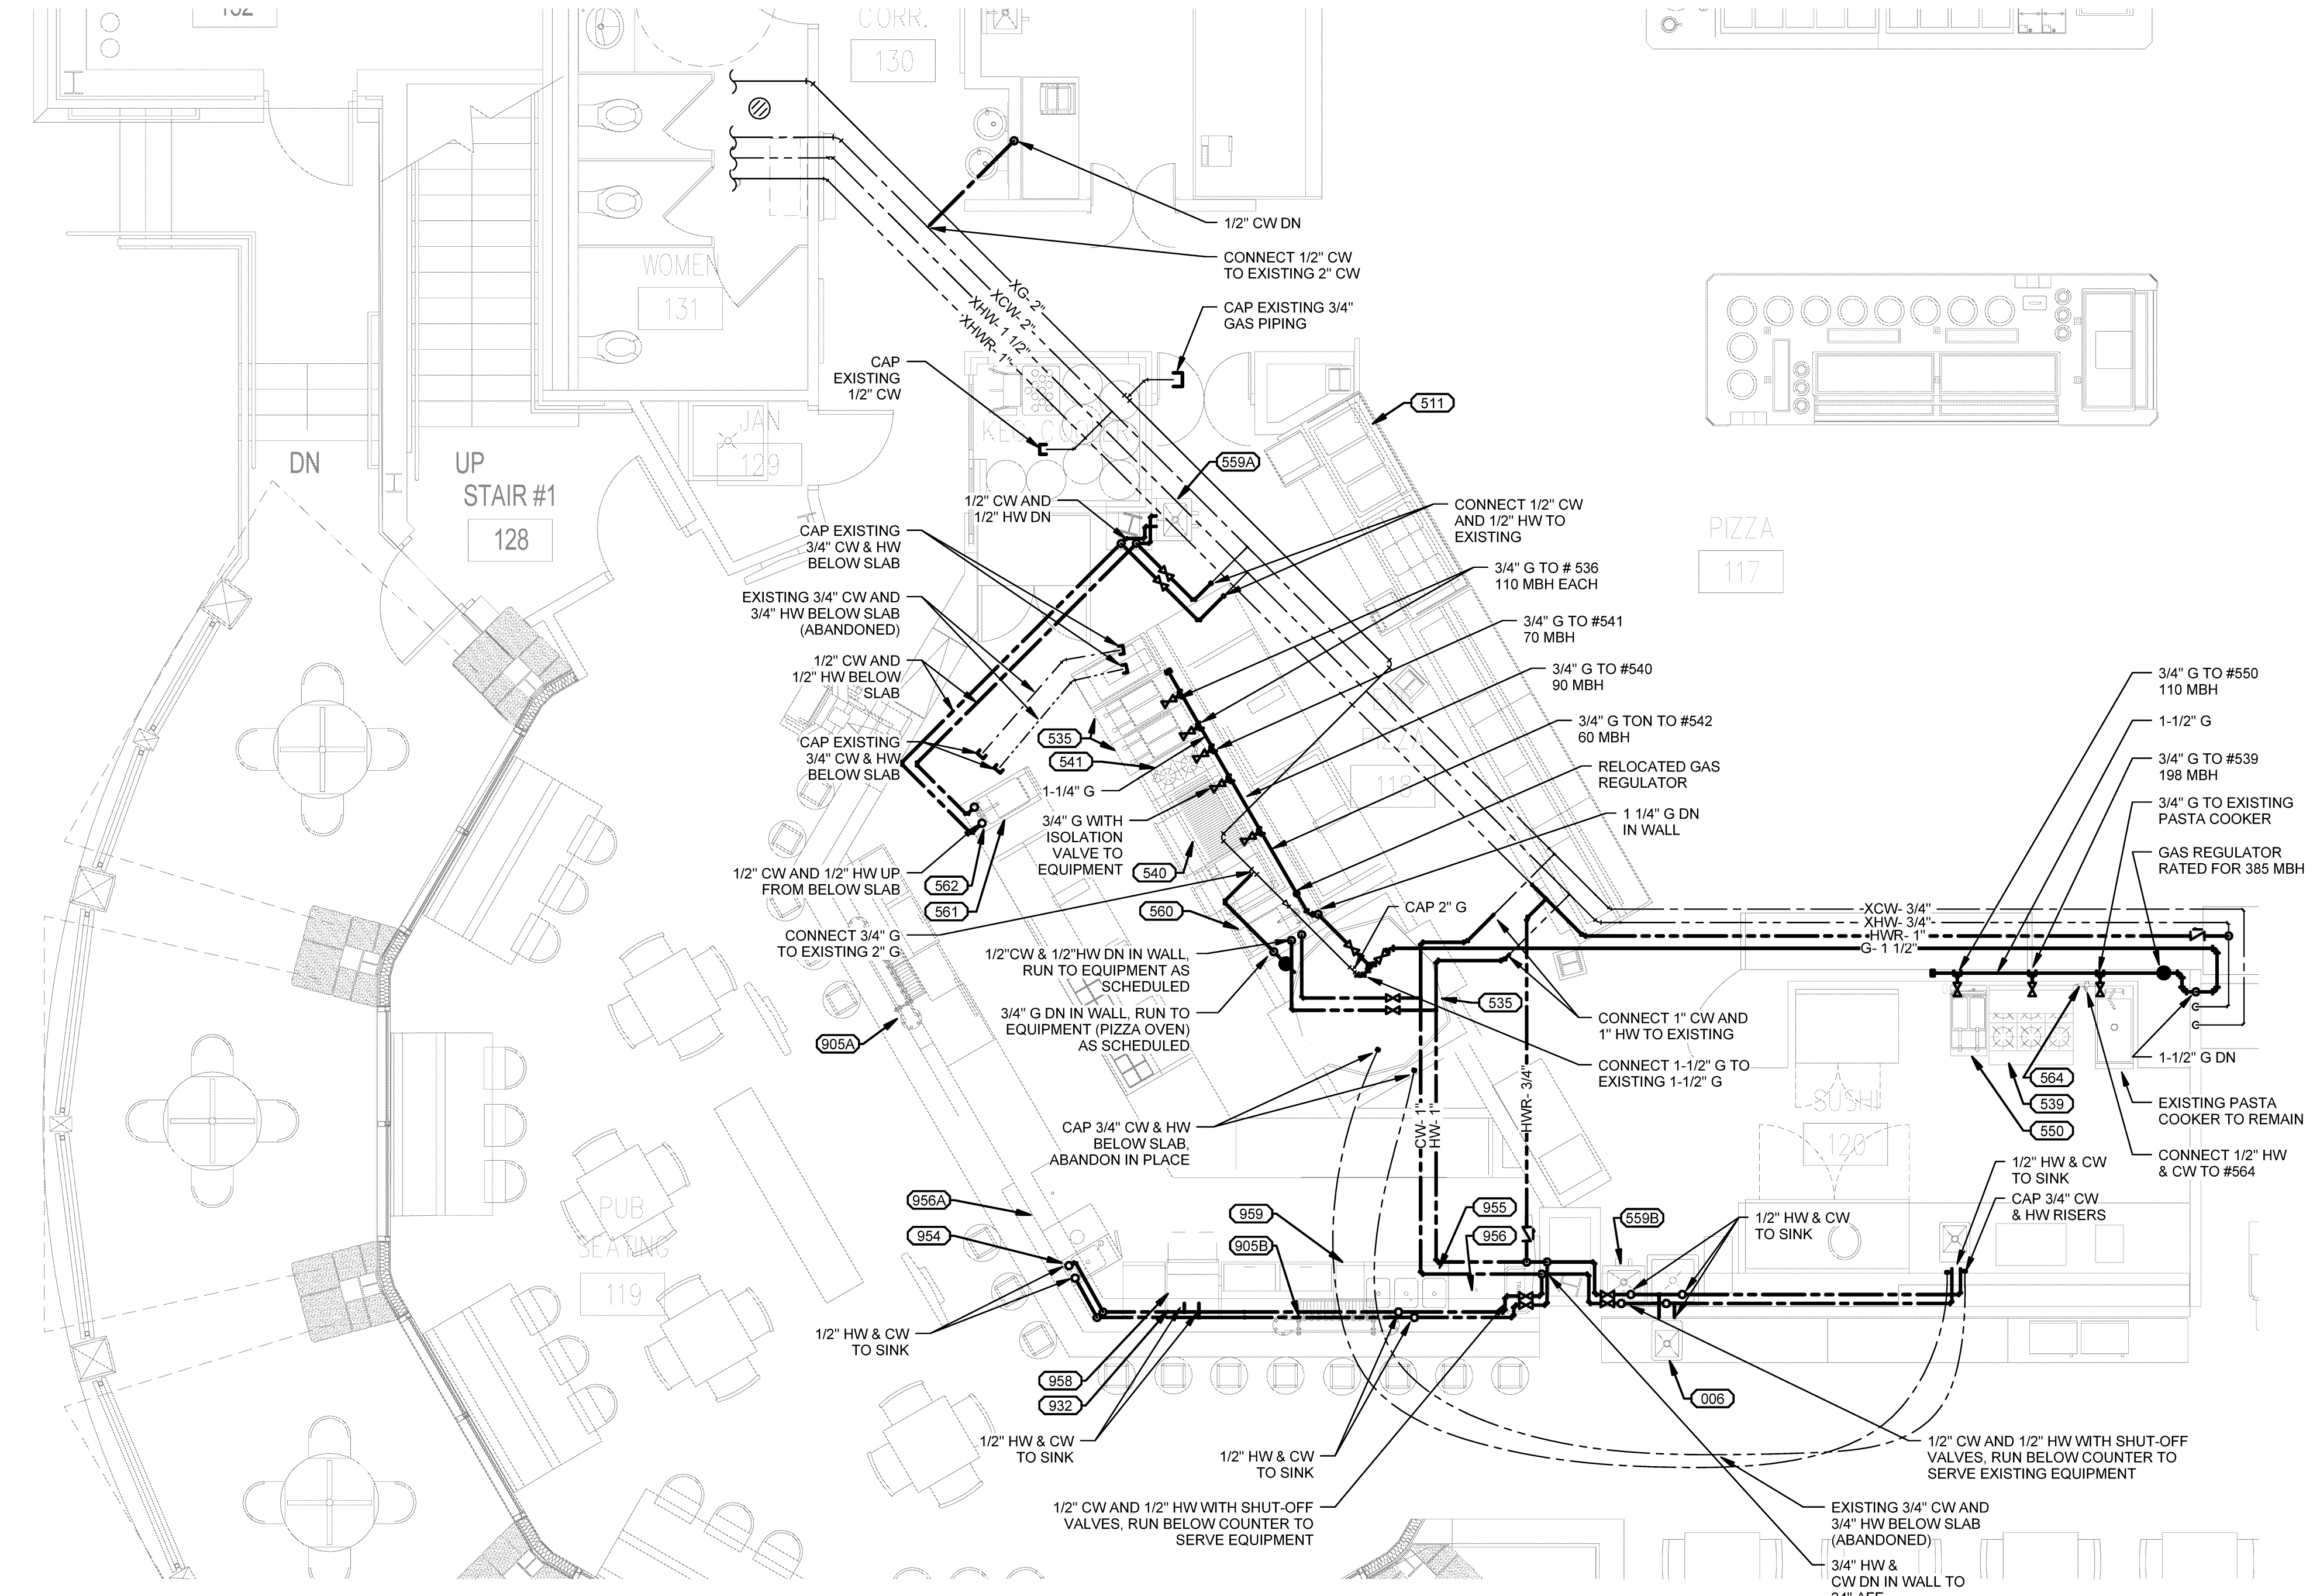

2 PUB SUPPLY PART-PLAN
SCALE: 1/4" = 1'-0"

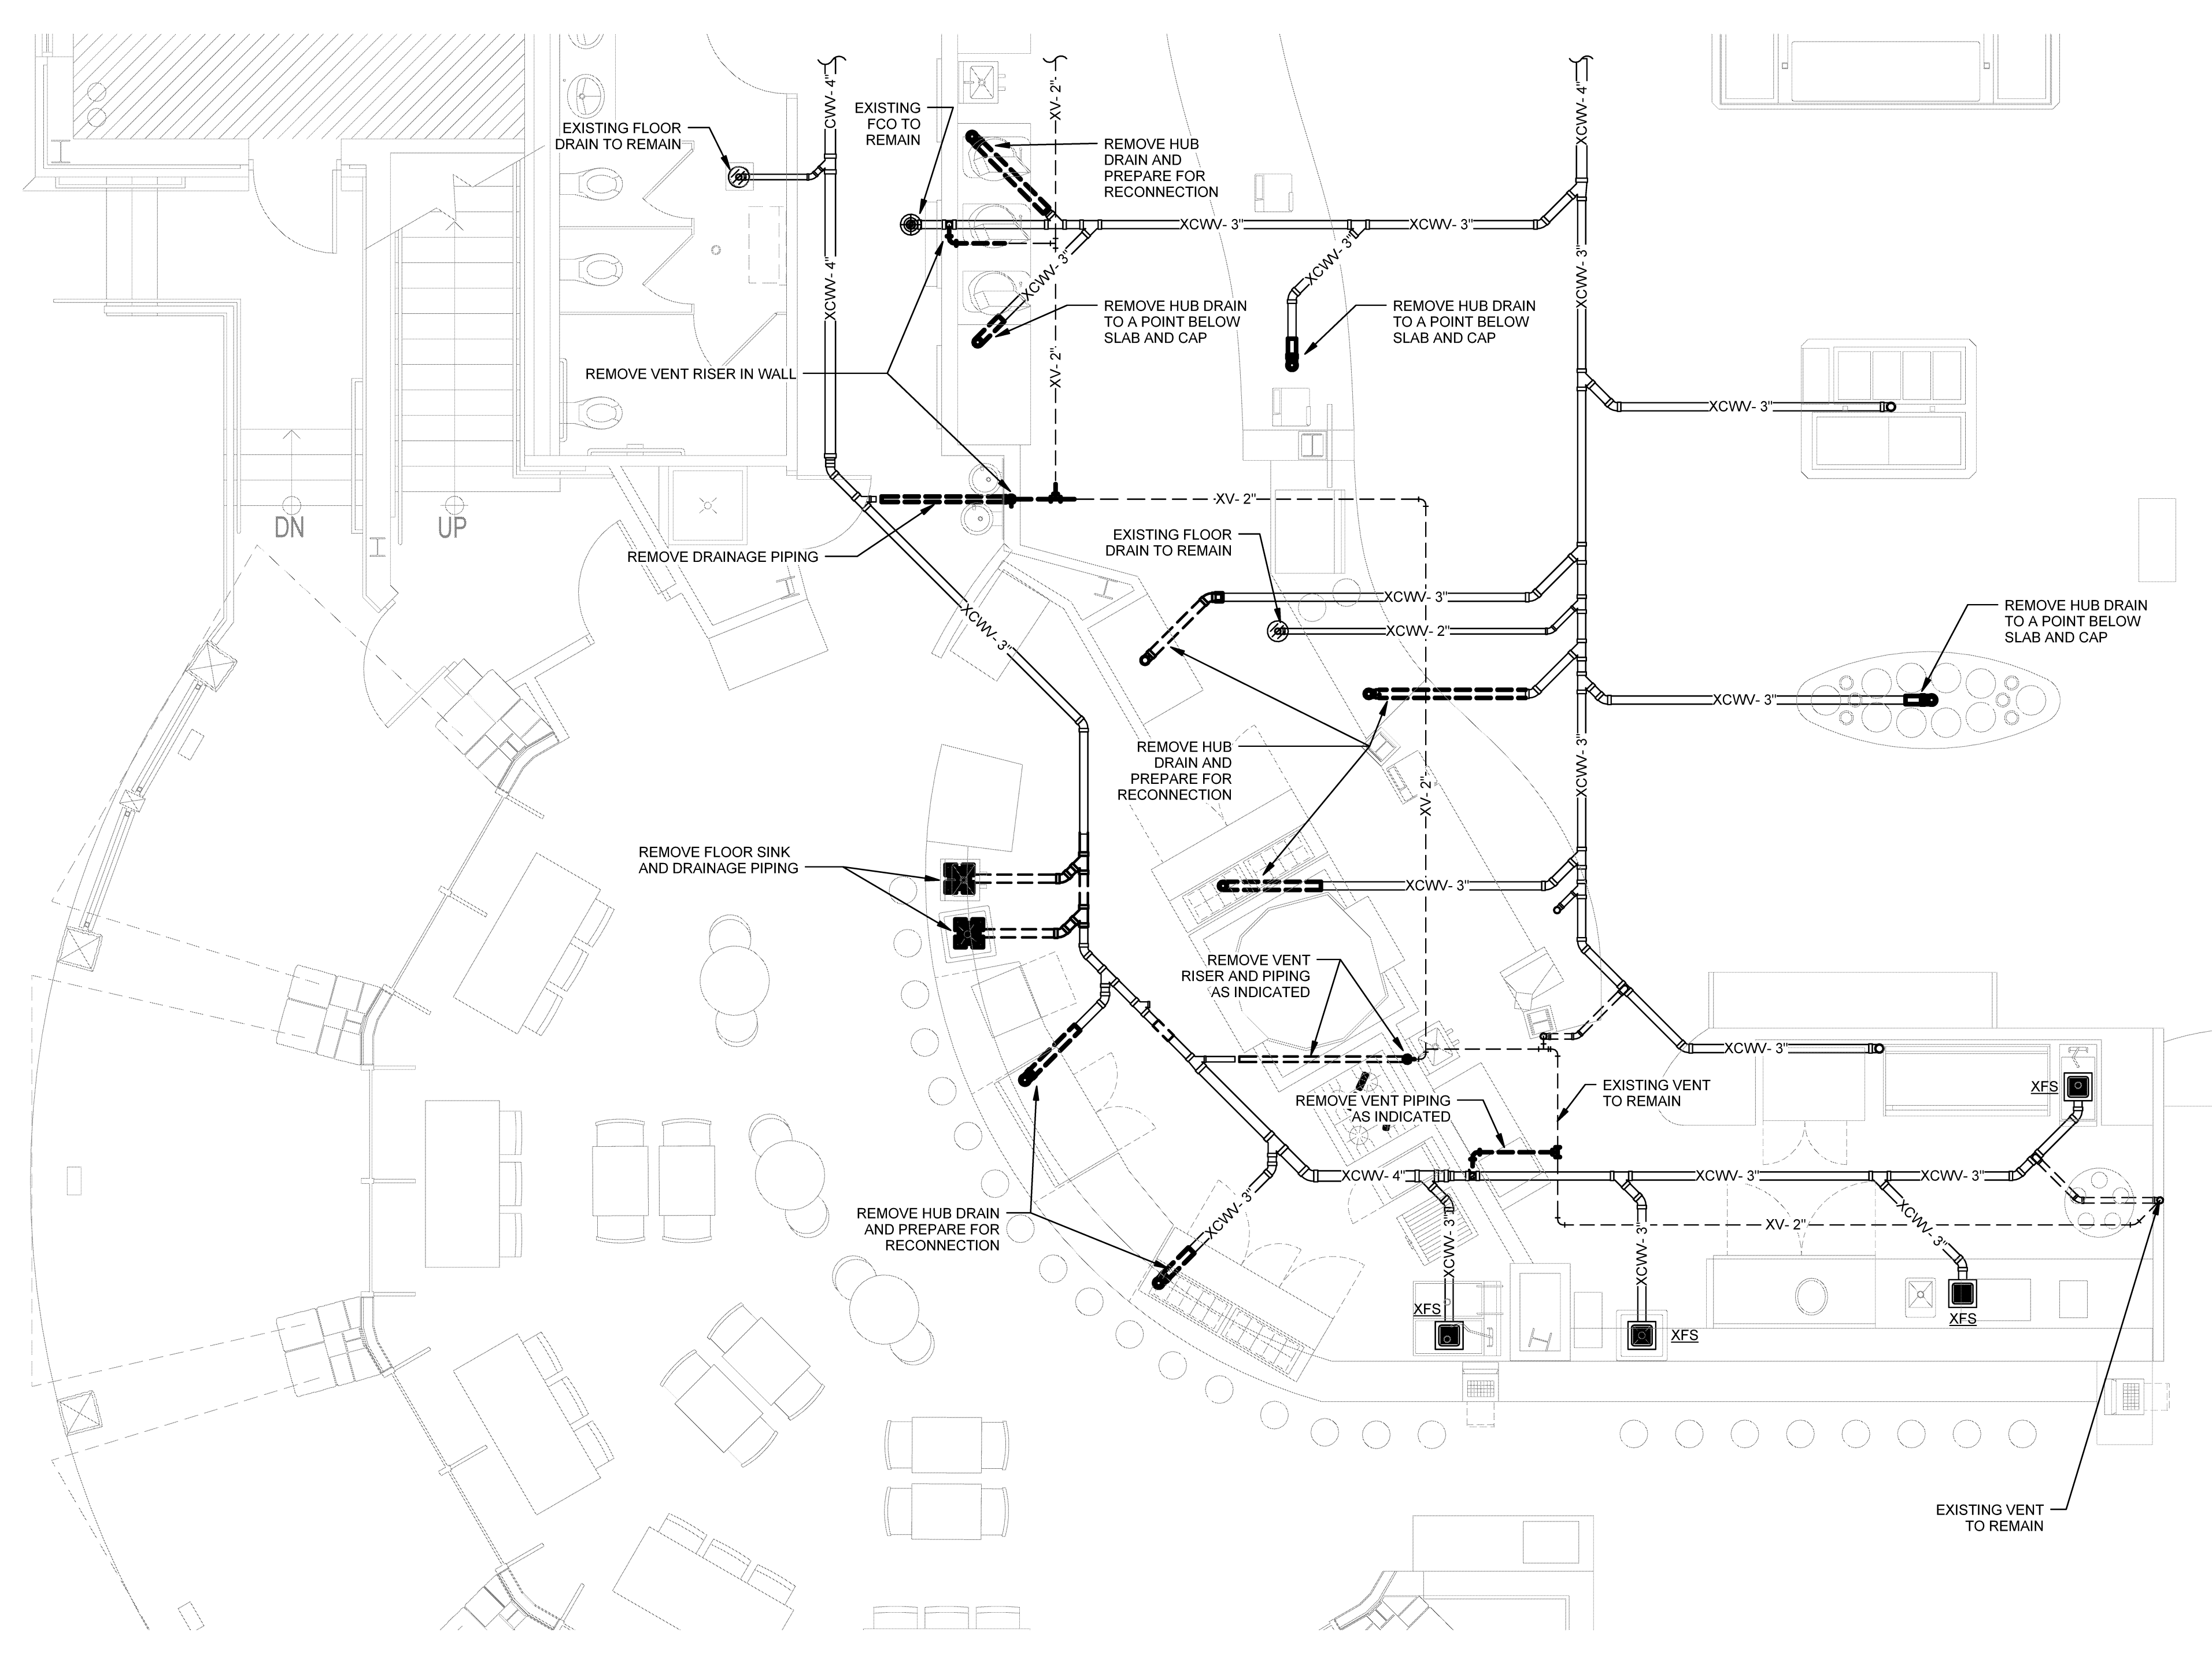


3 DEMOLITION DRAINAGE PLAN
SCALE: 1/4" = 1'-0"

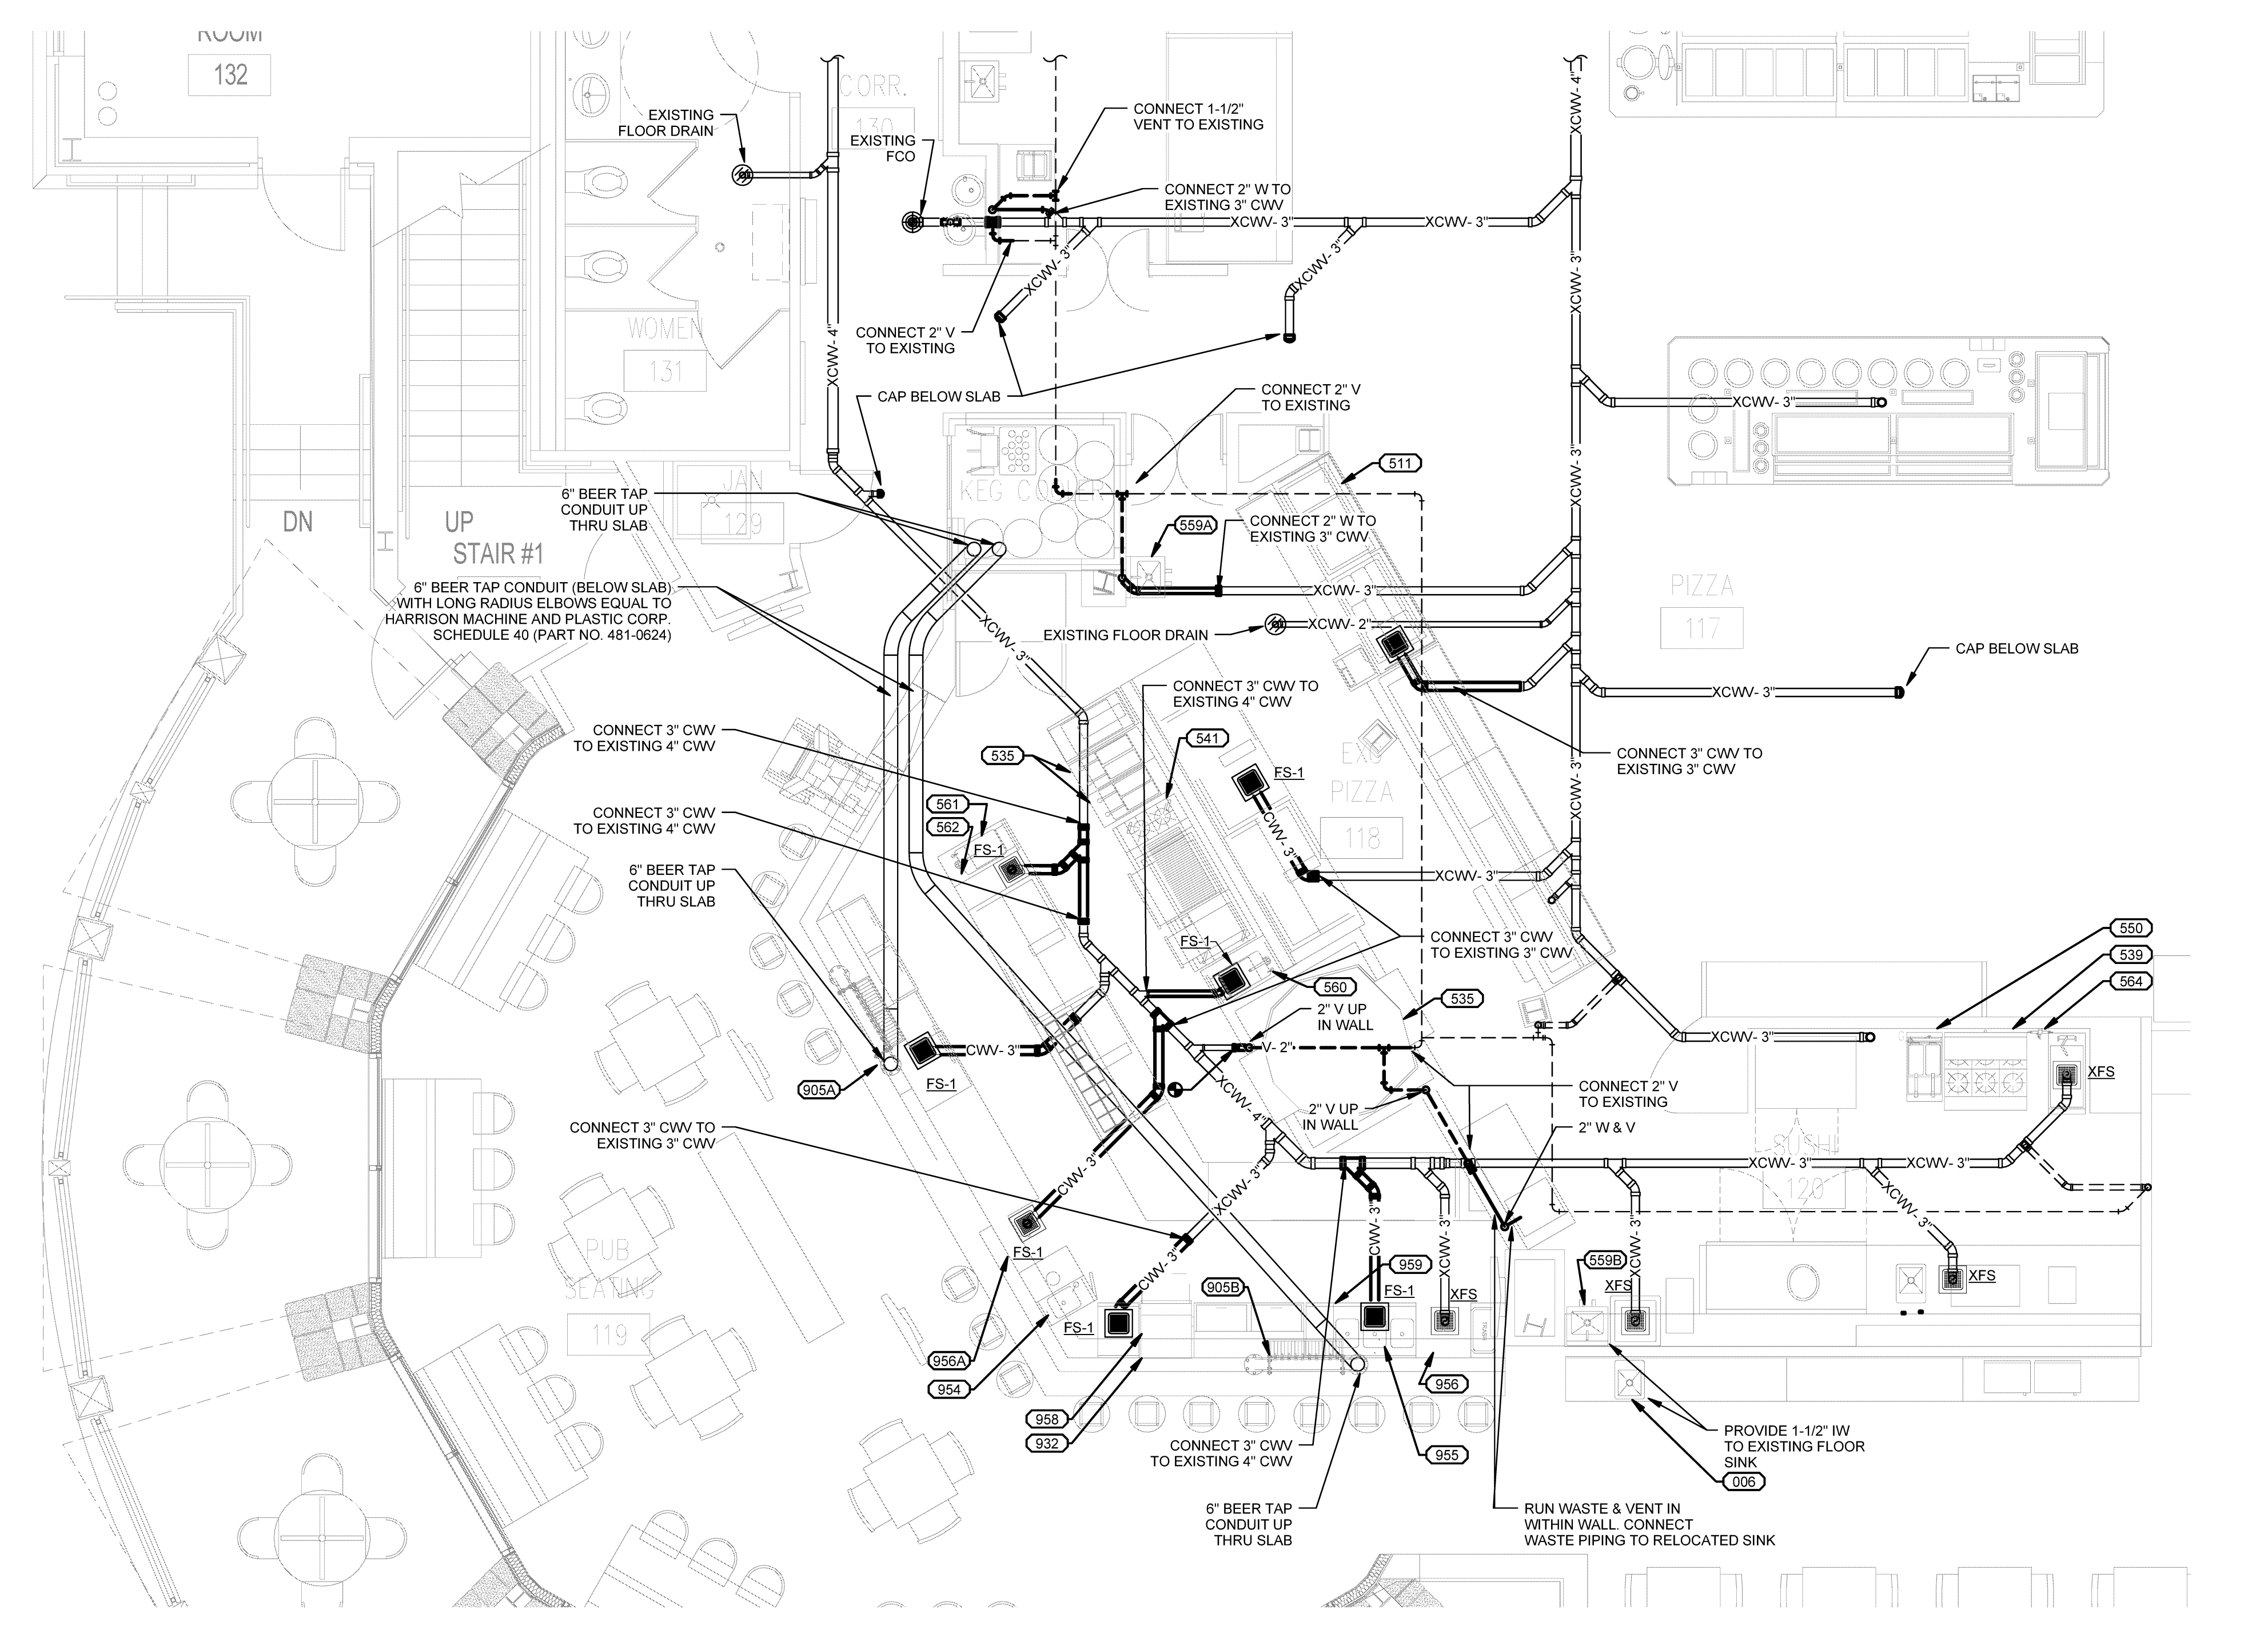

1 PUB DRAINAGE PART-PLAN
SCALE: 1/4" = 1'-0"

Mark	Date	Description
-	09-08-15	ISSUED FOR PERMITTING
-	10-08-15	CONSTRUCTION DOCUMENTS

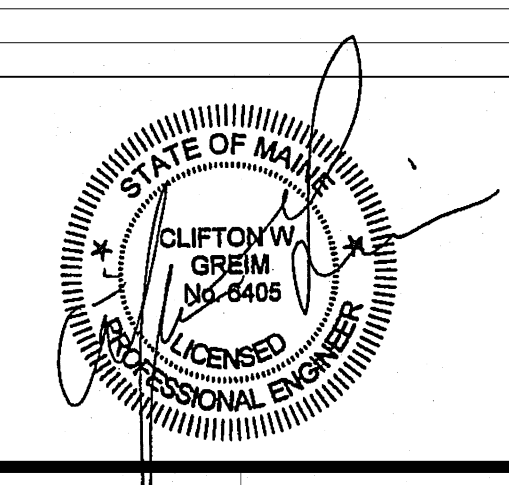

Drawing Scale: 1/4" = 1'-0"

PA/PE: CG © 2015
Drawn by: PSM Harriman Associates

PUB AREA PLUMBING PLANS

P10.1

Plot Date: 10/20/2015 10:24:50 AM