

NOTE:

- 1) PROPOSED BUILDING IS SHOWN FOR COORDINATION PURPOSES ONLY. CONTRACTOR TO REFER TO ARCHITECTURAL PLANS PREPARED BY THE ARCHITECT OF RECORD FOR EXACT DIMENSIONS.
- 2) LIGHT FIXTURE ELECTRICAL CIRCUIT BE UNMETERED PER CMP/CITY REQUIREMENT.
- 3) CONTRACTOR TO REFER TO AND COORDINATE WITH MECHANICAL, ELECTRICAL AND PLUMBING PLANS. CONTRACTOR TO COORDINATE ALL UTILITIES WITH APPLICABLE UTILITY SERVICE PROVIDERS, CITY OF PORTLAND, AND THEIR STANDARDS & SPECIFICATIONS.
- 4) CONTRACTOR SHALL PROVIDE LIGHT POLE BASES (SEE DETAIL) AND LIGHT POLES TO MATCH THE COLOR, SIZE, HEIGHT, AND STYLE OF THE EXISTING POLES ON CHESTNUT STREET, AND MAKE A SUBMITTAL FOR THE ENGINEER'S REVIEW AND ACCEPTANCE PRIOR TO ORDERING THE BASES AND POLES. CONTRACTOR SHALL PAY SERVICE CHARGES AND COORDINATE WITH CENTRAL MAINE POWER THE PROCUREMENT, INSTALLATION, AND POWERING OF HOLOPHANE ESU175MH004 ESPLANADE FIXTURES WITH MVR175/U - E-28 14000 LUMENS LAMP.

CONSTRUCTION MANAGER:
CONSIGLI
 84 Middle Street
 Portland, Maine 04101
 Phone 207-773-3000
 Fax 207-773-3000

PARKING GARAGE ARCHITECT:
SSI
 75 York Street
 Portland, Maine 04101
 Phone 207-773-4858
 Fax 207-628-4056

PARKING GARAGE STRUCTURAL ENGINEER:
BECKER
 75 York Street
 Portland, Maine 04101
 Phone 207-628-1828
 Fax 207-628-1828

SITE/CIVIL ENGINEER:
BAIRY & ASSOCIATES
 41 Middle Drive
 Portland, Maine 04102
 Phone 800-946-4282
 Fax 207-774-6835

HARRIMAN
 Architects + Engineers
 Auburn Business Park
 46 Elmwood Drive
 Auburn, Maine 04210
 207-784-5588 ext
 207-782-9817 fax
 123 Middle Street
 Portland, Maine 04101
 207-774-8800 ext
 207-774-8800 fax
 www.harriman.com
 © 2008

Project Title
**BAYCO LLC.
 BAYSIDE
 DEVELOPMENT**
 PORTLAND, MAINE

HA Project No.
 Key Plan

Professional Engineer Seal:
BAIRY & ASSOCIATES
 PROFESSIONAL ENGINEER
 STATE OF MAINE
 No. 10042
 JANUARY 7, 2009

Mark	Date	Description
1-7-09	100% SITE ENABLING PLAN	
12-19-08	90% SITE ENABLING PLAN	
11-21-08	PERMIT SUBMITTAL	
11-13-08	PERMIT SUBMITTAL	
10-24-08	PERMIT SUBMITTAL	
10-10-08	REVISE BLDG LAYOUT & ADD BUS DRDP	
09-26-08	PERMIT SUBMITTAL	


Drawing Status

--	--

Drawing Title
**UTILITY
 PLAN**

PA / PE: **BSS** Drawn By: **RJ/DV**

Drawing Number
C202

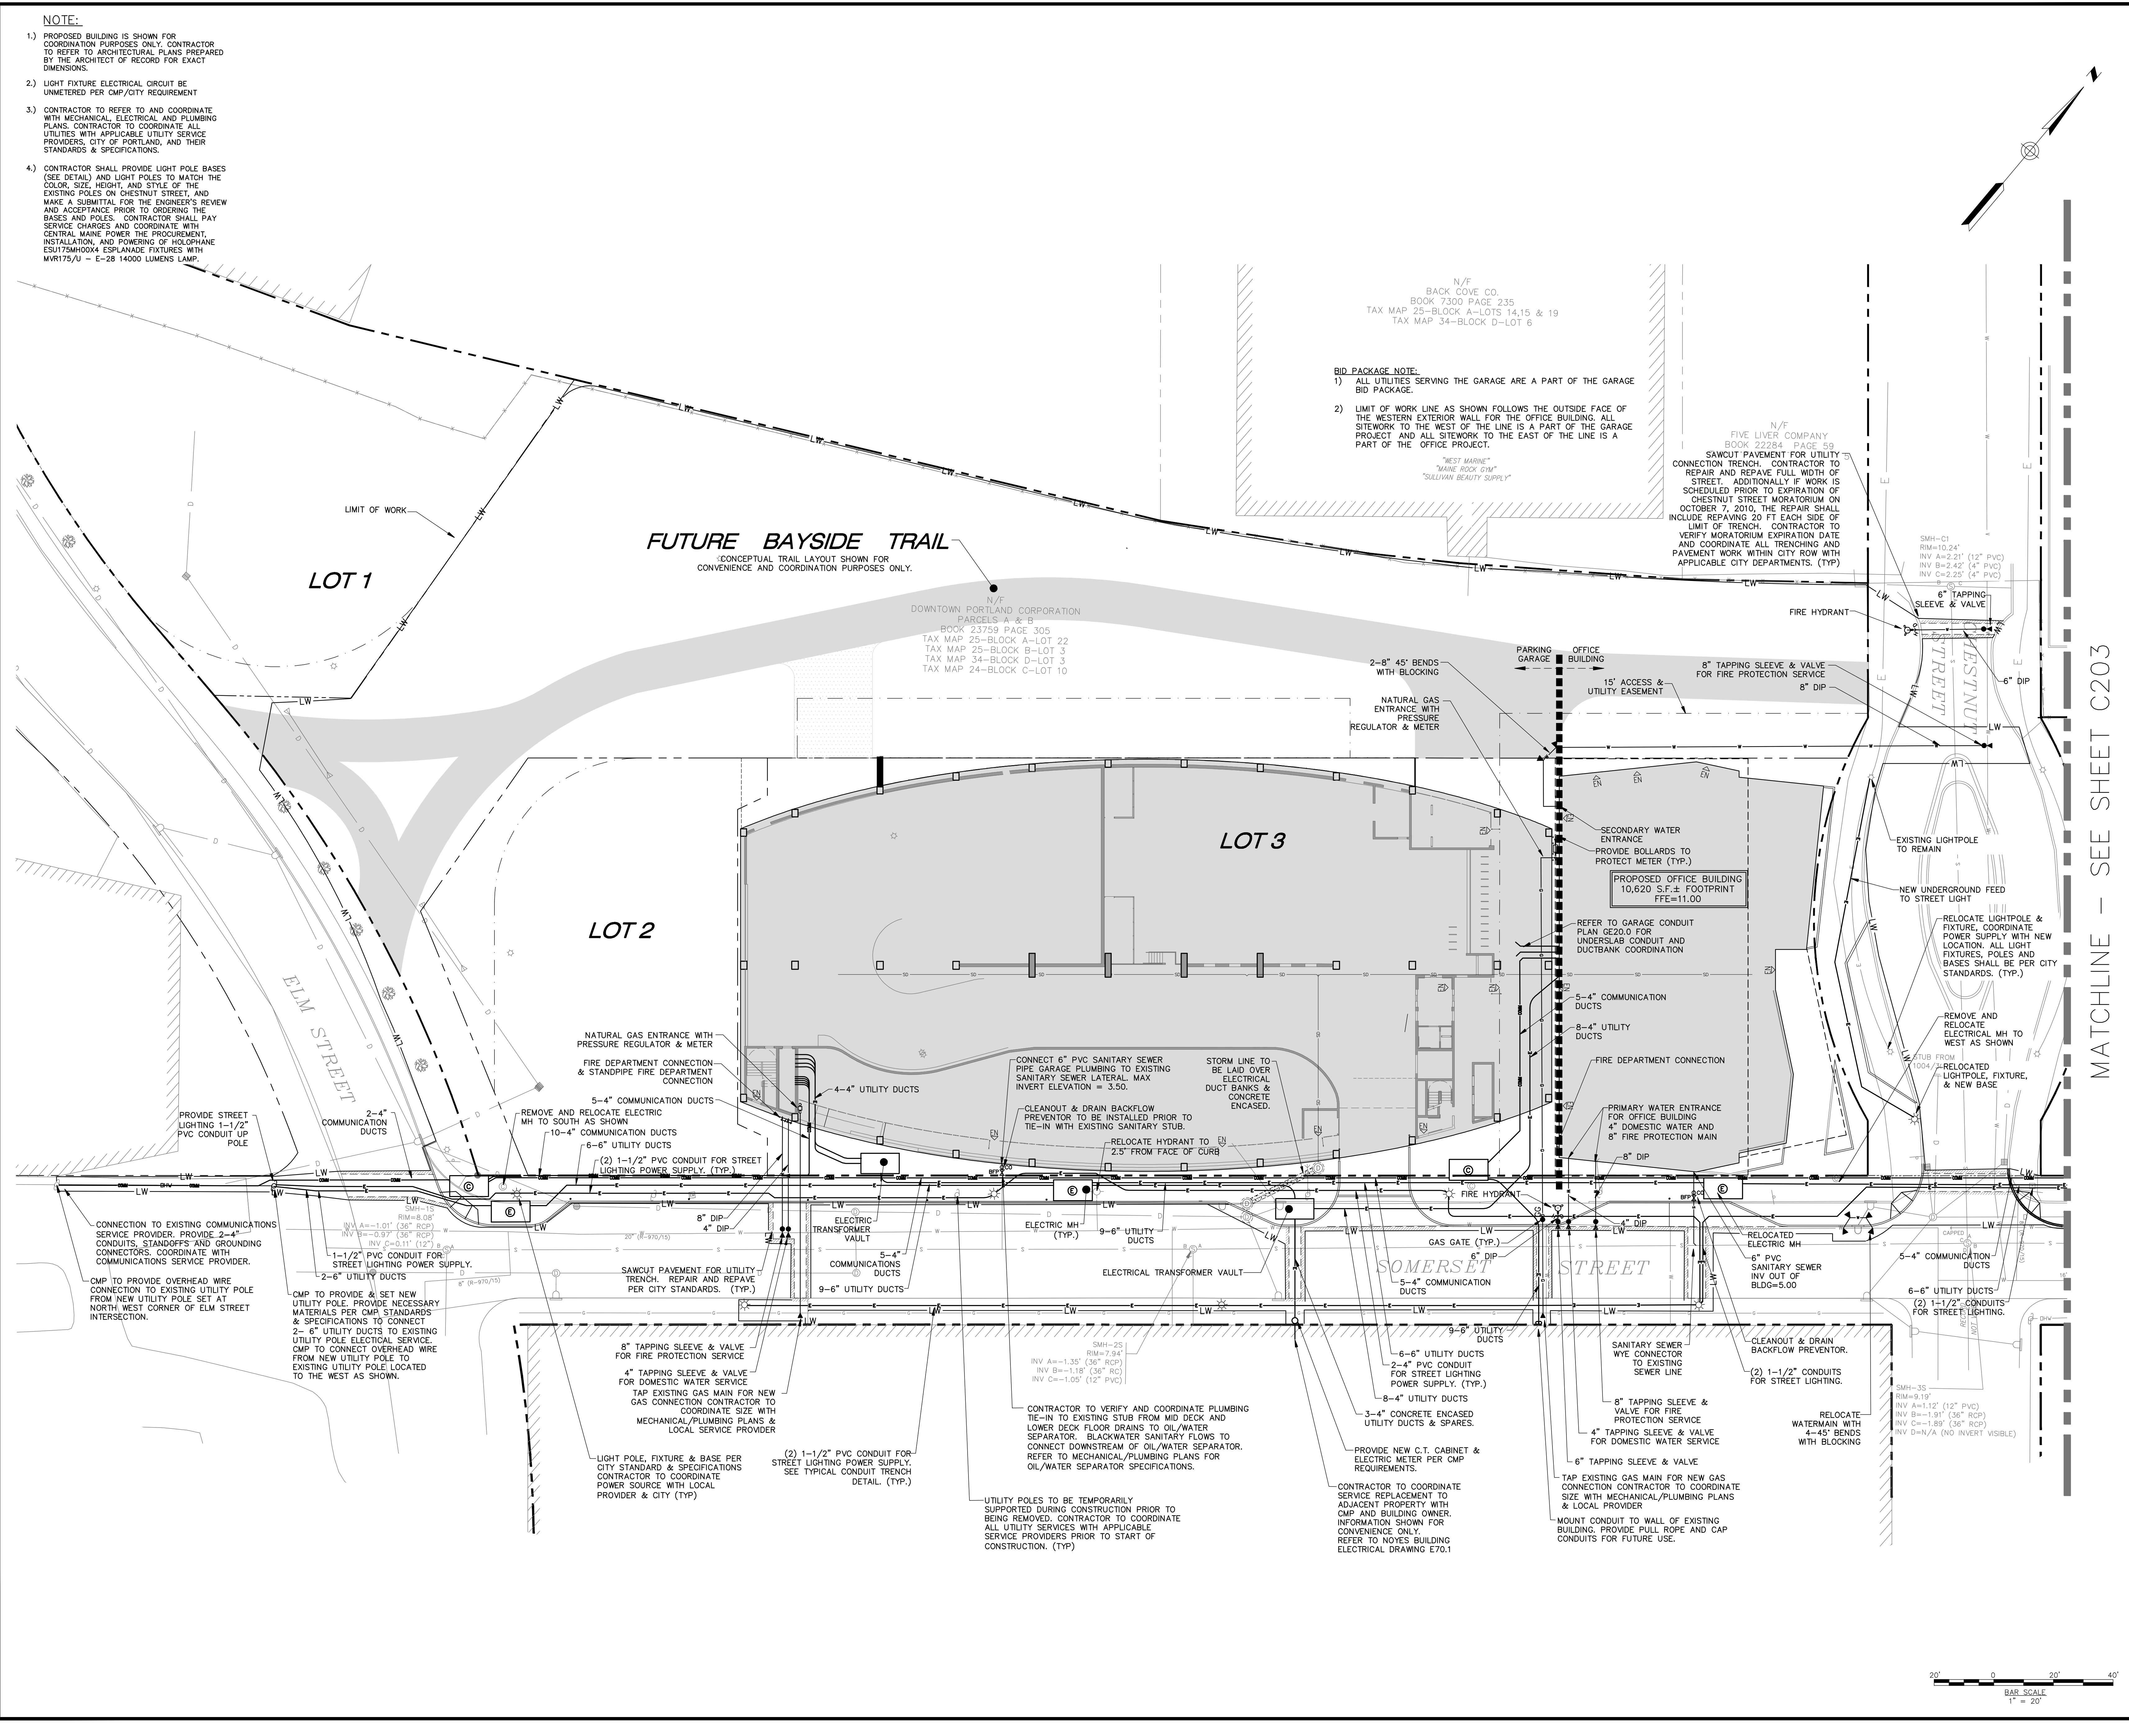

MATCHLINE - SEE SHEET C203

